



Scale: 1" = 100'

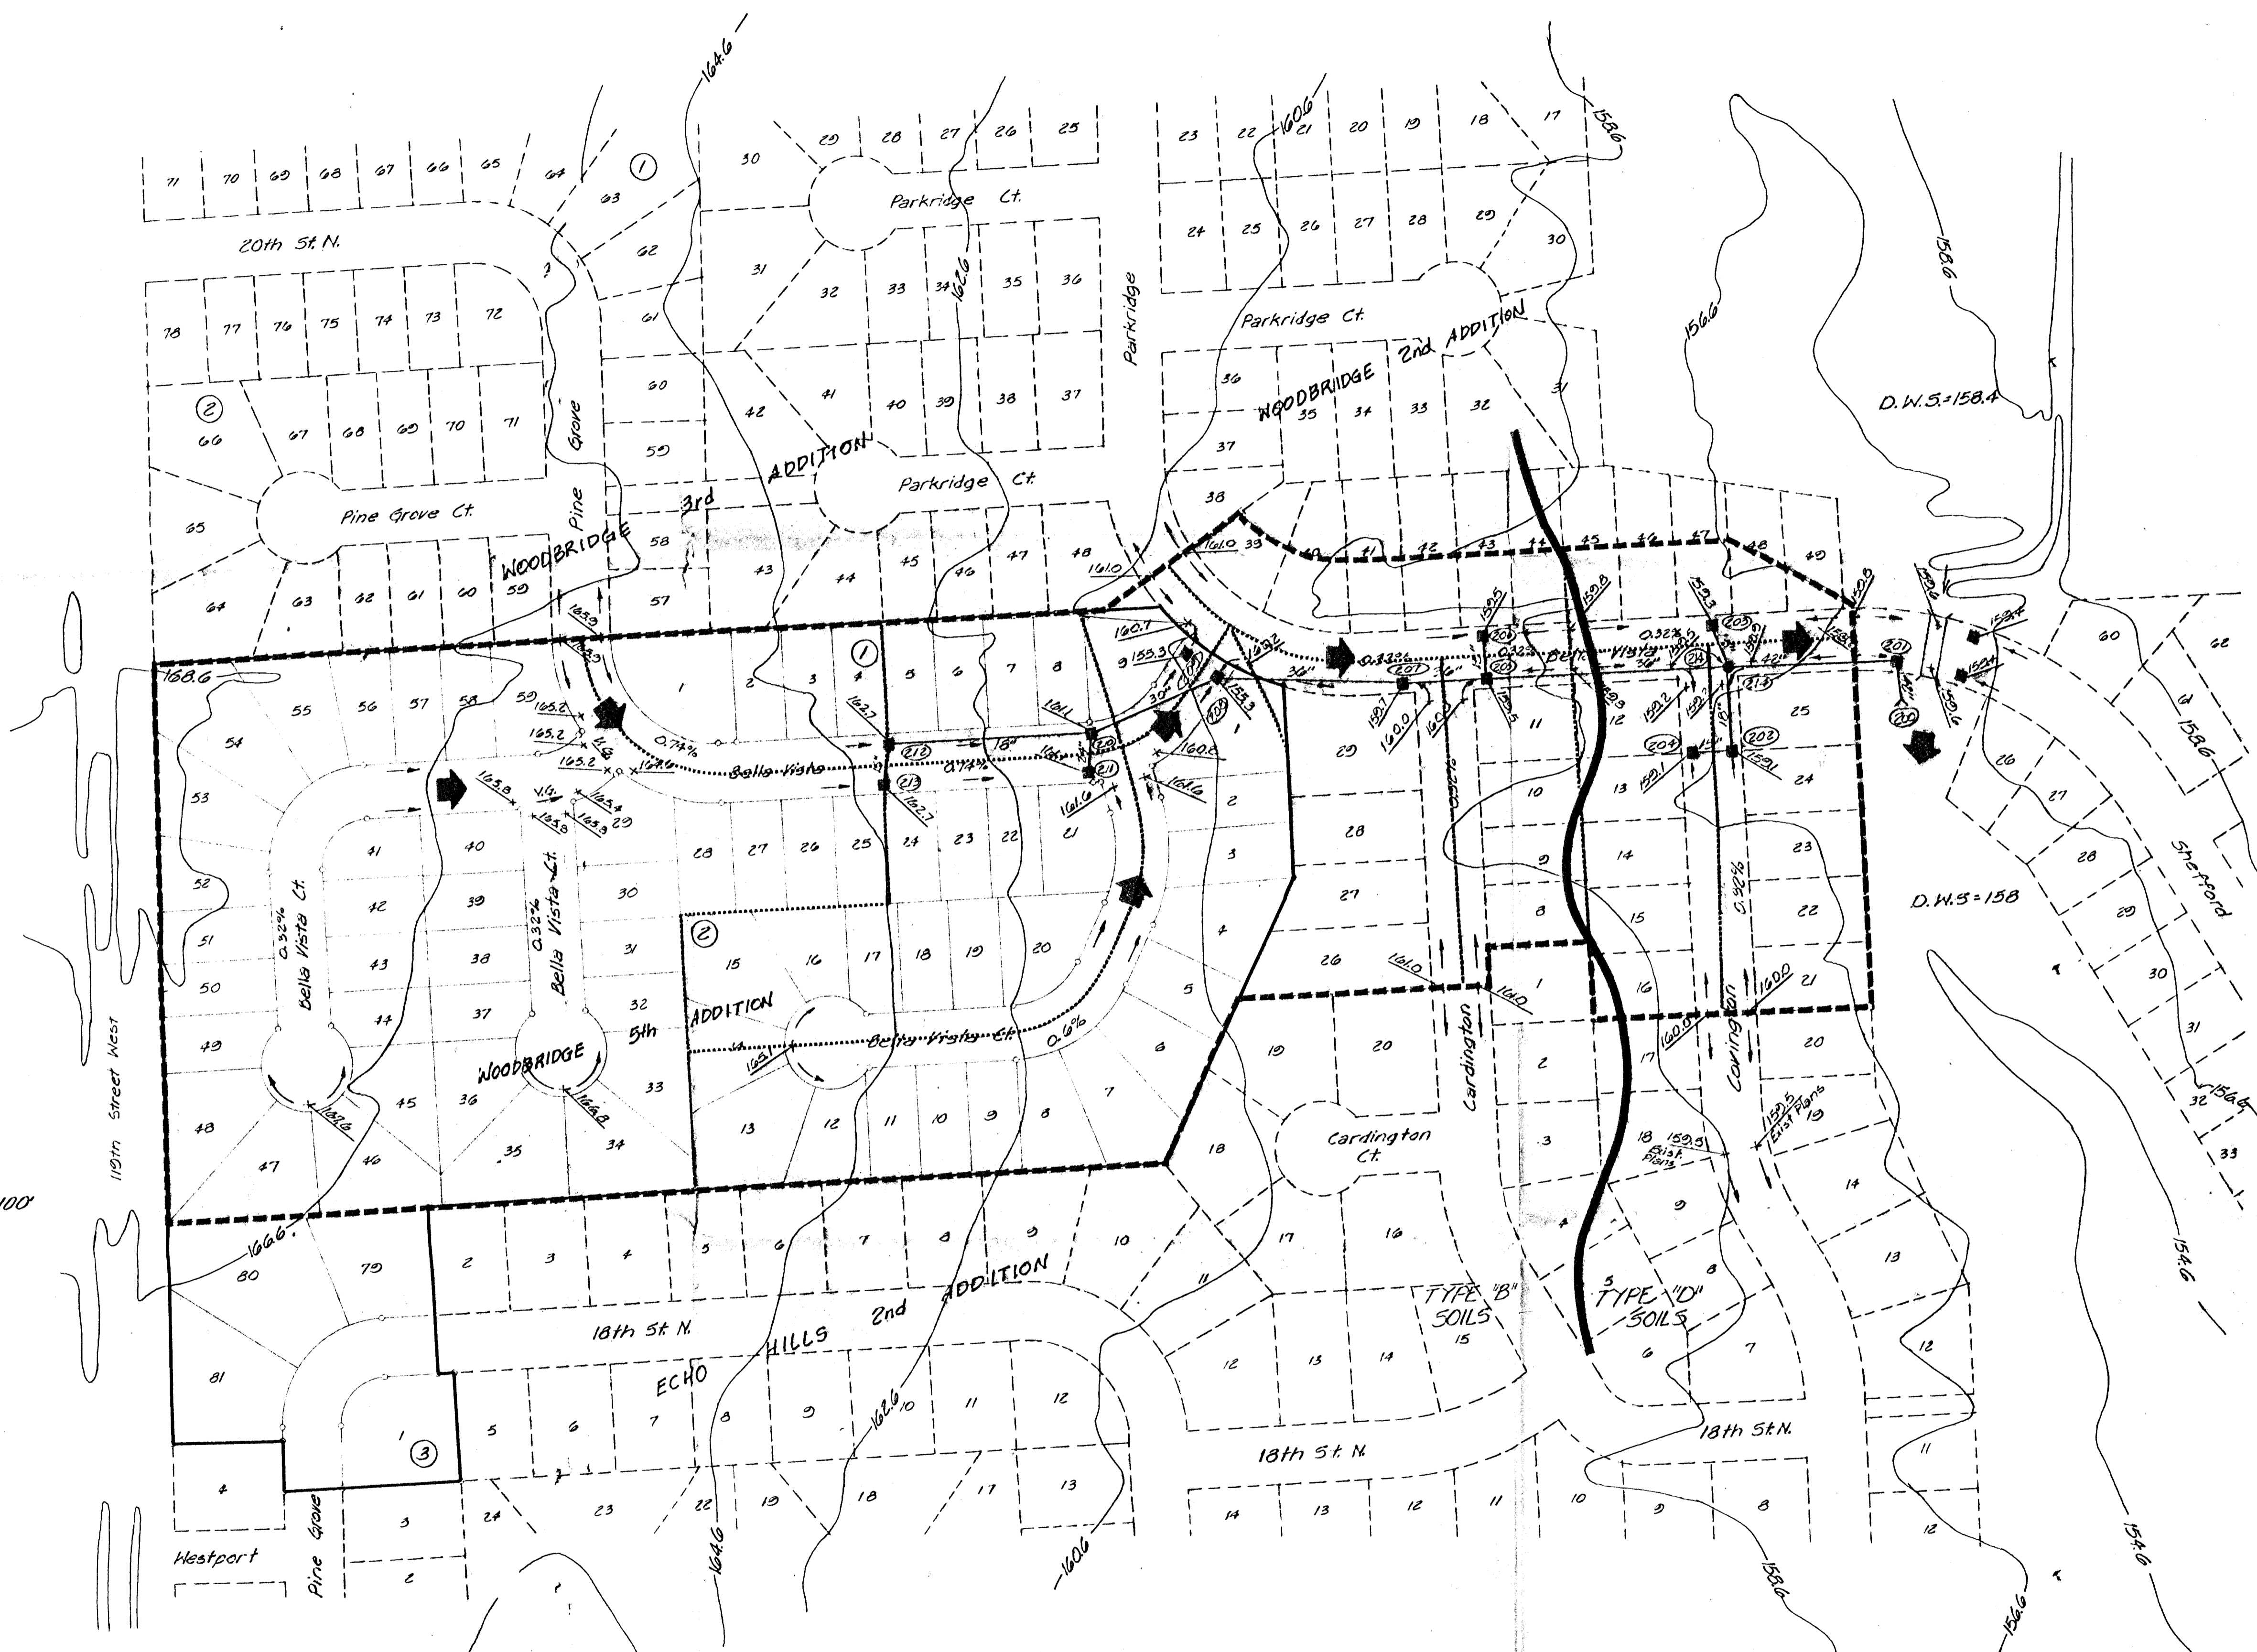

- LEGEND**
- (201) Node Nos.
 - Drainage Basin Boundary
 - - - Drainage Sub-Basin
 - Storm Water Sewer & Inlet
 - Storm Water Sewer & Manhole
 - Drainage Direction (2yr. storm)
 - Drainage Direction (100yr. storm)
 - ▲ Top curb elev.

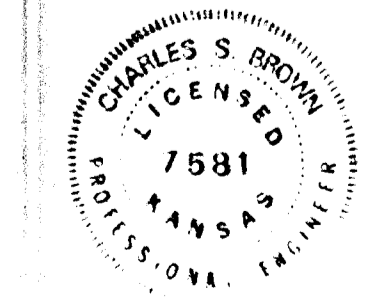

Woodbridge 5th Add
DRAINAGE PLAN

PROFESSIONAL ENGINEERING CONSULTANTS, P.A.
ENGINEERS
WICHITA, KANSAS

Designed by <i>CSB</i>	Job No. 87156
Drawn by <i>BS</i>	Date <i>May 3, 1987</i>

Sht. / of /