


OWNER: KANSAS GAS AND ELECTRIC COMPANY
c/o JIM HOPKINS
P.O. BOX 202
WICHITA, KANSAS 67201

ENGINEER: PROFESSIONAL ENGINEERING CONSULTANTS, P.A.
303 SOUTH TOPEKA
WICHITA, KANSAS 67202

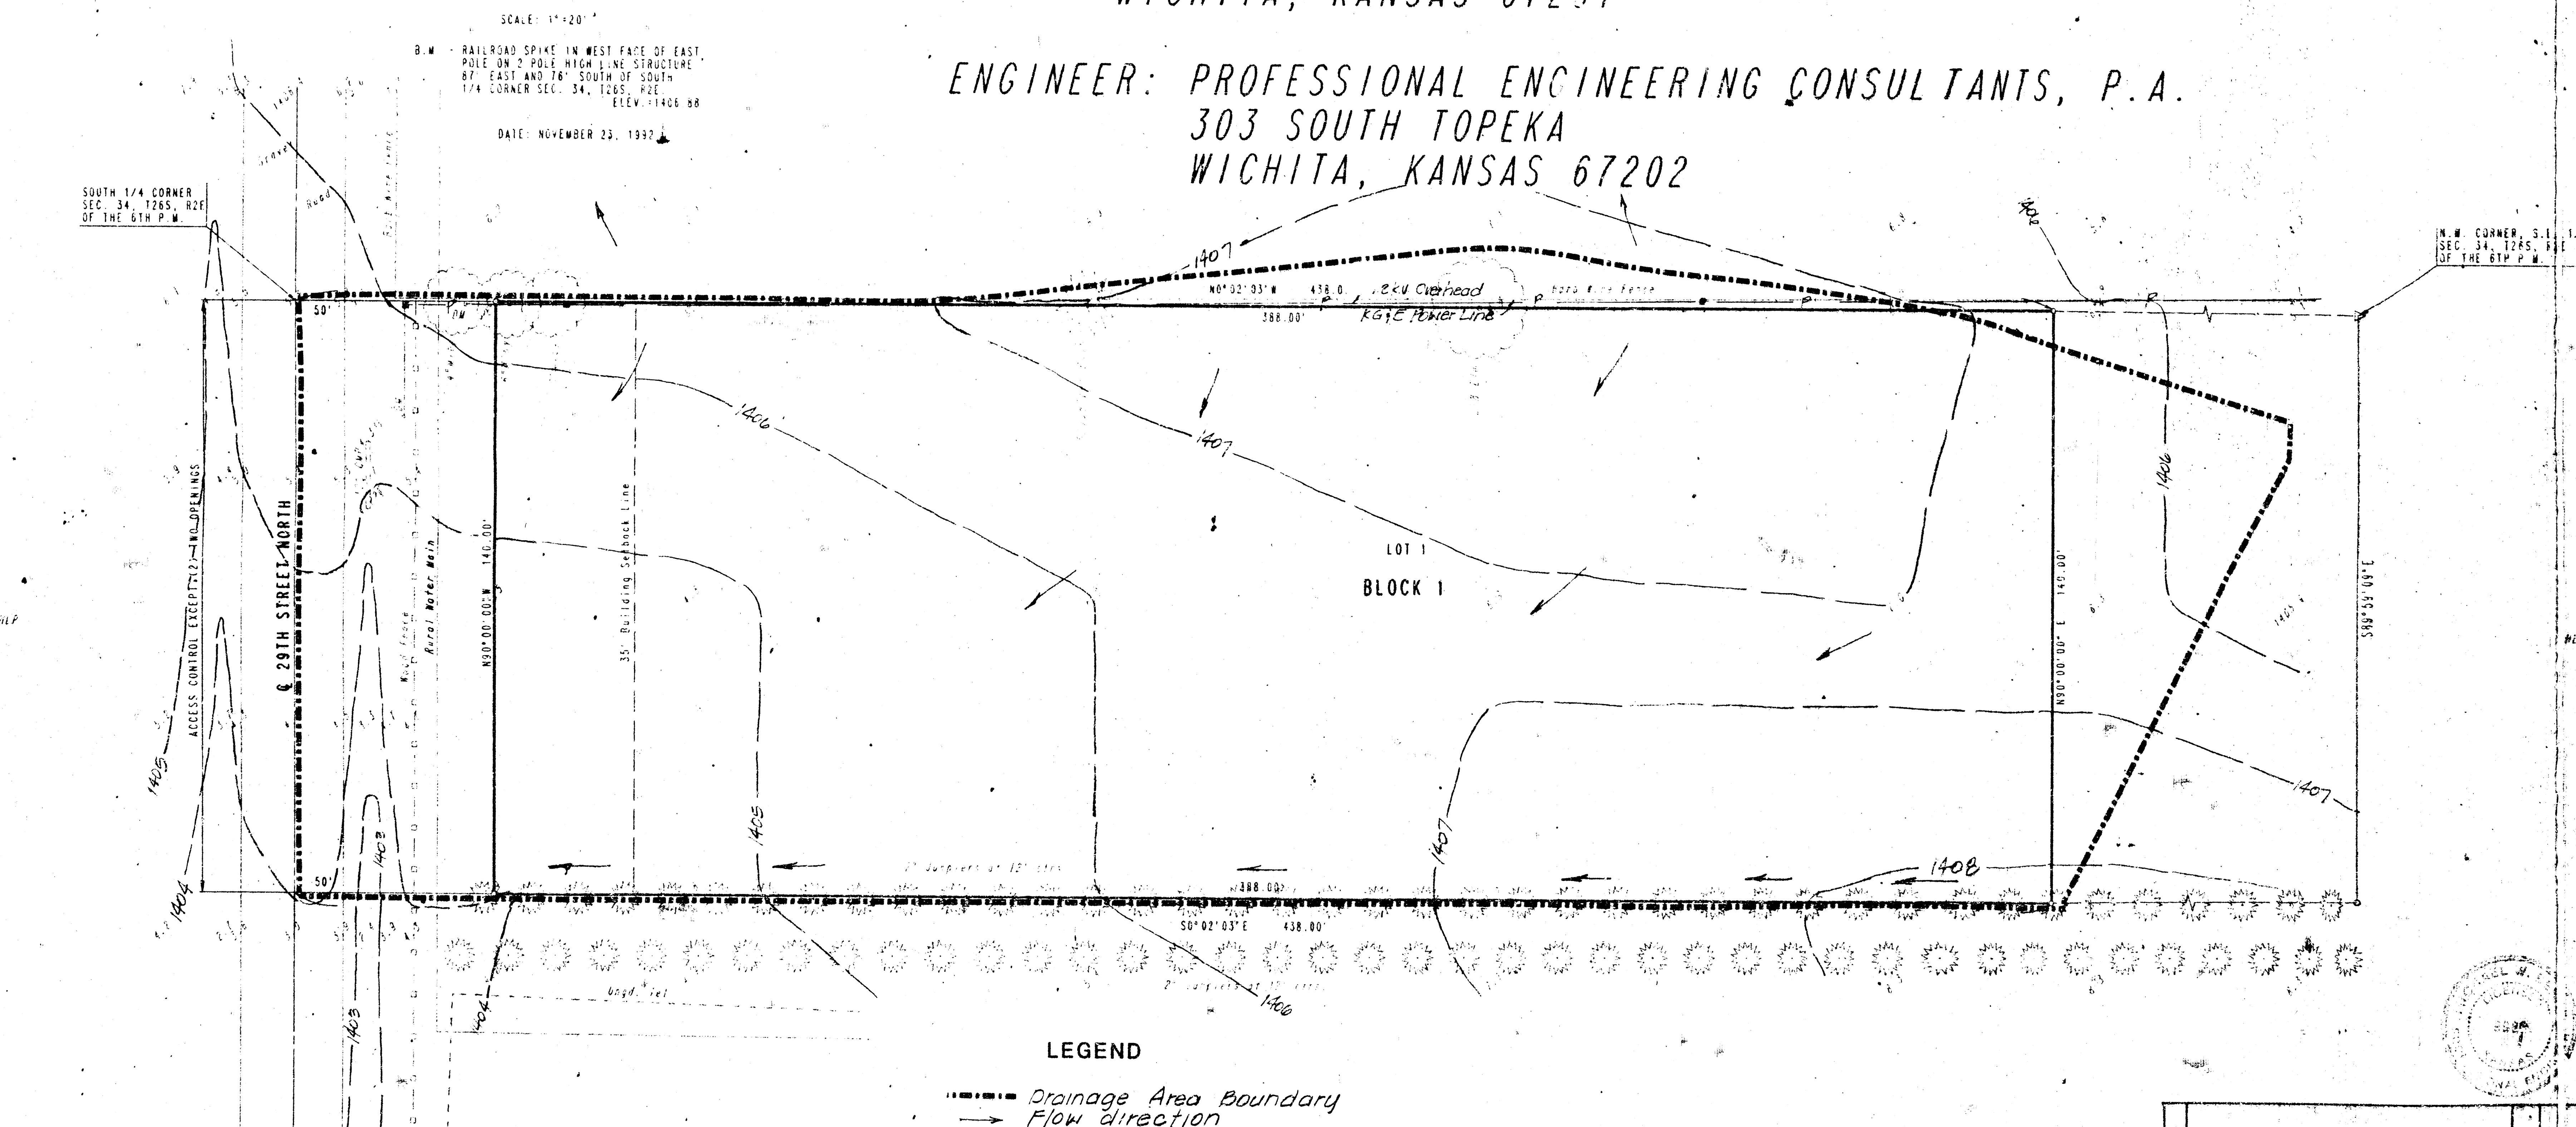

Note: Provide Two 24" dia. C.M.P. or Two 2.5 s.f. M.A.C entrance Pipes at each entrance.

No.	Revision	Sy
DRAINAGE PLAN 29TH. ST SUBSTATION ADD SEDGWICK CO. KS.		
PROFESSIONAL ENGINEERING CONSULTANTS, P.C. ENGINEERS WICHITA, KANSAS		
Designed by	John M. 923-dw-1	Sgt. 1
Drawn by	11-20-92	
Date	11-20-92	