


THE GATEWAY CENTER 2ND ADDITION

AN ADDITION TO WICHITA, SEDGWICK COUNTY, KANSAS

DRAINAGE PLAN

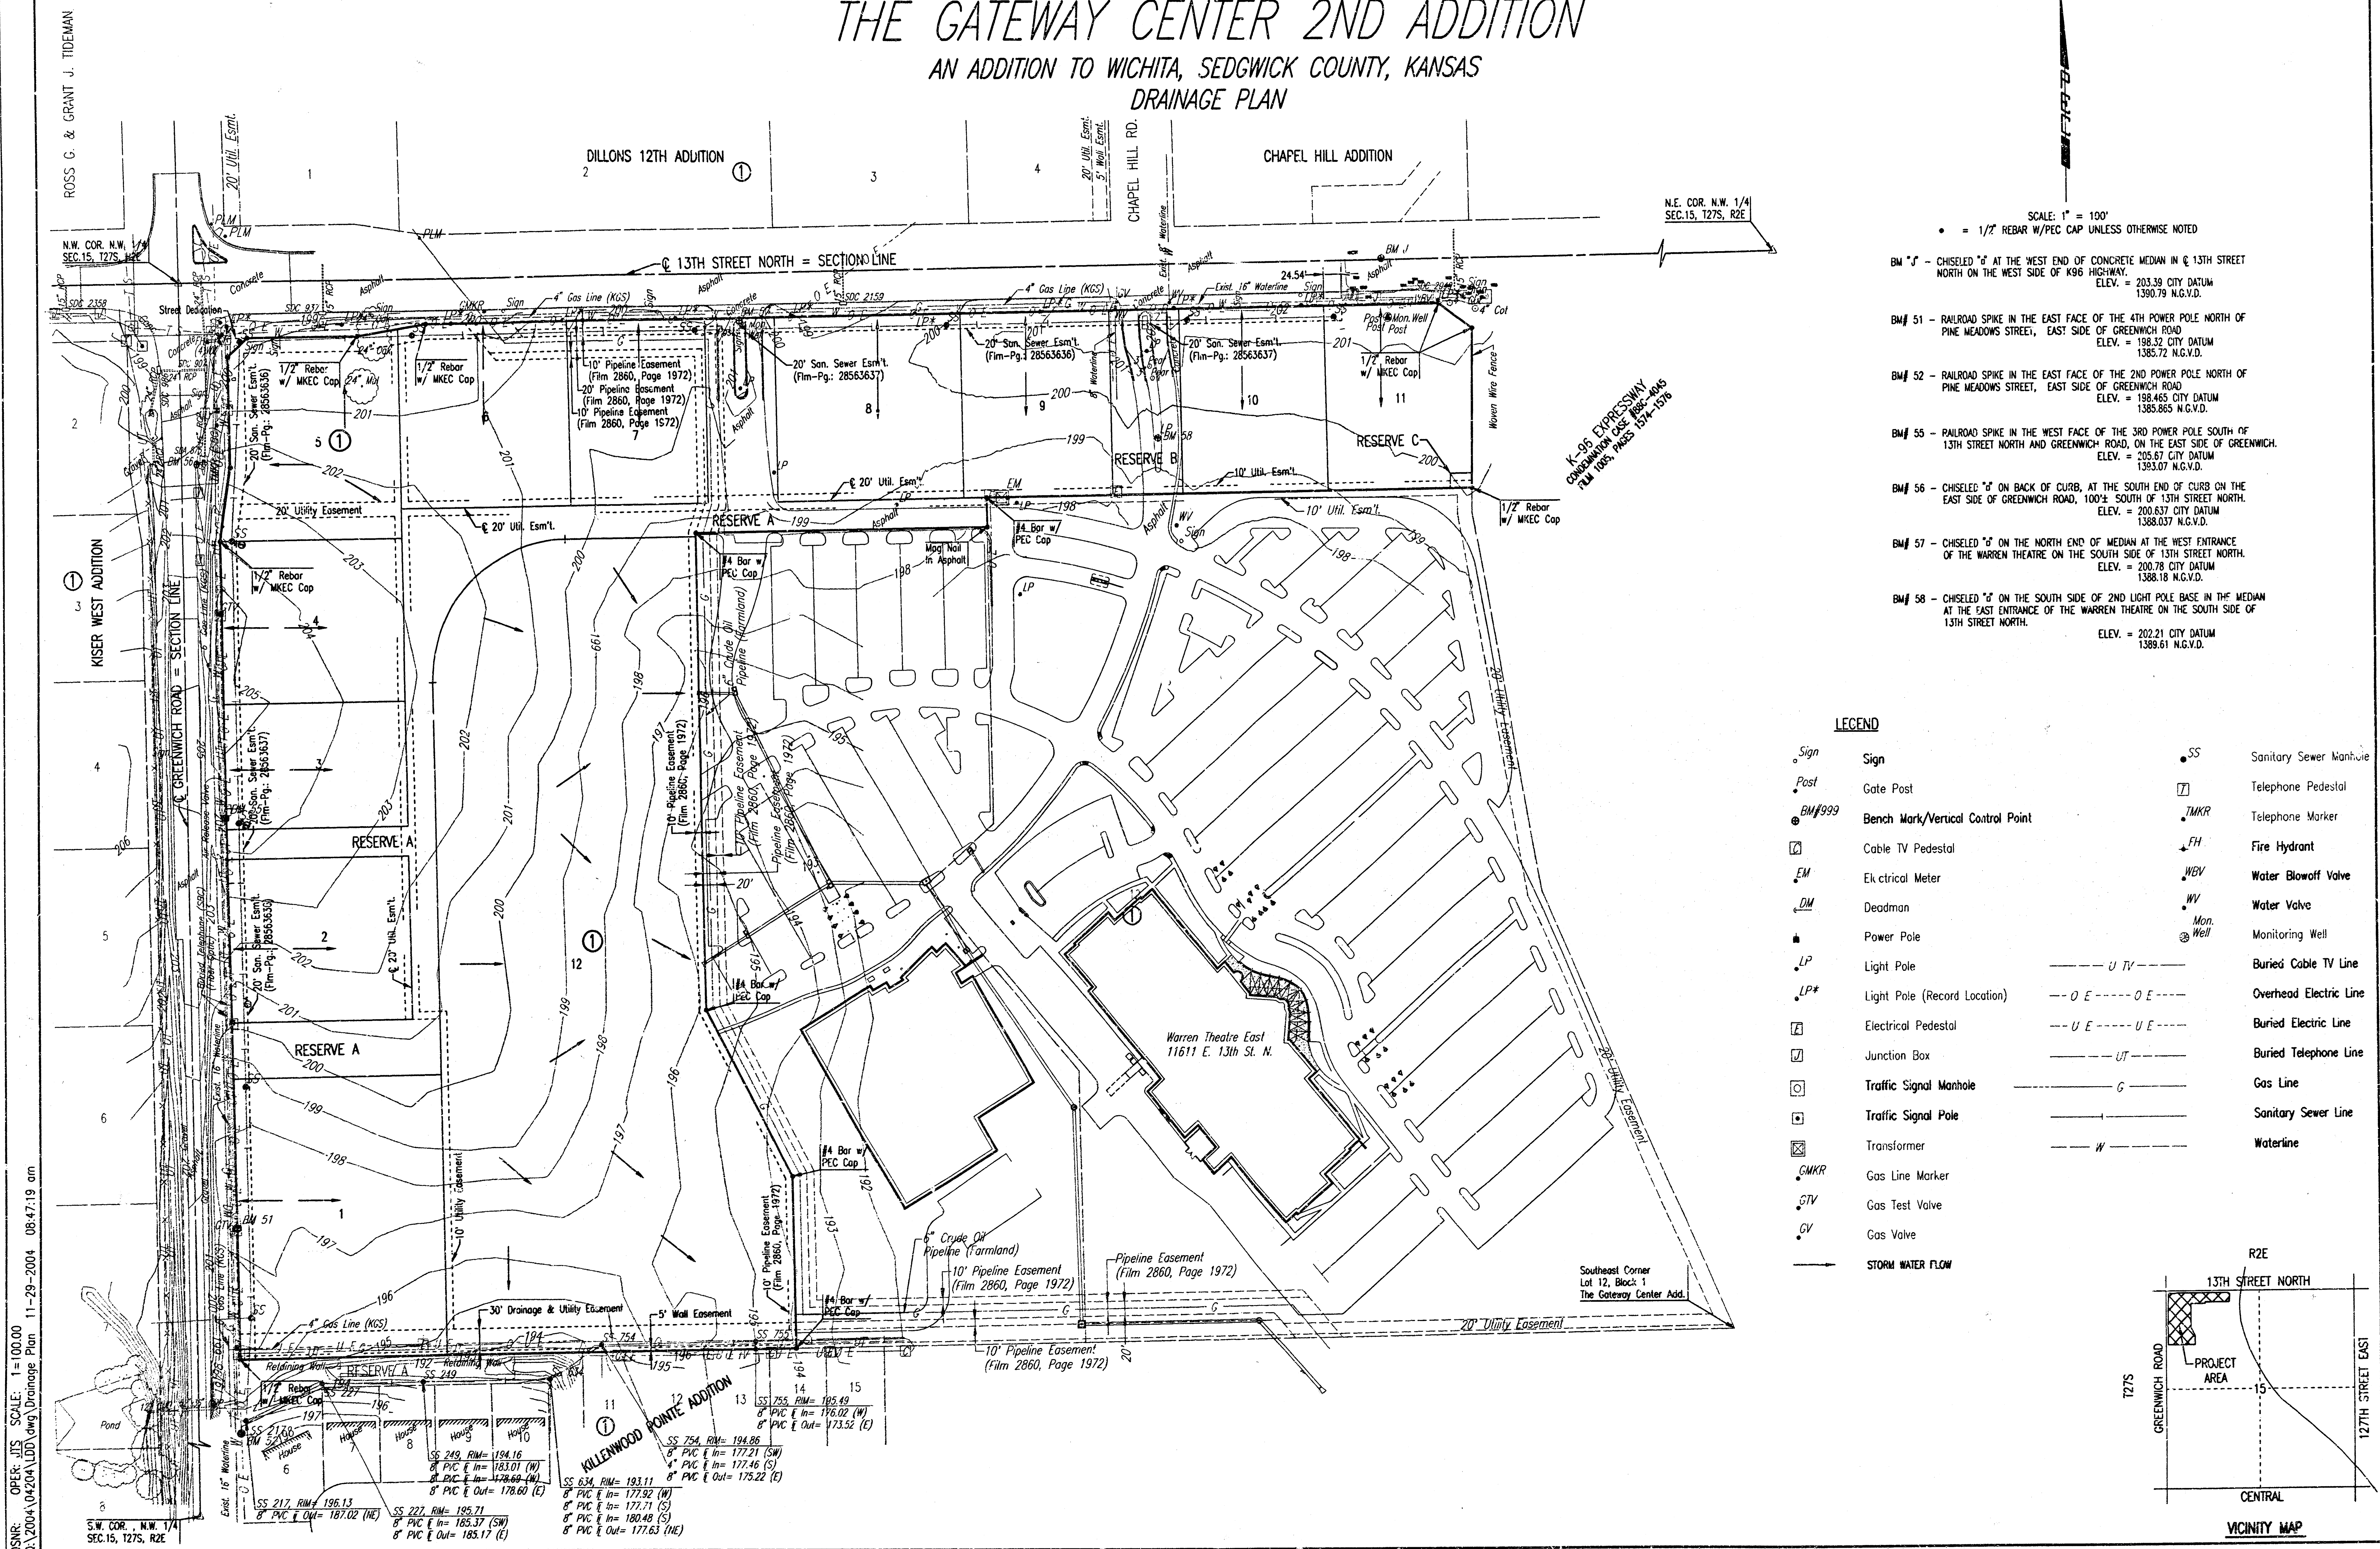

DSNR: OPER: JTS SCALE: 1"=100.00
 Q:\2004\04204\LD\dwg\Drainage Plan 11-29-2004 08:47:19 am

SCALE: 1" = 100'

• = 1/2" REBAR W/PEC CAP UNLESS OTHERWISE NOTED

- BM "J" - CHISELED "J" AT THE WEST END OF CONCRETE MEDIAN IN E 13TH STREET NORTH ON THE WEST SIDE OF K96 HIGHWAY.
ELEV. = 203.39 CITY DATUM
1390.79 N.G.V.D.
- BM# 51 - RAILROAD SPIKE IN THE EAST FACE OF THE 4TH POWER POLE NORTH OF PINE MEADOWS STREET, EAST SIDE OF GREENWICH ROAD
ELEV. = 198.32 CITY DATUM
1385.72 N.G.V.D.
- BM# 52 - RAILROAD SPIKE IN THE EAST FACE OF THE 2ND POWER POLE NORTH OF PINE MEADOWS STREET, EAST SIDE OF GREENWICH ROAD
ELEV. = 198.465 CITY DATUM
1385.865 N.G.V.D.
- BM# 55 - RAILROAD SPIKE IN THE WEST FACE OF THE 3RD POWER POLE SOUTH OF 13TH STREET NORTH AND GREENWICH ROAD, ON THE EAST SIDE OF GREENWICH.
ELEV. = 205.67 CITY DATUM
1389.07 N.G.V.D.
- BM# 56 - CHISELED "J" ON BACK OF CURB, AT THE SOUTH END OF CURB ON THE EAST SIDE OF GREENWICH ROAD, 100'± SOUTH OF 13TH STREET NORTH.
ELEV. = 200.637 CITY DATUM
1388.037 N.G.V.D.
- BM# 57 - CHISELED "J" ON THE NORTH END OF MEDIAN AT THE WEST ENTRANCE OF THE WARREN THEATRE ON THE SOUTH SIDE OF 13TH STREET NORTH.
ELEV. = 200.78 CITY DATUM
1388.18 N.G.V.D.
- BM# 58 - CHISELED "J" ON THE SOUTH SIDE OF 2ND LIGHT POLE BASE IN THE MEDIAN AT THE EAST ENTRANCE OF THE WARREN THEATRE ON THE SOUTH SIDE OF 13TH STREET NORTH.
ELEV. = 202.21 CITY DATUM
1389.61 N.G.V.D.

LEGEND

- | | | | |
|-----------------------------------|-----------------------------------|-----------|------------------------|
| Sign | Sign | SS | Sanitary Sewer Manhole |
| Gate Post | Gate Post | TMKR | Telephone Pedestal |
| Bench Mark/Vertical Control Point | Bench Mark/Vertical Control Point | FM | Telephone Marker |
| Cable TV Pedestal | Cable TV Pedestal | FW | Fire Hydrant |
| Electrical Meter | Electrical Meter | WBV | Water Blowoff Valve |
| Deadman | Deadman | WV | Water Valve |
| Power Pole | Power Pole | Mon. Well | Monitoring Well |
| Light Pole | Light Pole | UTV | Buried Cable TV Line |
| Light Pole (Record Location) | Light Pole (Record Location) | OE | Overhead Electric Line |
| Electrical Pedestal | Electrical Pedestal | UE | Buried Electric Line |
| Junction Box | Junction Box | UT | Buried Telephone Line |
| Traffic Signal Manhole | Traffic Signal Manhole | G | Gas Line |
| Traffic Signal Pole | Traffic Signal Pole | SS | Sanitary Sewer Line |
| Transformer | Transformer | W | Waterline |
| Gas Line Marker | Gas Line Marker | | |
| Gas Test Valve | Gas Test Valve | | |
| Gas Valve | Gas Valve | | |
| STORM WATER FLOW | STORM WATER FLOW | | |

