

LETTER OF TRANSMITTAL

PROJECT: Kelloqq West Square
Drainage and Utility Plan
PROJECT NO: 94024 DATE: 5/27/94

MID-KANSAS ENGINEERING
CONSULTANTS, INC.
3500 N. Rock Road, #800
Wichita, KS 67226
316-636-5566
FAX: 316-636-4125

TO: Vicky Huang, P.E.
City Hall - 7th Floor
455 N. Main
Wichita, KS 67202-1638

We are sending you the following items: Attached
 Under separate cover
 Via _____

Prints Specifications Drawings
 Contract Petitions Other


COMMENTS:

Here is the revised Drainage and Utility Plan for the referenced plat for your review and comment. This revised plan indicates drainage onto public property, rather than private property. At this time we are not able to get the required Cross Lot Drainage Agreement. By designing the site to public streets and storm sewers this agreement should not be required. If you have any questions, please contact me.

For Your Approval As Requested
 For Your Use For Your Files
 Approved As Noted For Review and Comment

REMARKS:

Signed: Greg Allison
Greg Allison, P.E.

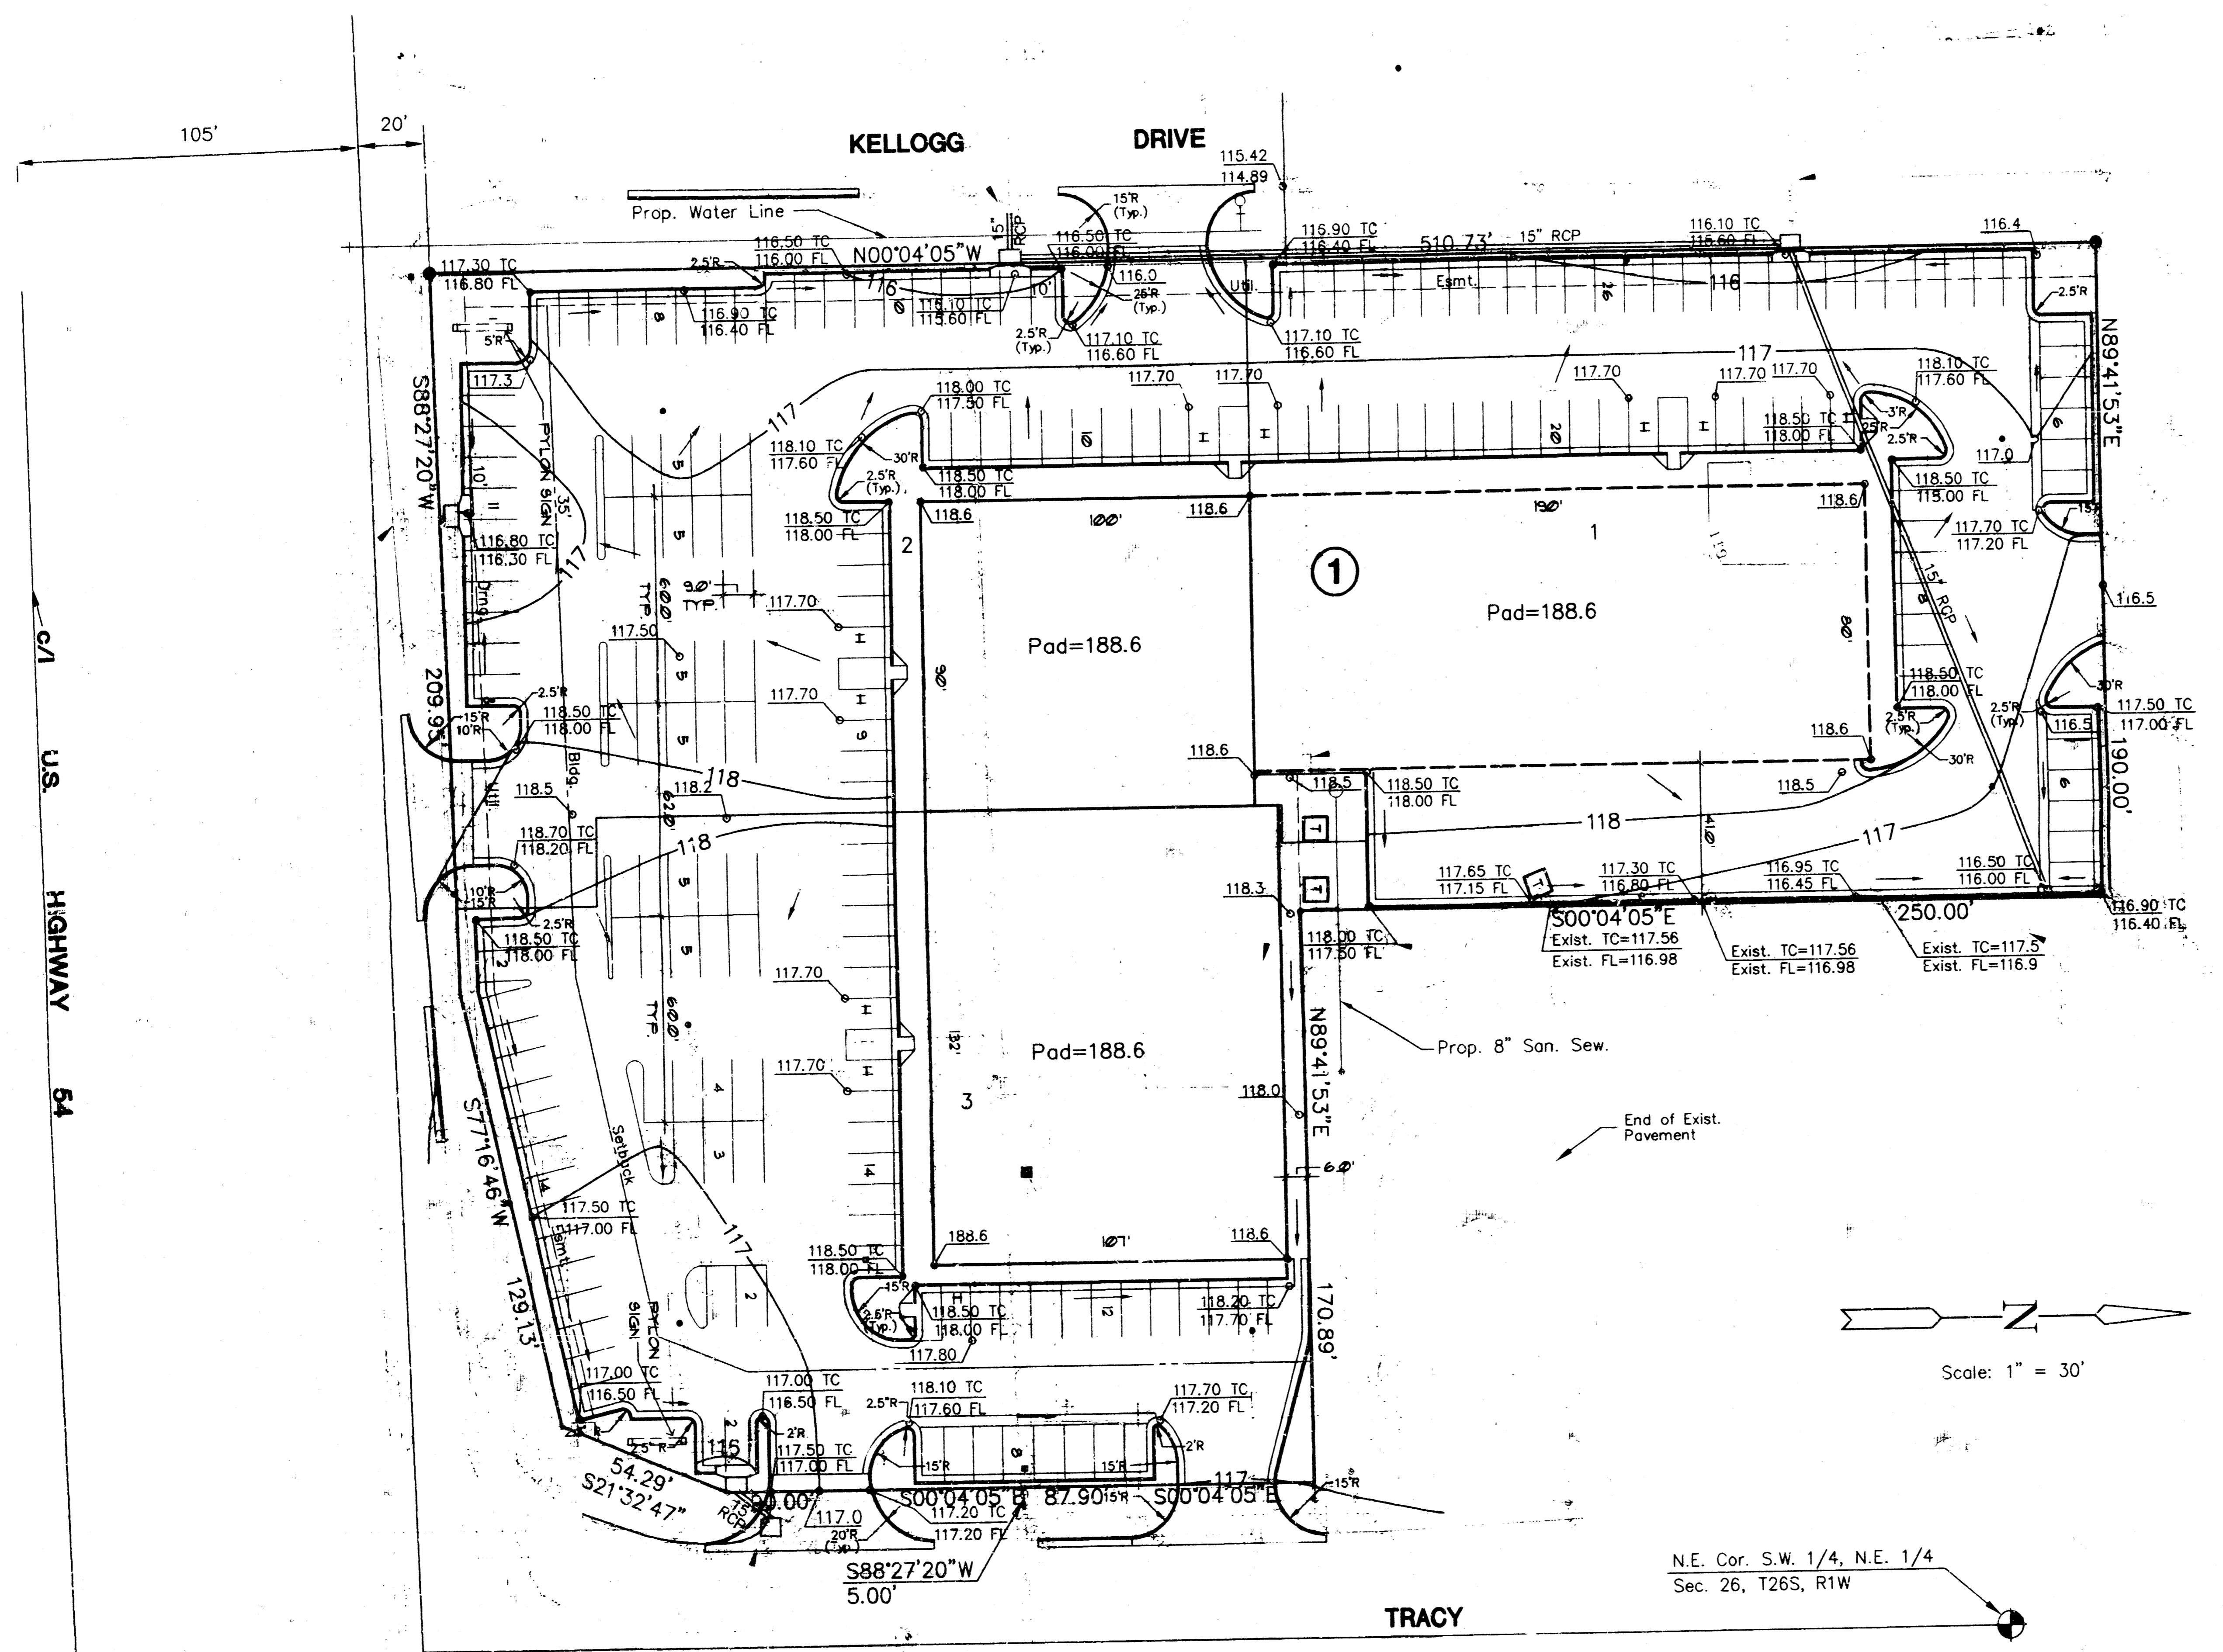

U.S. HIGHWAY 64


N.E. Cor. S.W. 1/4, N.E. 1/4
Sec. 26, T26S, R1W



KELLOGG WEST SQUARE
**DRAINAGE, GRADING,
AND UTILITY PLAN**

Design: GJA
Drawn by: WNJ
Checked by:
Date: MAY 1994
Job No.: 9423GRD

MID-KANSAS ENGINEERING CONSULTANTS INC.
3500 NORTH ROCK ROAD
BUILDING #800
WICHITA, KANSAS 67226 (316) 636-5566

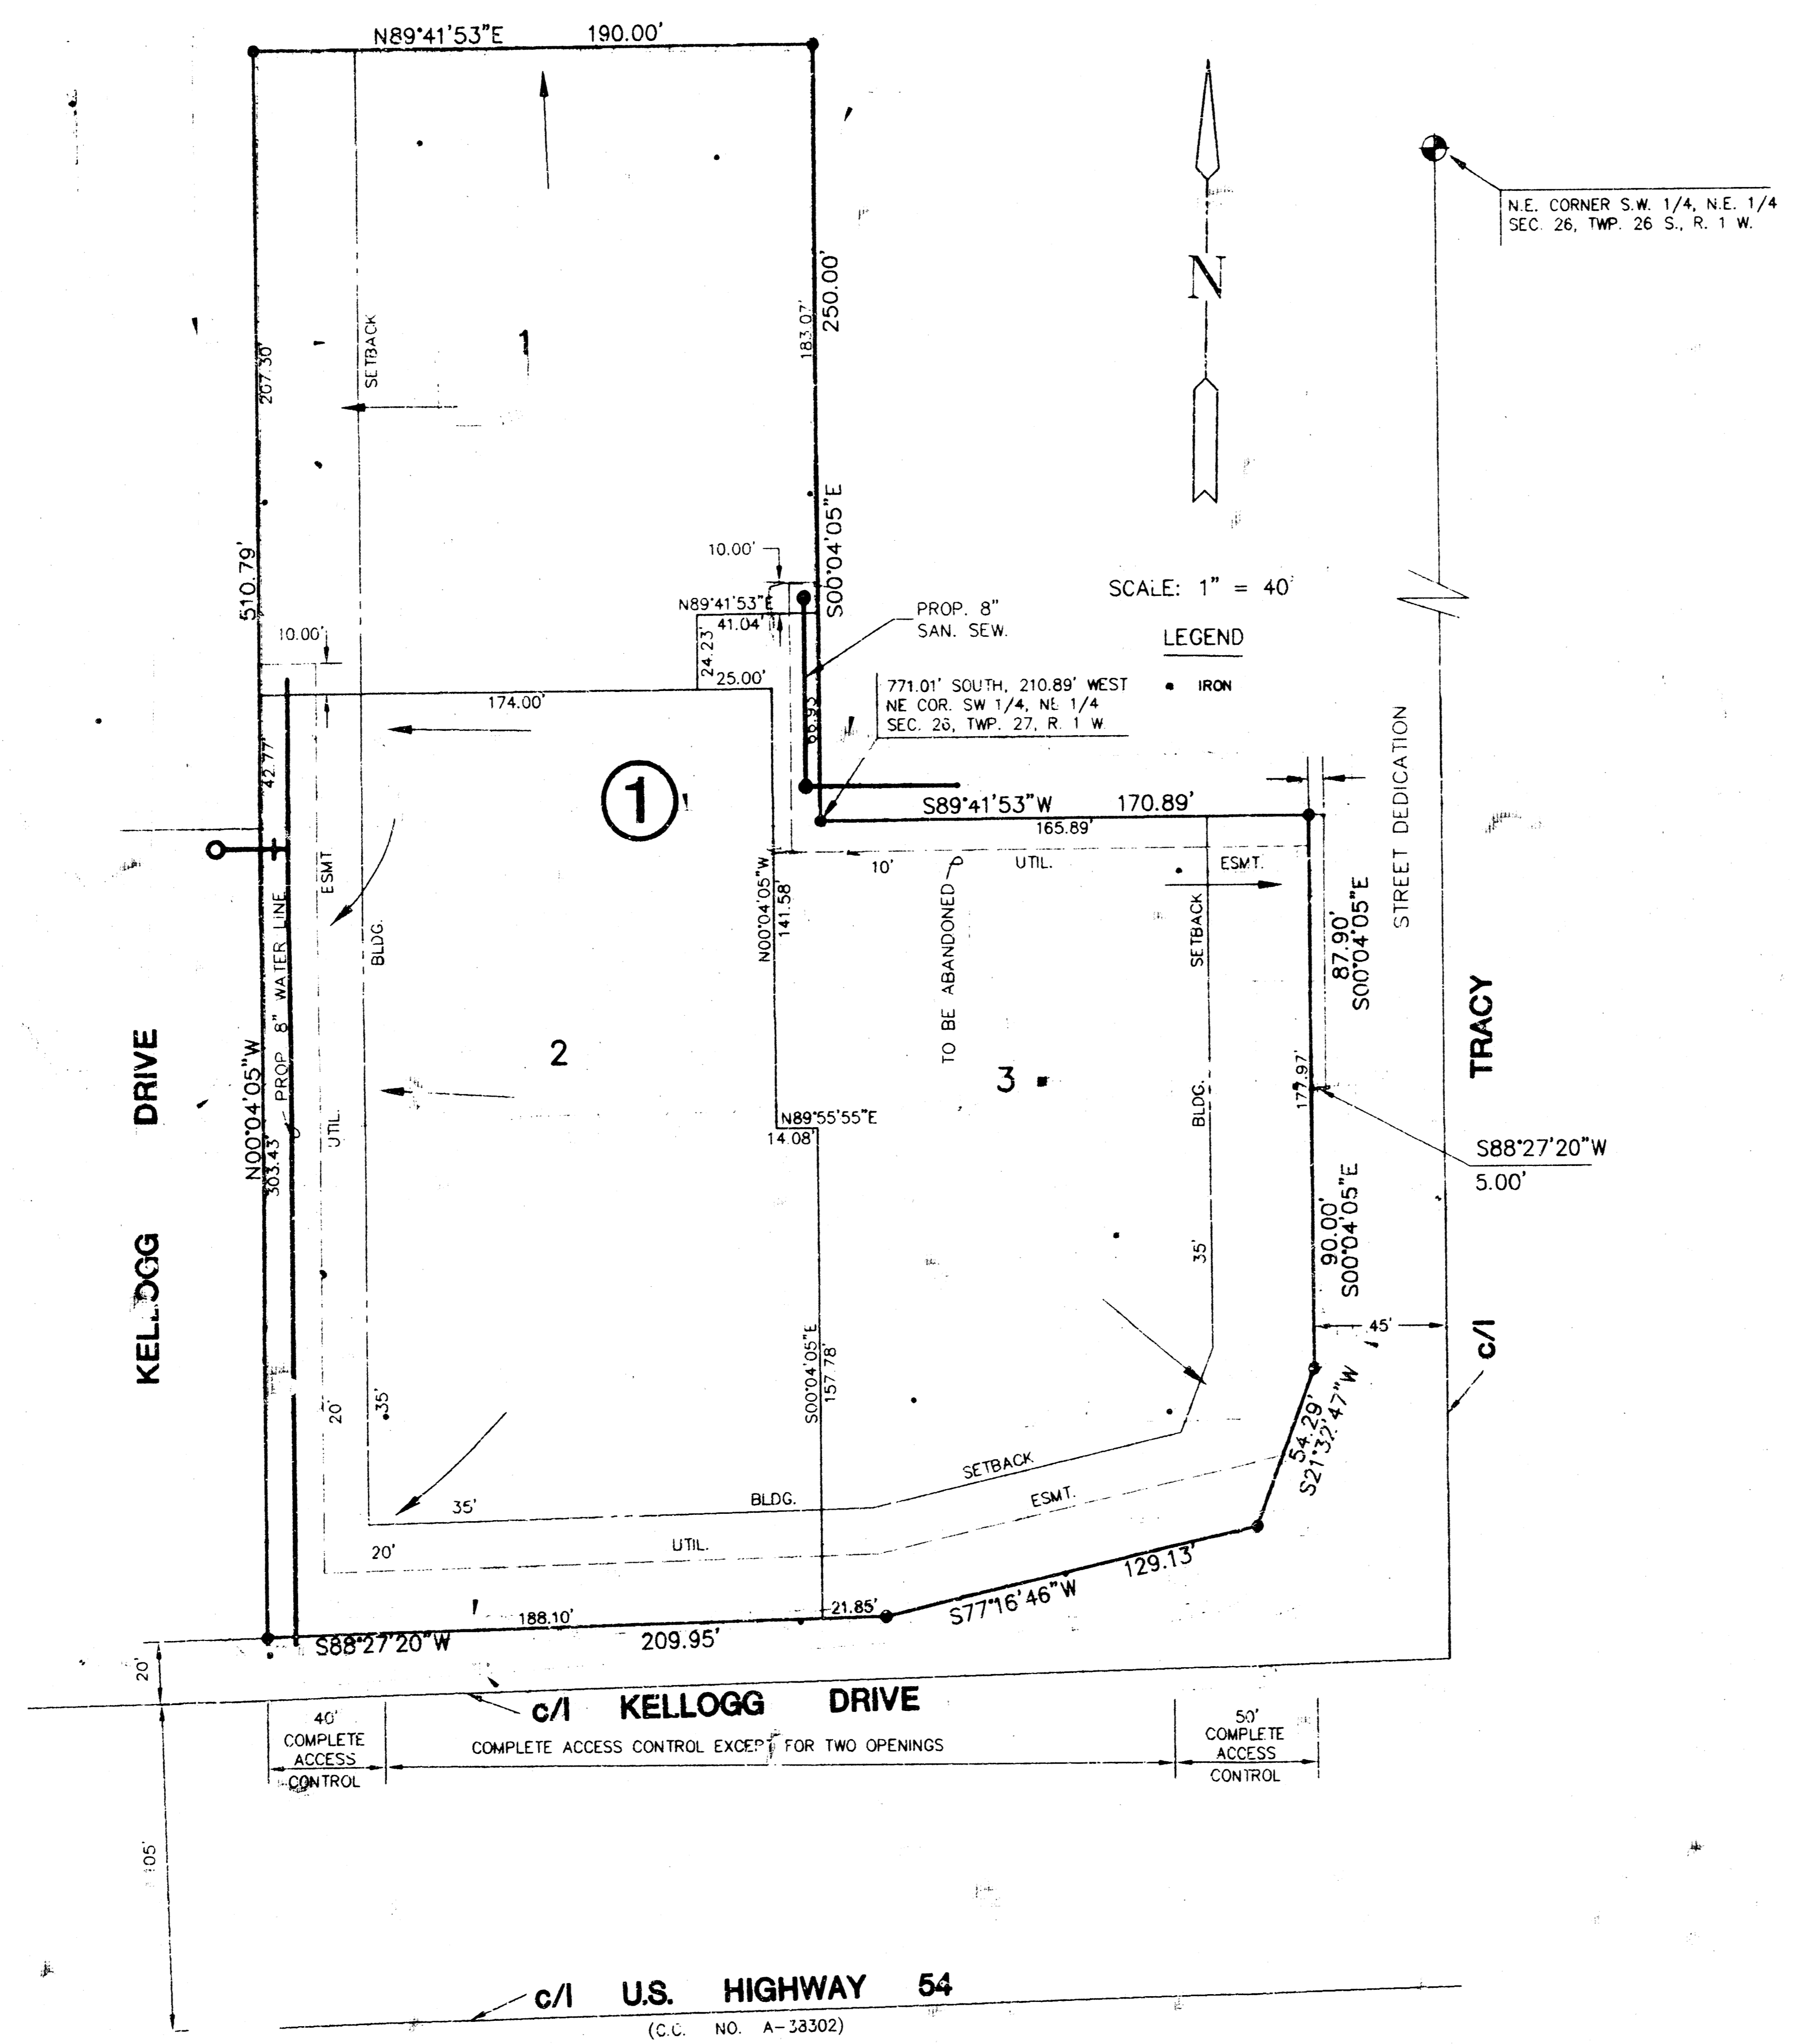

Requires off-site drainage agreement

	KELLOGG WEST SQUARE DRAINAGE AND UTILITY PLAN	Design Drawn by Checked by Date Job no.
	MID-KANSAS ENGINEERING CONSULTANTS INC. 3500 NORTH ROCK ROAD BUILDING #900 WICHITA, KANSAS 67226	Sheet of
	(316) 636-5566	