


STORM WATER SEWER NO. 145

Frank Soyeg
721-6027
7620 Suncrest
Sam Houf
7700 W Suncrest
722-3193

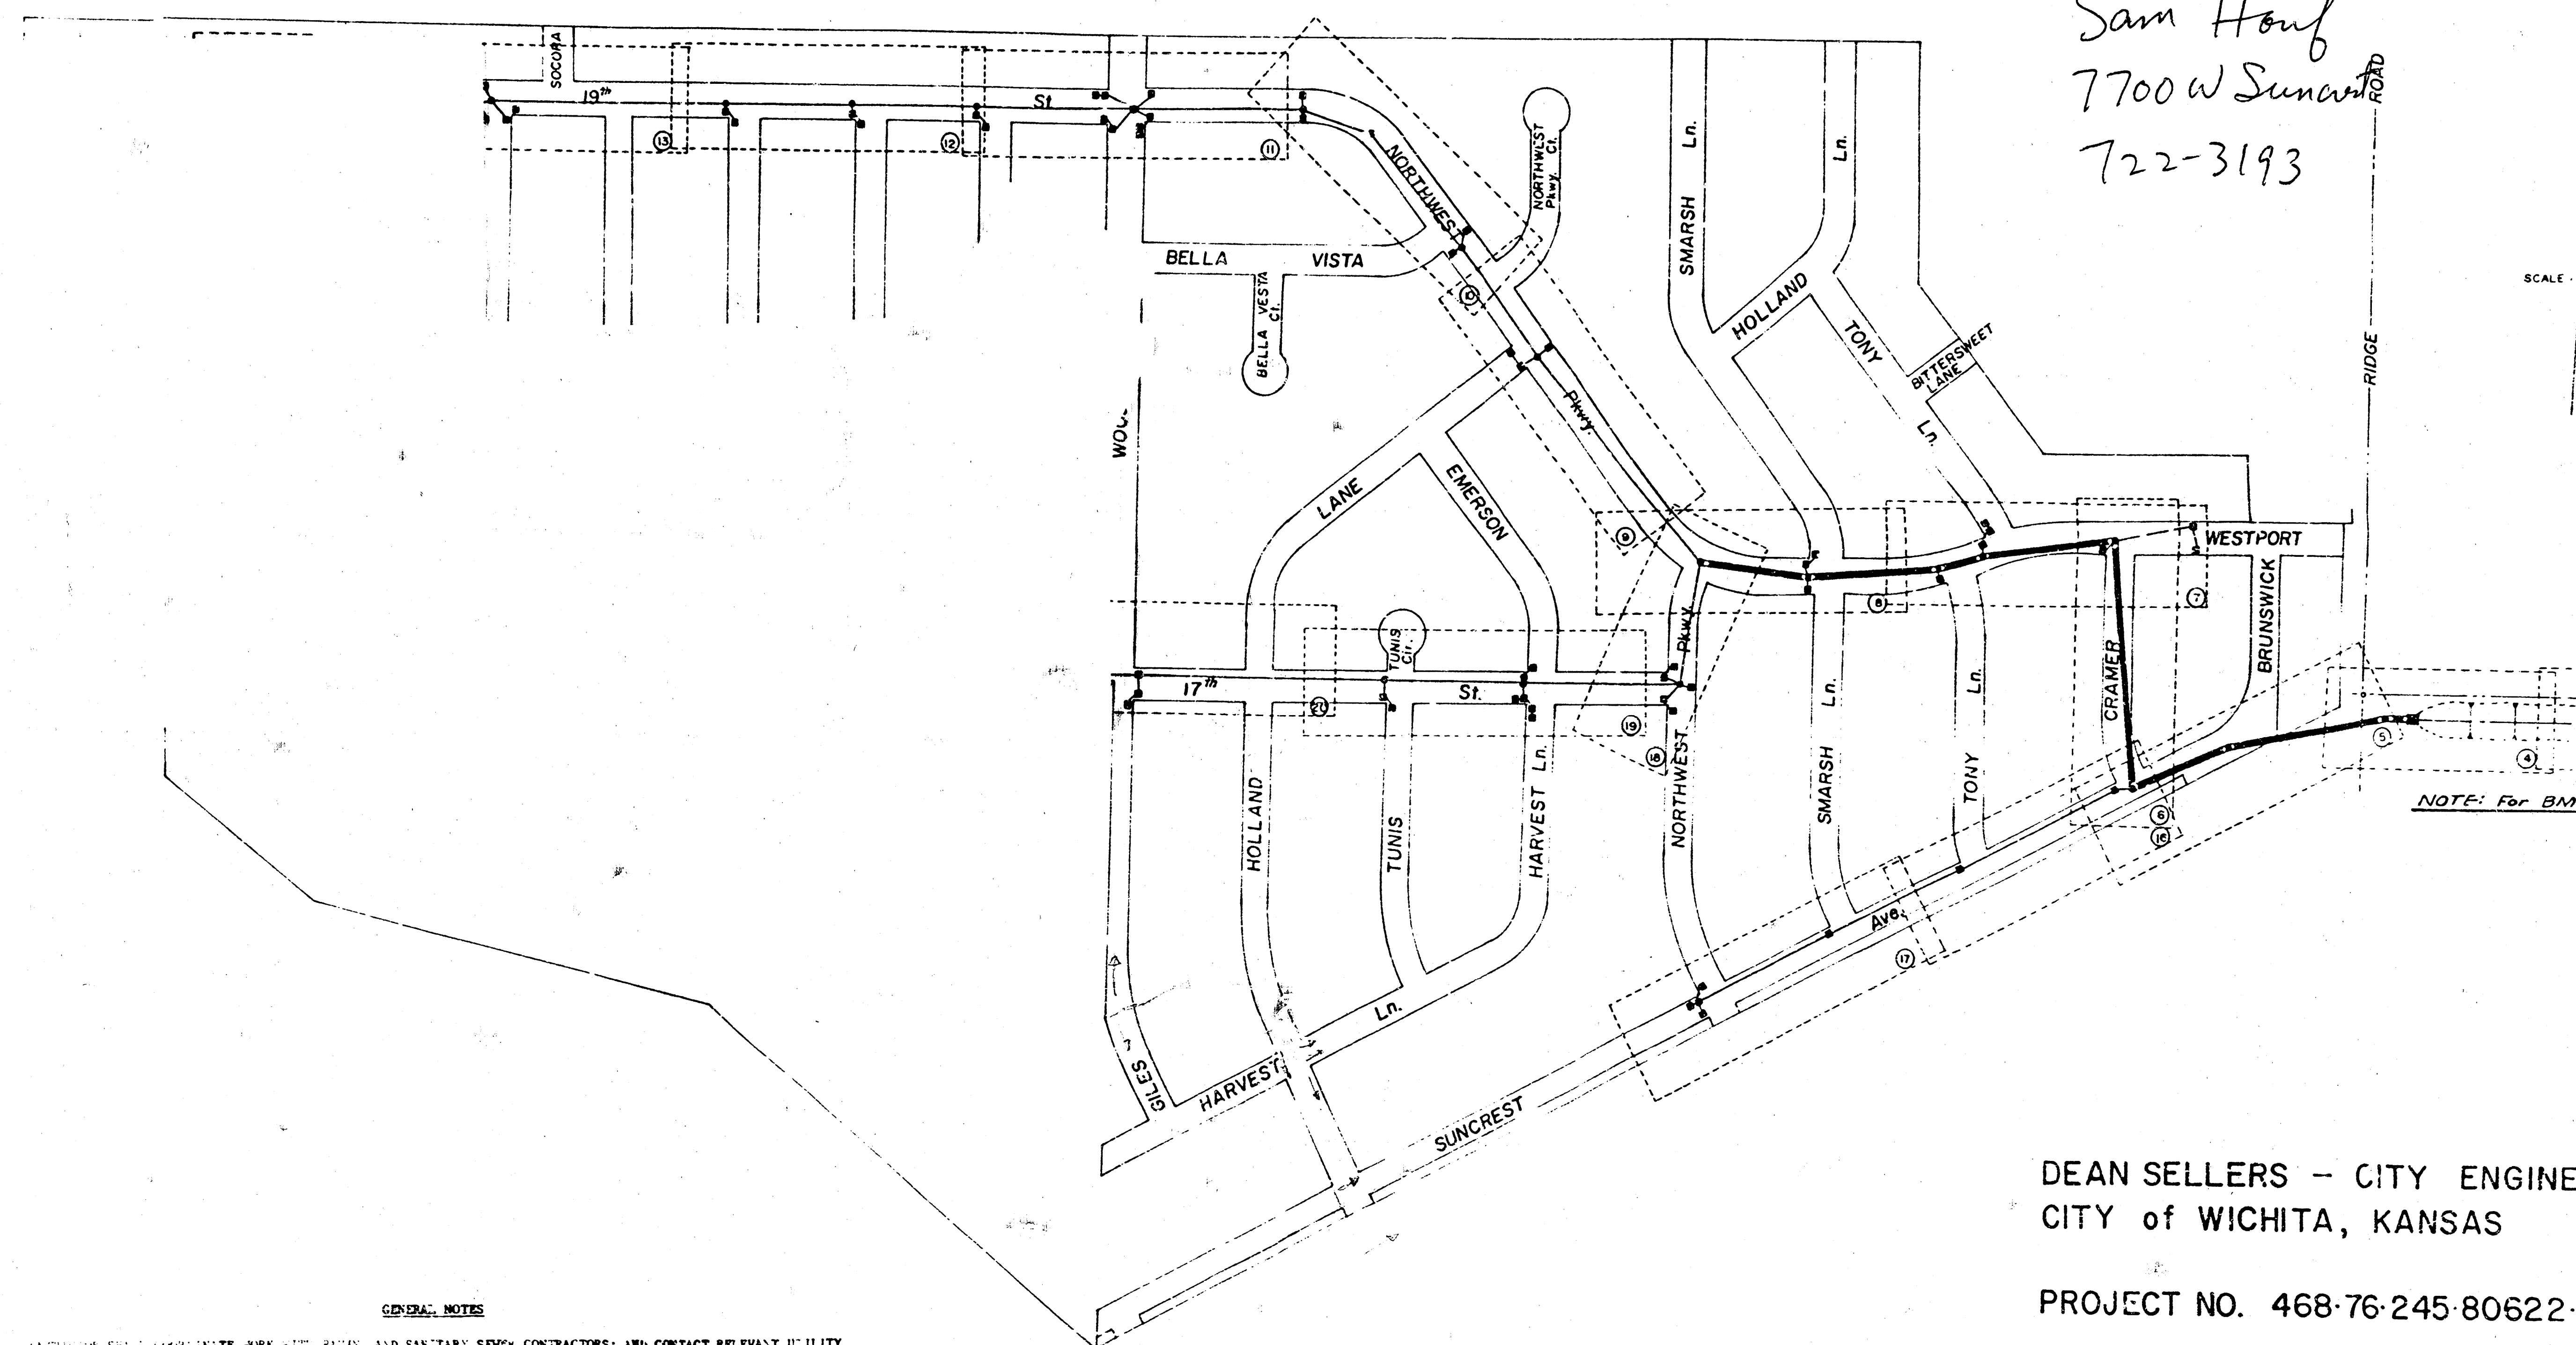

SCALE

NOTE: For BM's

GENERAL NOTES

1. CONTRACTOR SHALL COORDINATE WORK WITH PUBLIC AND SANITARY SEWER CONTRACTORS; AND CONTACT RELEVANT UTILITY COMPANIES AND OTHER AGENCIES INVOLVED WITH THIS PROJECT SITE DEVELOPMENTS.
2. FIELD ENGINEER SHALL TAKE CARE OF ALL TRUCKS AND TRAILERS IN THE PROJECT AREA PRIOR TO CONSTRUCTION. FIELD ENGINEER SHALL REPAIR ALL SUCH TRUCKS AND TRAILERS DISTURBED DURING CONSTRUCTION.

BENEFIT DISTRICT

DEAN SELLERS - CITY ENGINEER
CITY of WICHITA, KANSAS


PROJECT NO. 468-76-245-80622-0

DATE _____

DRAINAGE PLAN 6/22/92 SOCORA VILLAGE

SLAWSON INVESTMENT CORPORATION
c/o LARRY A. CHAMBERS
104 S. BROADWAY
SUITE 200
WICHITA, KANSAS 67202

ENGINEER:
PROFESSIONAL ENGINEERING CONSULTANTS, P.A.
303 S. TOPEKA
WICHITA, KANSAS 67202

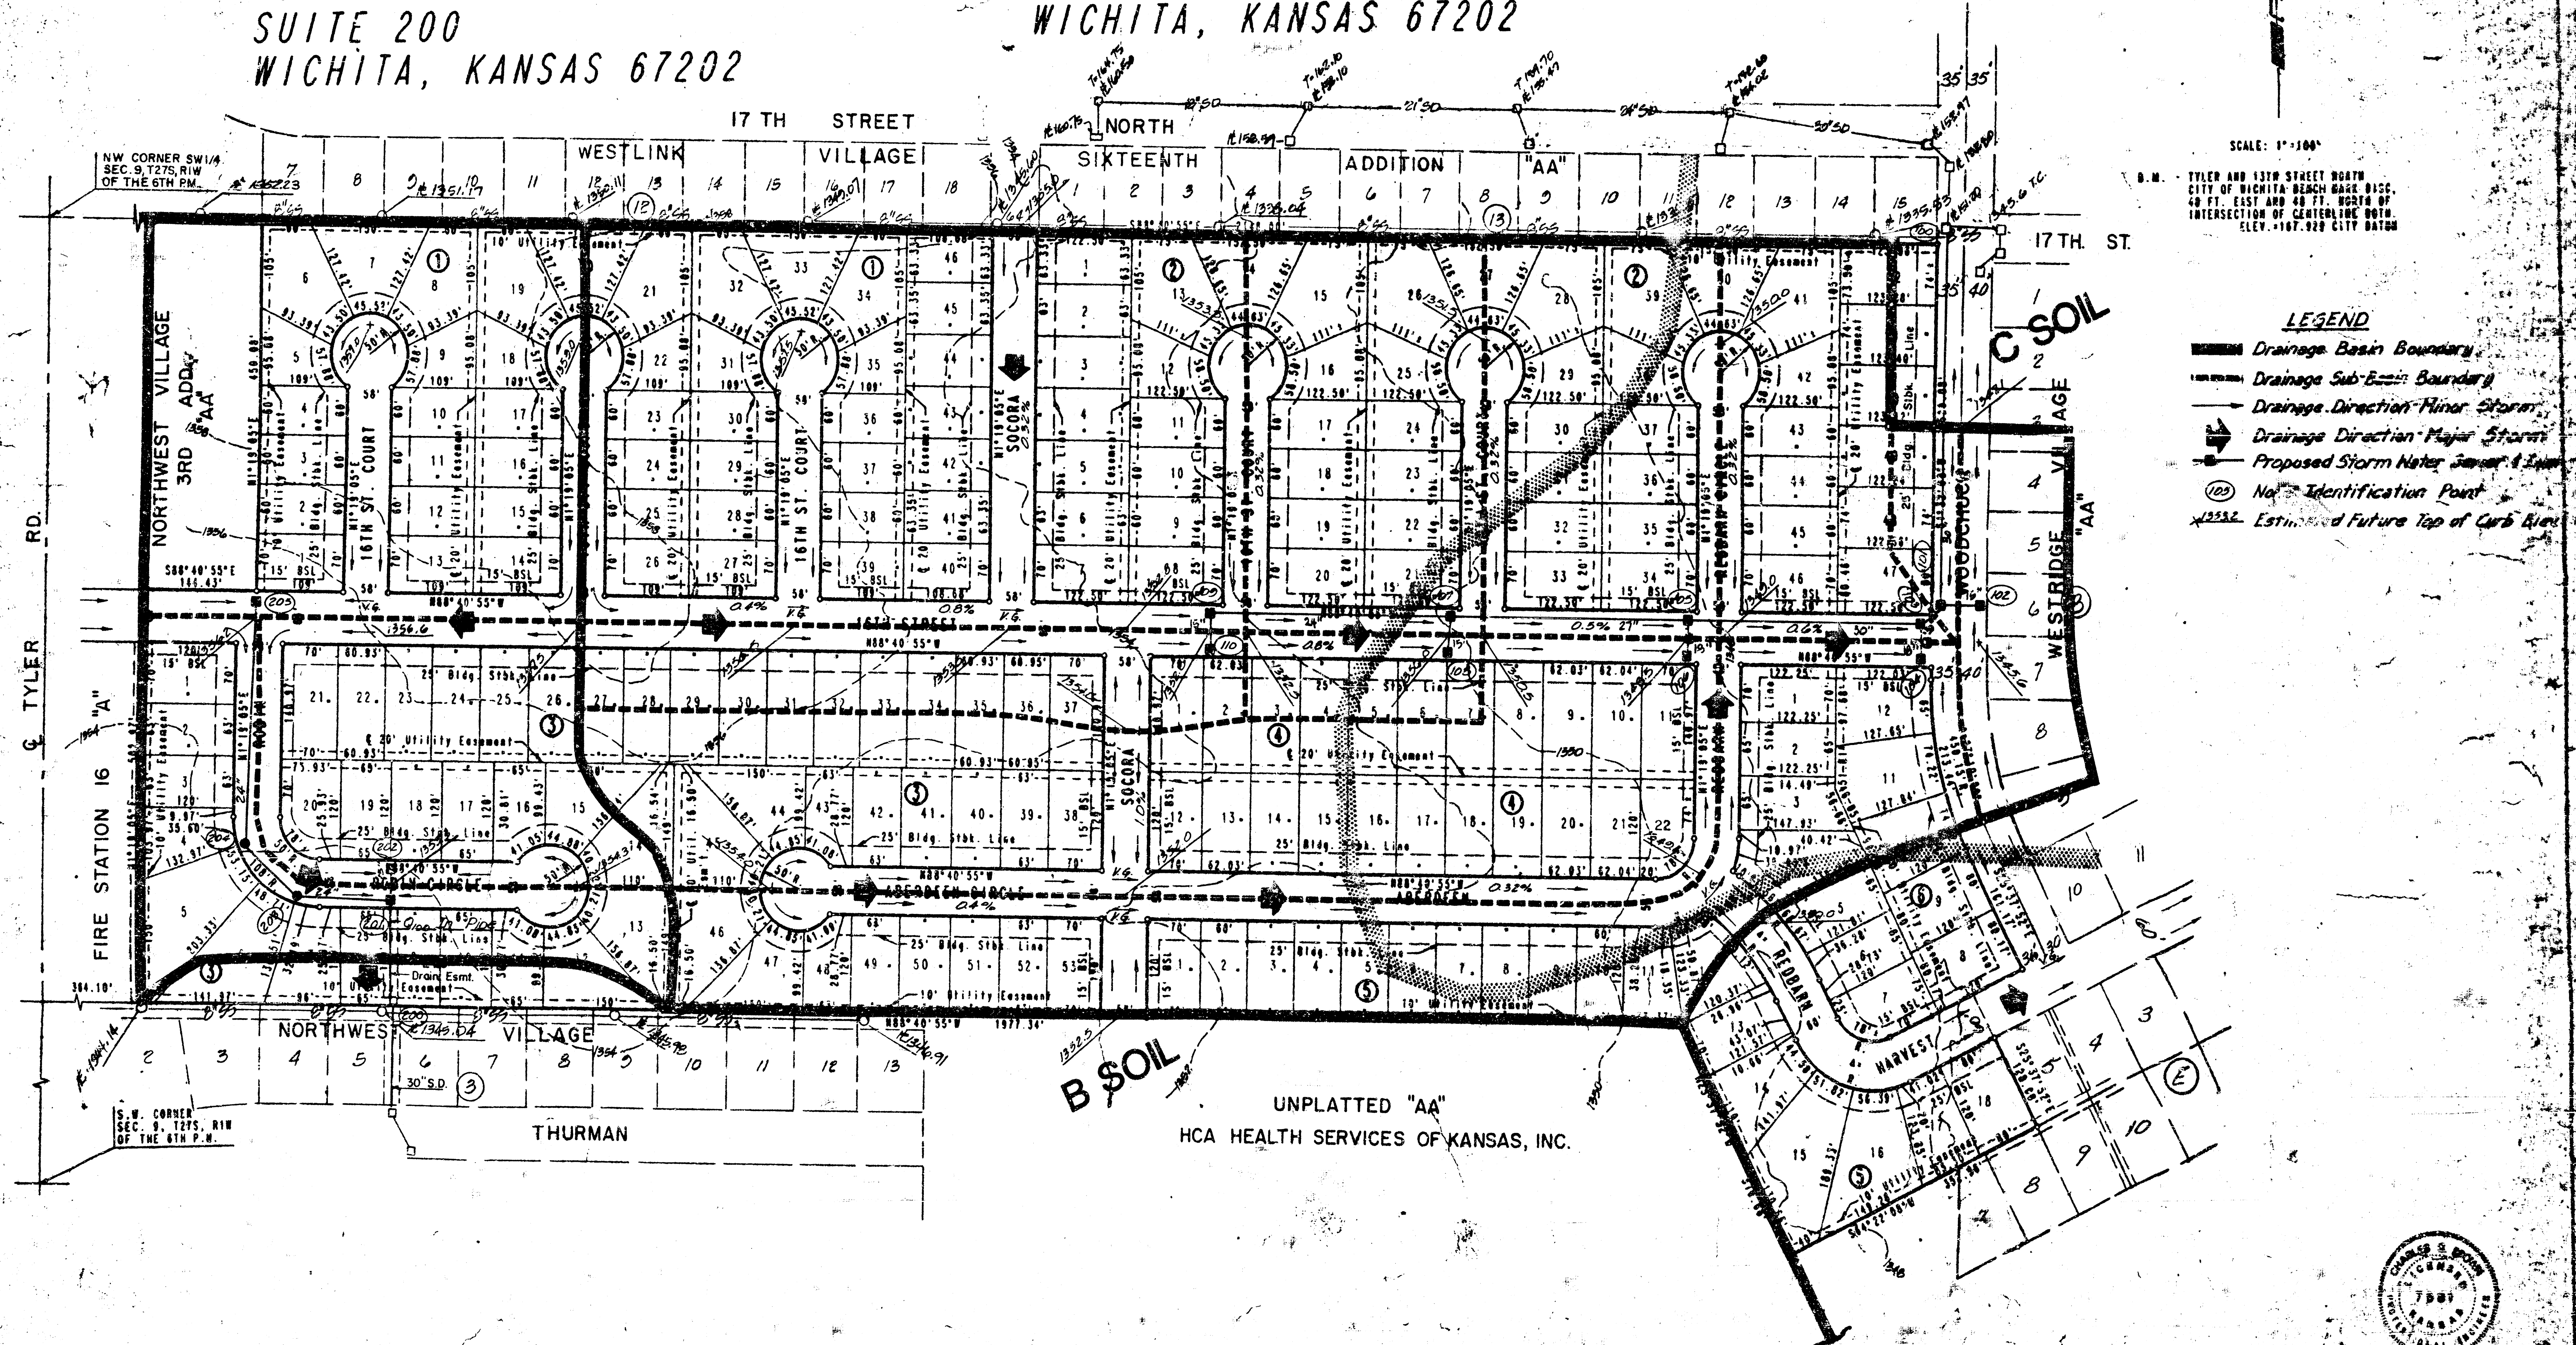

○ = IRON SET
● = IRON FOUND

B.W. - TYLER AND 13TH STREET NORTH
CITY OF WICHITA BENCH MARK DISC
48 FT. EAST AND 48 FT. NORTH OF
INTERSECTION OF CENTERLINE BOTH
ELEV. = 167.929 CITY DATUM

≠ Match Exist. Elev

APPROVED DRAINAGE PLAN



No.	Revision	By	Date
DETAILED GRADING PLAN			
PROFESSIONAL ENGINEERING CONSULTANTS, P.A. ENGINEERS WICHITA, KANSAS			
Designed by <i>M.H.B.</i>	Job No. <i>34-99200</i>	Sht. / of /	
Drawn by <i>E.S.</i>	Date <i>10-20-92</i>		