


F:\CIVIL\98135.DWG Tue Feb 02 09:36:17 1999

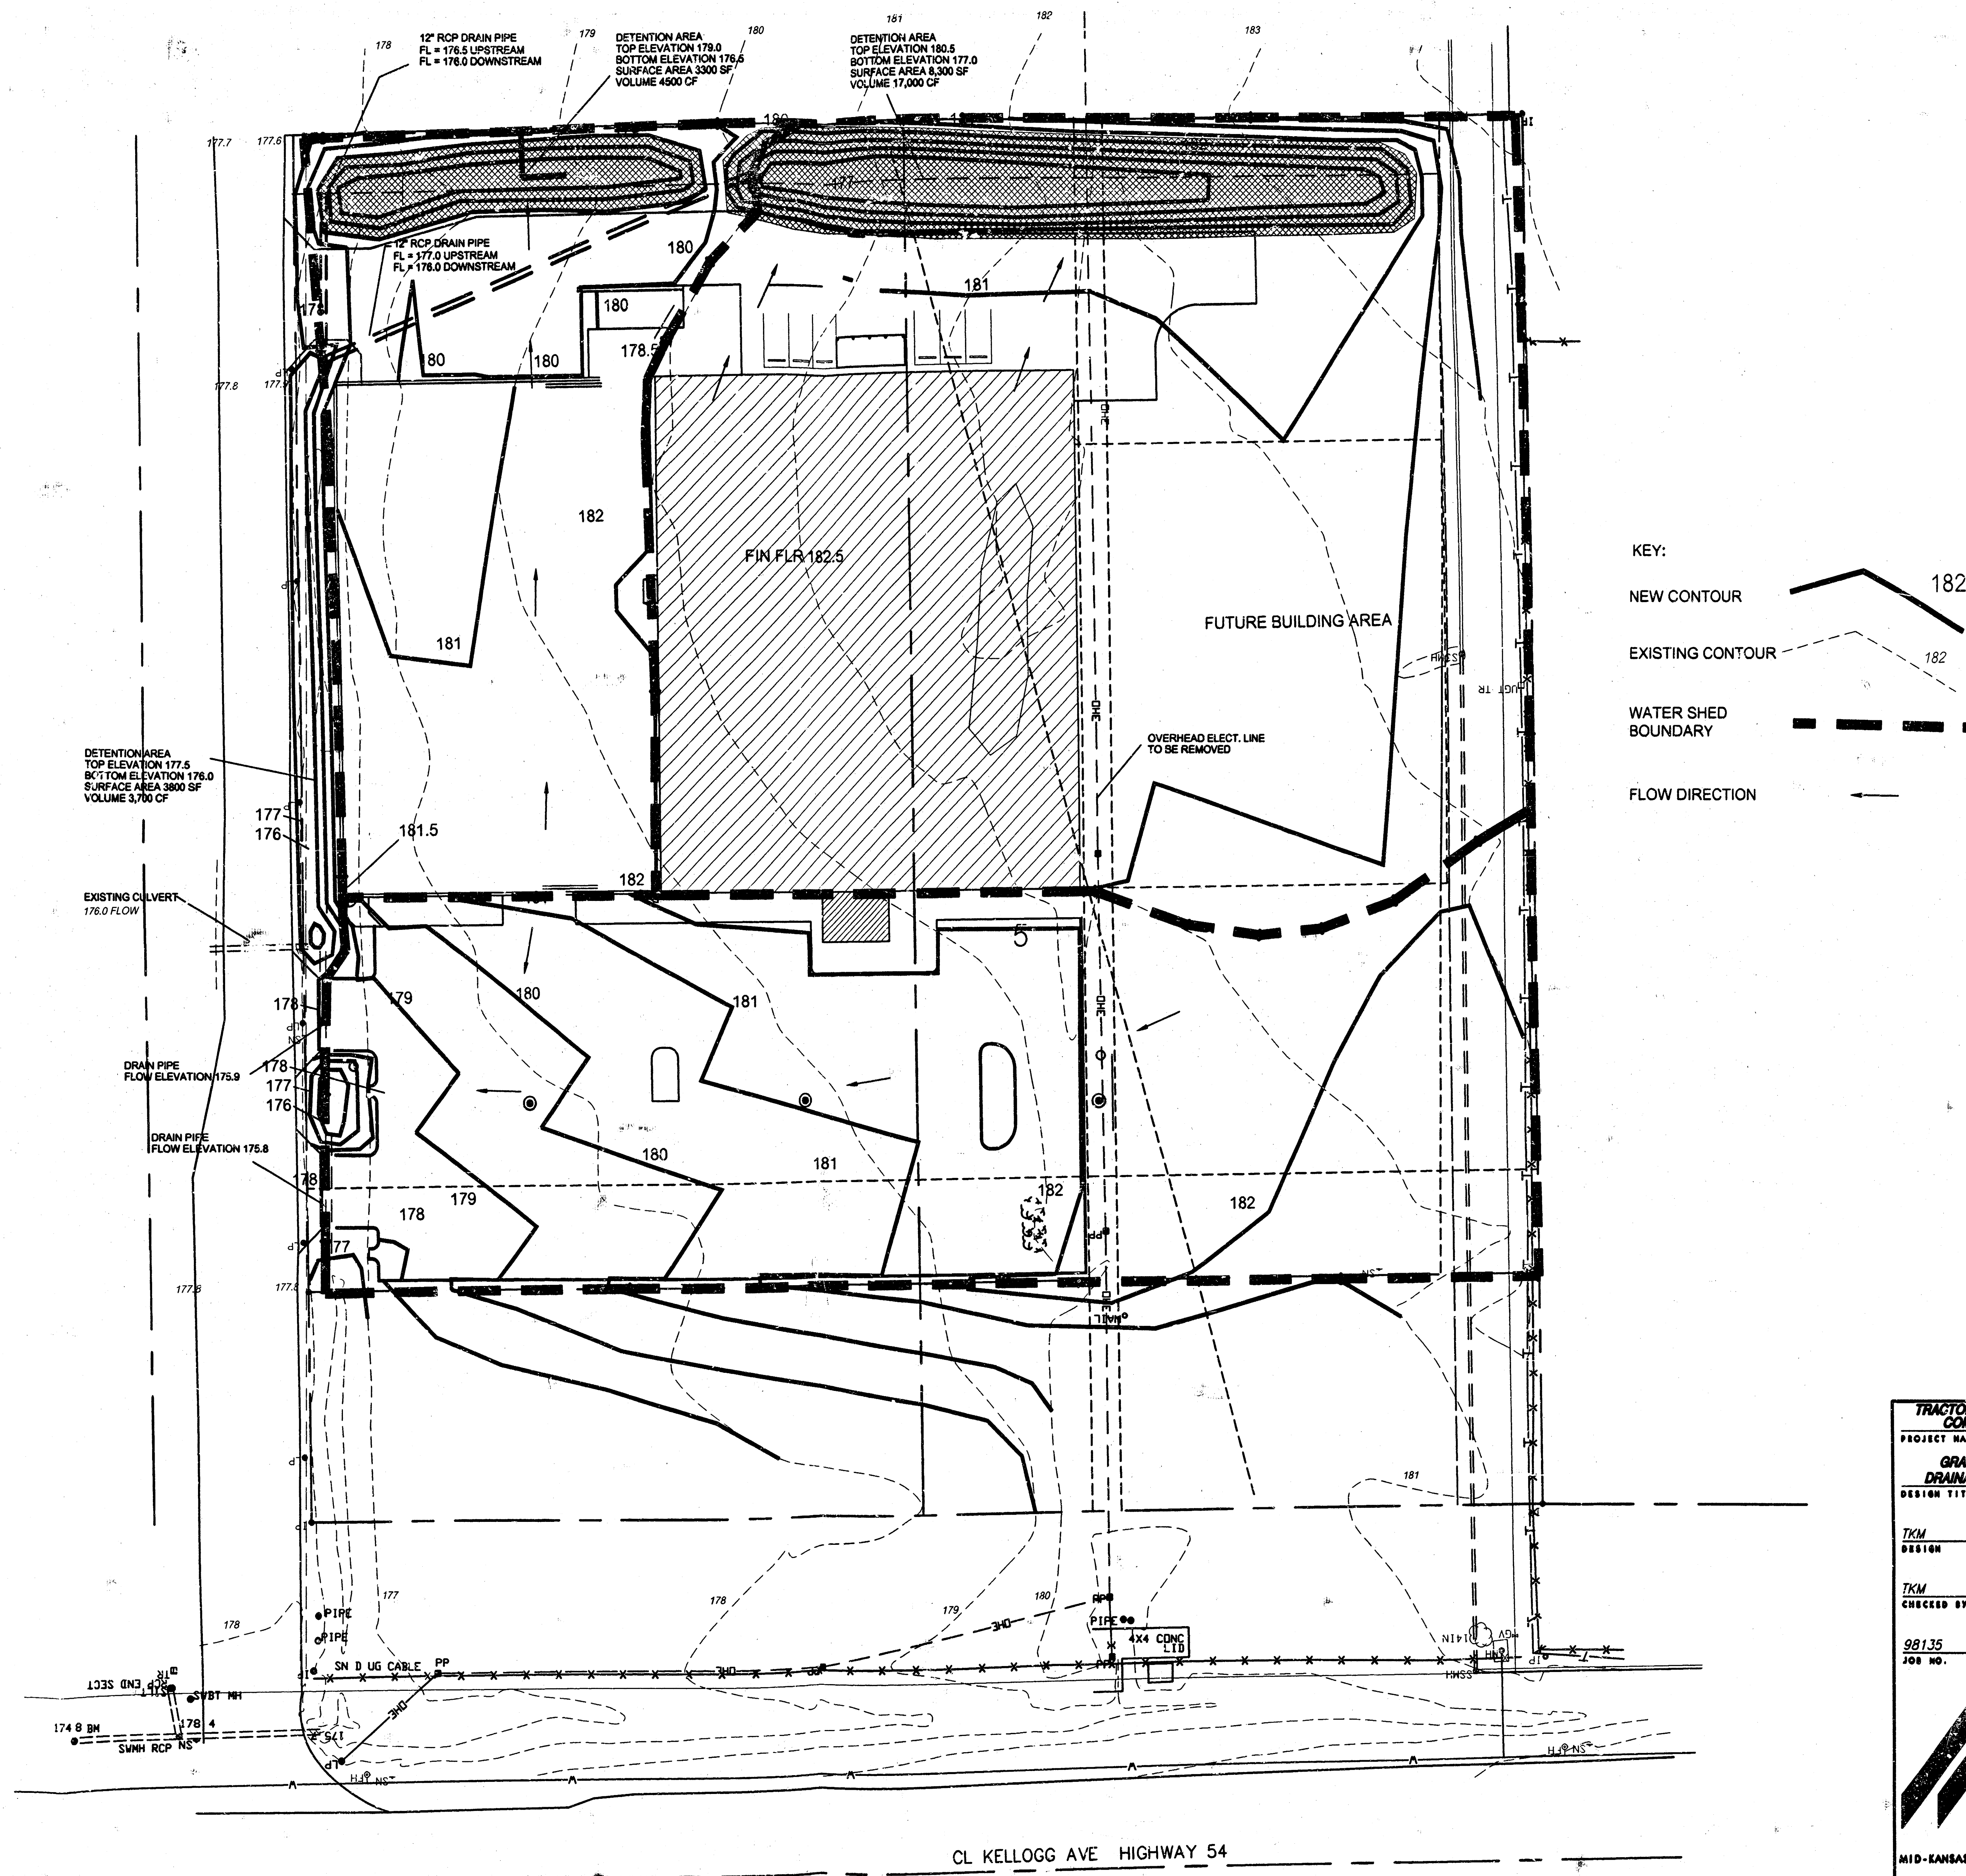

GRADING & DRAINAGE PLAN
SCALE: 1" = 30'

TRACTOR SUPPLY COMPANY	
PROJECT NAME	
GRADING & DRAINAGE PLAN	
DESIGN TITLE	
TKM	DAC
DESIGN	DRAWN BY:
TKM	FEB. 1999
CHECKED BY:	DATE
98135	1 / 1
JOB NO.	SHEET/OF
	
MID-KANSAS ENGINEERING CONSULTANTS, INC. 411 N WEBB ROAD WICHITA, KS 67206 316-694-9600	

PROJECT	DATE
ISSUE	DATE
GRADING PLAN	

SP2

**TRACTOR SUPPLY COMPANY
DEVELOPMENT FOR WALTER LEWIS**

KELLOGG AND WEBB ROAD
WICHITA, KANSAS

**SPANGENBERG • PHILLIPS
ARCHITECTURE**

224 E. Douglas, Fifth Floor Wichita, KS 67202 T 316-267-4002 F 316-267-1509