


FYWA REGION NO.	STATE	PROJECT NO.	YEAR	SHEET NO.	TOTAL SHEETS
7	KS.	87-U-1362-01	199	113	149

SCALE: 1" = 100'

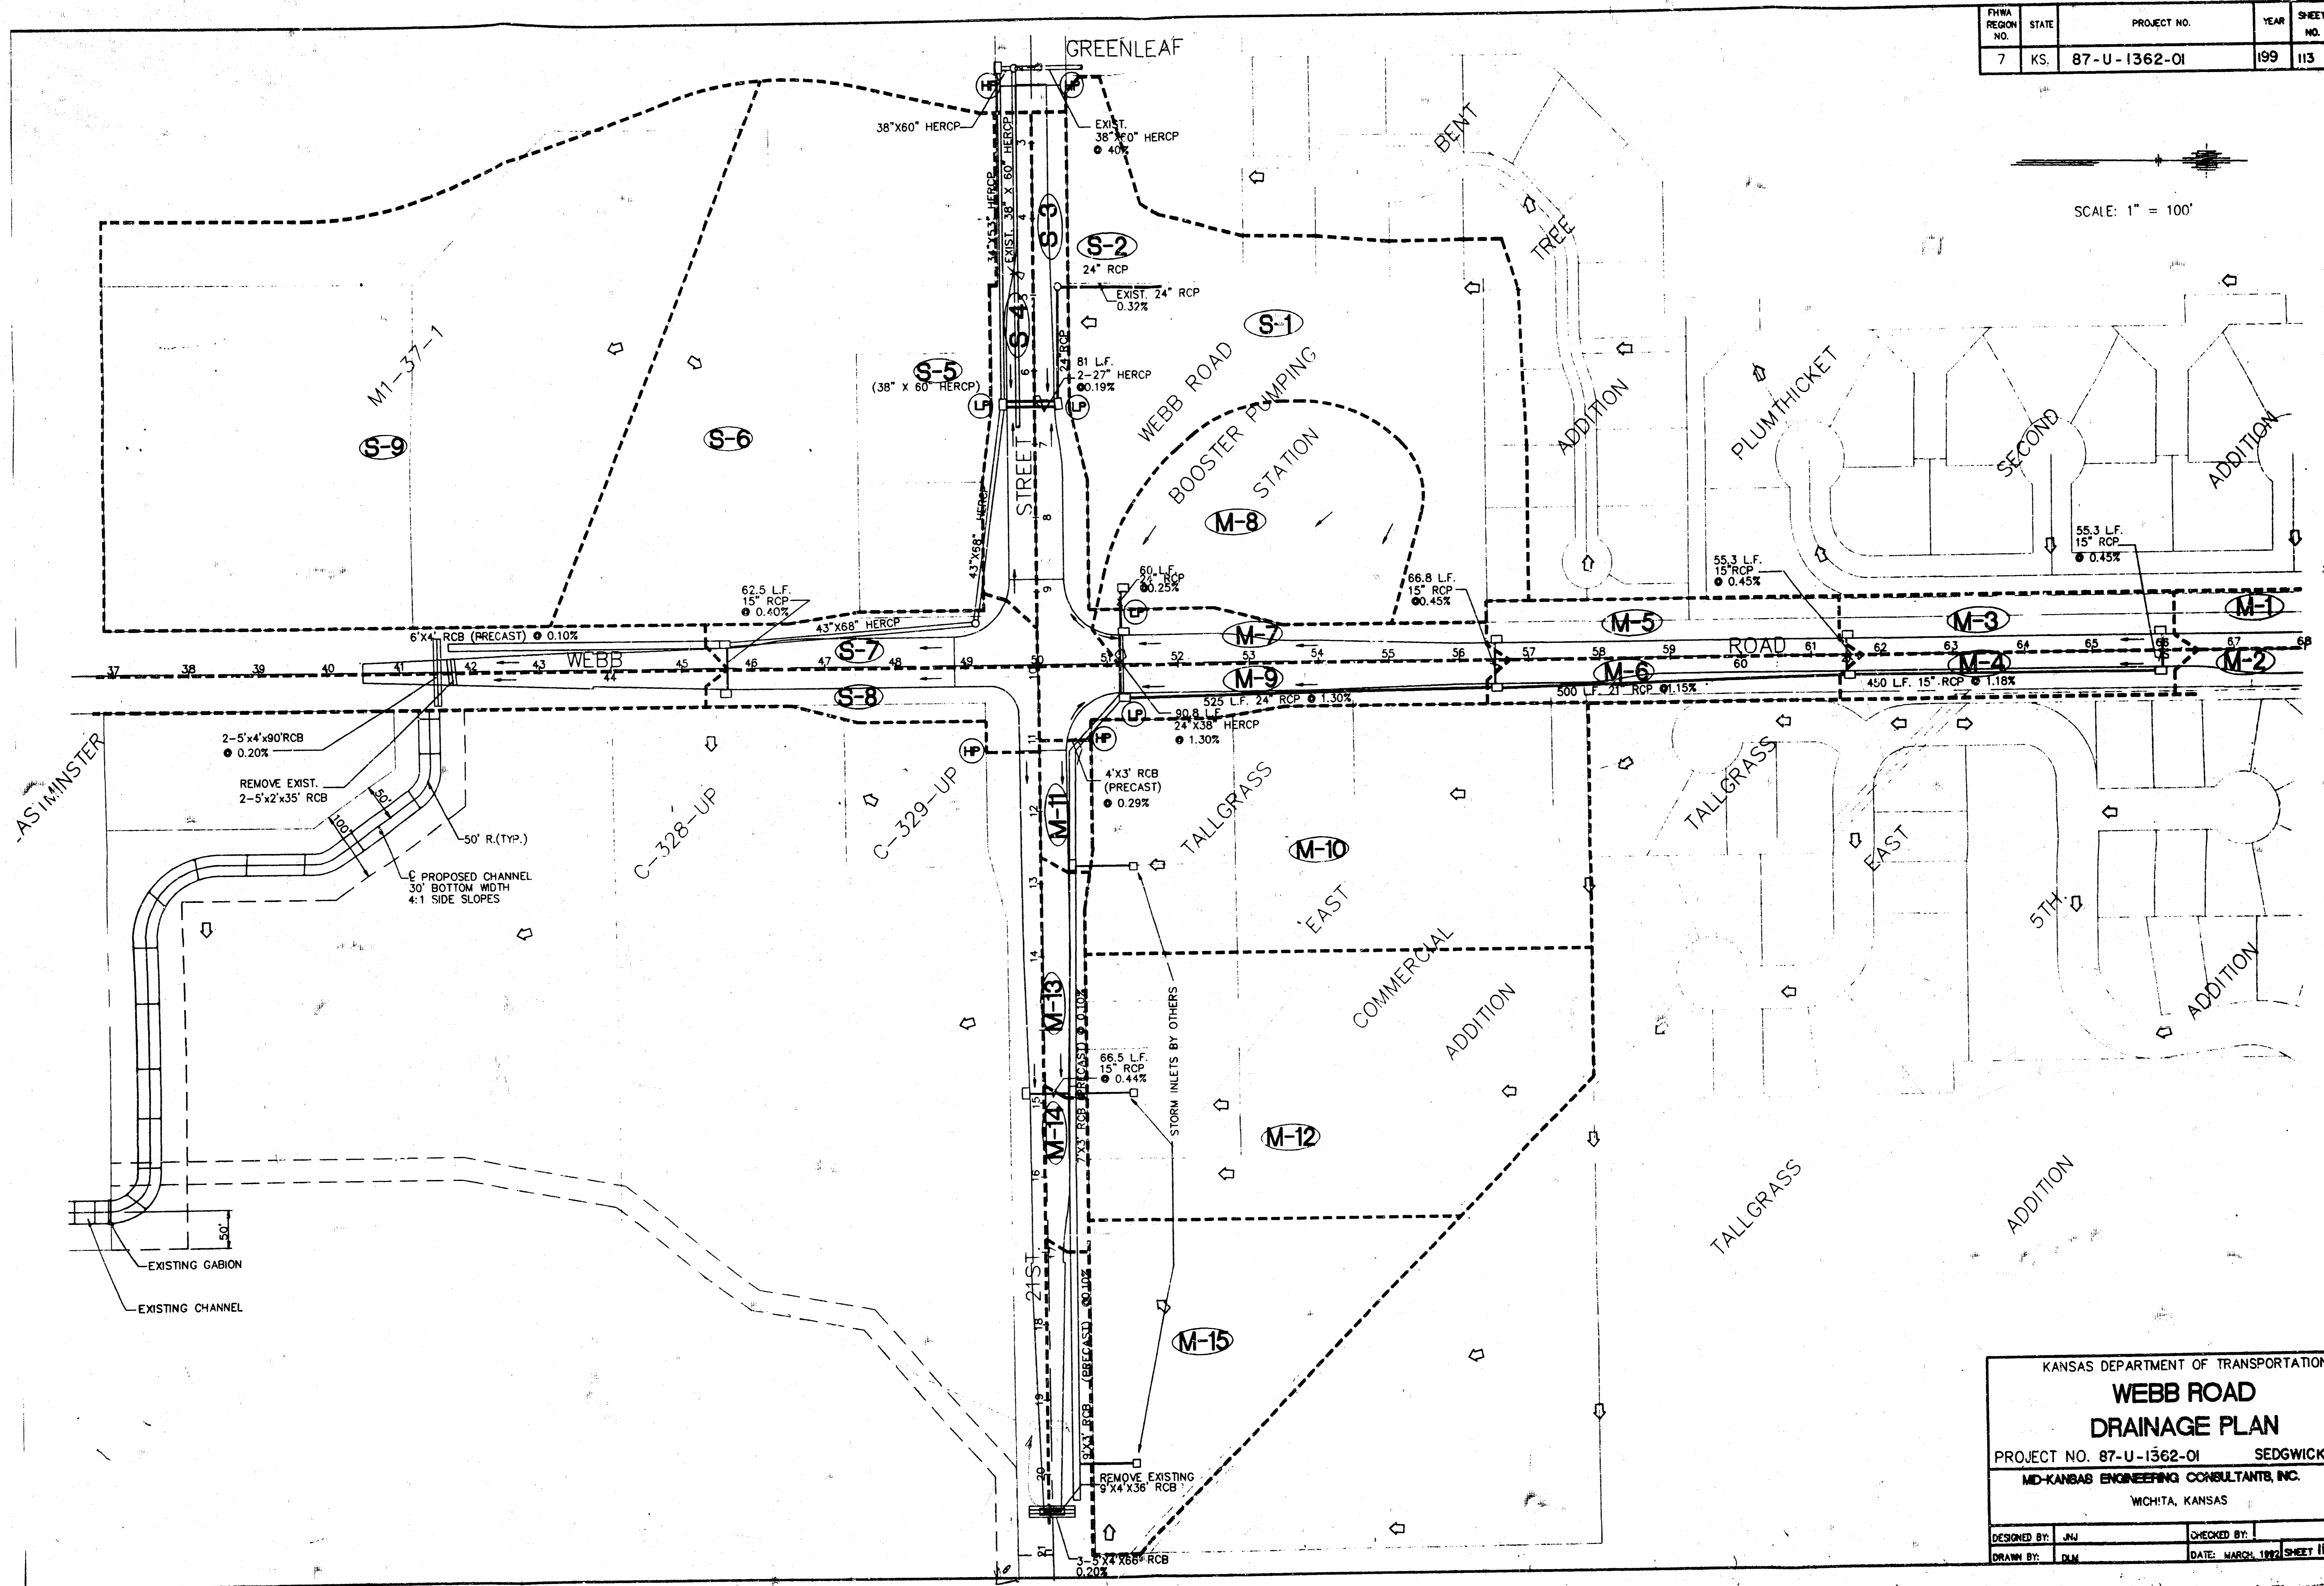

KANSAS DEPARTMENT OF TRANSPORTATION

**WEBB ROAD
DRAINAGE PLAN**

PROJECT NO. 87-U-1362-01 SEDGWICK CO.

MD-KANSAS ENGINEERING CONSULTANTS, INC.
WICHITA, KANSAS

DESIGNED BY: JMJ	CHECKED BY:
DRAWN BY: JMJ	DATE: MARCH, 1992 SHEET 113 OF 149