

PROFESSIONAL
ENGINEERING CONSULTANTS, PA
303 South Topeka
WICHITA, KANSAS 67202

(318) 282-2691

TO VICKY HUANG, P.E.
ENGINEERING DEPT
7TH FLOOR, CITY HALL

LETTER OF TRANSMITTAL

DATE	10-19-95	JOB NO.	36-95136-2108
ATTENTION			
RE	WELLEY MEDICAL CENTER		
	5TH ADD.		

WE ARE SENDING YOU ☒ Attached ☐ Under separate cover via _____ the following items:

- ☐ Shop drawings ☐ Prints ☐ Plans ☐ Samples ☐ Specifications
☐ Copy of letter ☐ Change order ☐ _____

COPIES	DATE	NO	DESCRIPTION
2			DRAINAGE PLAN

THESE ARE TRANSMITTED as checked below:

- ☒ For approval ☐ Approved as submitted ☐ Resubmit _____ copies for approval
☐ For your use ☐ Approved as noted ☐ Submit _____ copies for distribution
☐ As requested ☐ Returned for corrections ☐ Return _____ corrected prints
☐ For review and comment ☐ _____
☐ FOR BIDS DUE _____ 19 _____ ☐ PRINTS RETURNED AFTER LOAN TO US

REMARKS _____


COPY TO FILE

SIGNED: GARY WILEY

DRAINAGE PLAN OF WESLEY MEDICAL CENTER 5TH ADDITION

OWNER: H.C.A. HEALTH SERVICES OF KANSAS, INC.
c/o THOMAS L. NESTER
550 N. HILLSIDE
WICHITA, KANSAS 67218

ENGINEER: PROFESSIONAL ENGINEERING CONSULTANTS, P.A.
303 S. TOPEKA
WICHITA, KANSAS 67202

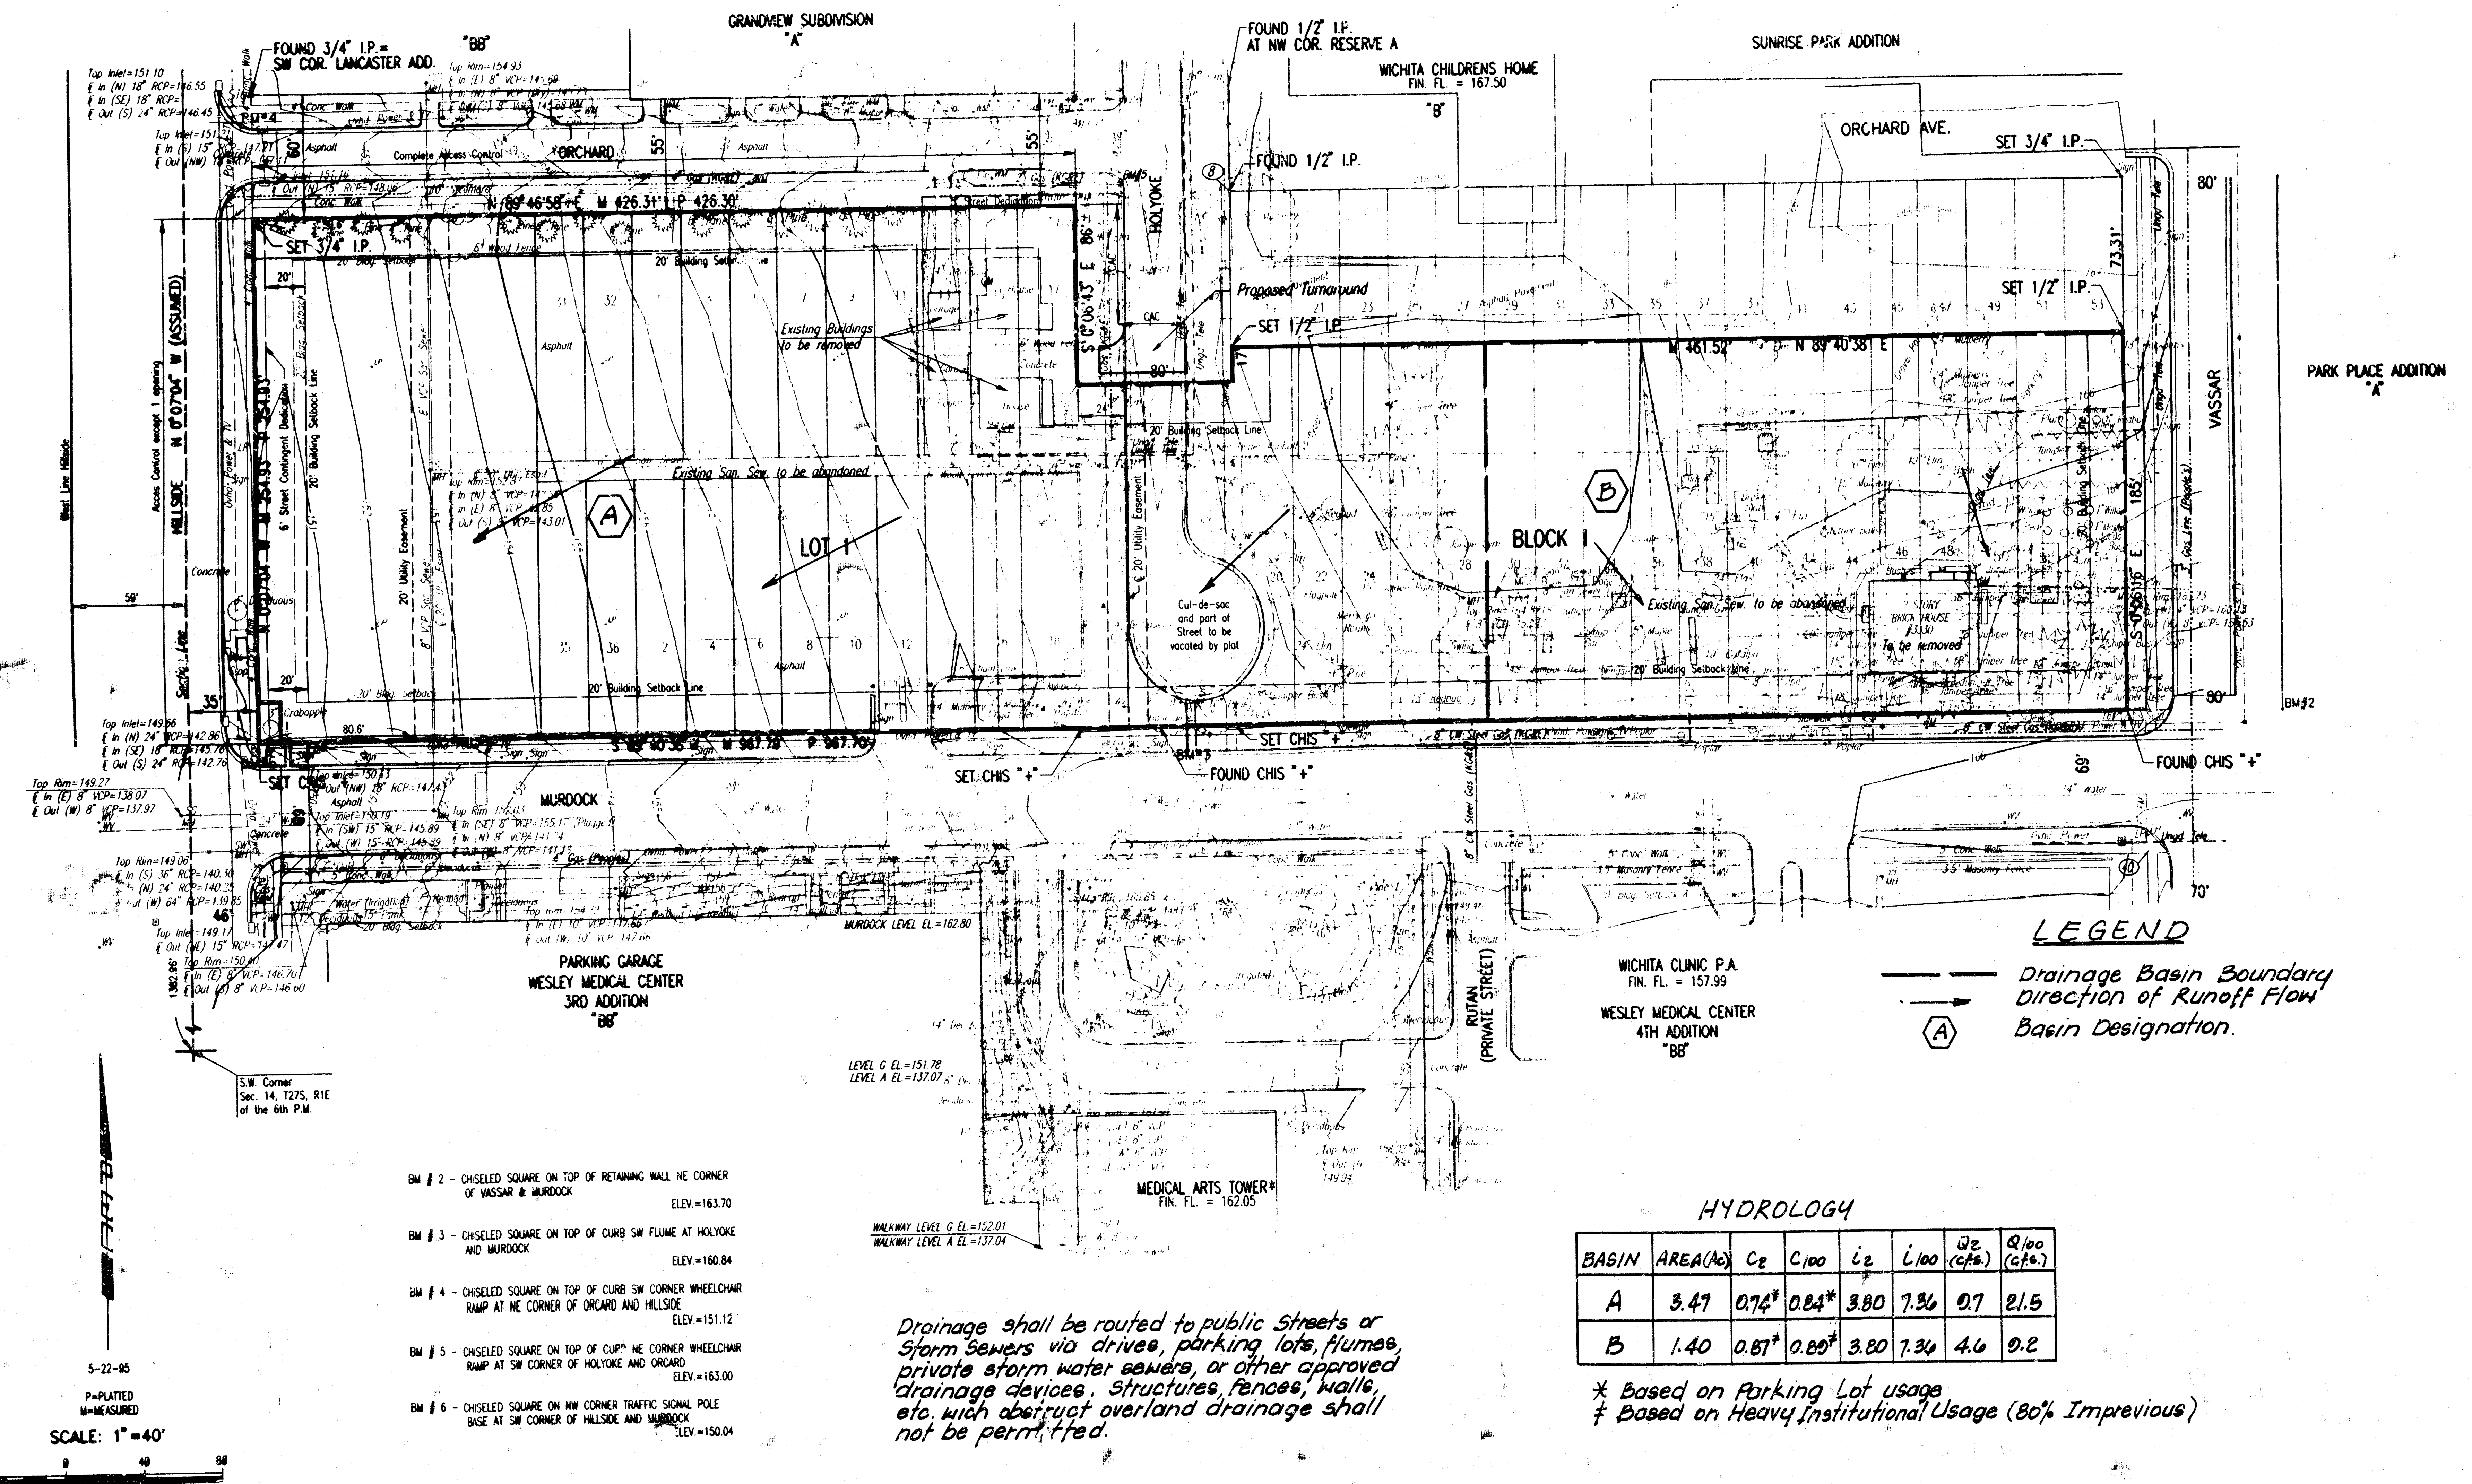

5-22-95
 P=PLATTED
 M=MEASURED
 SCALE: 1"=40'
 40 0 40 80