

PRELIMINARY
NOT FOR
CONSTRUCTION

DRAINAGE AND UTILITY PLAN
CEDAR VIEW VILLAGE

DRAINAGE AND UTILITY
SHEET TITLE

06189
PROJECT NUMBER

AF | CMJ | KLA
DESIGNED DRAWN CHECKED


ISSUED
October 2007

REVISED


SHEET NO.
1 OF 1

LEGEND

- ☆ 6IN - CONIFEROUS TREE
- 3IN - DECIDUOUS TREE
- SN - SIGN
- PP - POWER POLE
- ELEC BOX - ELECTRIC BOX
- LP - LIGHT POLE
- FH - FIRE HYDRANT
- WV - WATER VALVE
- WM - WATER METER
- △ - SECTION CORNER
- BM - BENCHMARK
- - - - - EASEMENT
- - - - - BUILDING SETBACK
- - - - - FENCE
- - - - - STORM SEWER PIPE
- - - - - WATER LINE
- - - - - SANITARY SEWER LINE
- - - - - GAS LINE
- - - - - GAS PIPELINE
- - - - - TELEPHONE LINE
- - - - - UNDERGROUND ELEC.
- - - - - OVERHEAD ELECTRIC
- - - - - FIBER OPTIC CABLE I
- - - - - DRAINAGE SUB BASIN
- - - - - DRAINAGE BASIN
- - FLOW ARROW
- A17** - AREA FOR SWS SIZING
- ▨ - LINES REMOVED

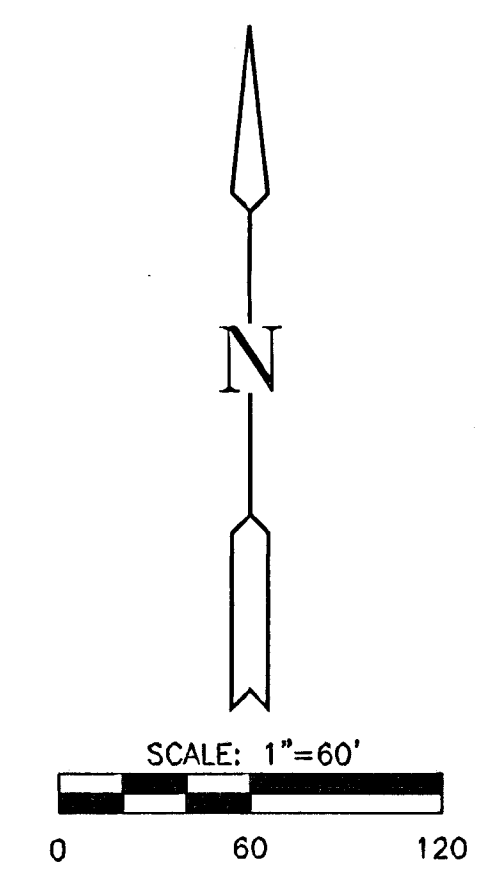

PROP. DETENTION			
STORM	Q(CFS)	WSEL	VOLUME AC-FT
2-YR	25	1346.7	0.8
5-YR	40	1347.0	1.0
10-YR	48	1347.1	1.1
25-YR	60	1347.3	1.3
100-YR	76	1347.6	1.5

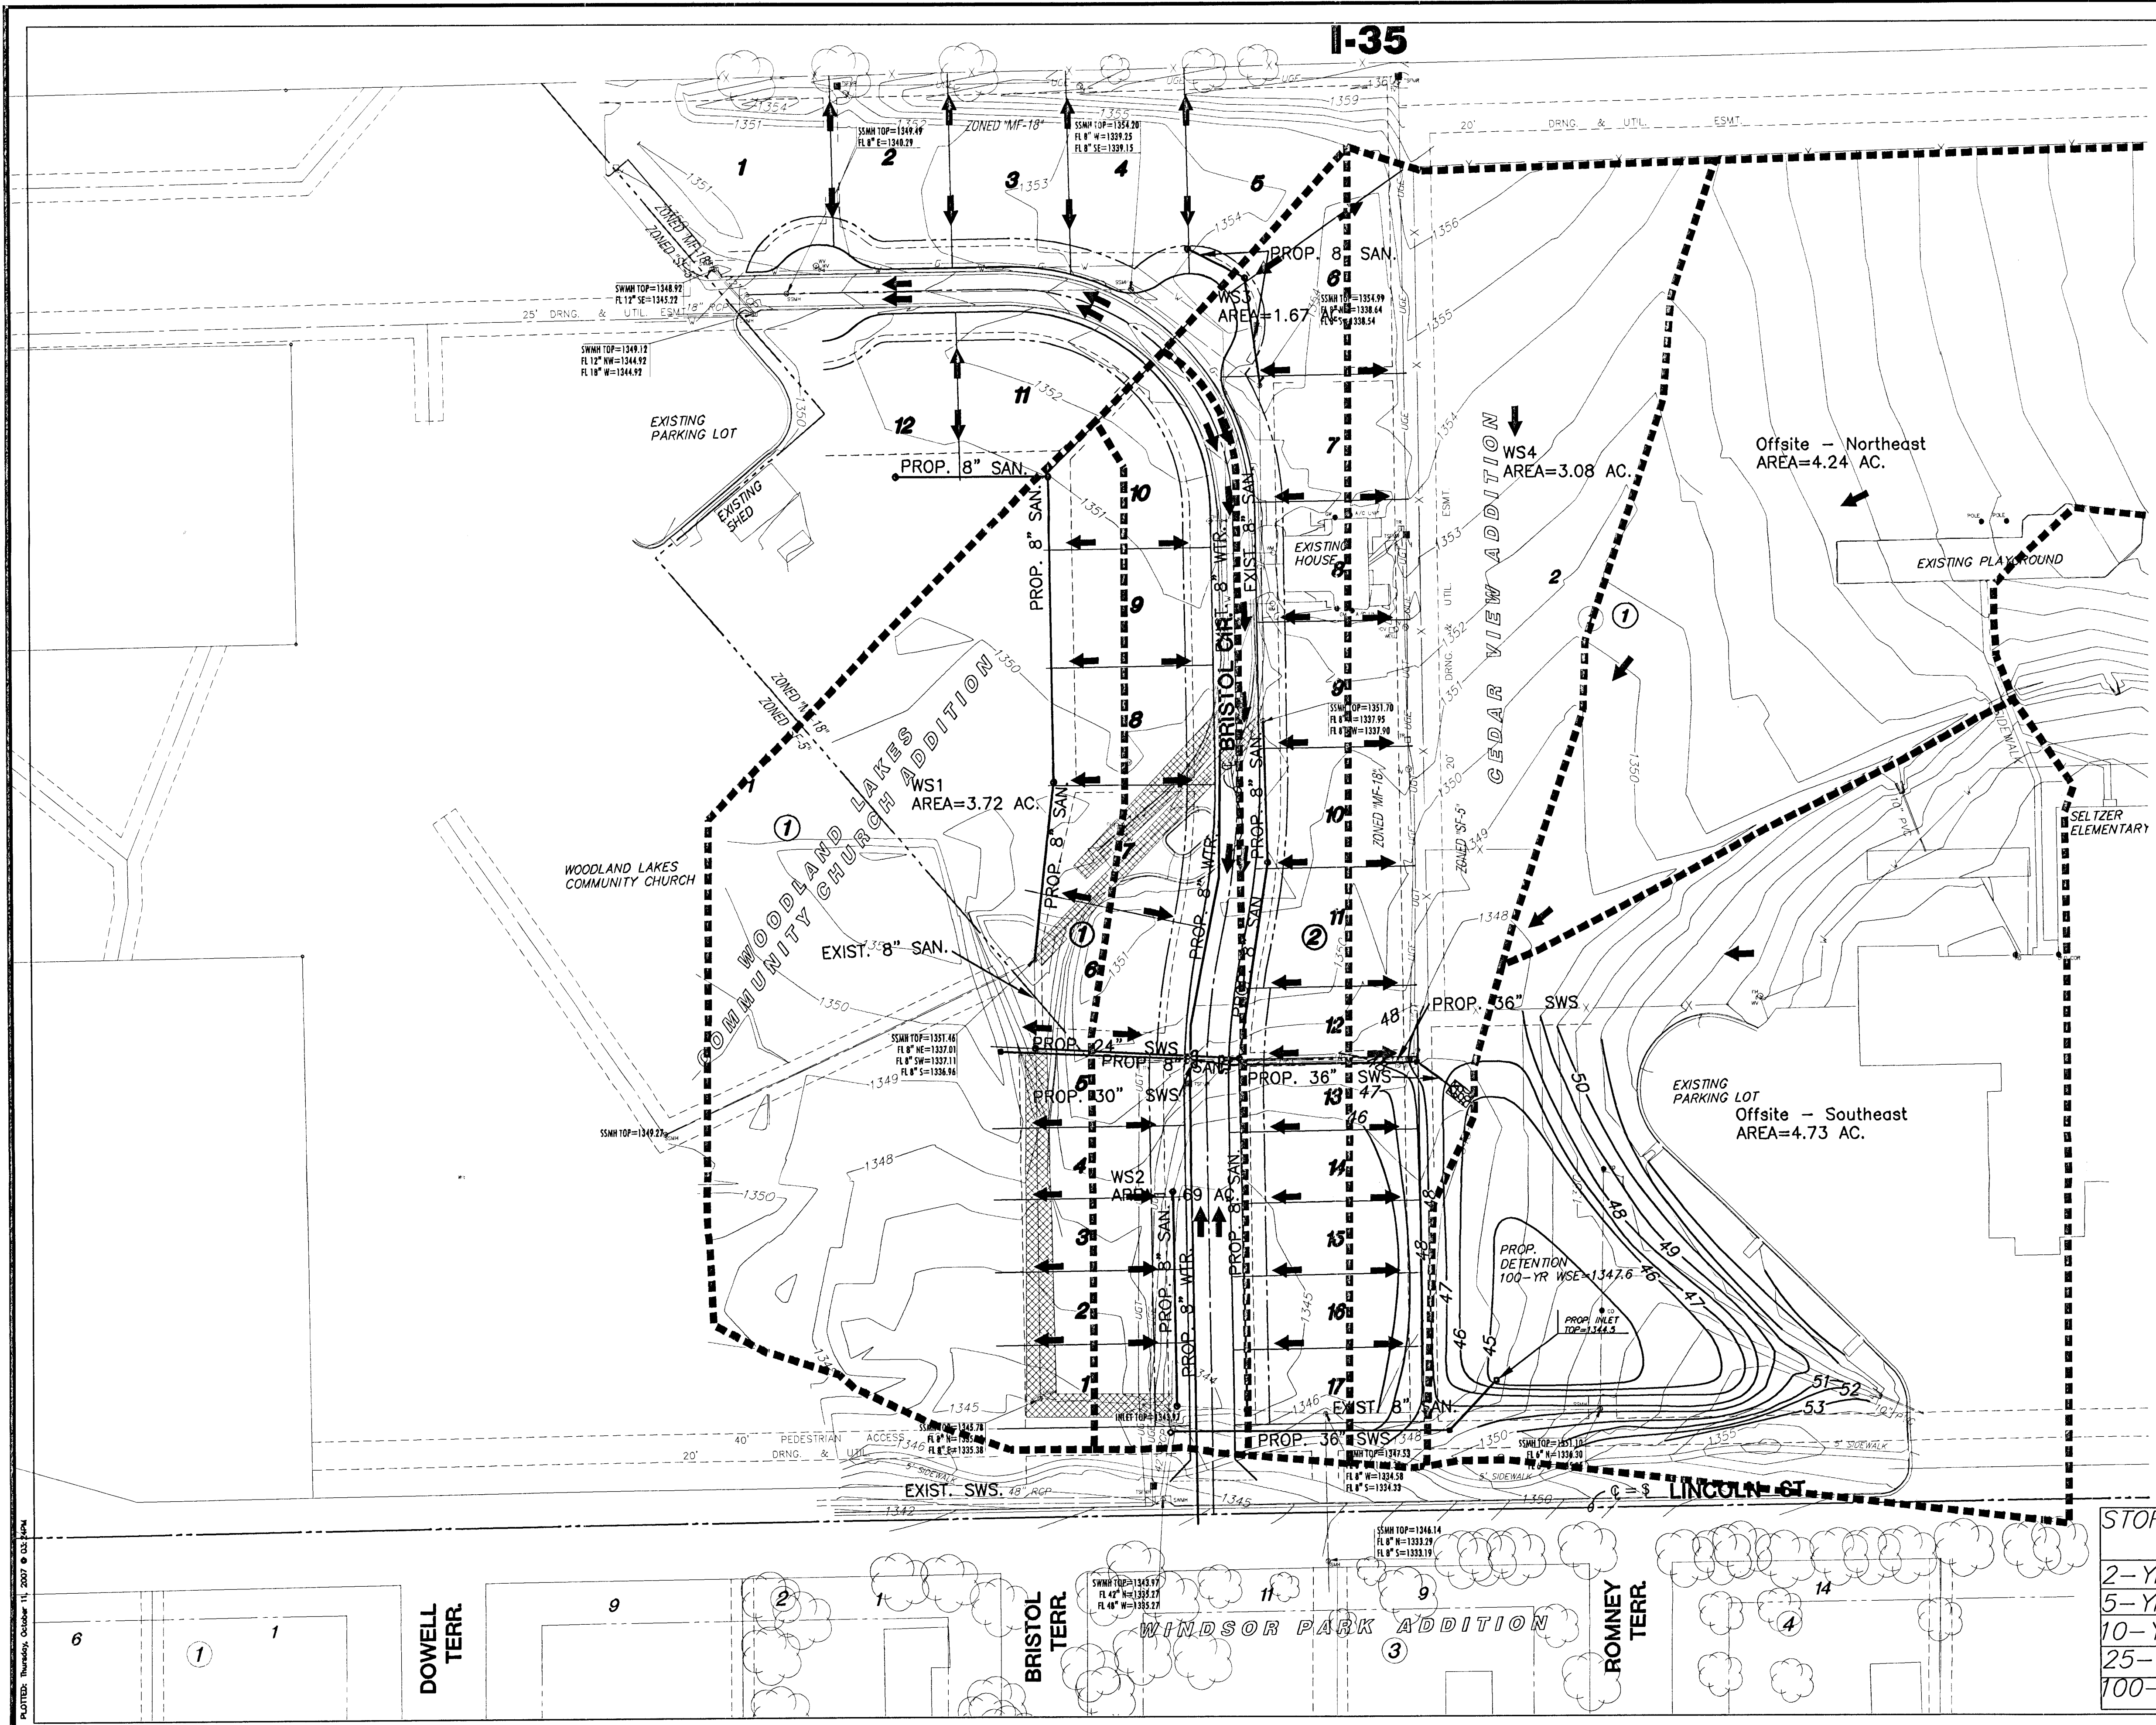

PLOTTED: Thursday, October 11, 2007 @ 03:40 AM
 C:\CIVIL\06189\DWG\DRNG_UTILITY_V06189.DWG