


13TH STREET NORTH

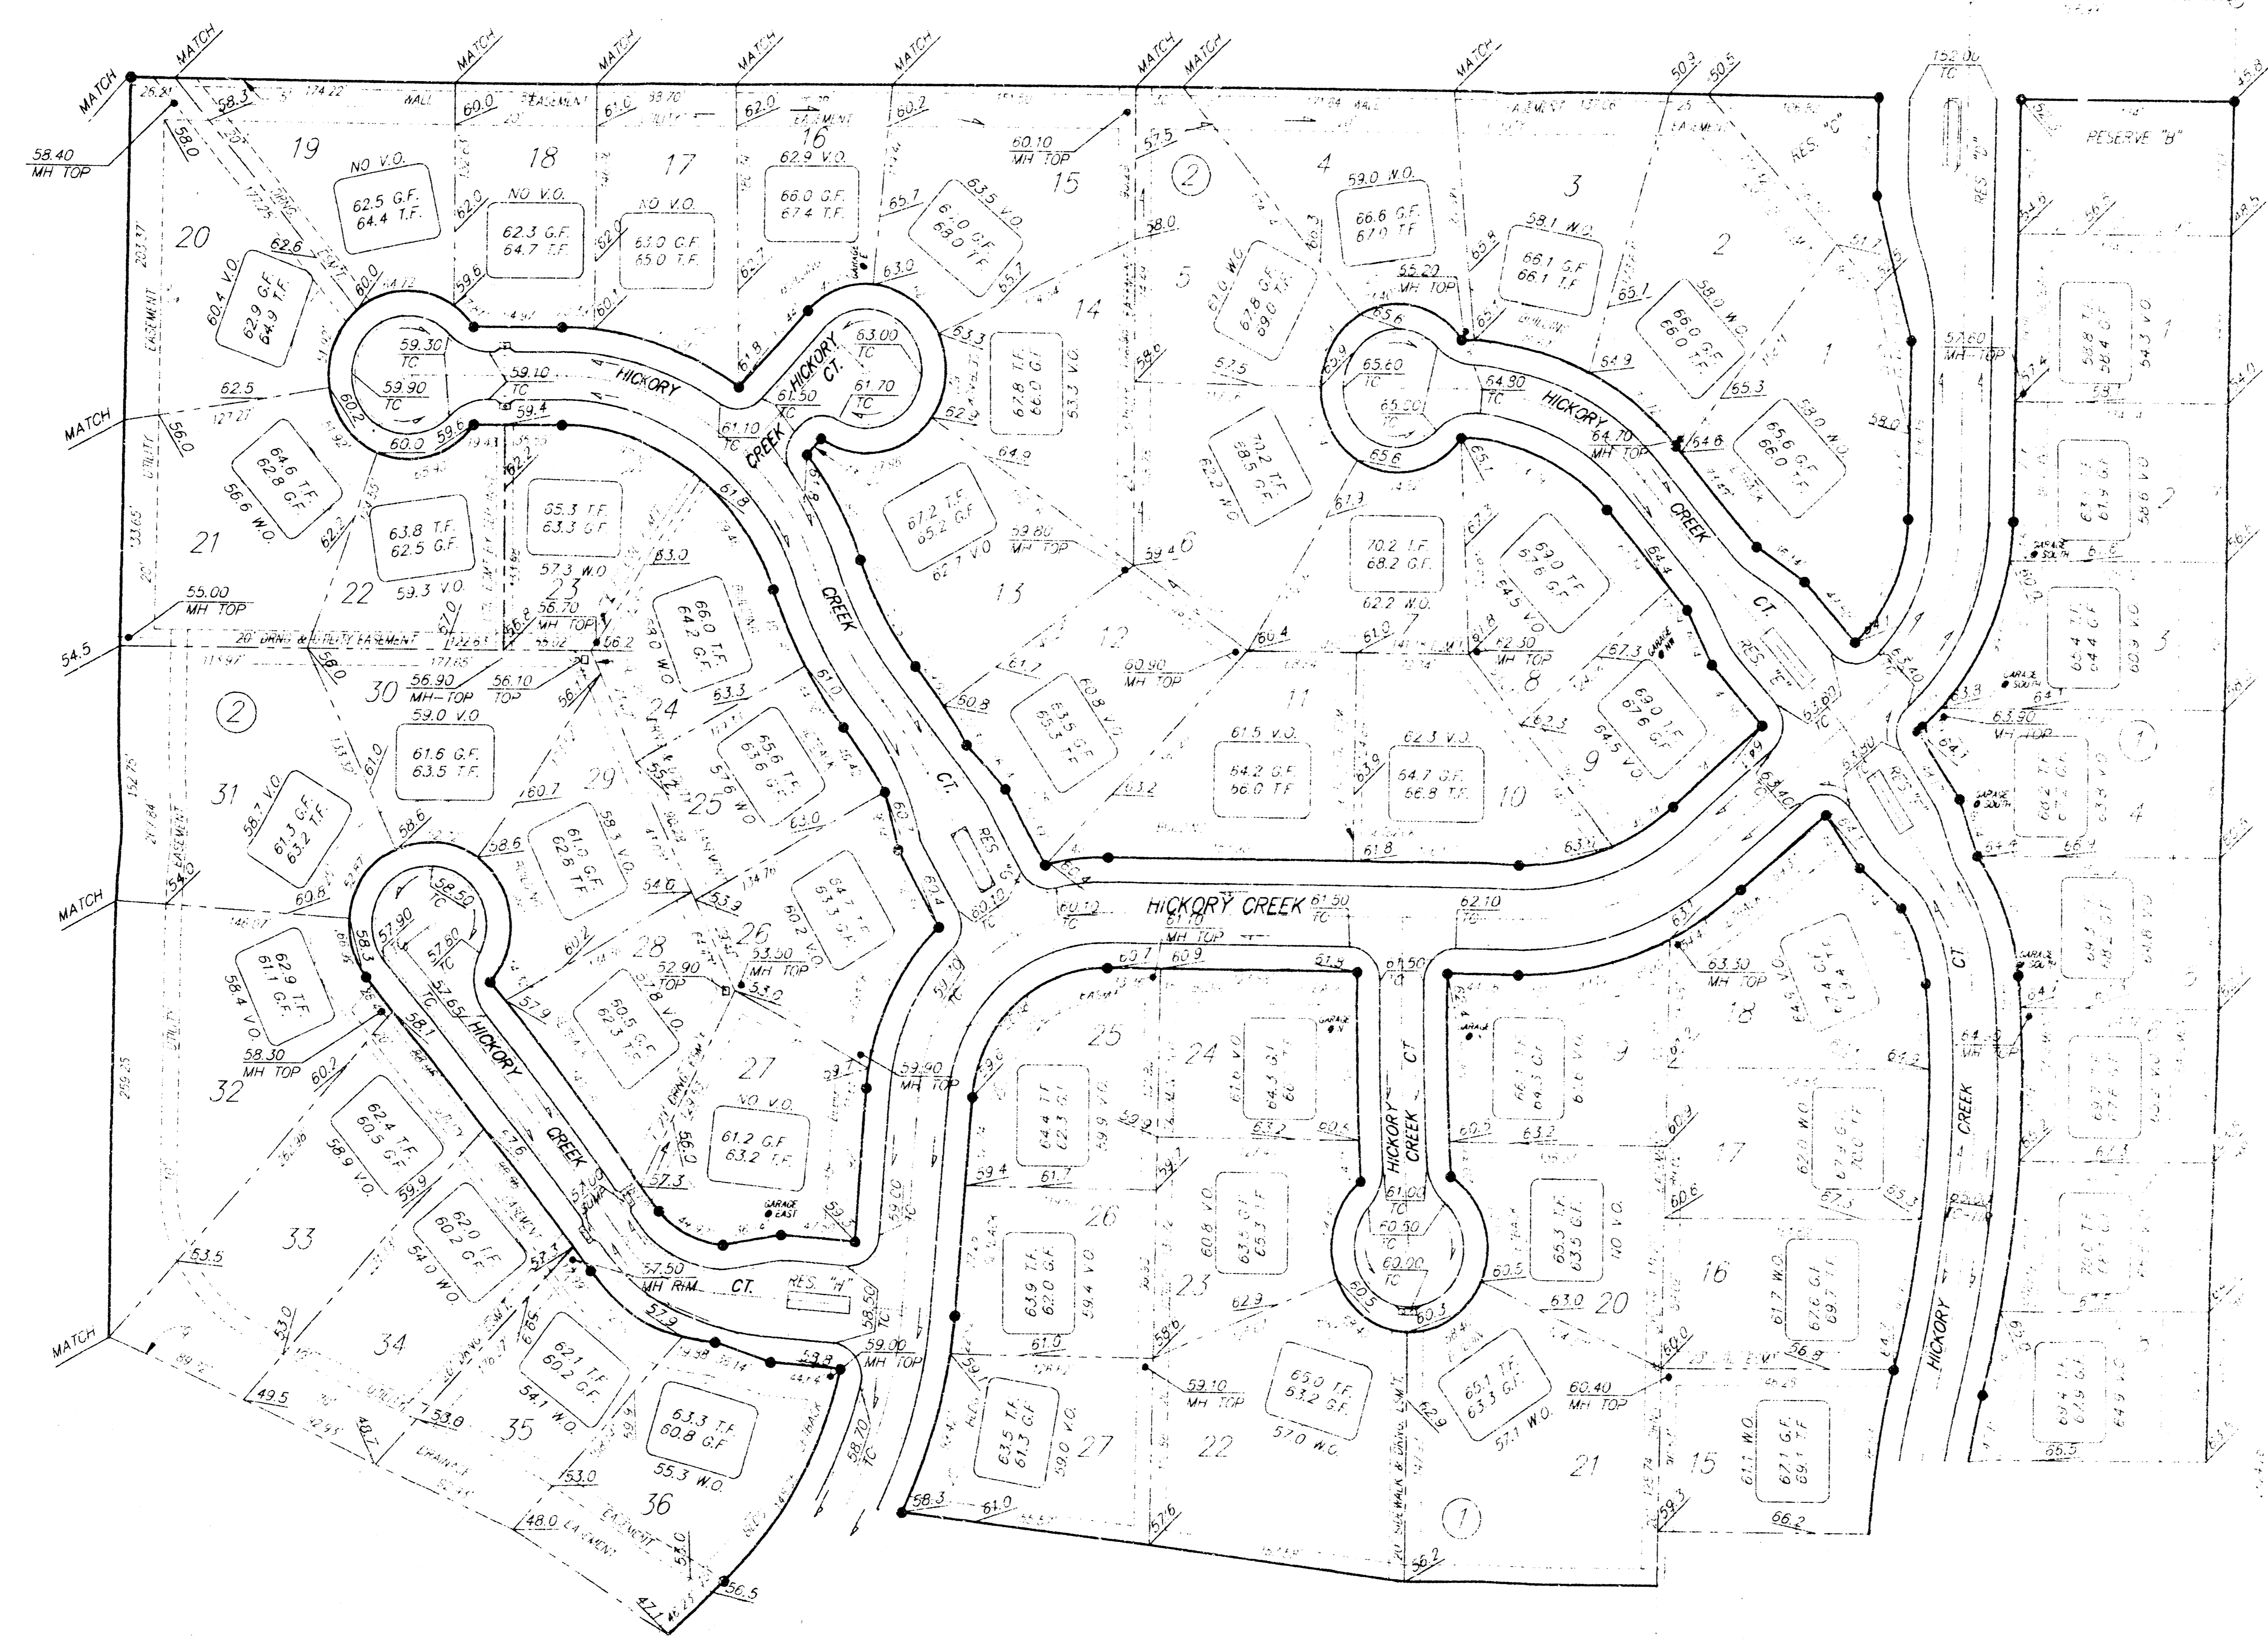

**APPROVED  
DRAINAGE PLAN**

**LOT GRADING PLAN**


**BAUGHMAN COMPANY, P.A.**  
ENGINEERING, SURVEYING, PLANNING

PROJECT NUMBER: \_\_\_\_\_

DATE	BY	APP'D	DATE

1  
3


PLAT CARDS MARKED 29 FEB 1990

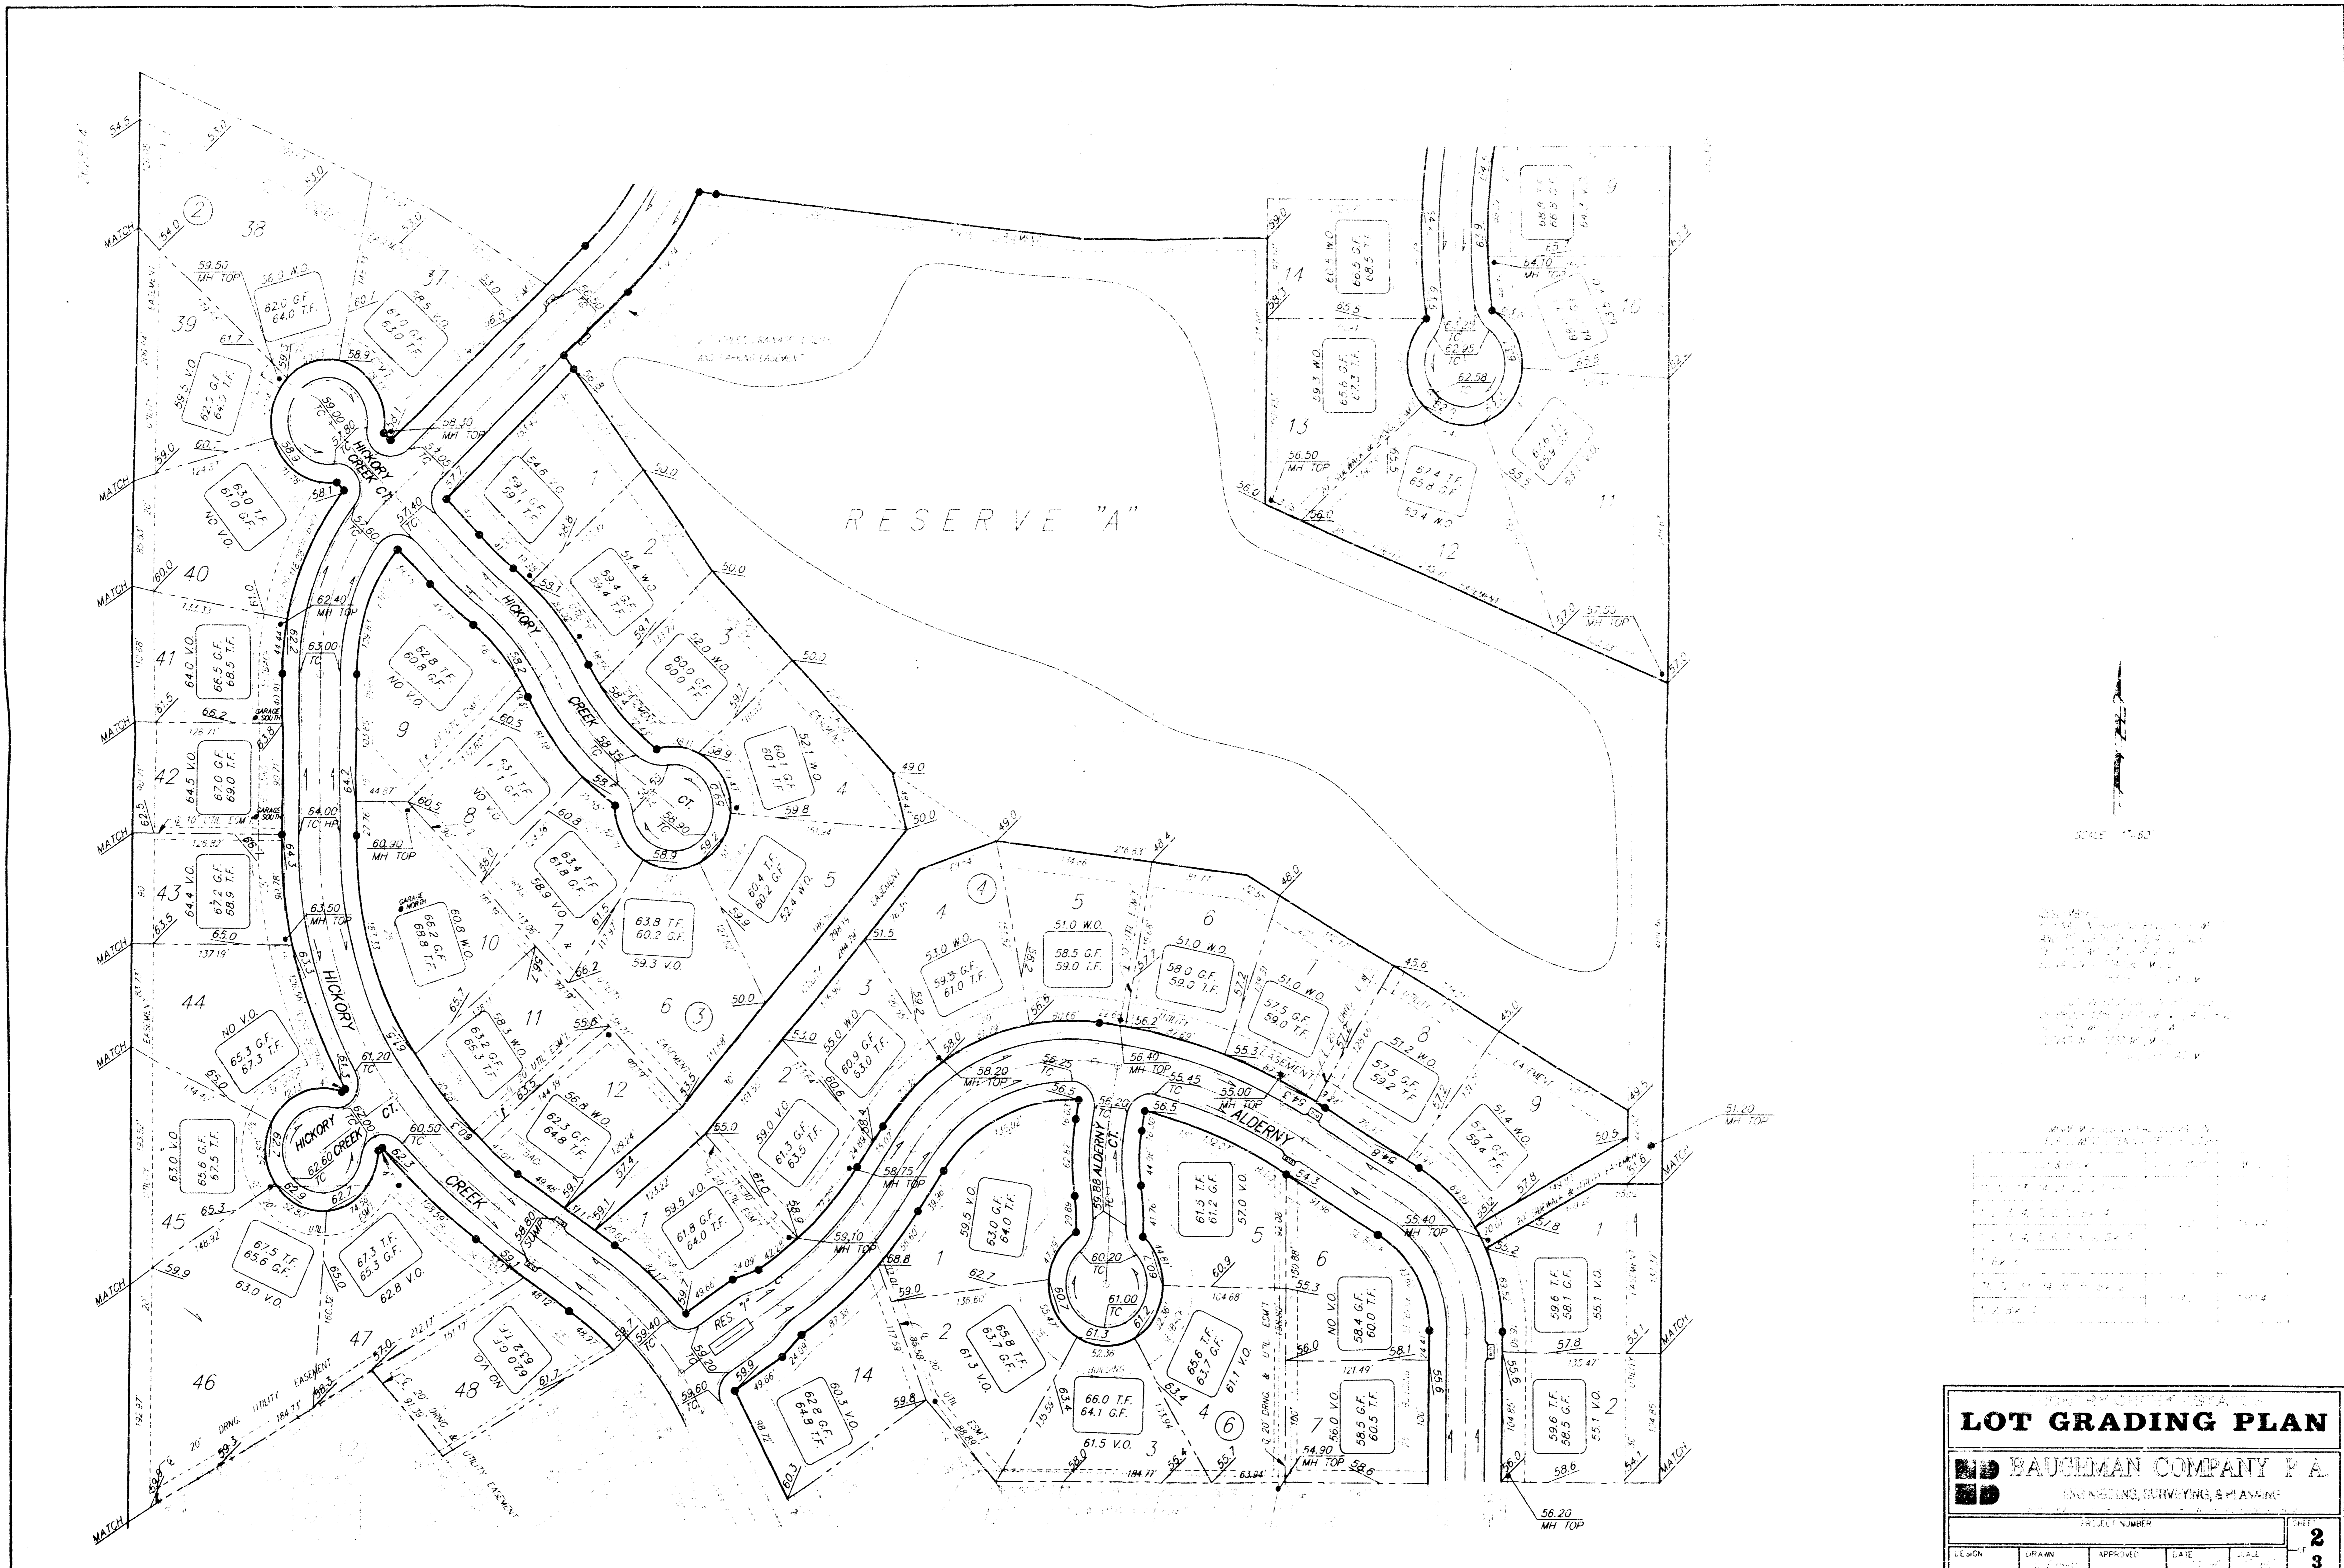

**LOT GRADING PLAN**

**BAUCEMAN COMPANY P.A.**  
 ENGINEERS, SURVEYORS, & PLANNERS

PROJECT NUMBER					SHEET <b>2</b> <b>3</b>
DESIGN	DRAWN	APPROVED	DATE	SCALE	

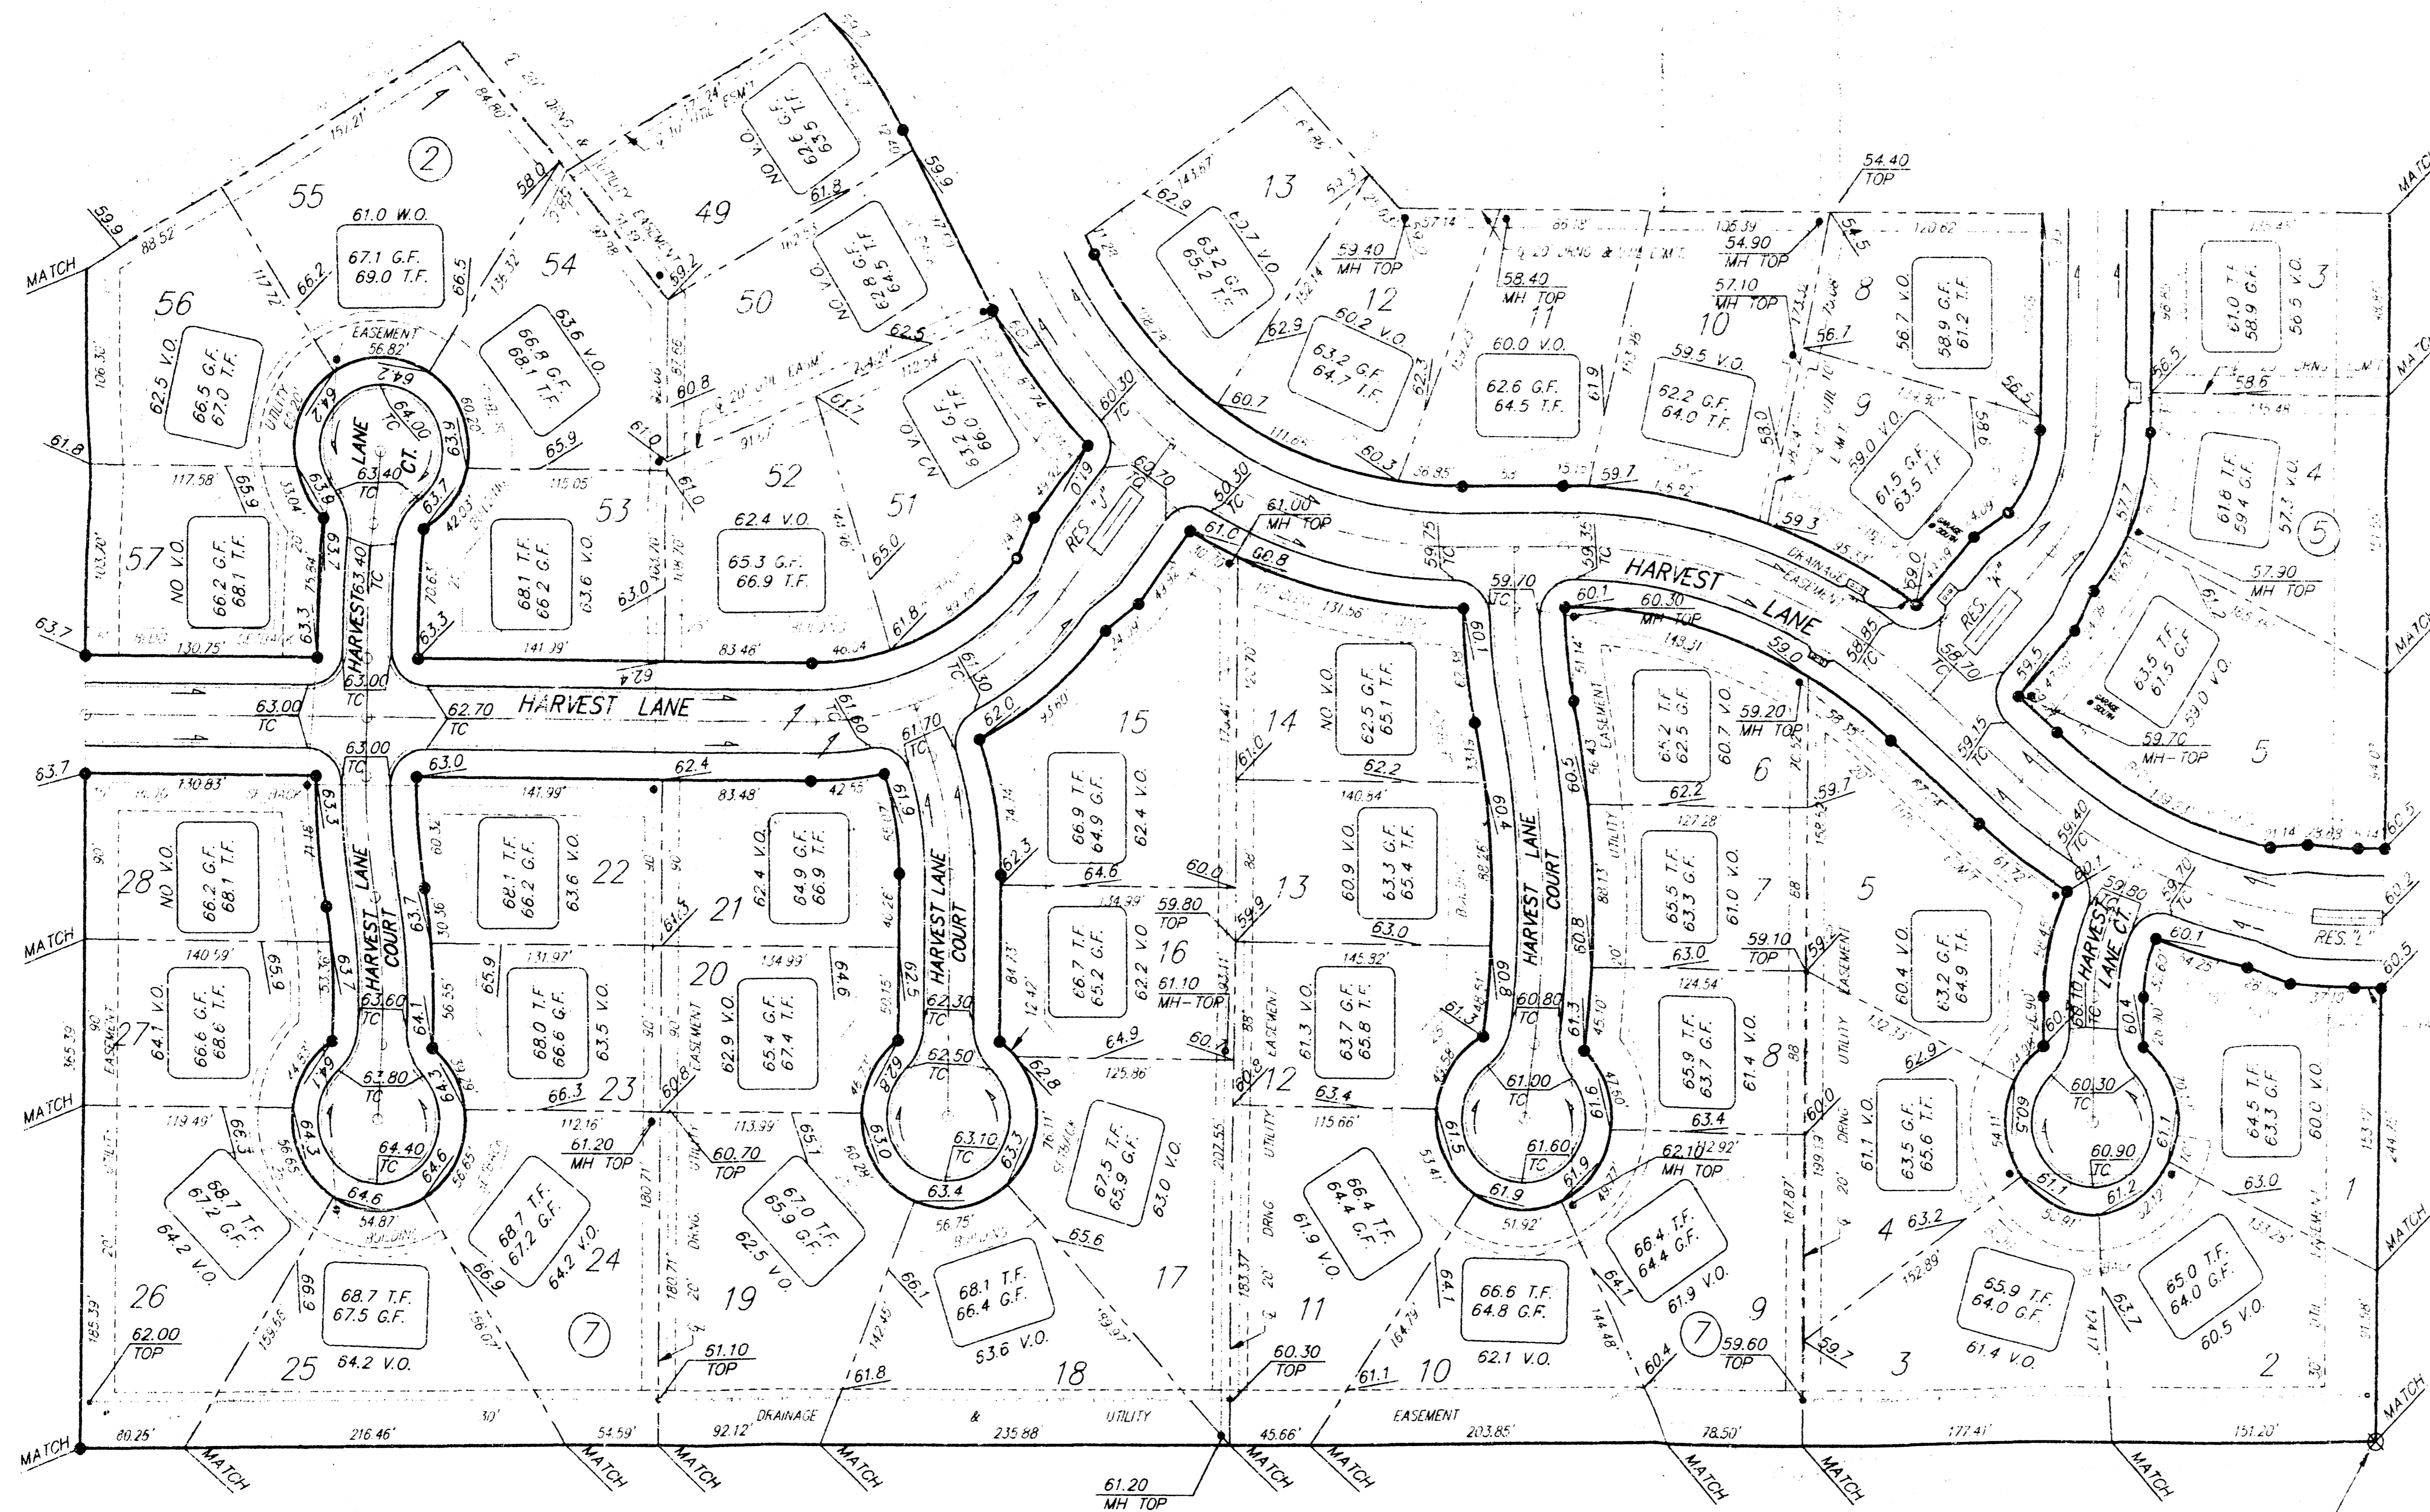

SCALE: 1"=60'

BAUGHMAN COMPANY P.A.  
 ENGINEERS, SURVEYORS & PLANNERS  
 1000 W. 44th Street, Suite 100  
 Lincoln, Nebraska 68502  
 (402) 441-1111  
 www.baughmanpa.com

**LOT GRADING PLAN**

BAUGHMAN COMPANY P.A.  
 ENGINEERS, SURVEYORS & PLANNERS

DESIGN	DRAWN	APPROVED	DATE	SCALE	SHEET
					3

SE CORNER NW 1/4  
 SEC. 13, TWP. 27-S, R-2-W