

11/17/78



APPROVED

REMARKS

By *J.P. Kelly* Date 11-17-78

Concur *Y.A. ...* 11/17/78

Concur *M. ...* 11/21/78

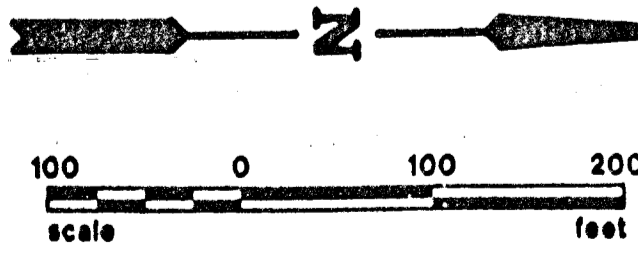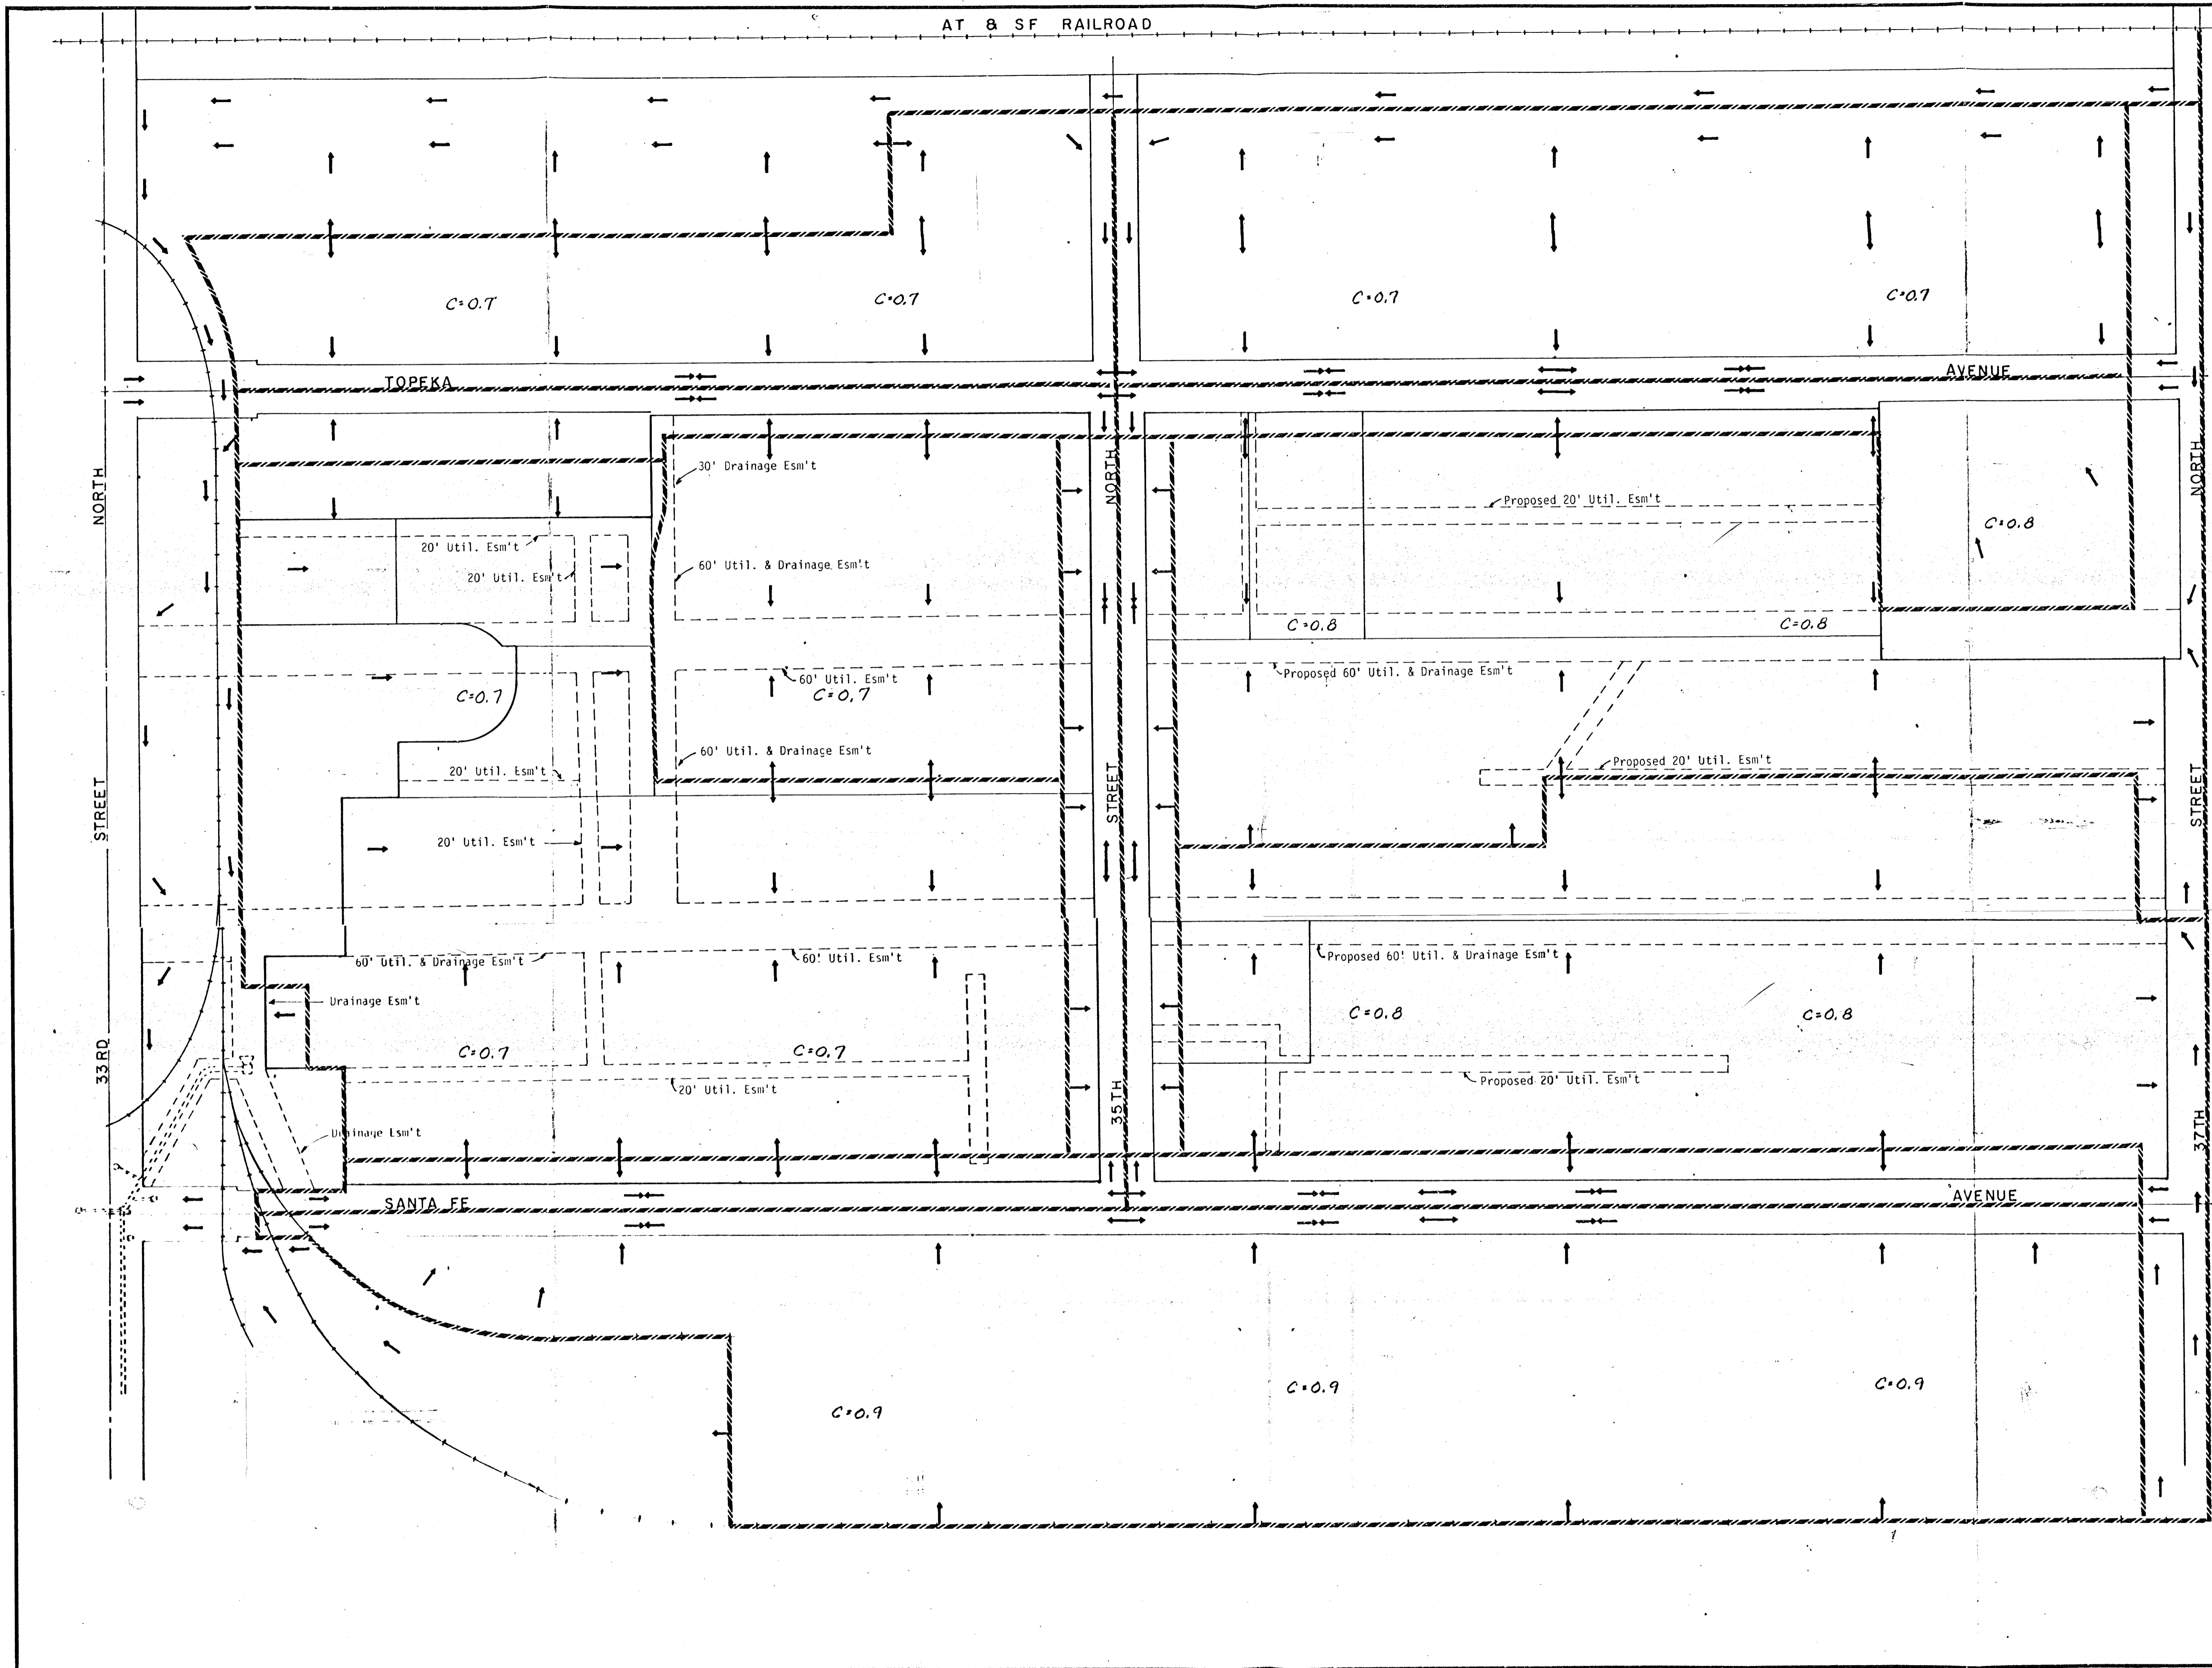

dp	WICHITA U.R.A. Bridgeport Ind. Park I	
	Drainage Plan	
ENGINEER T.J.T.	ENG. TECH. J.W.	
DRAWN BY J.W.	SCALE NOTED	
DATE: NOV. 1978	SHEET 1	OF 1

POE & ASSOCIATES
CONSULTING ENGINEERS