




NOTE: PRIVATE ONSITE SWS LAYOUT AND SIZES WILL BE DETERMINED ONCE THE FINAL SITE LAYOUT IS DETERMINED.

LEGEND

- P - GAS PIPELINE
- UGT - TELEPHONE LINE
- UGE - UNDERGROUND ELEC.
- OHE - OVERHEAD ELECTRIC
- FOC - FIBER OPTIC CABLE
- DSB - DRAINAGE SUB BASIN
- DB - DRAINAGE BASIN
- FA - FLOW ARROW
- A17 - AREA FOR SWS SIZING
- EC - EXISTING CONTOURS
- PC - PROPOSED CONTOURS
- PSW - PROPOSED SANITARY
- PSTW - PROPOSED STORM WATER
- PW - PROPOSED WATER
- CT - CONIFEROUS TREE
- DT - DECIDUOUS TREE
- SN - SIGN
- PP - POWER POLE
- EB - ELECTRIC BOX
- LP - LIGHT POLE
- FH - FIRE HYDRANT
- WV - WATER VALVE
- WM - WATER METER
- SC - SECTION CORNER
- BM - BENCHMARK
- E - EASEMENT
- BS - BUILDING SETBACK
- F - FENCE
- SSP - STORM SEWER PIPE
- WL - WATER LINE
- SSL - SANITARY SEWER LINE
- GL - GAS LINE

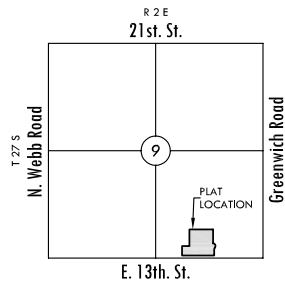

 VICINITY MAP

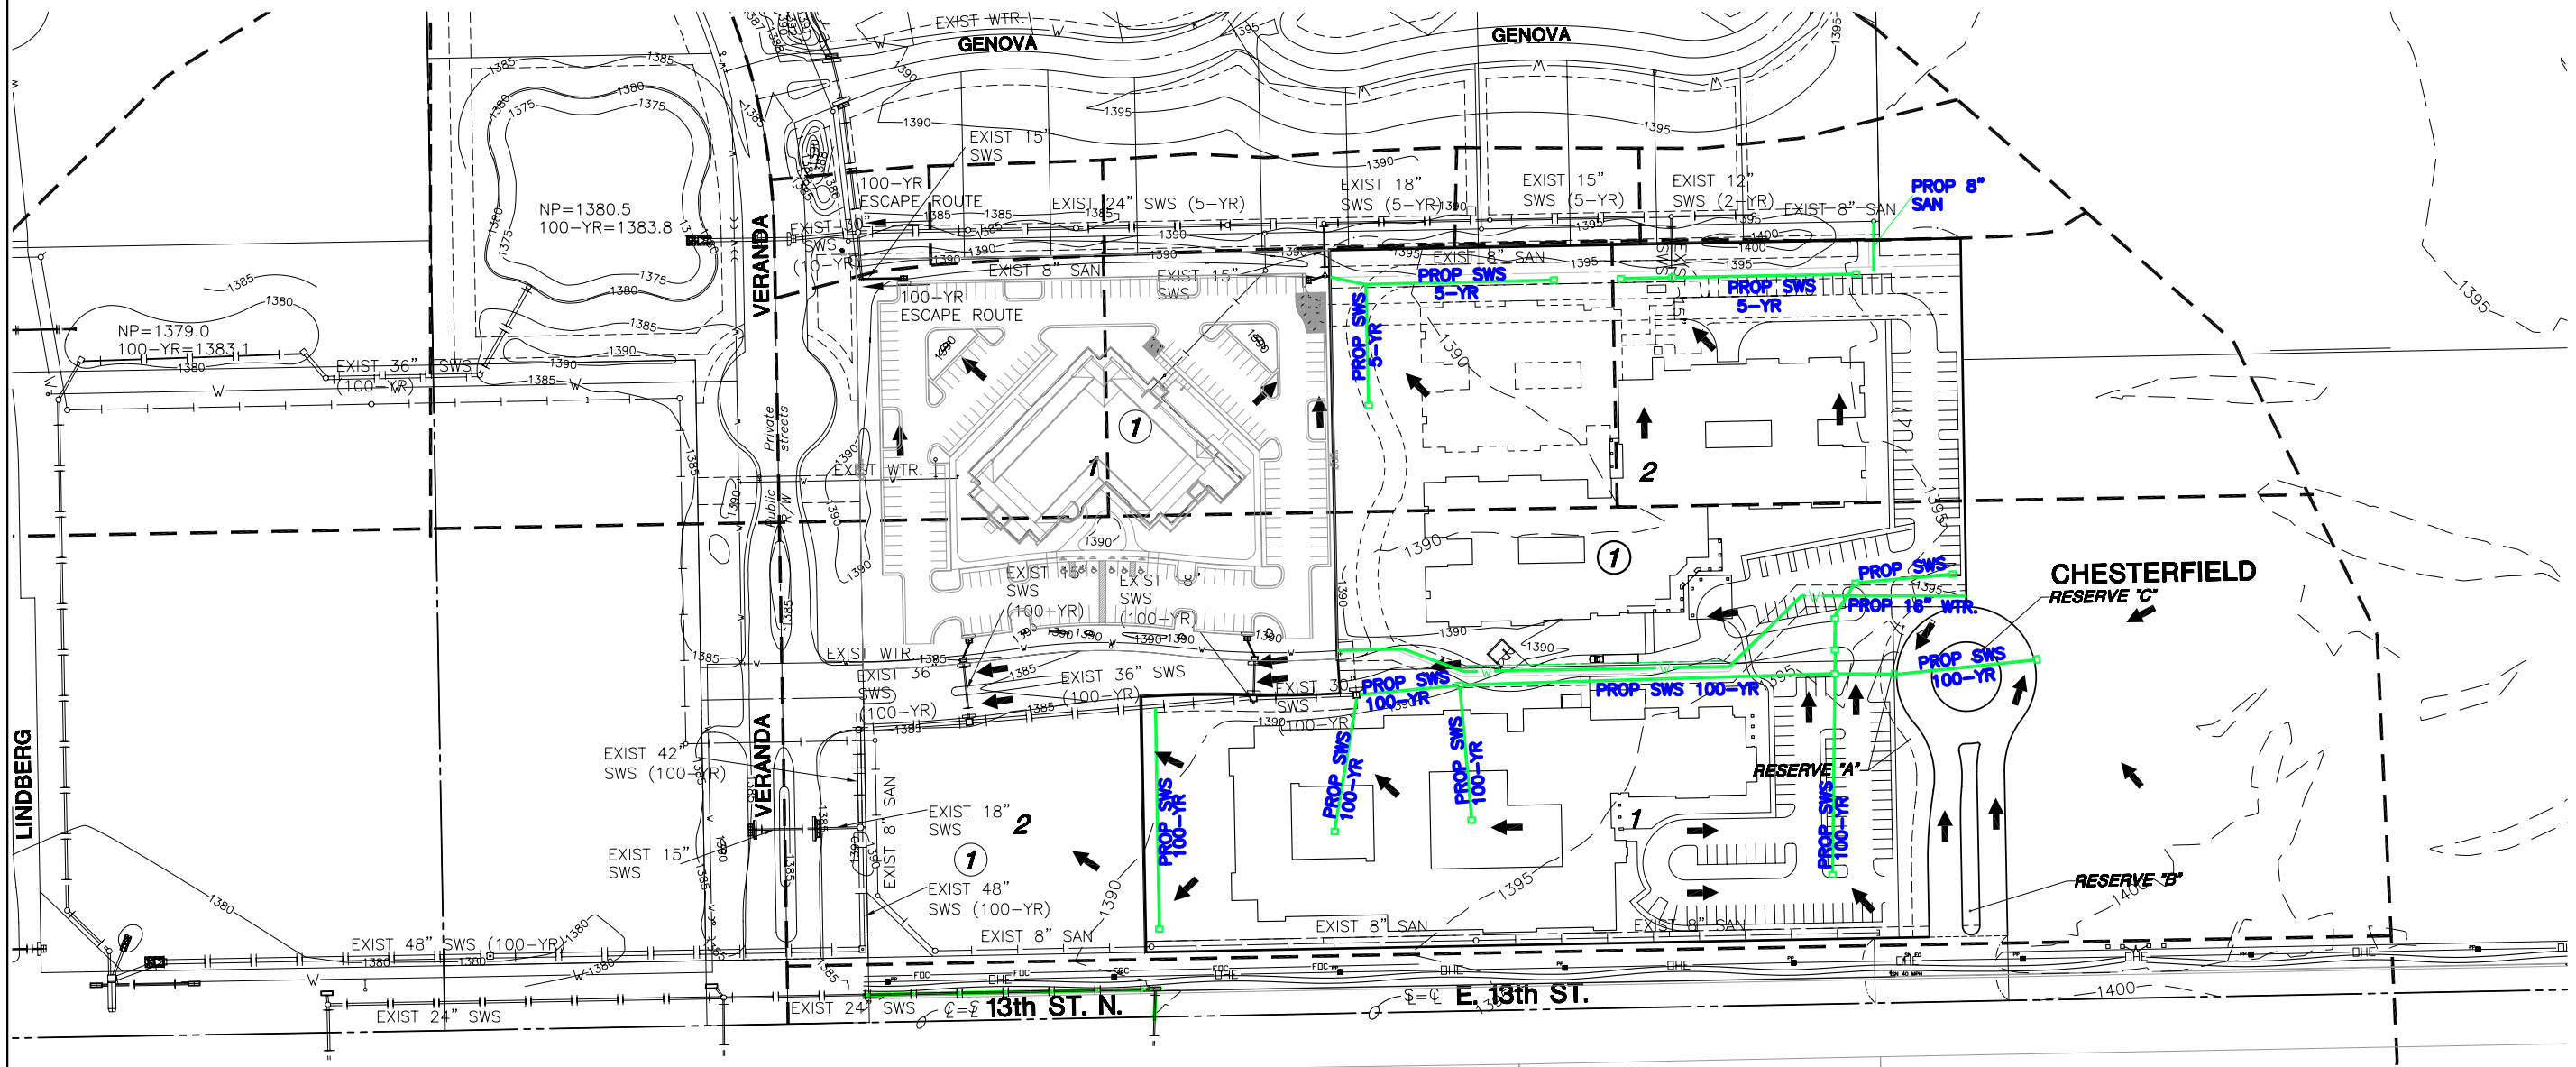

MKEC
ENGINEERING
CONSULTANTS, INC.
411 N. WEBB ROAD
WICHITA, KS. 67206
316-684-9600

GREENWICH OFFICE PARK 2ND
WICHITA, KANSAS
DRAINAGE PLAN

DATE	October 10
REVISED	10-19-10
	10-20-10

DESIGN BY	KLA
DRAWN BY	CMJ
CHECKED BY	GJA

SHEET NUMBER
1

J:\Civil\07063\Dwg_Draining\07063_DUP.dwg