

MKEC
ENGINEERING
CONSULTANTS, INC.

411 N. WEBB ROAD
WICHITA, K.S. 67206
316 - 684 - 9600

EOD DISPOSAL FACILITY

SITE PLAN


SHEET TITLE
PROJECT NUMBER
06530

DESIGNED BY
DRAWN BY
CHECKED BY



ISSUED
November 2006

REVISIONS

SHEET NO.
3 of 7

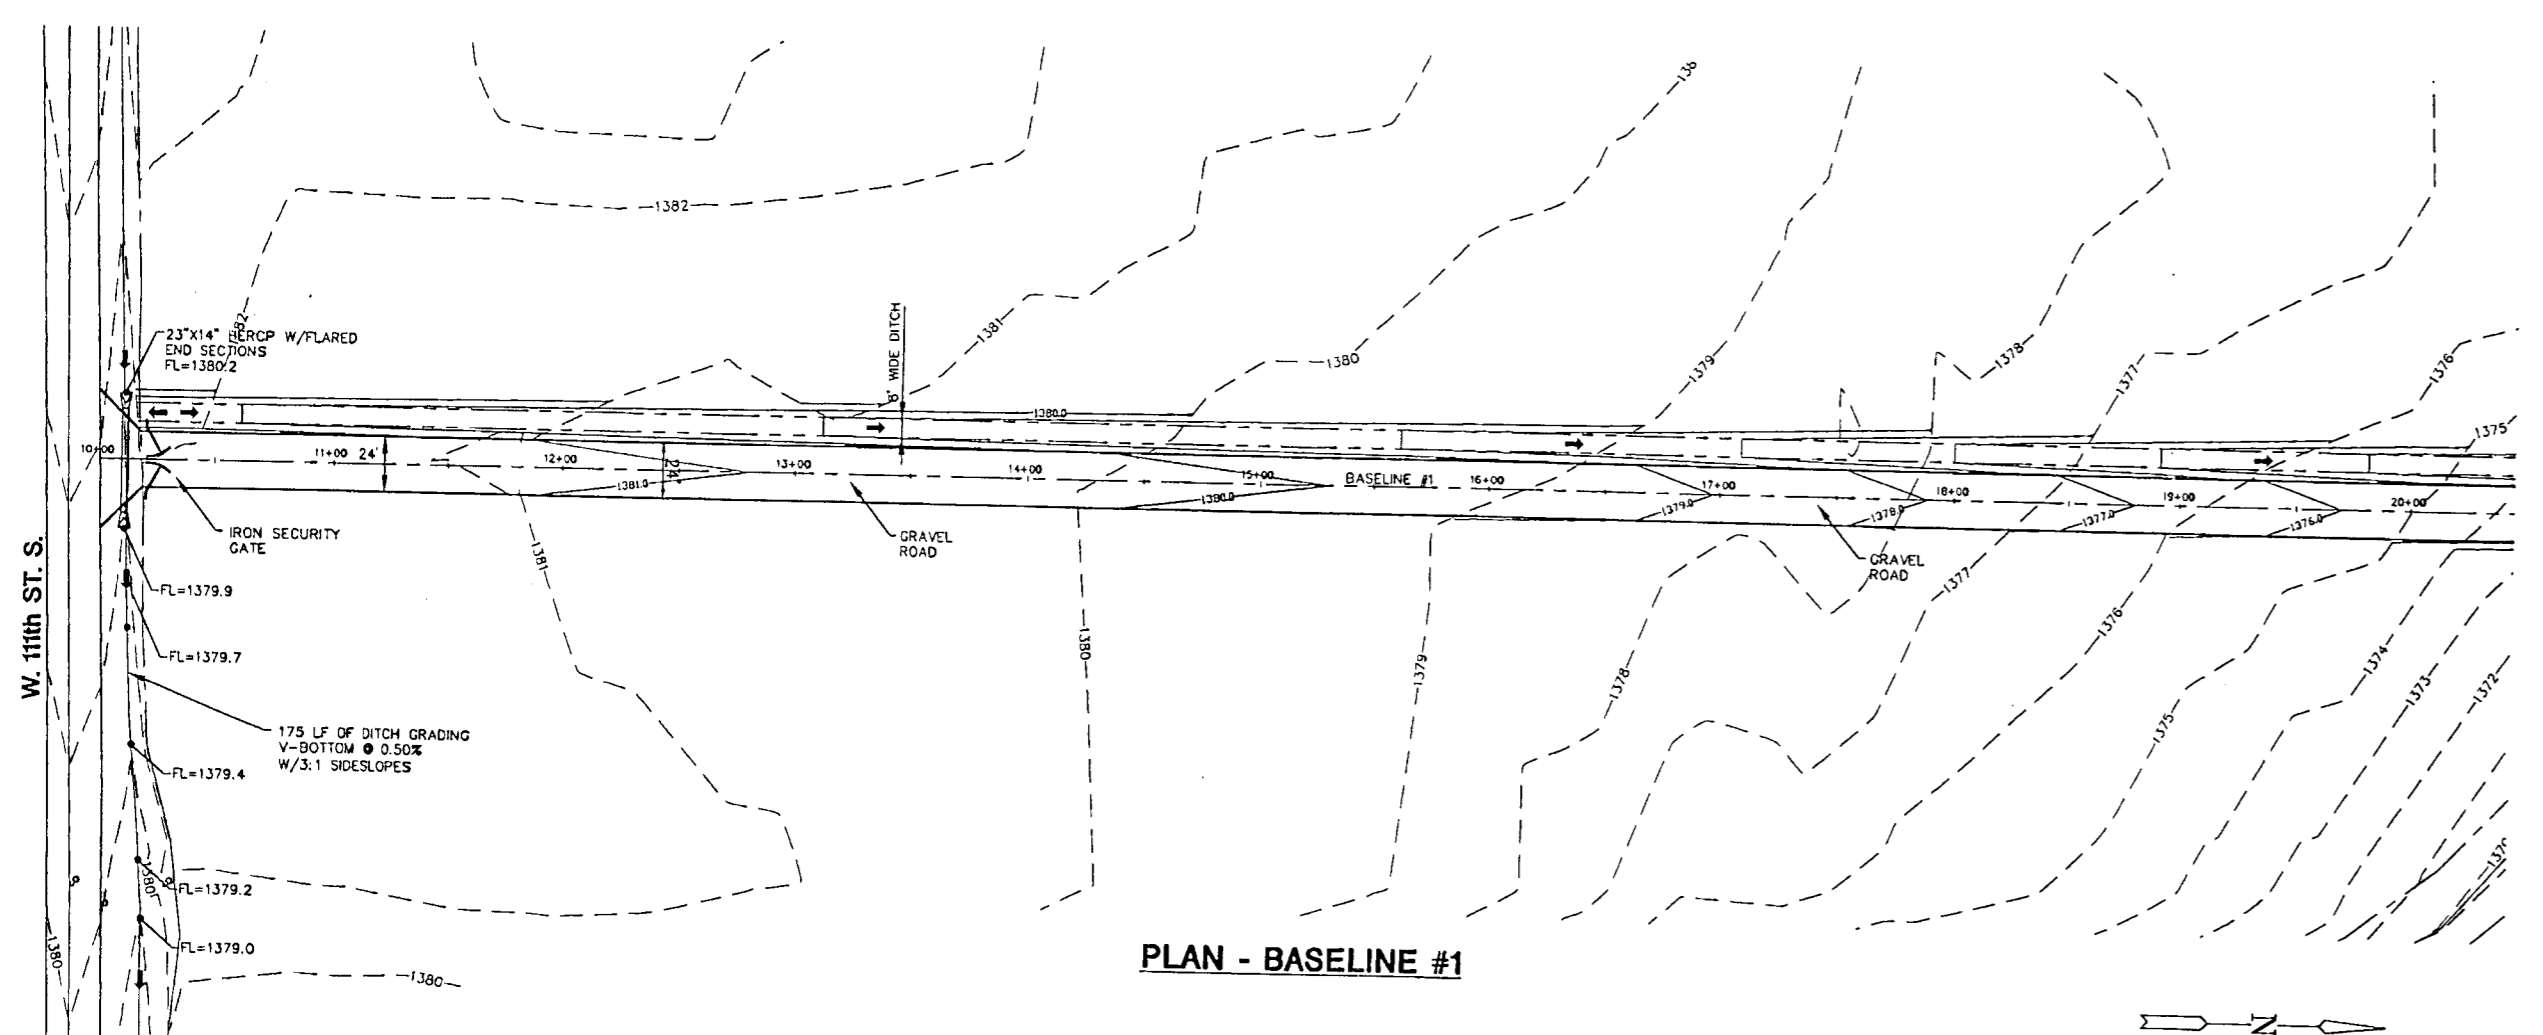

PLAN - BASELINE #1

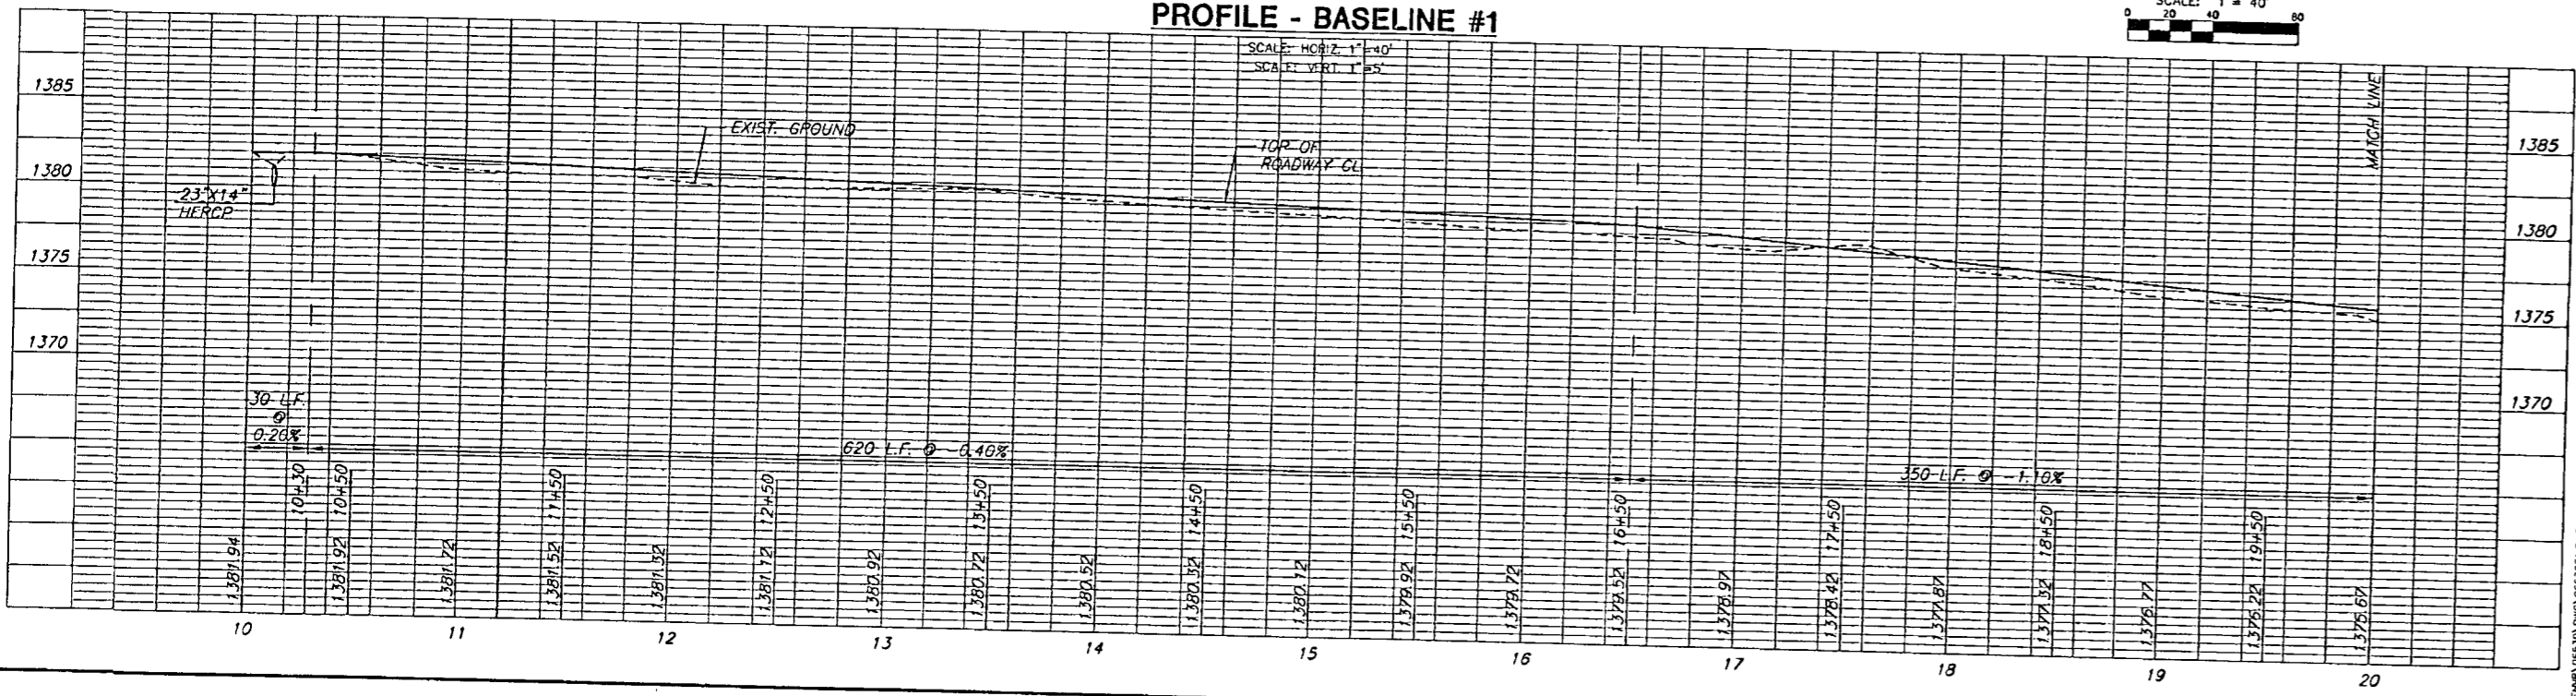 

PROFILE - BASELINE #1

L:\DWG\06530\DWG\06530_S03.DWG