
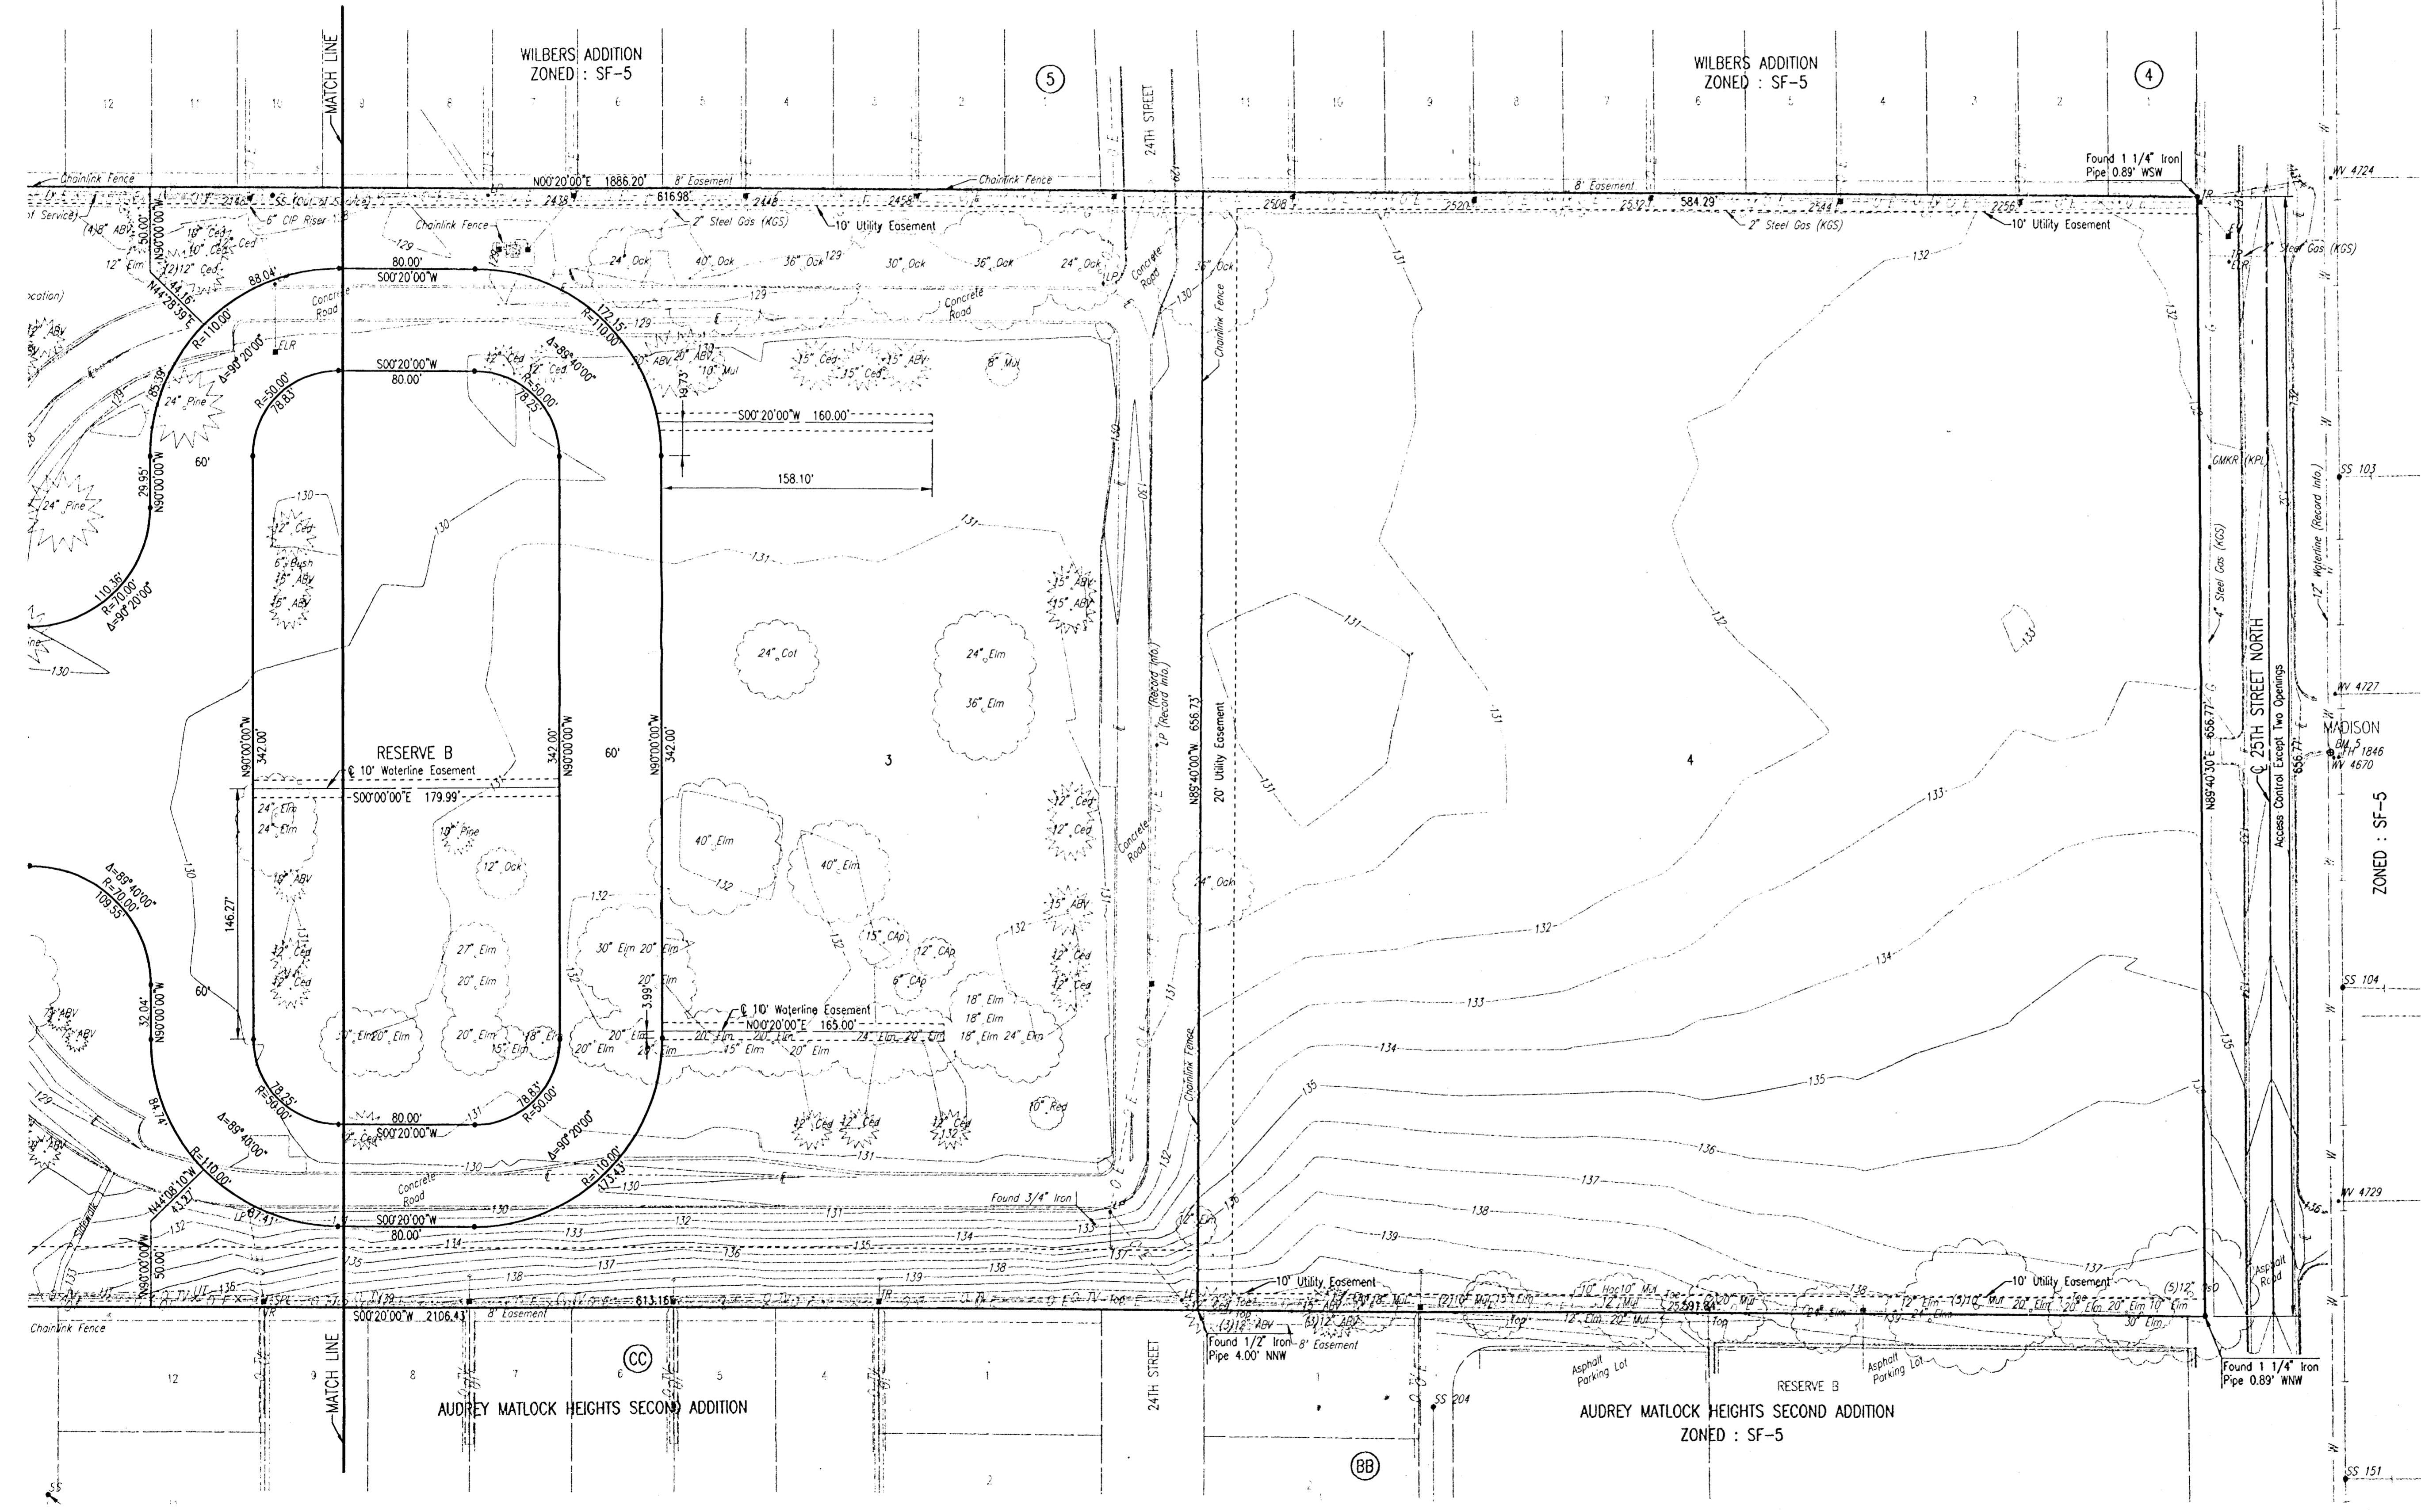


21ST STREET KIDS AND FAMILY EMPOWERMENT

AN ADDITION TO WICHITA, SEDGWICK COUNTY, KANSAS


 SCALE: 1" = 50'
 DATE OF SURVEY: JUNE 2005
 • = 1/2" REBAR W/PEC CAP UNLESS OTHERWISE NOTED



LEGEND

	Sign
	Bench Mark/Vertical Control Point
	Electrical Riser
	Electrical Yard Light
	Electrical Meter
	Light Pole
	Deadman
	Power Pole
	Transformer
	Gas Line Marker
	Sanitary Sewer Manhole
	Storm Water Sewer Manhole
	Storm Water Drain Area Inlet
	Storm Water Drain Curb Inlet
	Telephone Riser
	Telephone Pedestal
	Fire Hydrant
	Water Meter
	Water Valve
	Masonry Fence/Wall
	Fence Types
	Overhead Cable TV Line
	Overhead Electric Line
	Overhead Telephone Line
	Buried Telephone Line
	Gas Line
	Sanitary Sewer Line
	Storm Water Sewer Line
	Waterline

USNR: RMH OPER: JLS SCALE: 1"=50.00
 Q: 2005\05389\LD0\dwg\05389 - One Step Pg 3 08-29-2005 08:20:39 am