
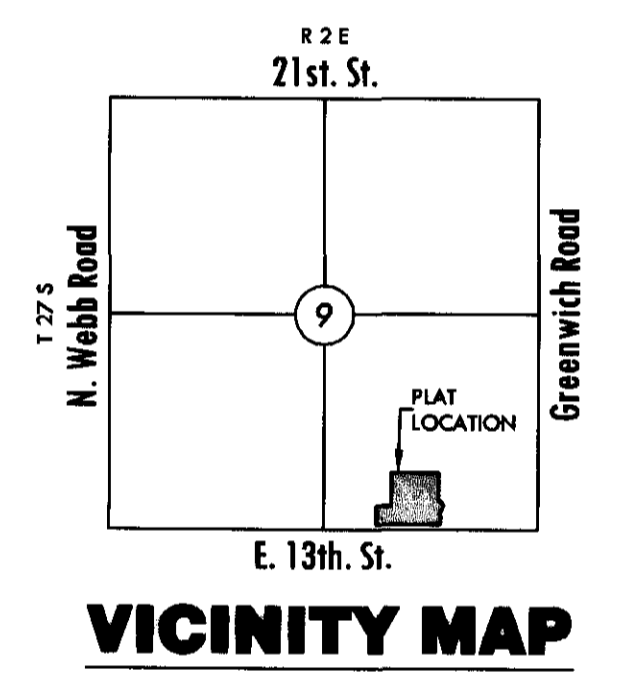
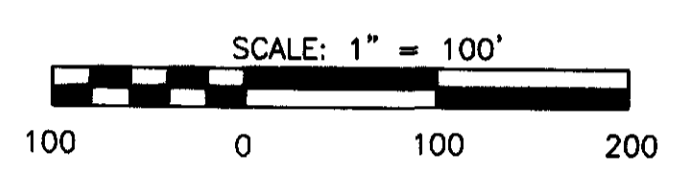


GREENWICH OFFICE PARK 2ND
WICHITA, KANSAS
DRAINAGE PLAN

DATE
October 10
REVISED

DESIGN BY
KLA
DRAWN BY
CMJ
CHECKED BY
GJA

SHEET NUMBER
1

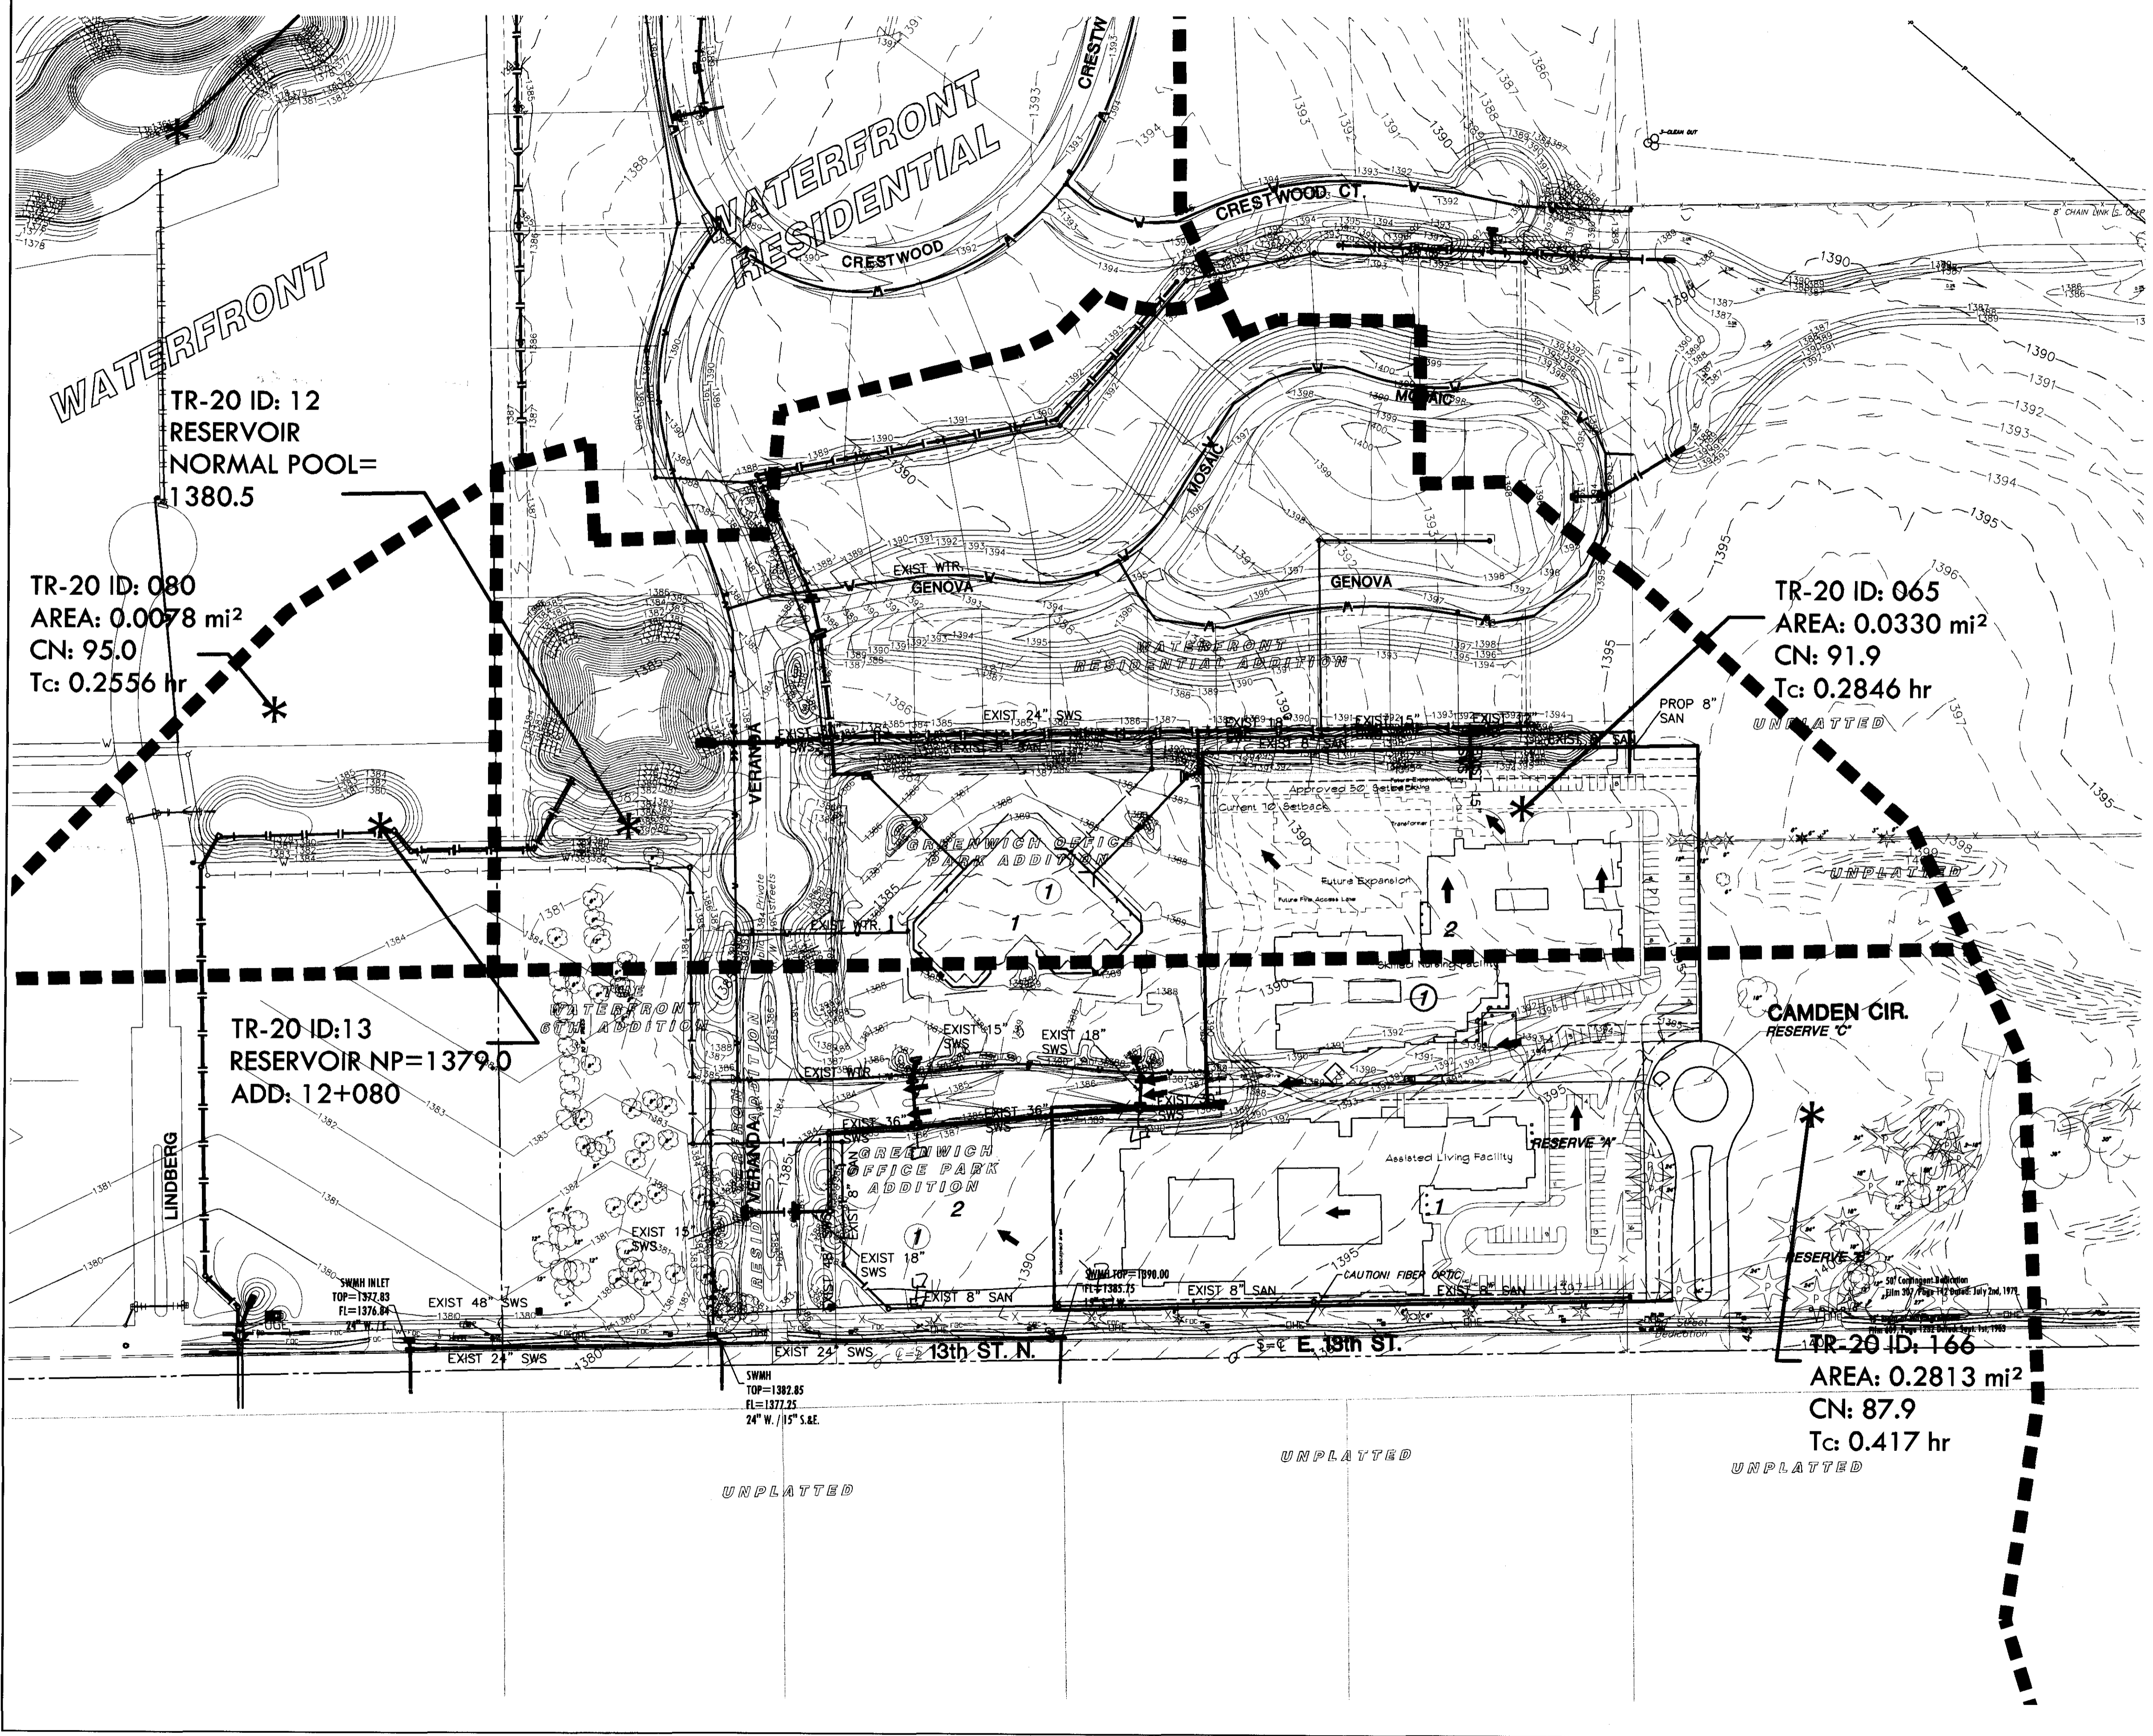

LEGEND

- CN - CONIFEROUS TREE
- DN - DECIDUOUS TREE
- SN - SIGN
- PP - POWER POLE
- ELEC - ELECTRIC BOX
- LP - LIGHT POLE
- FH - FIRE HYDRANT
- WV - WATER VALVE
- WM - WATER METER
- SC - SECTION CORNER
- BM - BENCHMARK
- - - - - EASEMENT
- - - - - BUILDING SETBACK
- - - - - FENCE
- - - - - STORM SEWER PIPE
- - - - - WATER LINE
- - - - - SANITARY SEWER LINE
- - - - - GAS LINE
- - - - - GAS PIPELINE
- - - - - TELEPHONE LINE
- - - - - UNDERGROUND ELEC.
- - - - - OVERHEAD ELECTRIC
- - - - - FIBER OPTIC CABLE
- - - - - DRAINAGE SUB BASIN
- - - - - DRAINAGE BASIN
- - - - - FLOW ARROW
- - - - - AREA FOR SWS SIZING
- - - - - EXISTING CONTOURS
- - - - - PROPOSED CONTOURS

NOTE: PRIVATE ONSITE SWS LAYOUT AND SIZES WILL BE DETERMINED ONCE THE FINAL SITE LAYOUT IS DETERMINED.

J:\Civil\07063\Draw\Drng\07063_DUP.dwg