
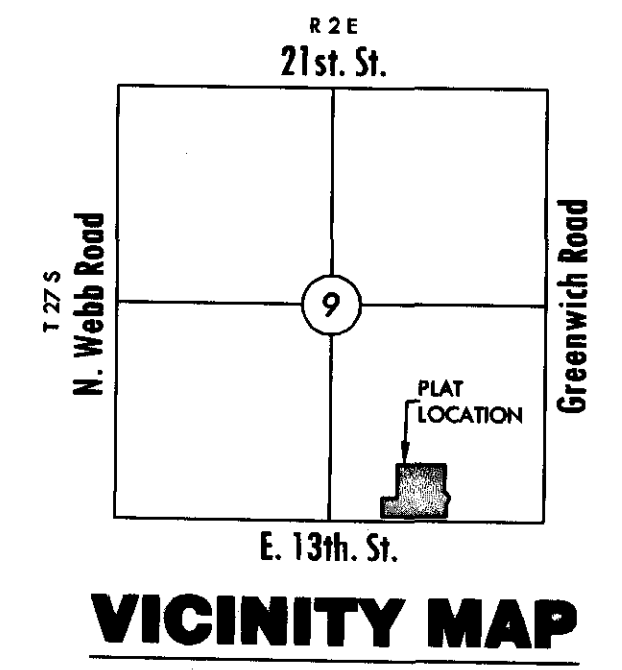
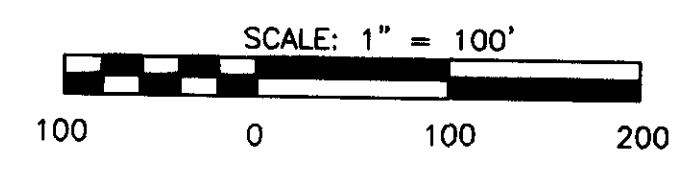
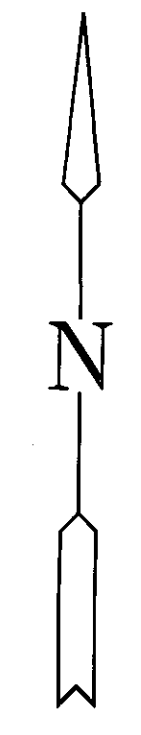


GREENWICH OFFICE PARK 2ND
 WICHITA, KANSAS
LOT GRADING PLAN

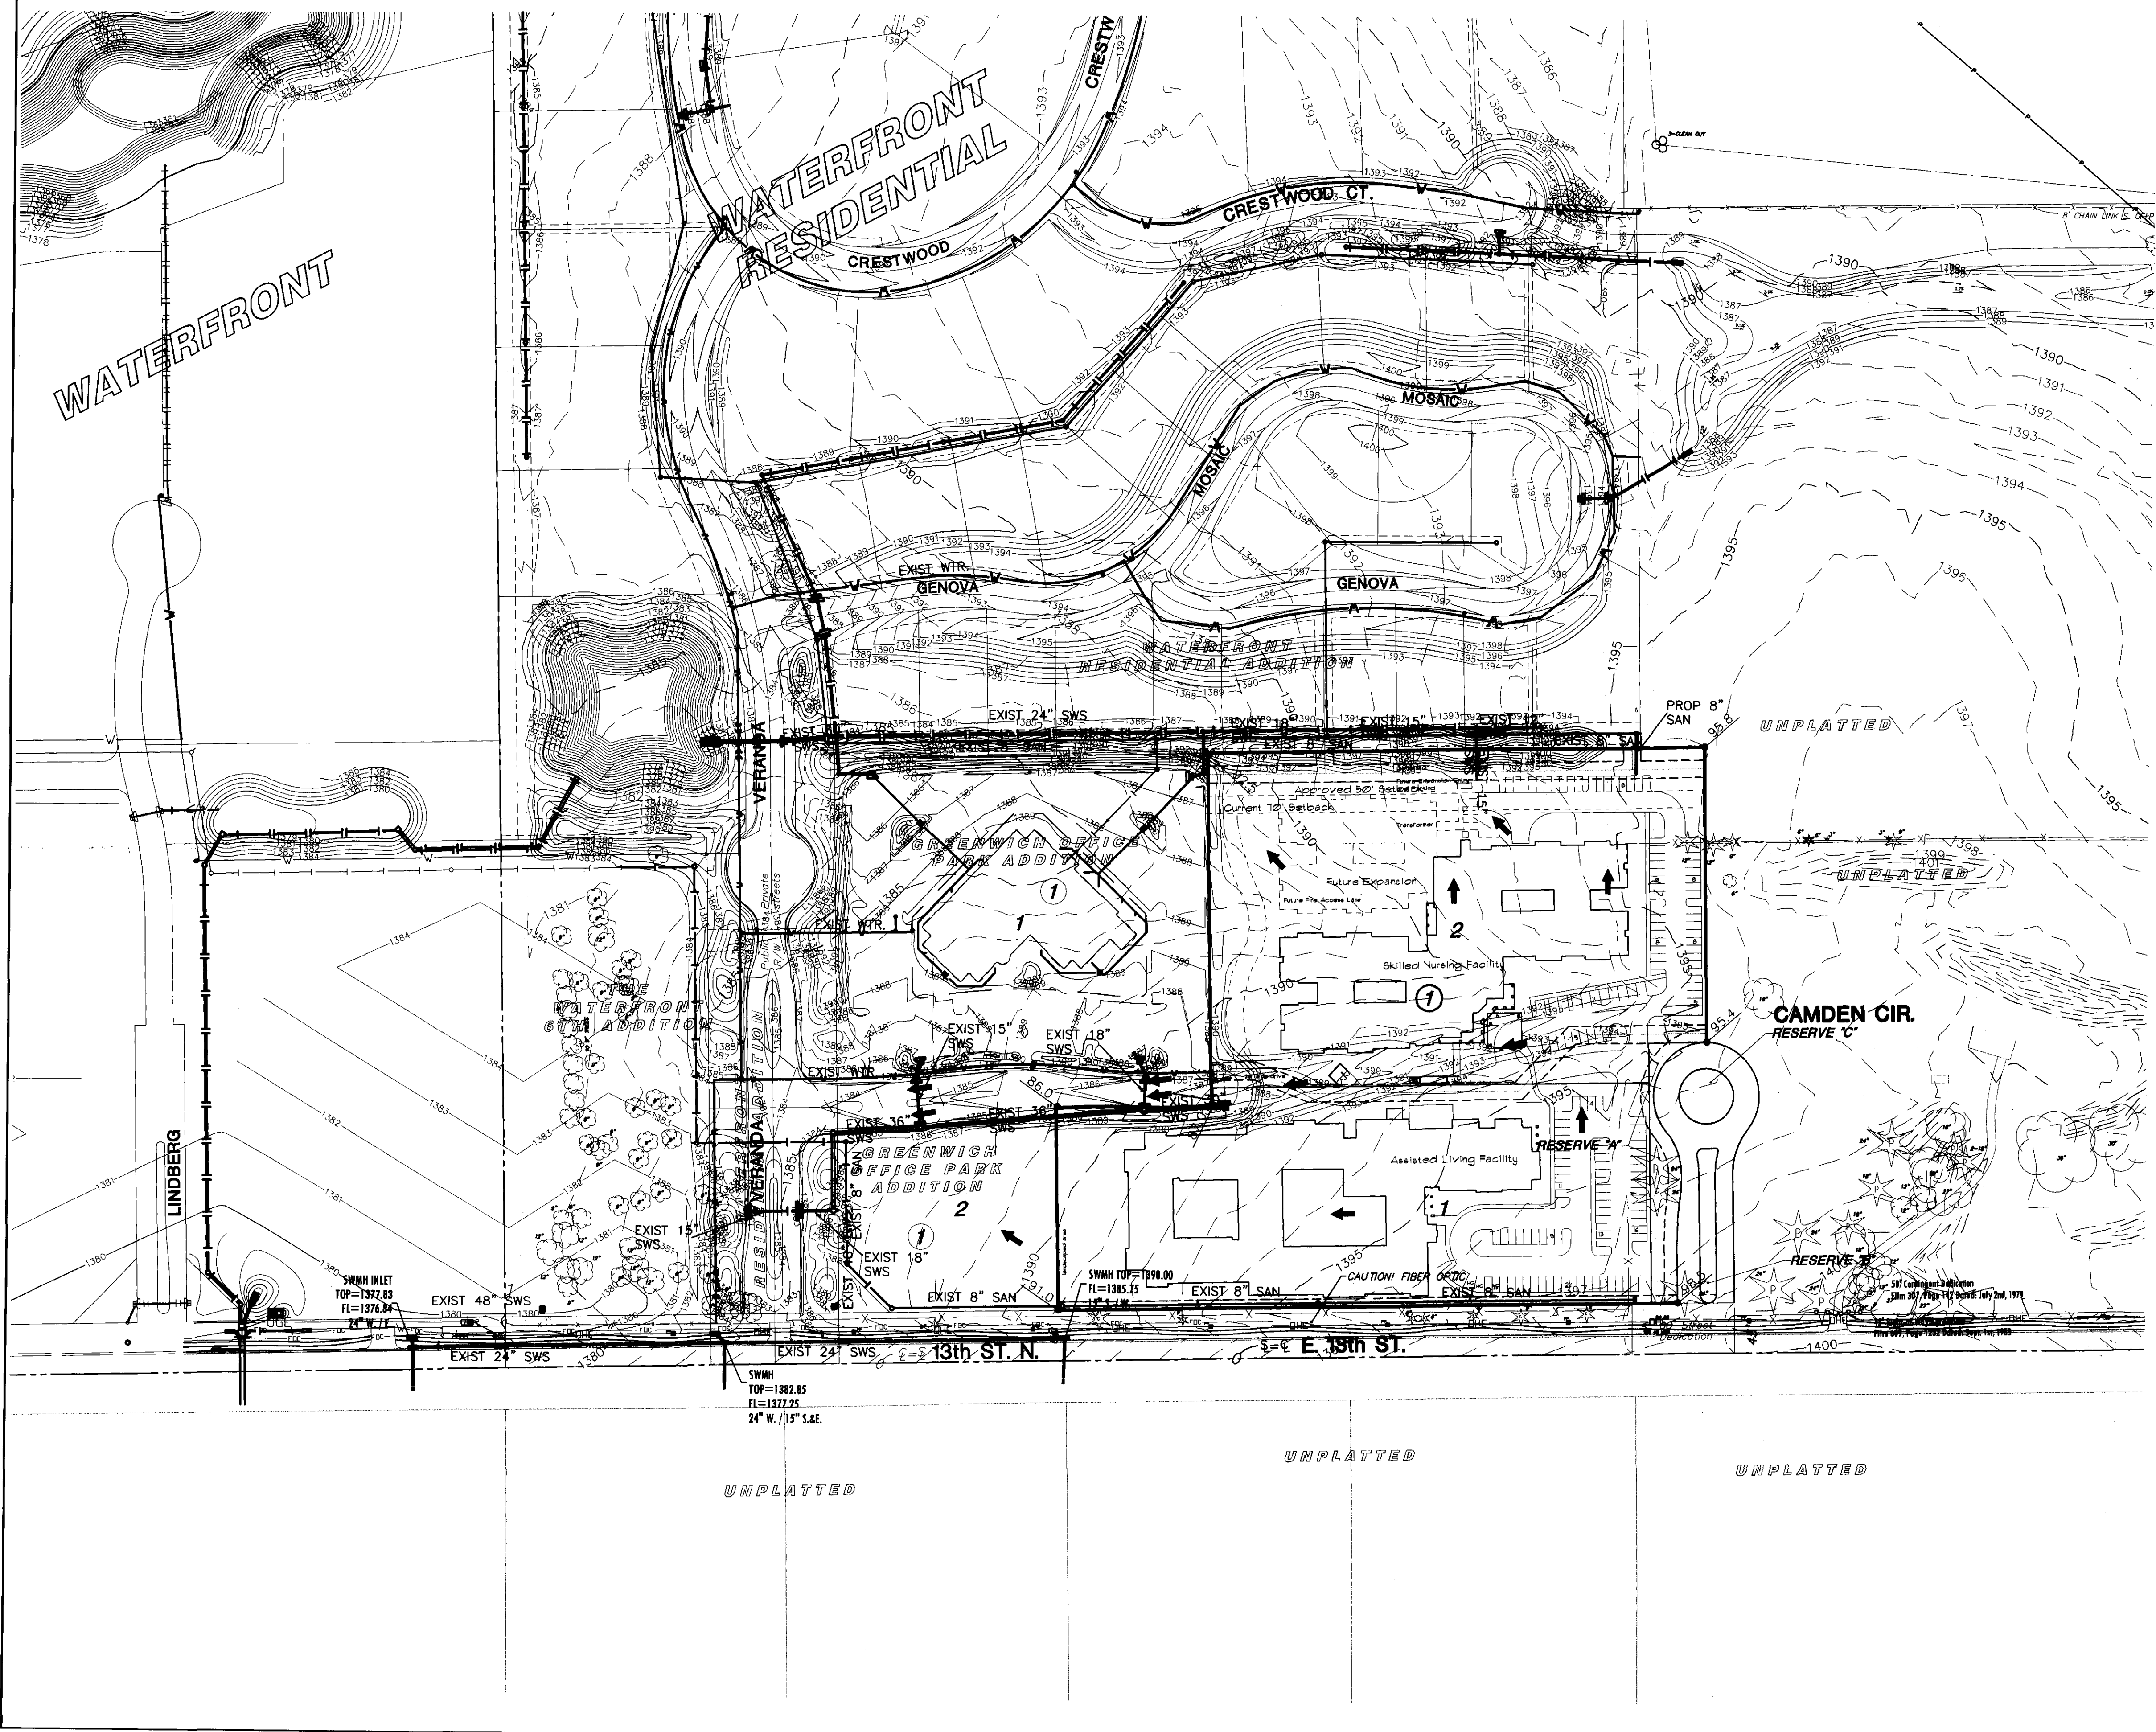

LEGEND

- ★ - CONIFEROUS TREE
- - DECIDUOUS TREE
- SN - SIGN
- PP - POWER POLE
- ELEC BOX - ELECTRIC BOX
- LP - LIGHT POLE
- FH - FIRE HYDRANT
- WV - WATER VALVE
- WM - WATER METER
- △ - SECTION CORNER
- BM - BENCHMARK
- - EASEMENT
- - - - BUILDING SETBACK
- - - - FENCE
- - - - STORM SEWER PIPE
- - - - WATER LINE
- - - - SANITARY SEWER LINE
- - - - GAS LINE
- - - - GAS PIPELINE
- - - - TELEPHONE LINE
- - - - UNDERGROUND ELEC.
- - - - OVERHEAD ELECTRIC
- - - - FIBER OPTIC CABLE
- 98.5 - ELEVATION
- ➔ - FLOW ARROW
- - - - EXISTING CONTOURS
- - - - PROPOSED CONTOURS

NOTE: PRIVATE ONSITE SWS LAYOUT AND SIZES WILL BE DETERMINED ONCE THE FINAL SITE LAYOUT IS DETERMINED.

DATE	October 10
REVISED	

DESIGN BY	KLA
DRAWN BY	CMJ
CHECKED BY	GJA

SHEET NUMBER	1
--------------	---

J:\Civil\07063.Dwg\Orig\07063_LGP.dwg