



DRAINAGE PLAN
SWEETBRIAR SECOND ADDITION
PHASE 1

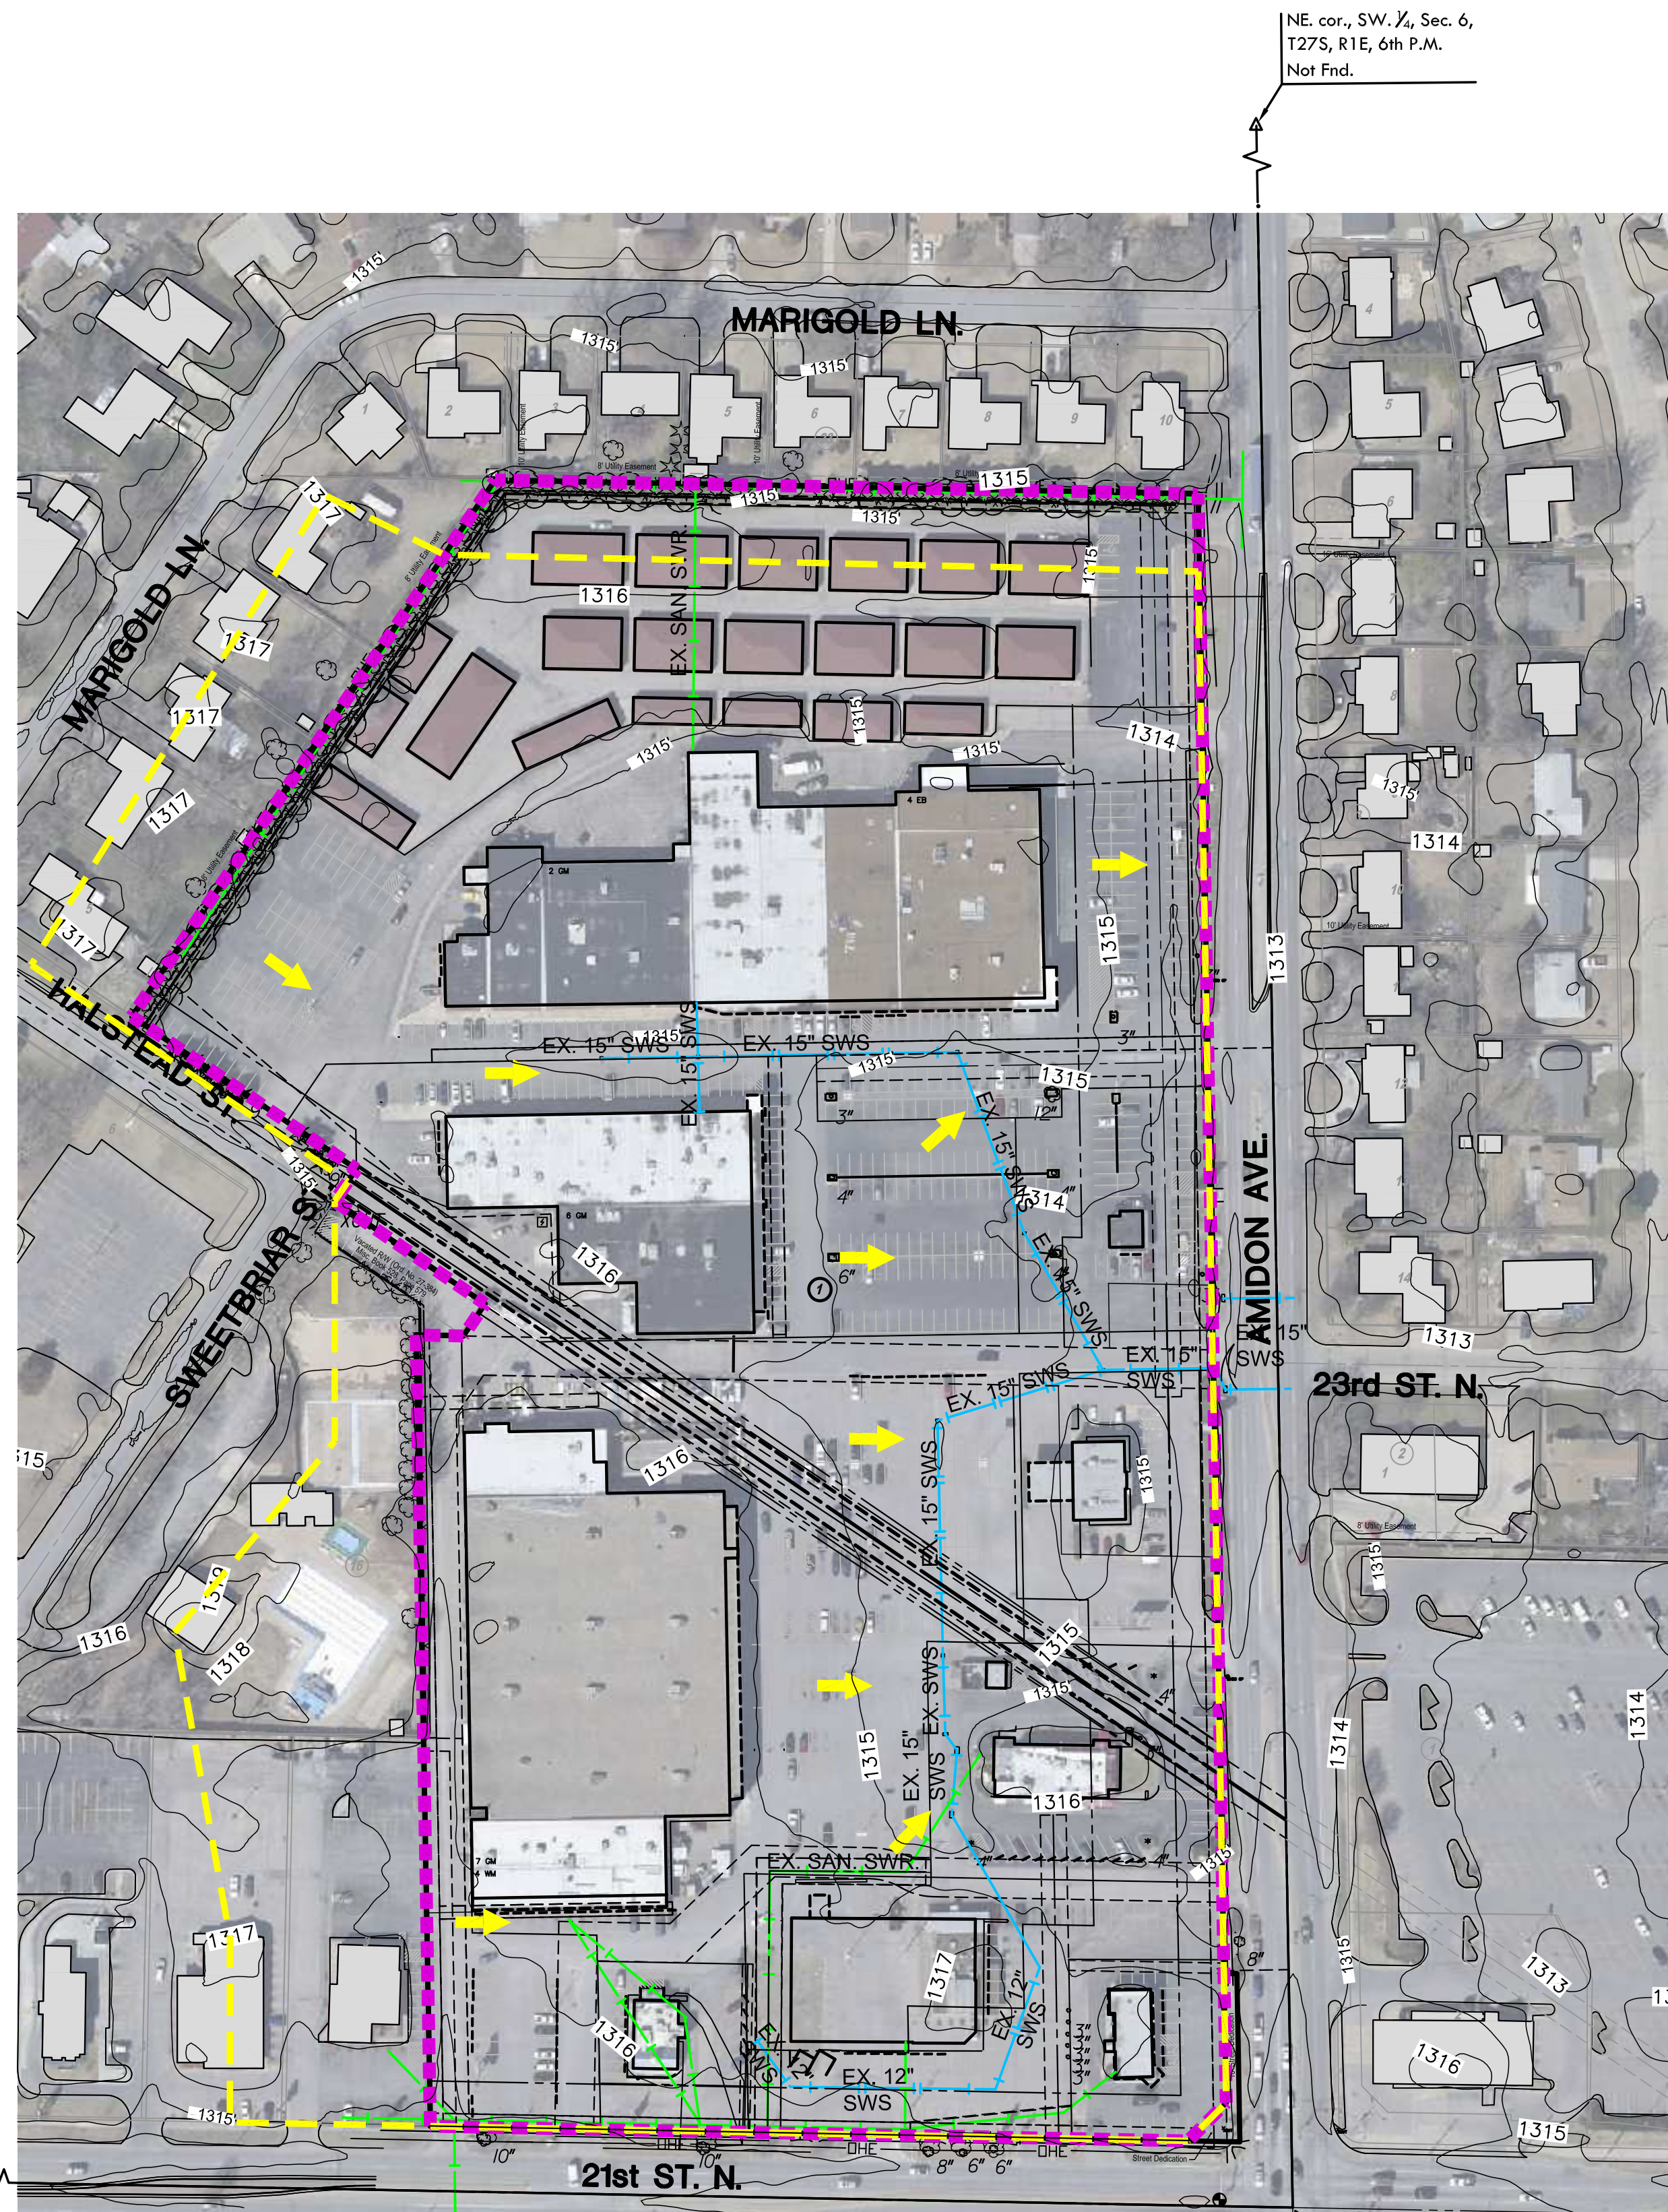

SW. cor., SW. 1/4, Sec. 6,
T27S, R1E, 6th P.M.
Fnd. Thimble no rebar

NE. cor., SW. 1/4, Sec. 6,
T27S, R1E, 6th P.M.
Not Fnd.

SE. cor., SW. 1/4, Sec. 6,
T27S, R1E, 6th P.M.
Fnd. 3/8" Pipe w/o id cap

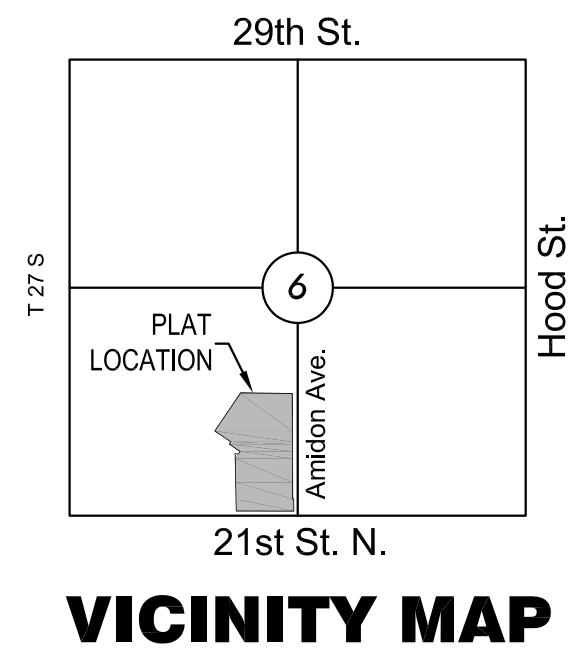

LEGEND

- CONIFEROUS TREE
- EASEMENT
- DECIDUOUS TREE
- BUILDING SETBACK
- SIGN
- FENCE
- POWER POLE
- STORM SEWER PIPE
- ELECTRIC BOX
- WATER LINE
- LIGHT POLE
- SANITARY SEWER LINE
- FIRE HYDRANT
- GAS LINE
- WATER VALVE
- GAS PIPELINE
- WATER METER
- TELEPHONE LINE
- SECTION CORNER
- UNDERGROUND ELEC.
- BENCHMARK
- OVERHEAD ELECTRIC
- FIBER OPTIC CABLE
- FLOW ARROW
- DRAINAGE SUB BASIN
- AREA FOR SWS SIZING
- MAJOR BASIN
- SITE BOUNDARY

BASIN	AREA (AC)	C	Q ₂	Q ₅	Q ₁₀	Q ₂₅	Q ₅₀	Q ₁₀₀
TO AMIDON	64.3	0.87	215	254	292	339	379	412

©2014
MKEC Engineering
All Rights Reserved
www.mkec.com
These drawings and their contents, including, but not limited to, all concepts, designs, & ideas are the exclusive property of MKEC Engineering (MKEC), and may not be used or reproduced in any way without the express consent of MKEC.

DRAINAGE PLAN

PROJECT NO.	1401020200	
DATE	OCTOBER 2014	
SCALE	#"=#"	
DESIGNED	DRAWN	CHECKED
KLA	NRF	-
NO.	REVISION	DATE

SHEET NO.
1 OF 1

