

THE WICHITA AIRPORT AUTHORITY
WICHITA, KANSAS

COLONEL JAMES JABARA AIRPORT

PLANS FOR
SOUTHWEST AREA SITE DEVELOPMENT UTILITY IMPROVEMENTS
SANITARY SEWER - CITY OF WICHITA PRIVATE PROJECT NO. 1674PPS (607861)

INDEX OF SHEETS

Sheet No. CS1.0	Sanitary Sewer Title Sheet
Sheet No. CS1.1	Sanitary Sewer Key Map and General Notes
Sheet No. CS1.2	4" Force Main Plan/Profile
Sheet No. CS1.3-1.4	Sanitary Sewer Plan/Profile
Sheet No. CS1.5	Lift Station and Mechanical Details
Sheet No. CS1.6	Standard Type "P" Manhole Details
Sheet No. CS1.7	Manhole Frame & Cover Details
Sheet No. CS1.8	Vertical Riser Details
Sheet No. E1.1	Electrical Symbols, General Notes, Schedules, & Details
Sheet No. E1.2	Electrical Details
Sheet No. E1.3	Electrical Site Plan
Sheet No. S1.1	Concrete Wall Details
Sheet No. CF1.0	Fencing Plan
Sheet No. CF1.1	Fence Details
Sheet No. CS0-5.3	Soil Erosion BMP Details

APPROVED AS NOTED
By CITY ENGINEER OF WICHITA

Sanitary Sewers VRH 7/28/06

Storm Sewers _____

Driveway Approaches _____

Paving _____

NOTE TO CONTRACTOR

INSPECTION AND TESTING FOR THIS PROJECT IS TO BE PROVIDED BY A LICENSED CONSULTING ENGINEERING FIRM CONTRACTED BY THE OWNER/DEVELOPER. SAID INSPECTION IS TO BE IN ACCORDANCE WITH THE CITY OF WICHITA STANDARD CONSTRUCTION ENGINEERING PRACTICES AND CERTIFIED BY A LICENSED PROFESSIONAL ENGINEER. NO WORK SHALL BE PERFORMED IN DEDICATED EASEMENTS OR PUBLIC RIGHT-OF-WAY BY THE CONTRACTOR UNTIL SUCH INSPECTION IS ARRANGED FOR AND REQUIRED BONDS HAVE BEEN SUBMITTED TO AND APPROVED BY THE CITY. NOR SHALL ANY WORK BE COMMENCED IN DEDICATED EASEMENTS OR PUBLIC RIGHT-OF-WAY WITHOUT WRITTEN AUTHORIZATION BY THE CITY ENGINEER. IMPROVEMENTS PERFORMED UNDER THIS PROJECT SHALL NOT BE ACCEPTED BY THE CITY UNTIL ALL APPLICABLE DOCUMENTATION HAS BEEN SUBMITTED TO THE CITY ENGINEER. THIS MAY INCLUDE: RECORD DRAWINGS, INSPECTION LOGS, TEST DOCUMENTATION, TV TAPES, AND A CERTIFICATE OF COMPLETION. THE ABOVE SHALL BE PERFORMED BY THE CONSULTING FIRM CONTRACTED TO INSPECT THIS PROJECT.

AIRPORT REFERENCE CODE (ARC) D - IX

APPROVED


THE WICHITA AIRPORT AUTHORITY

DIRECTOR OF AIRPORTS

AIRPORT ENGINEERING AND
PLANNING MANAGER



PLANS PREPARED BY
Professional Engineering Consultants, P.A.
303 S. TOPEKA • WICHITA, KANSAS 67202
316-262-2691 • FAX 316-262-3003

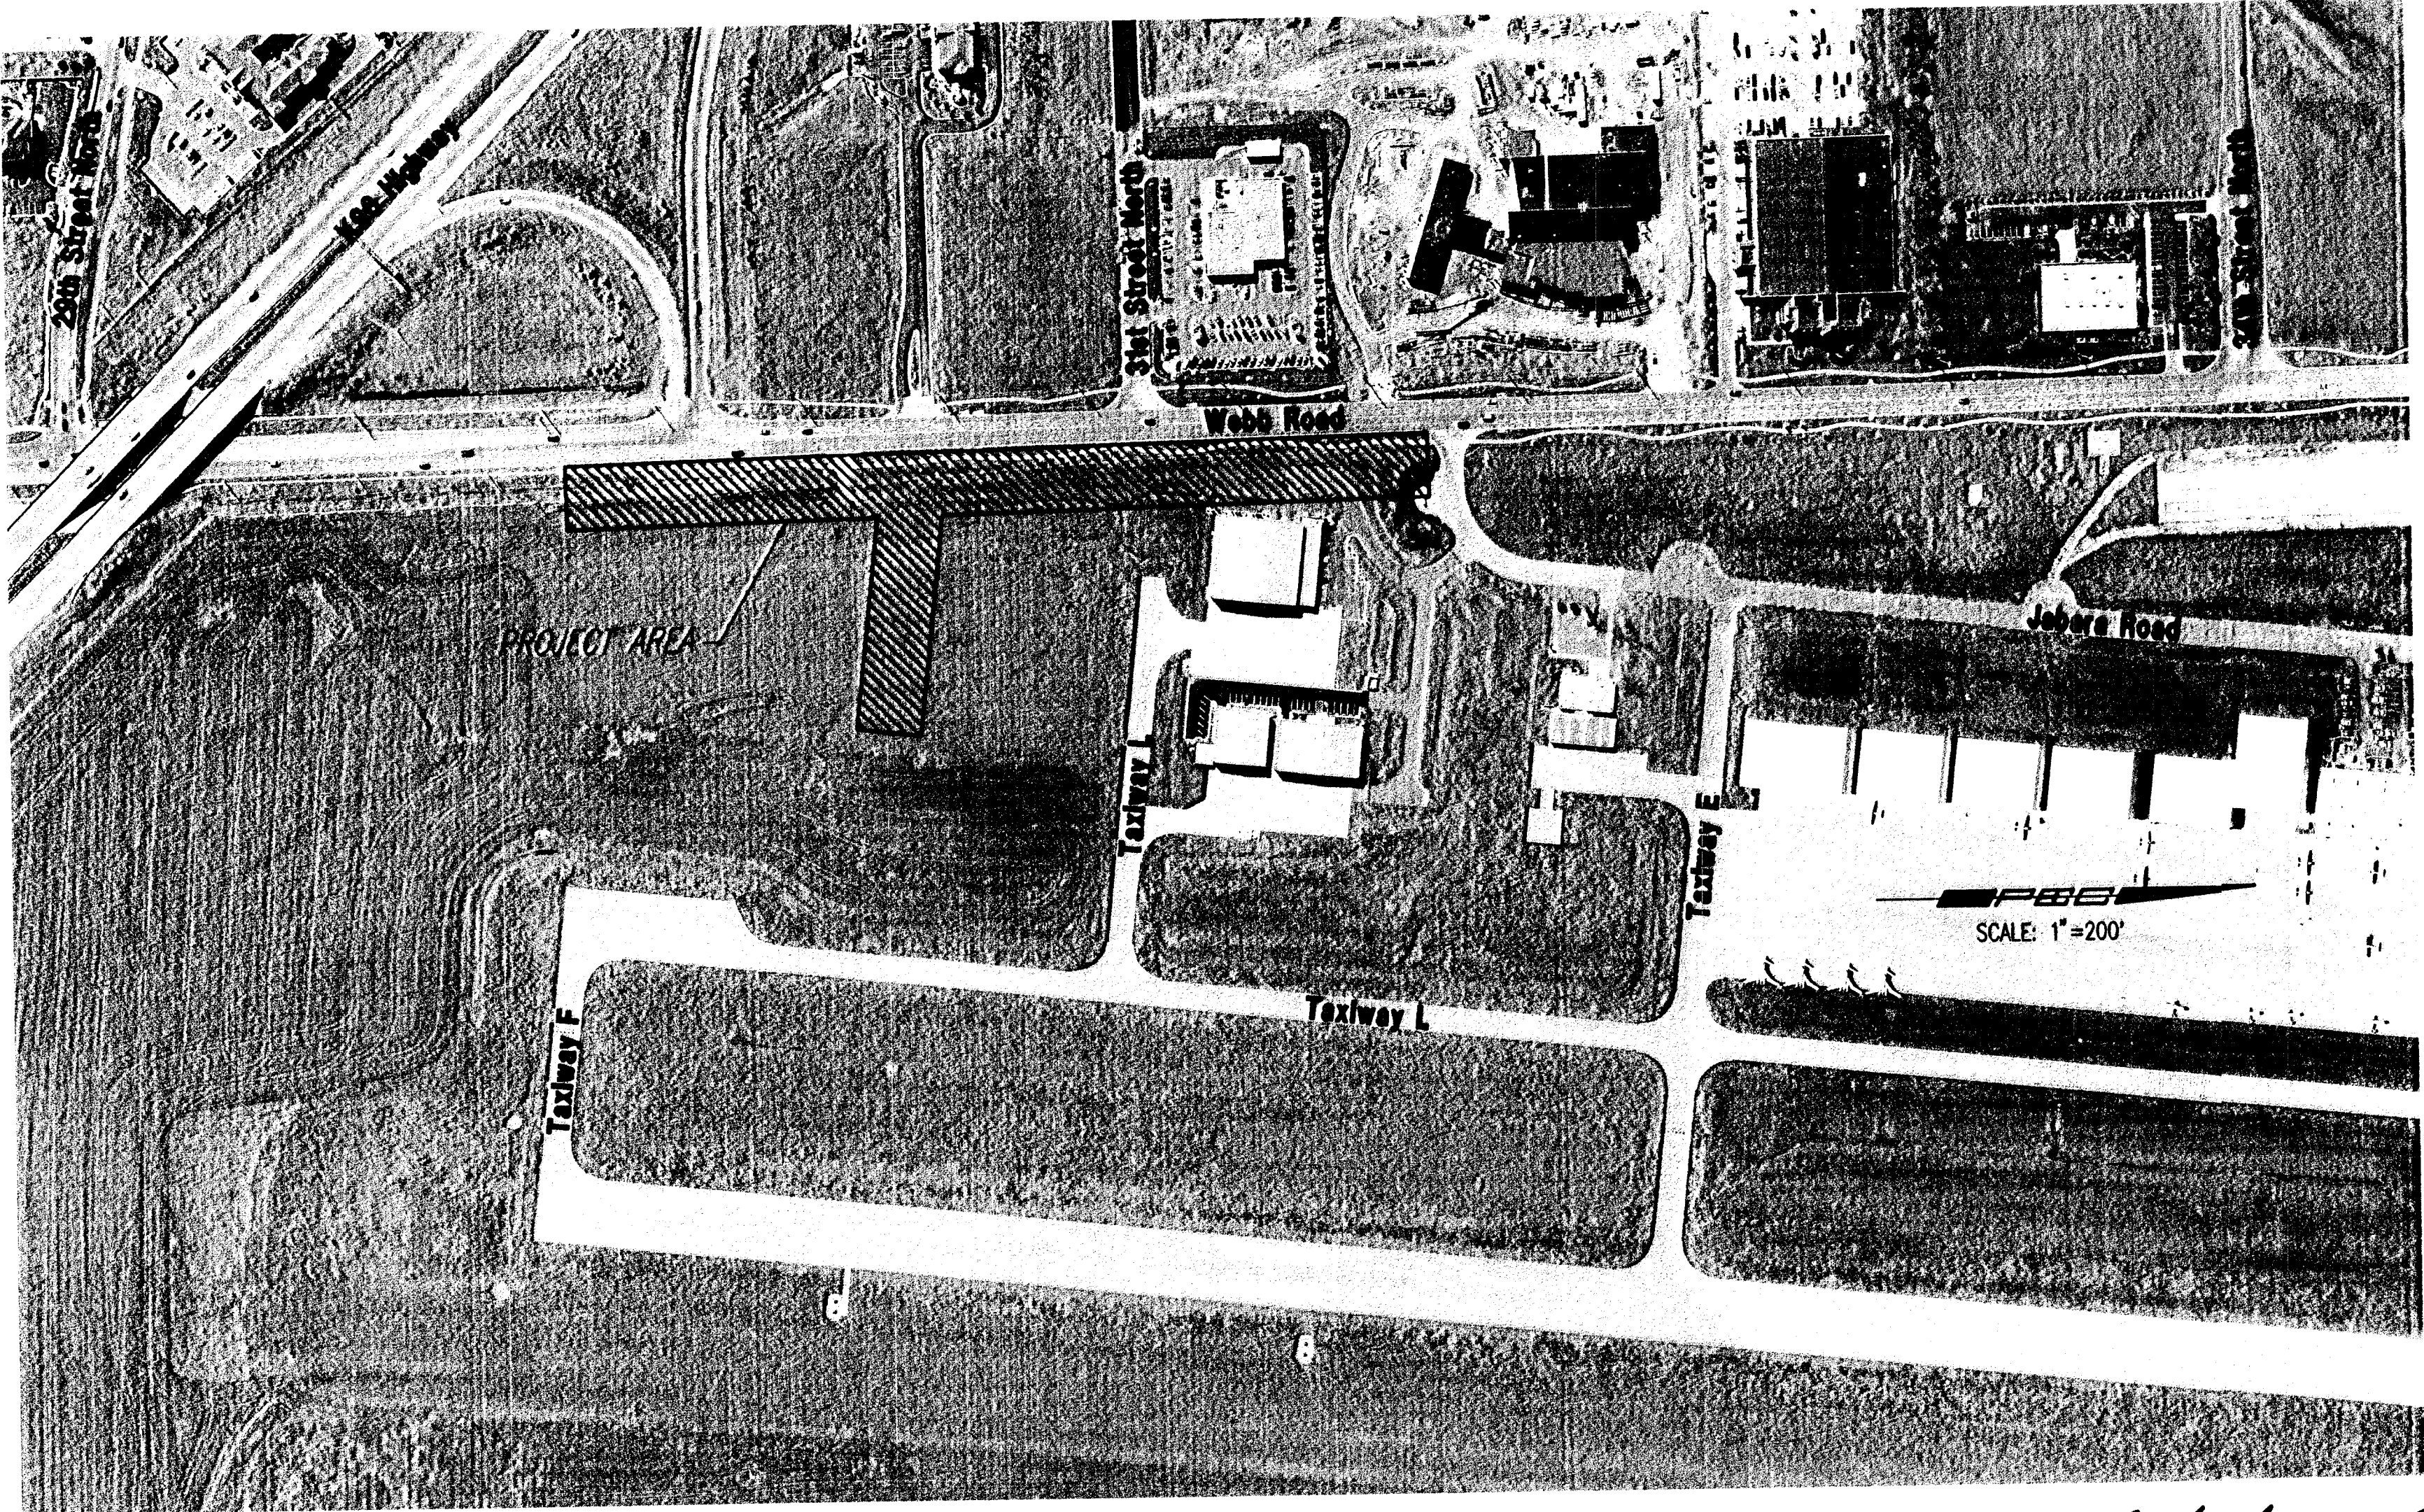

Dondlinger & Sons Construction Co, Inc - Contractor
Rogers, P.E.C. - Inspector
Released 5/29/07
As-Built
Riser & Stubs
.pdf by JDL 6/19/07

JULY 2006

RECORD DRAWING

