



KD-7625

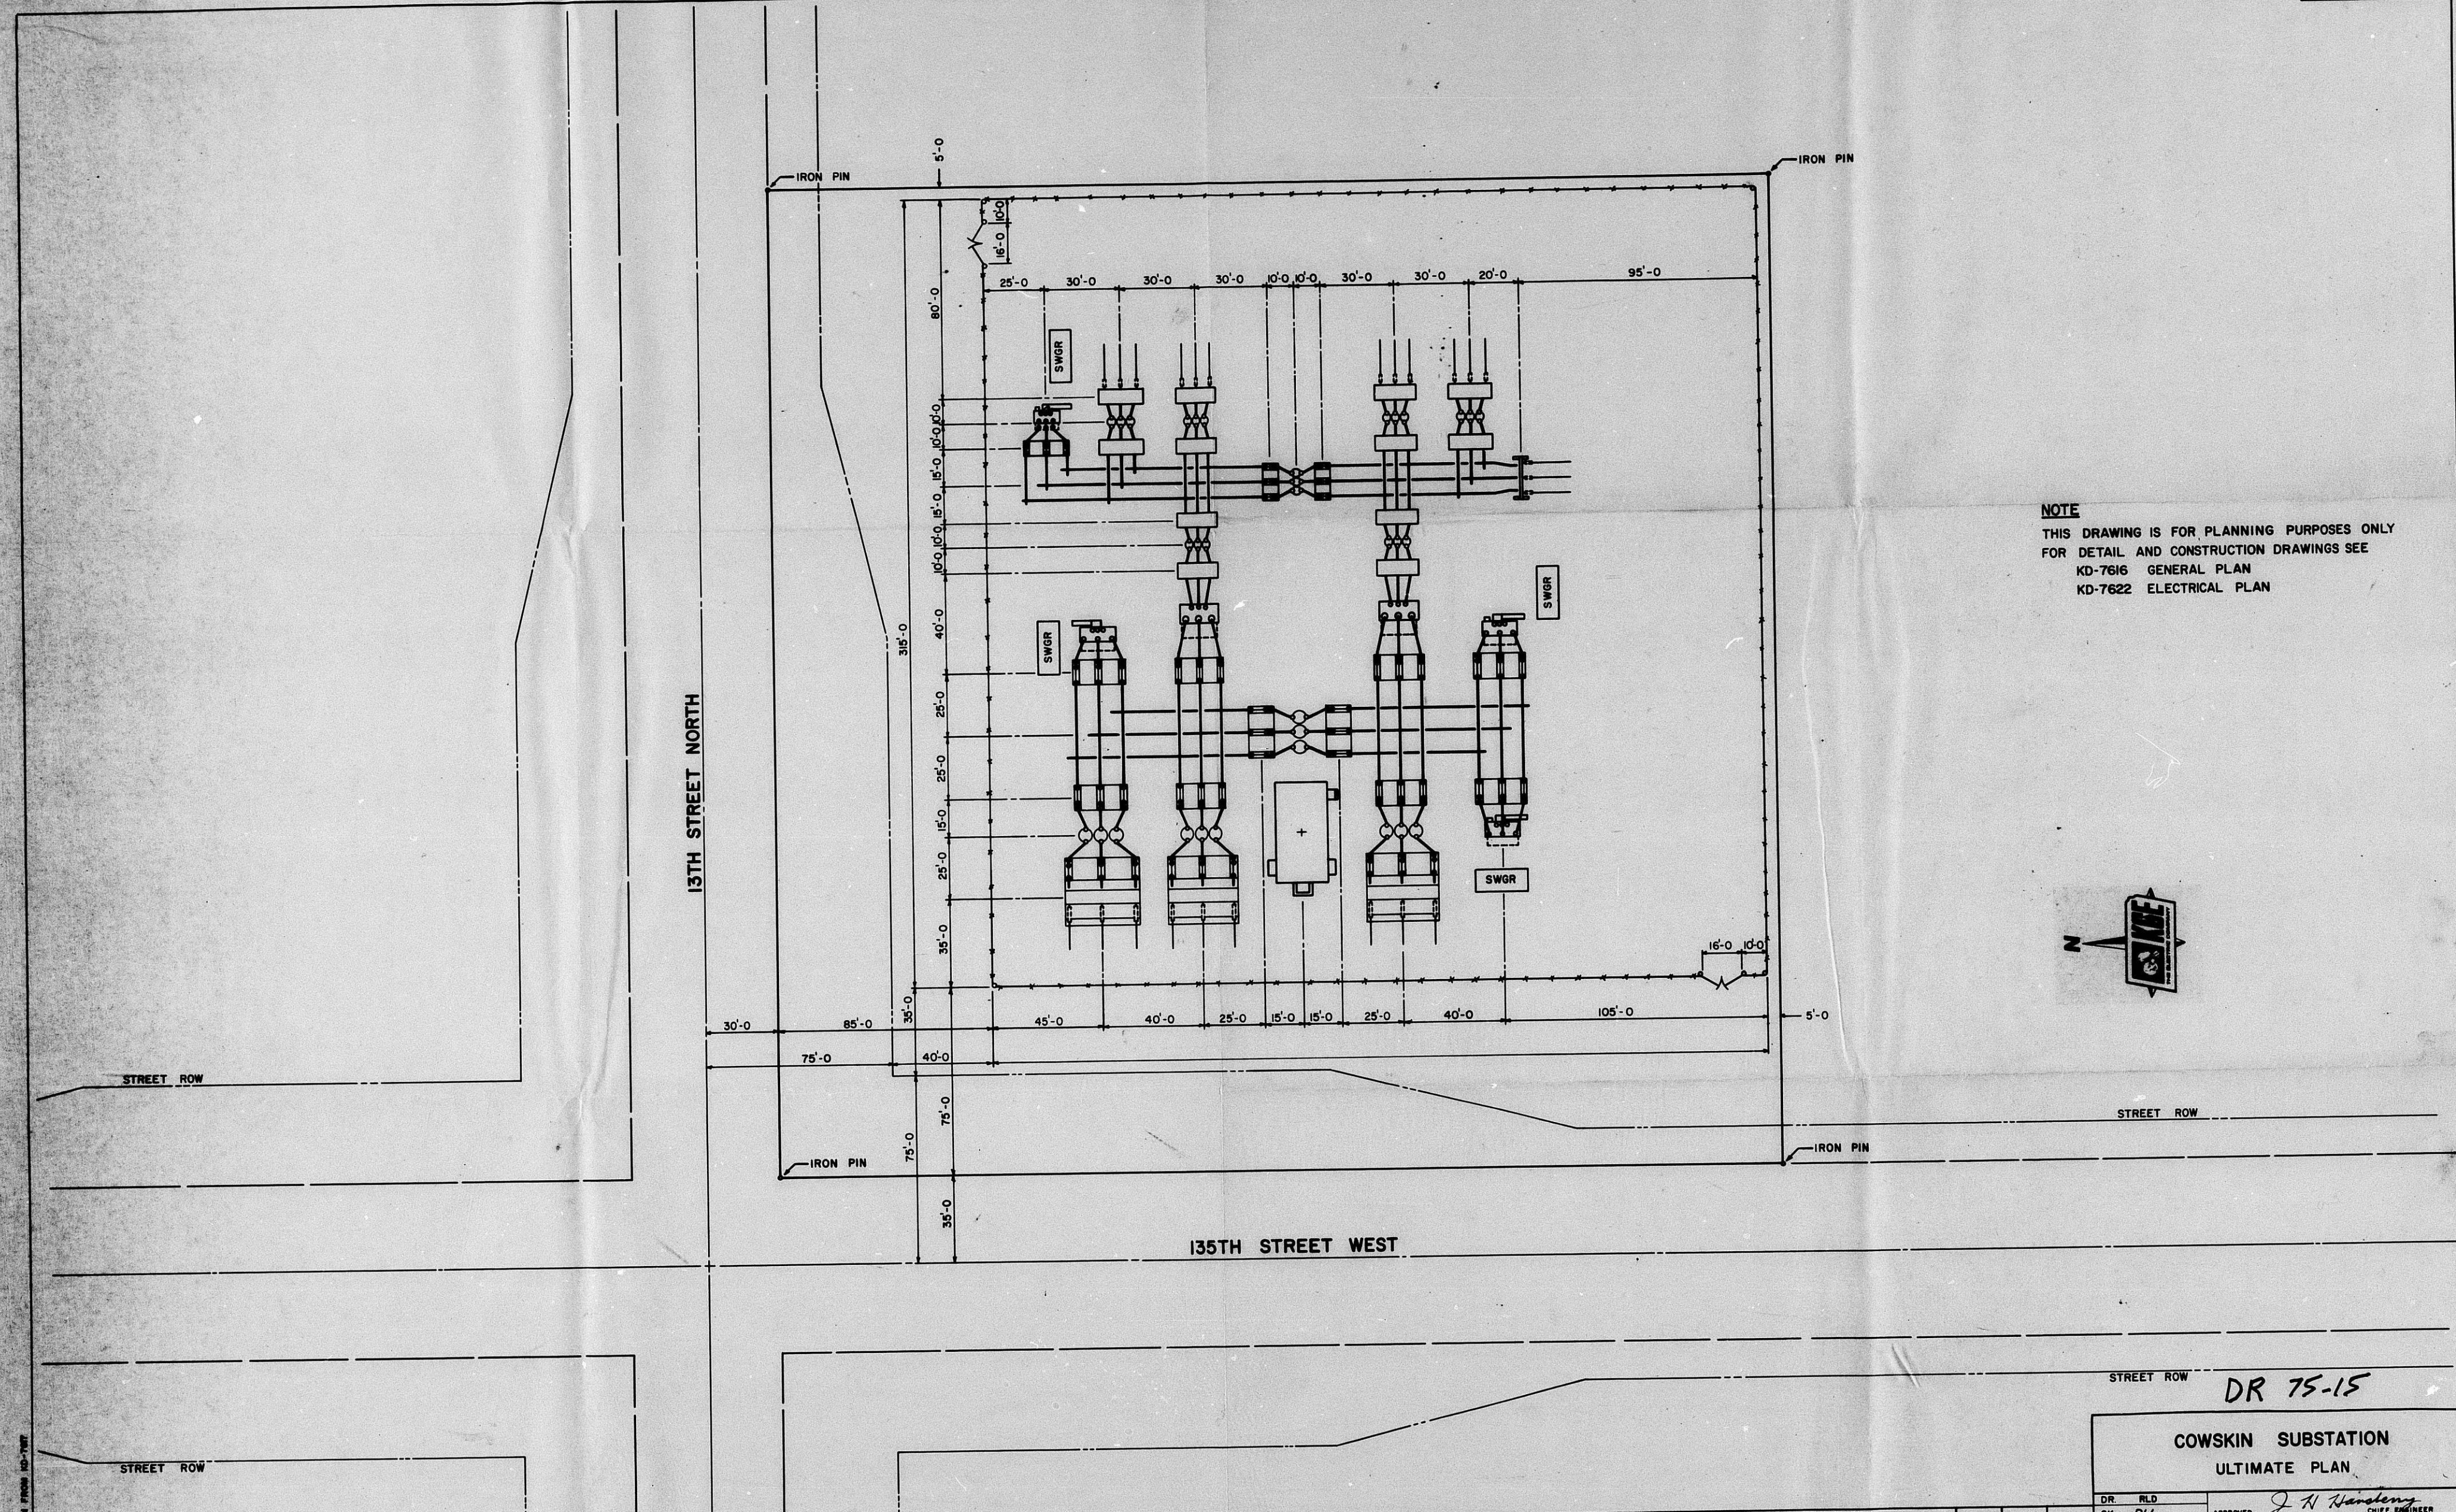

NOTE
 THIS DRAWING IS FOR PLANNING PURPOSES ONLY
 FOR DETAIL AND CONSTRUCTION DRAWINGS SEE
 KD-7616 GENERAL PLAN
 KD-7622 ELECTRICAL PLAN

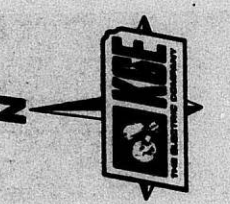

STREET ROW DR 75-15

COWSKIN SUBSTATION
 ULTIMATE PLAN

DR RLD
 CK DLE
 DATE 4/8/75
 KANSAS GAS AND ELECTRIC COMPANY
 ENGINEERING DEPT. WICHITA, KANSAS

APPROVED *J. N. Hensley*
 CHIEF ENGINEER

SCALE 1" = 30'-0"
 SHEET 1 OF 2
 KD-7625

NO.	DATE	REVISION	BY	CK.	APP.	NO.	DATE	REVISION	BY	CK.	APP.	NO.	DATE	REVISION	BY	CK.	APP.	NO.	DATE	REVISION	BY	CK.	APP.	

FILMED FROM THE BEST AVAILABLE COPY