



**STORM WATER SEWER EXTENSION
FOR
GALICIA HEART HOSPITAL
LOCATED AT 2600 N. WOODLAWN
WICHITA, KANSAS
COW PRIV. PROJ. NO. 1137 PPS(807861)
MIKE LINDEBAK, P.E., CITY ENGINEER
JULY 2001**

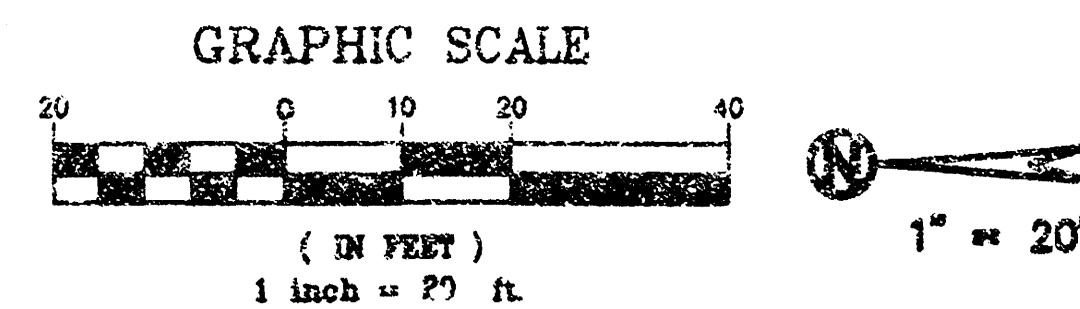

UTILITIES SHOWN REPRESENT THE BEST INFORMATION AVAILABLE FOR DESIGN. ADDITIONAL UTILITIES MAY BE PRESENT ON THIS PROJECT. THE CONTRACTOR SHALL BE RESPONSIBLE FOR DETERMINING THE EXACT LOCATION, DEPTH AND SIZE OF ALL UNDERGROUND UTILITIES PRIOR TO CONSTRUCTION. THE CONTRACTOR SHALL BE LIABLE FOR ANY DAMAGE CAUSED BY THE FAILURE TO DO SO.

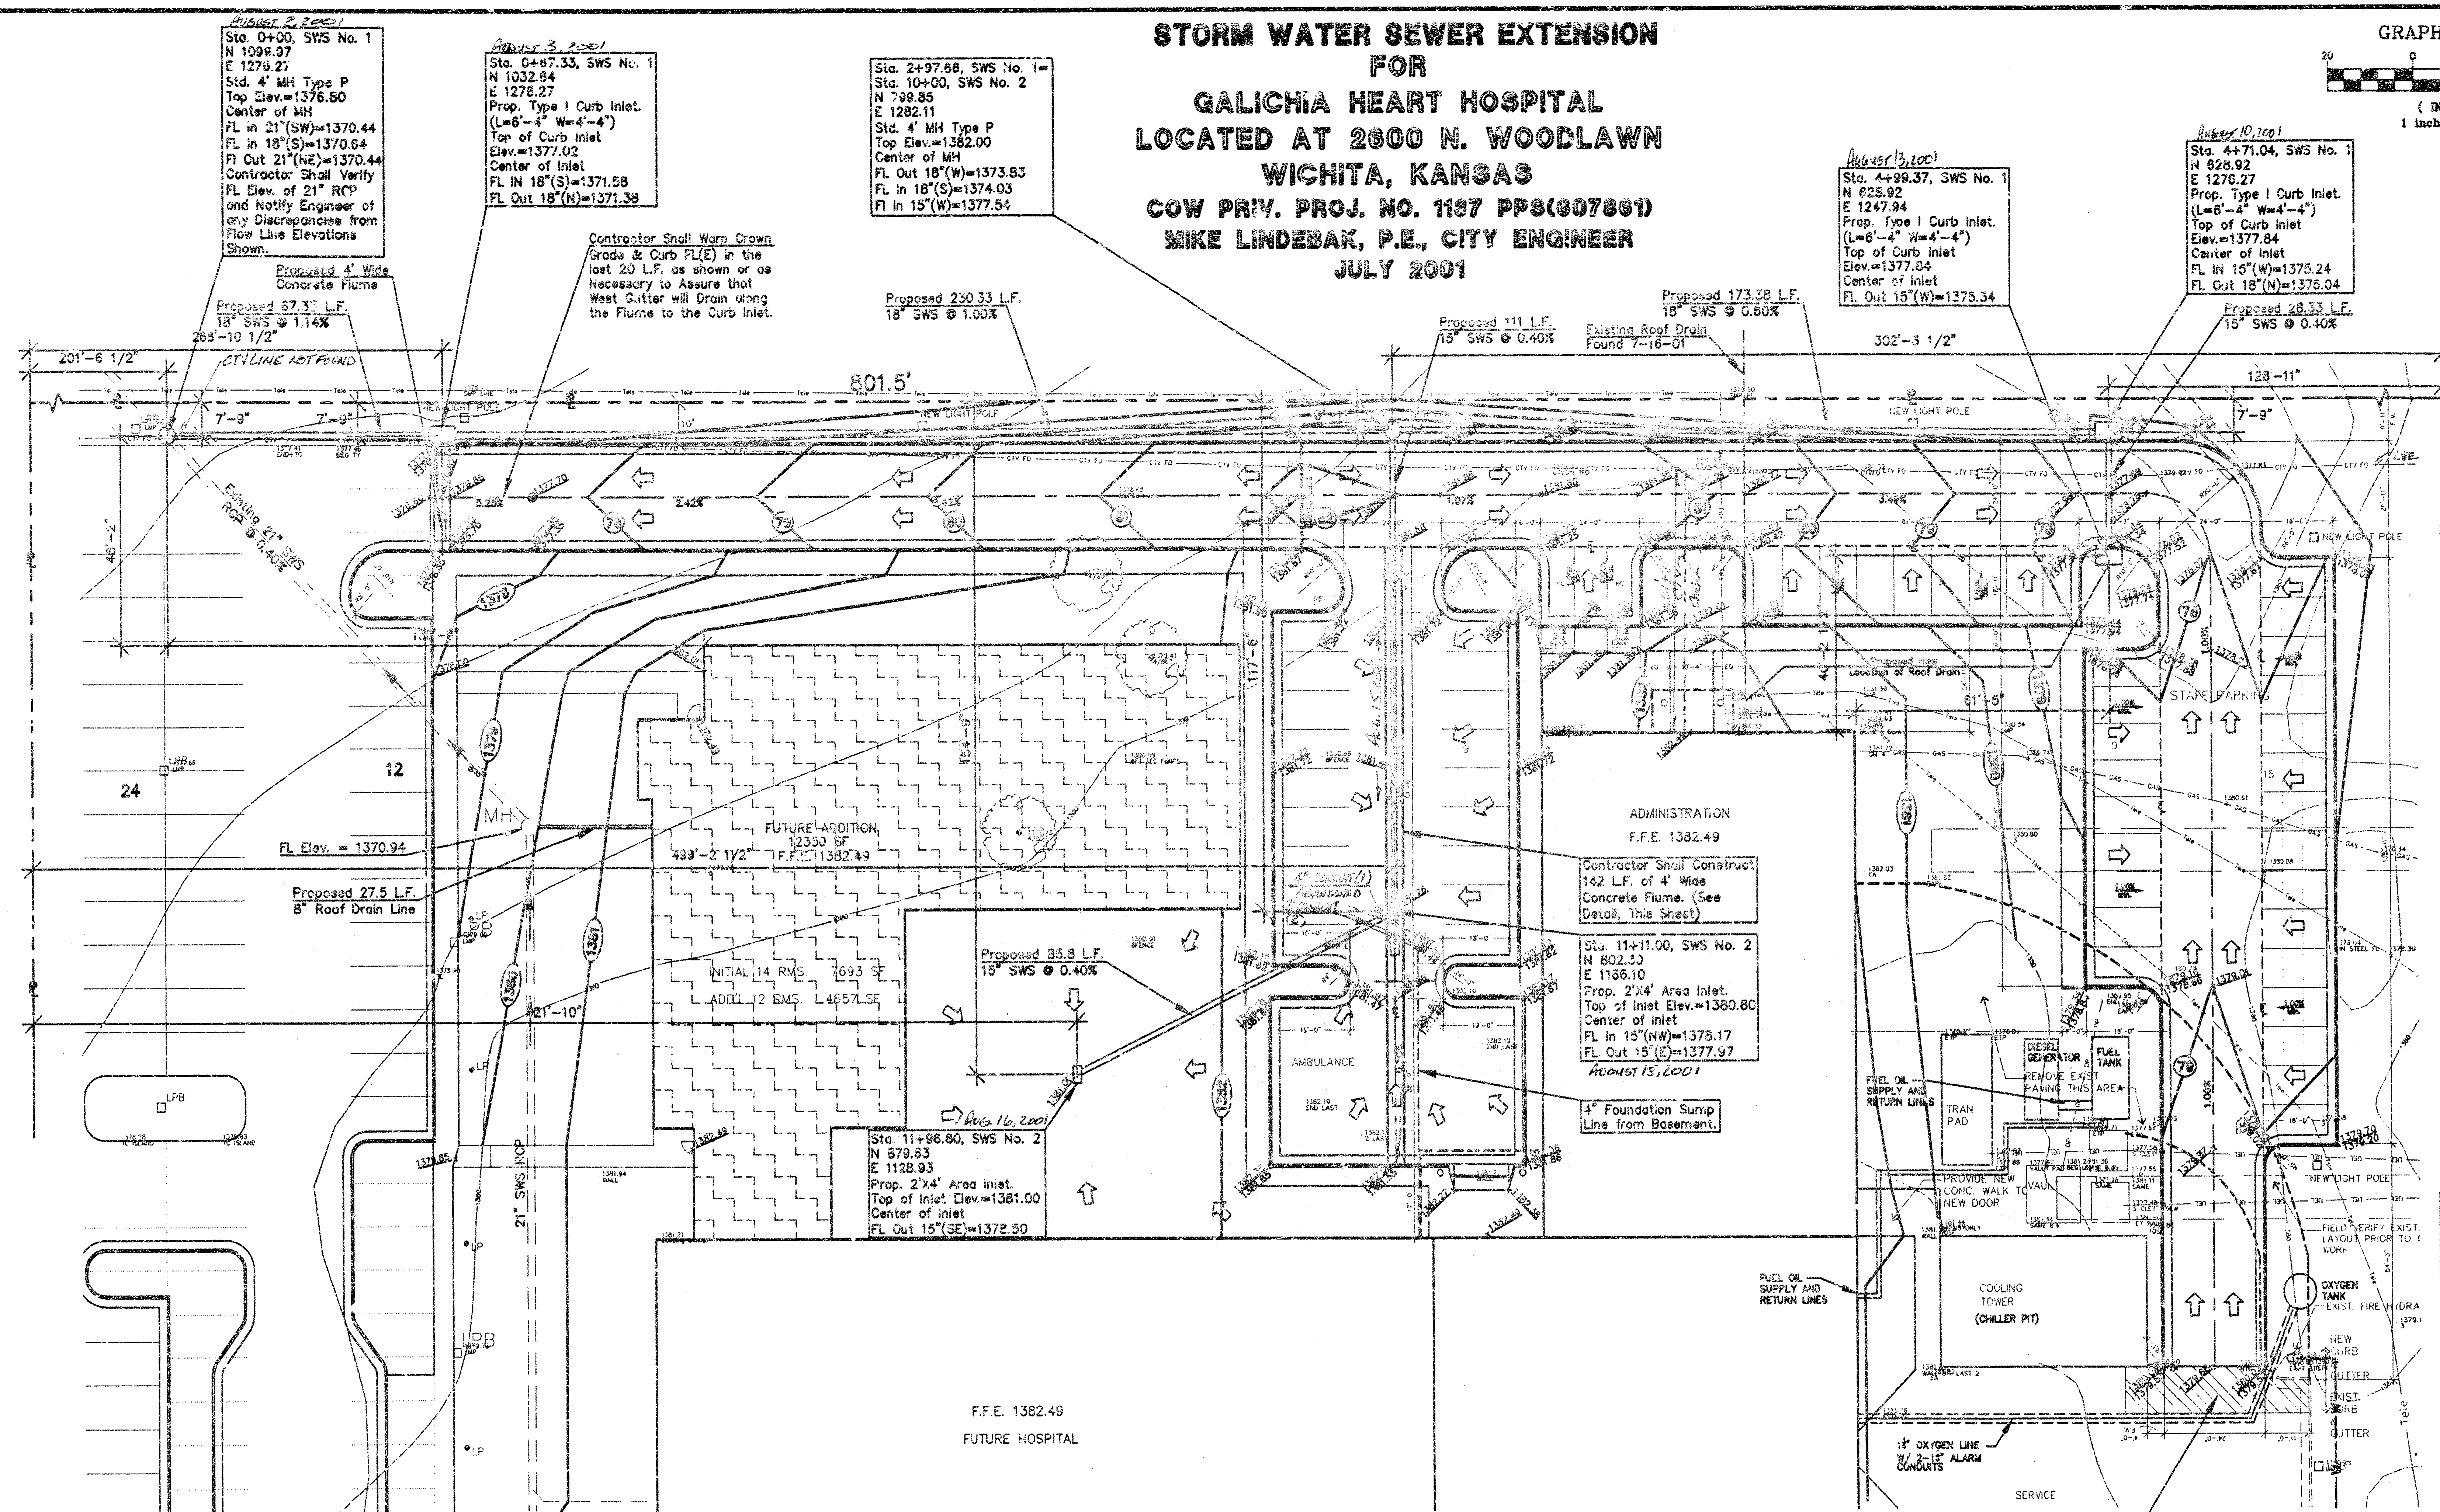


LEGEND

△ = 5/8" L.S. #500 (FOUND)	○ FOR = FIBER OPTIC MARKER
× = CHISELED "X" (FOUND)	▲ = SIGN
LP = LIGHT POLE	FP = FLAG POLE
LPB = DECORATIVE LAMP POST	— UEL — UEL — = UNDERGROUND ELECTRIC LINE
☼ = CONIFEROUS TREE	— SP — SP — = DRAINAGE PIPE (STORM SEWER)
☼ = DECIDUOUS TREE	— CTV FO — CTV FO — = CATV TELEVISION FIBER OPTIC LINE
○ SWMH = STORM SEWER MAN HOLE	— GAS — GAS — = GAS LINE
○ WMH = WATER VAULT MAN HOLE	— HEDG ROW — = HEDGE ROW
○ SS MH = SANITARY SEWER MAN HOLE	— HND RAIL — = HAND RAIL
○ KGMH = KANSAS GAS & ELECTRIC MAN HOLE	— TEL — TEL — = UNDERGROUND TELEPHONE LINE
○ BMH = BELL TELEPHONE MAN HOLE	— W — W — = WATER LINE
	— S — S — = SANITARY SEWER

(A) SITE GRADING PLAN

GRADING LEGEND

• 1361.25 = Existing Elevation
— = Existing Contour Elevation
1361.25 = Proposed Spot Elevation
②-1362 = Proposed Contour Elevation
→ = Proposed Drainage Flow Direction

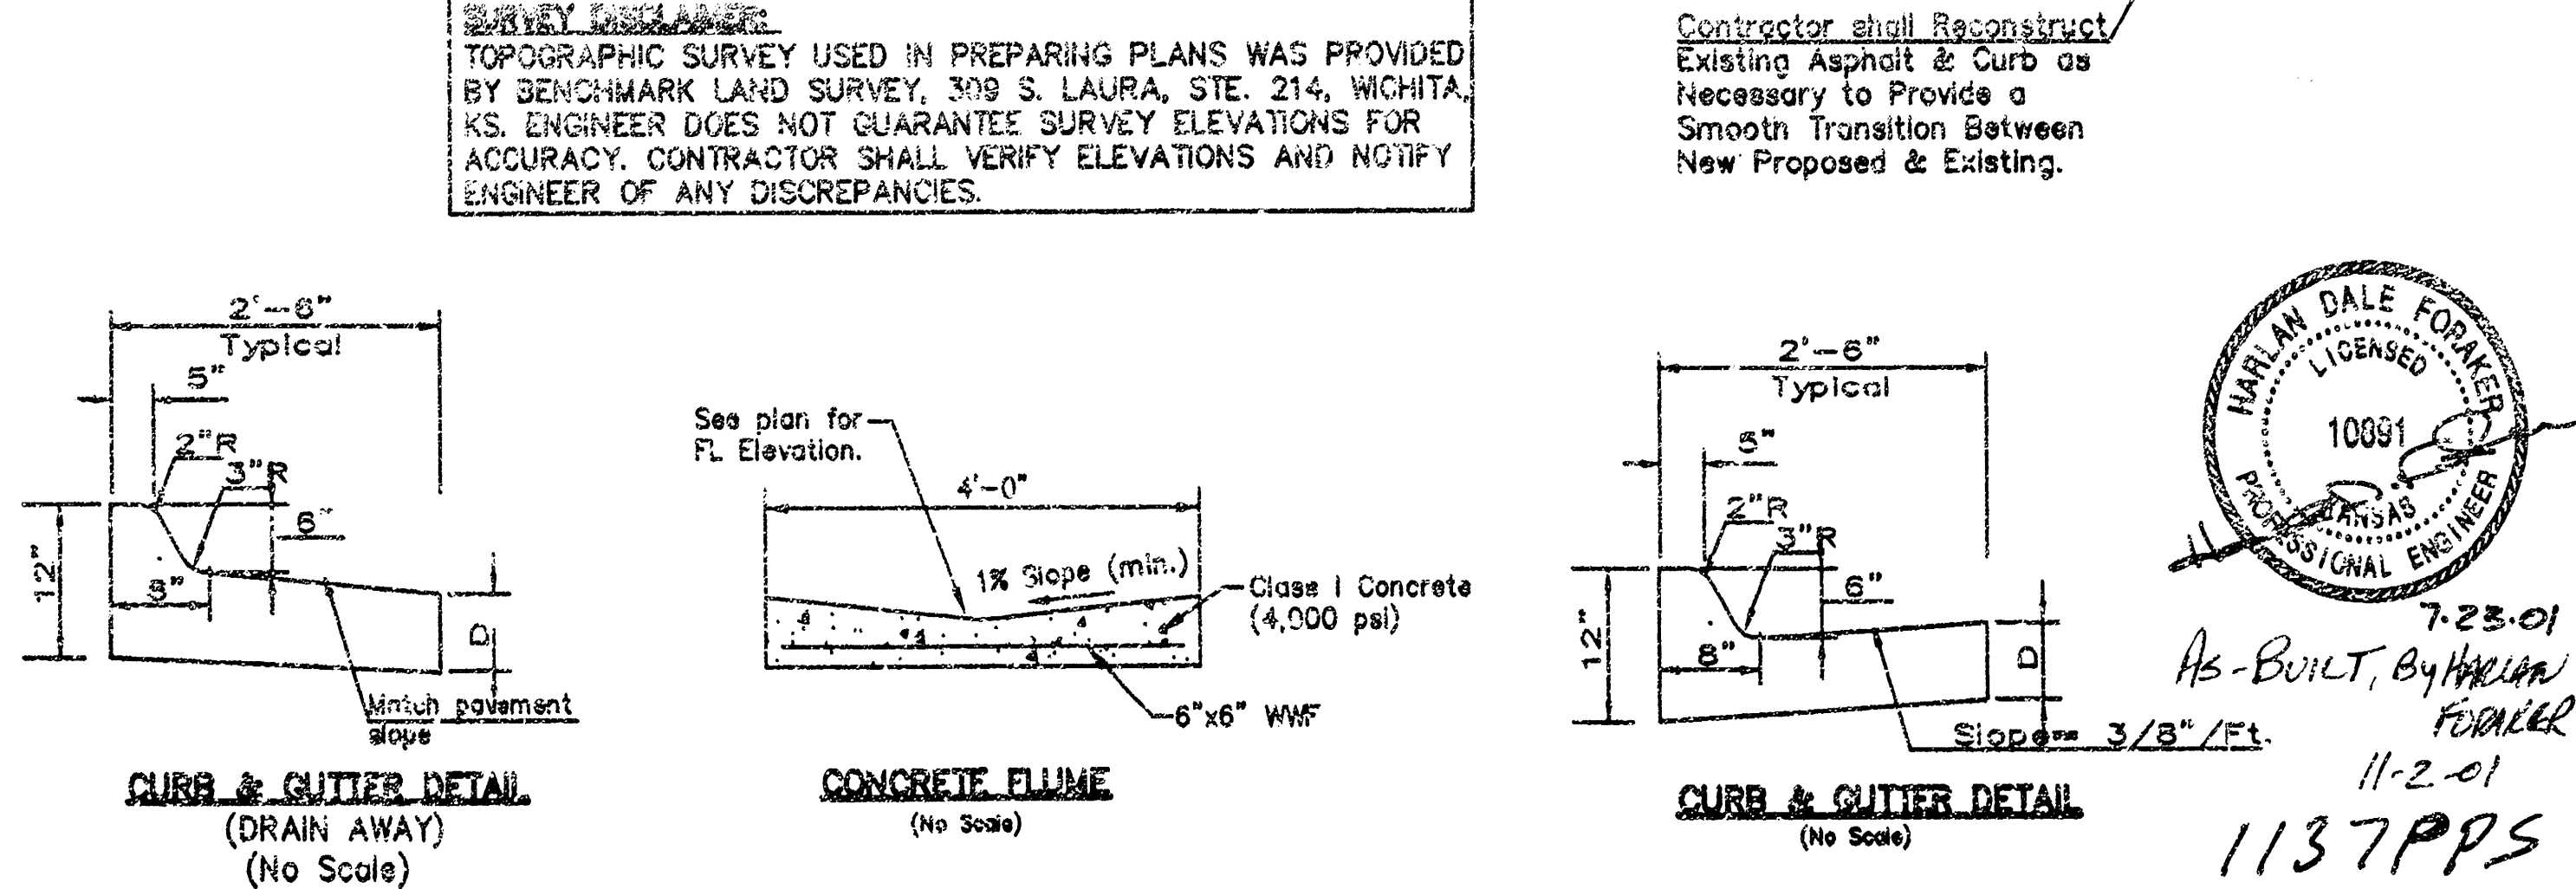

SITE GRADING PLAN

GALICIA MEDICAL GROUP

2600 N. WOODLAWN, WICHITA, KANSAS

CED PROJ. NO.: 2000640

CERTIFIED ENGINEERING DESIGN, P.A.

810 WEST DOUGLAS, SUITE C
WICHITA, KANSAS 67203
PH. (316) 262-8808 FAX. (316) 262-1669

DESIGNED: HDF	SCALE: 1"=20'	SHEET 1
DRAWN: CKW	DATE: 3/01	
CHECKED: HDF	CED FILE: gh-adm-swp.dwg	TOTAL 2

APPROVED AS NOTED
By CITY ENGINEER OF WICHITA

Sanitary Sewers See Plan 1137 PPS

Storm Sewers _____

Driveway Approaches _____

Water Mains _____

Paving _____

NOTE TO CONTRACTOR

INSPECTION AND TESTING FOR THIS PROJECT IS TO BE PROVIDED BY A LICENSED CONSULTING ENGINEERING FIRM UNDER CONTRACT WITH THE OWNER/DEVELOPER. SAID INSPECTION TO BE IN ACCORDANCE WITH THE CITY OF WICHITA STANDARD CONSTRUCTION ENGINEERING PRACTICES AND CERTIFIED BY A LICENSED PROFESSIONAL ENGINEER. NO WORK SHALL BE PERFORMED IN DEDICATED EASEMENTS OR THE PUBLIC RIGHT-OF-WAY BY THE CONTRACTOR WITHOUT SUCH INSPECTION NOR SHALL ANY WORK BE COMMENCED IN DEDICATED EASEMENTS OR PUBLIC RIGHT-OF-WAY WITHOUT WRITTEN AUTHORIZATION BY THE CITY ENGINEER.

