



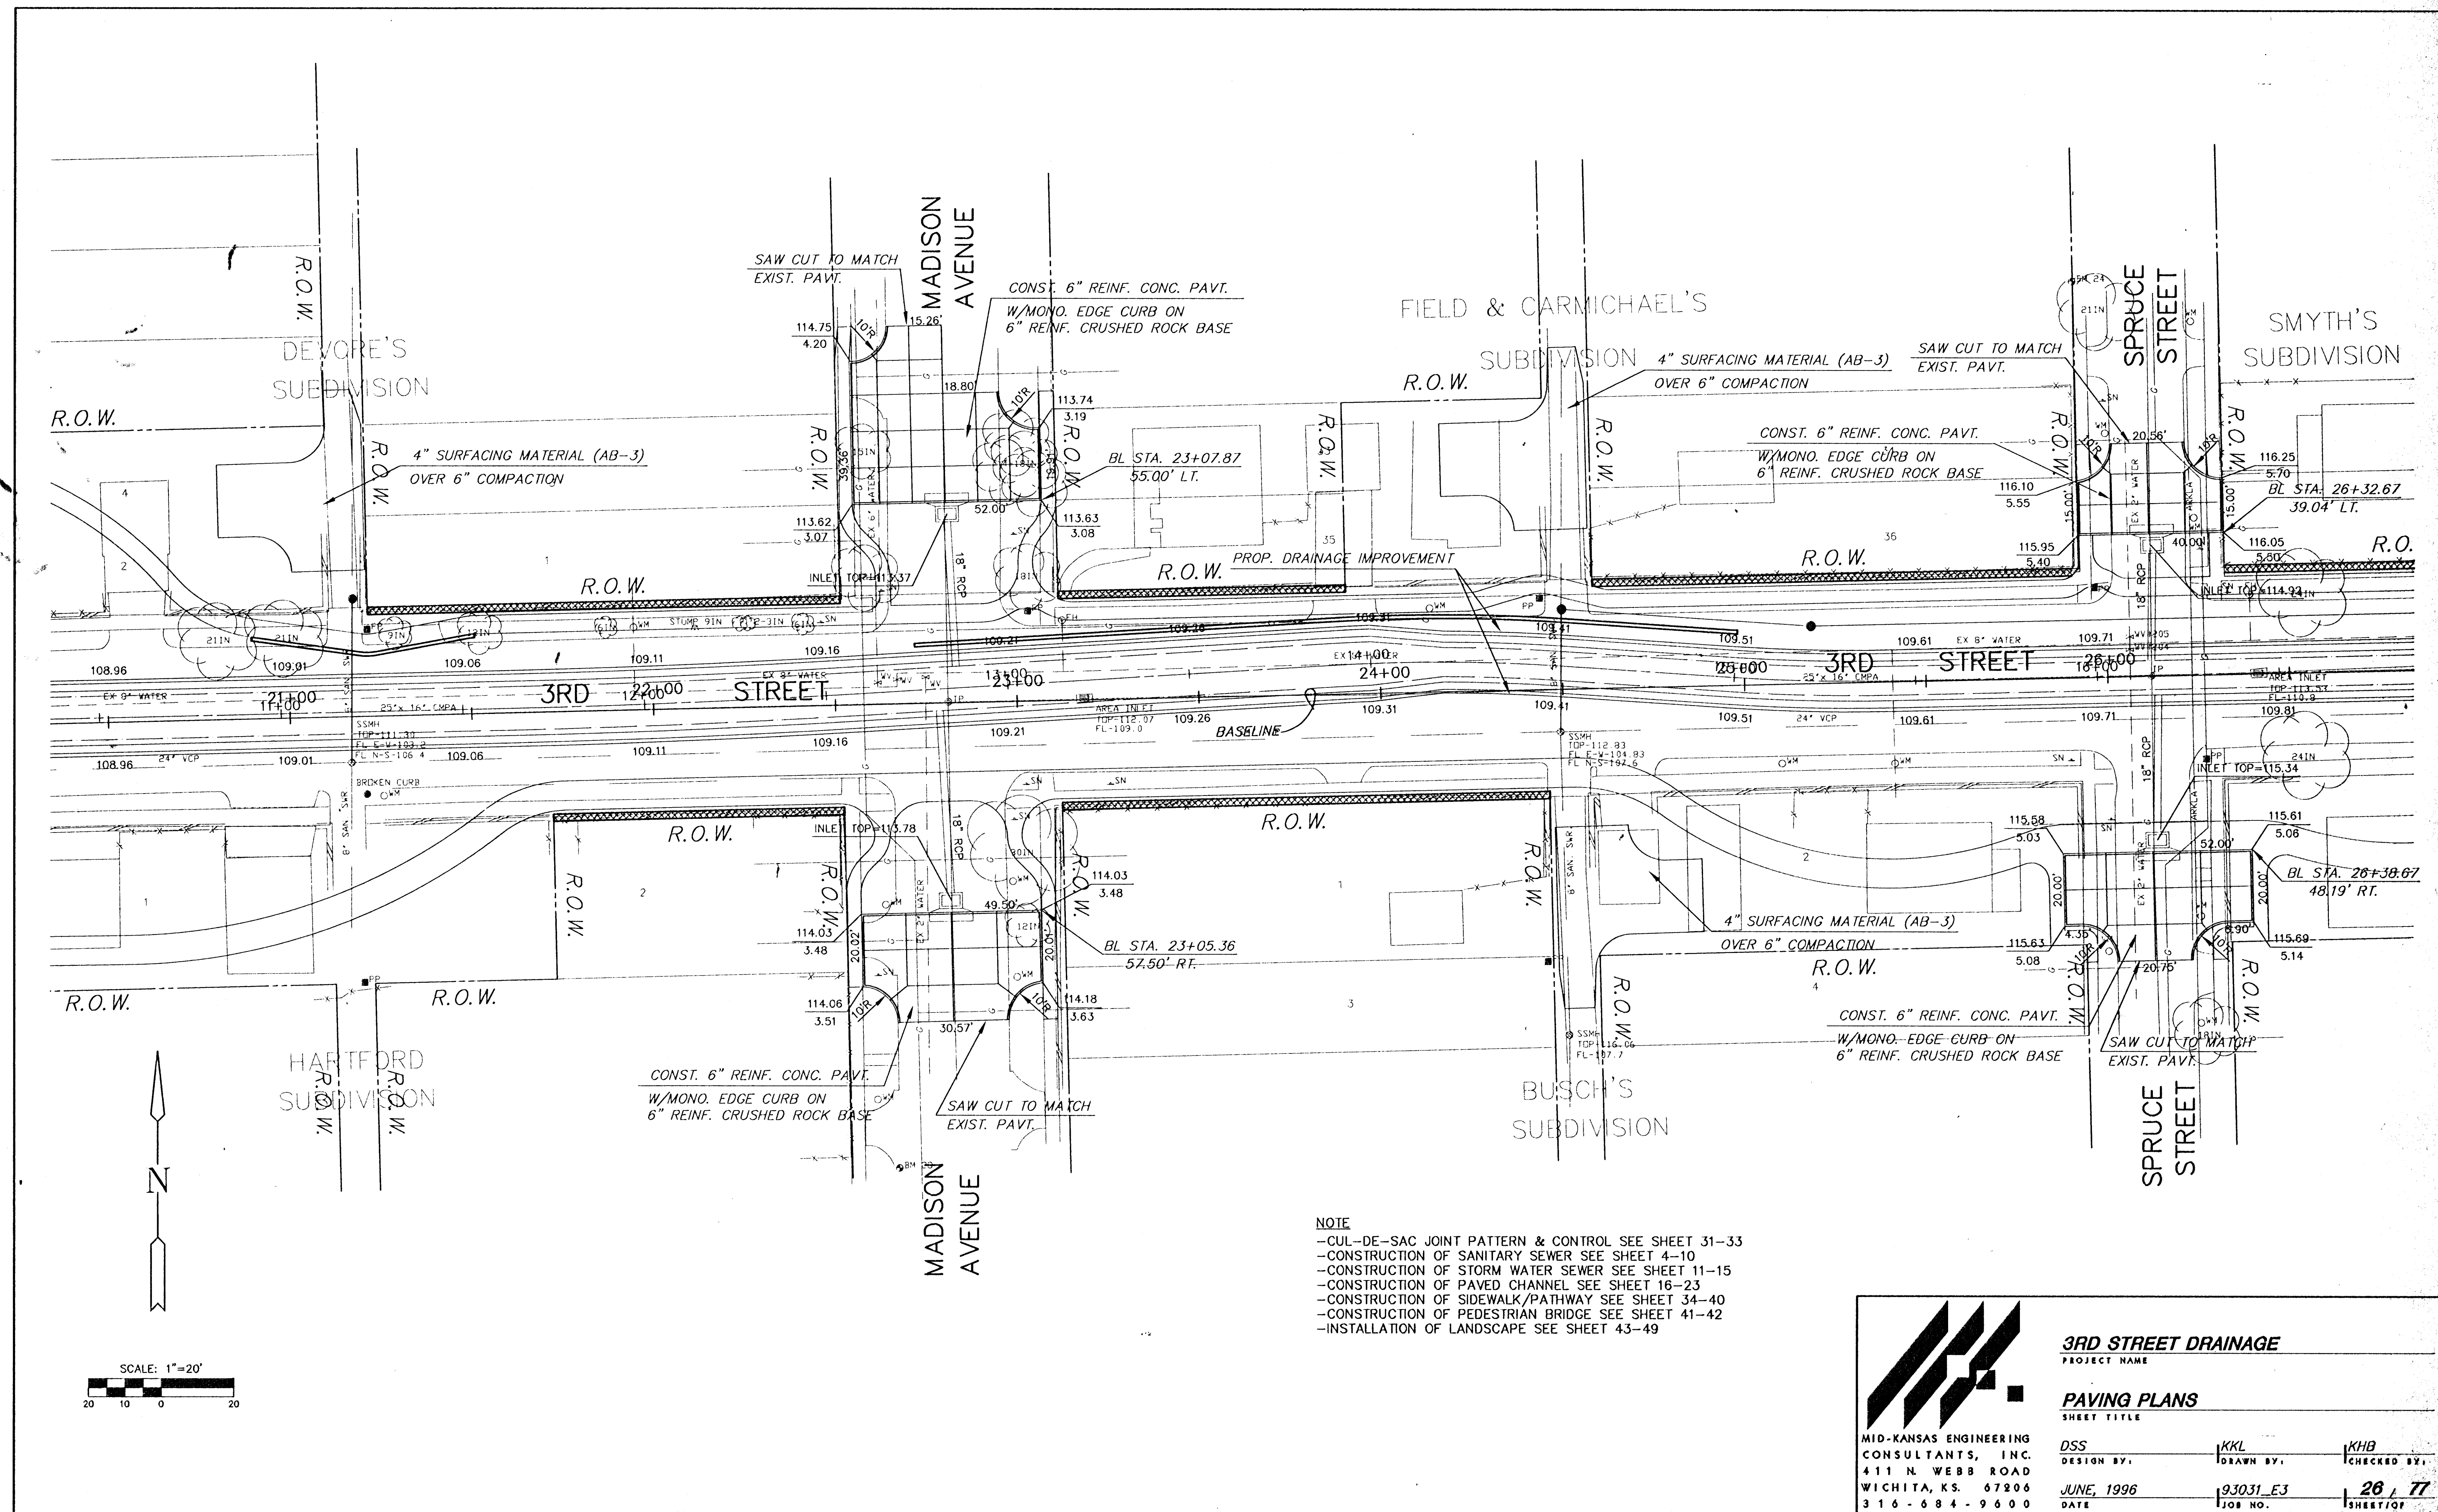

NOTE
-CUL-DE-SAC JOINT PATTERN & CONTROL SEE SHEET 31-33
-CONSTRUCTION OF SANITARY SEWER SEE SHEET 4-10
-CONSTRUCTION OF STORM WATER SEWER SEE SHEET 11-15
-CONSTRUCTION OF PAVED CHANNEL SEE SHEET 16-23
-CONSTRUCTION OF SIDEWALK/PATHWAY SEE SHEET 34-40
-CONSTRUCTION OF PEDESTRIAN BRIDGE SEE SHEET 41-42
-INSTALLATION OF LANDSCAPE SEE SHEET 43-49

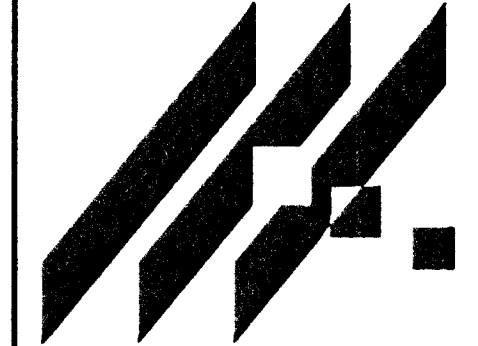

MID-KANSAS ENGINEERING
CONSULTANTS, INC.
411 N. WEBB ROAD
WICHITA, KS. 67206
316-684-9600

3RD STREET DRAINAGE
PROJECT NAME

PAVING PLANS
SHEET TITLE

DESIGN BY: DSS	DRAWN BY: KKL	CHECKED BY: KHB
DATE: JUNE, 1996	JOB NO.: 93031_E3	SHEET/OF: 26 / 77