



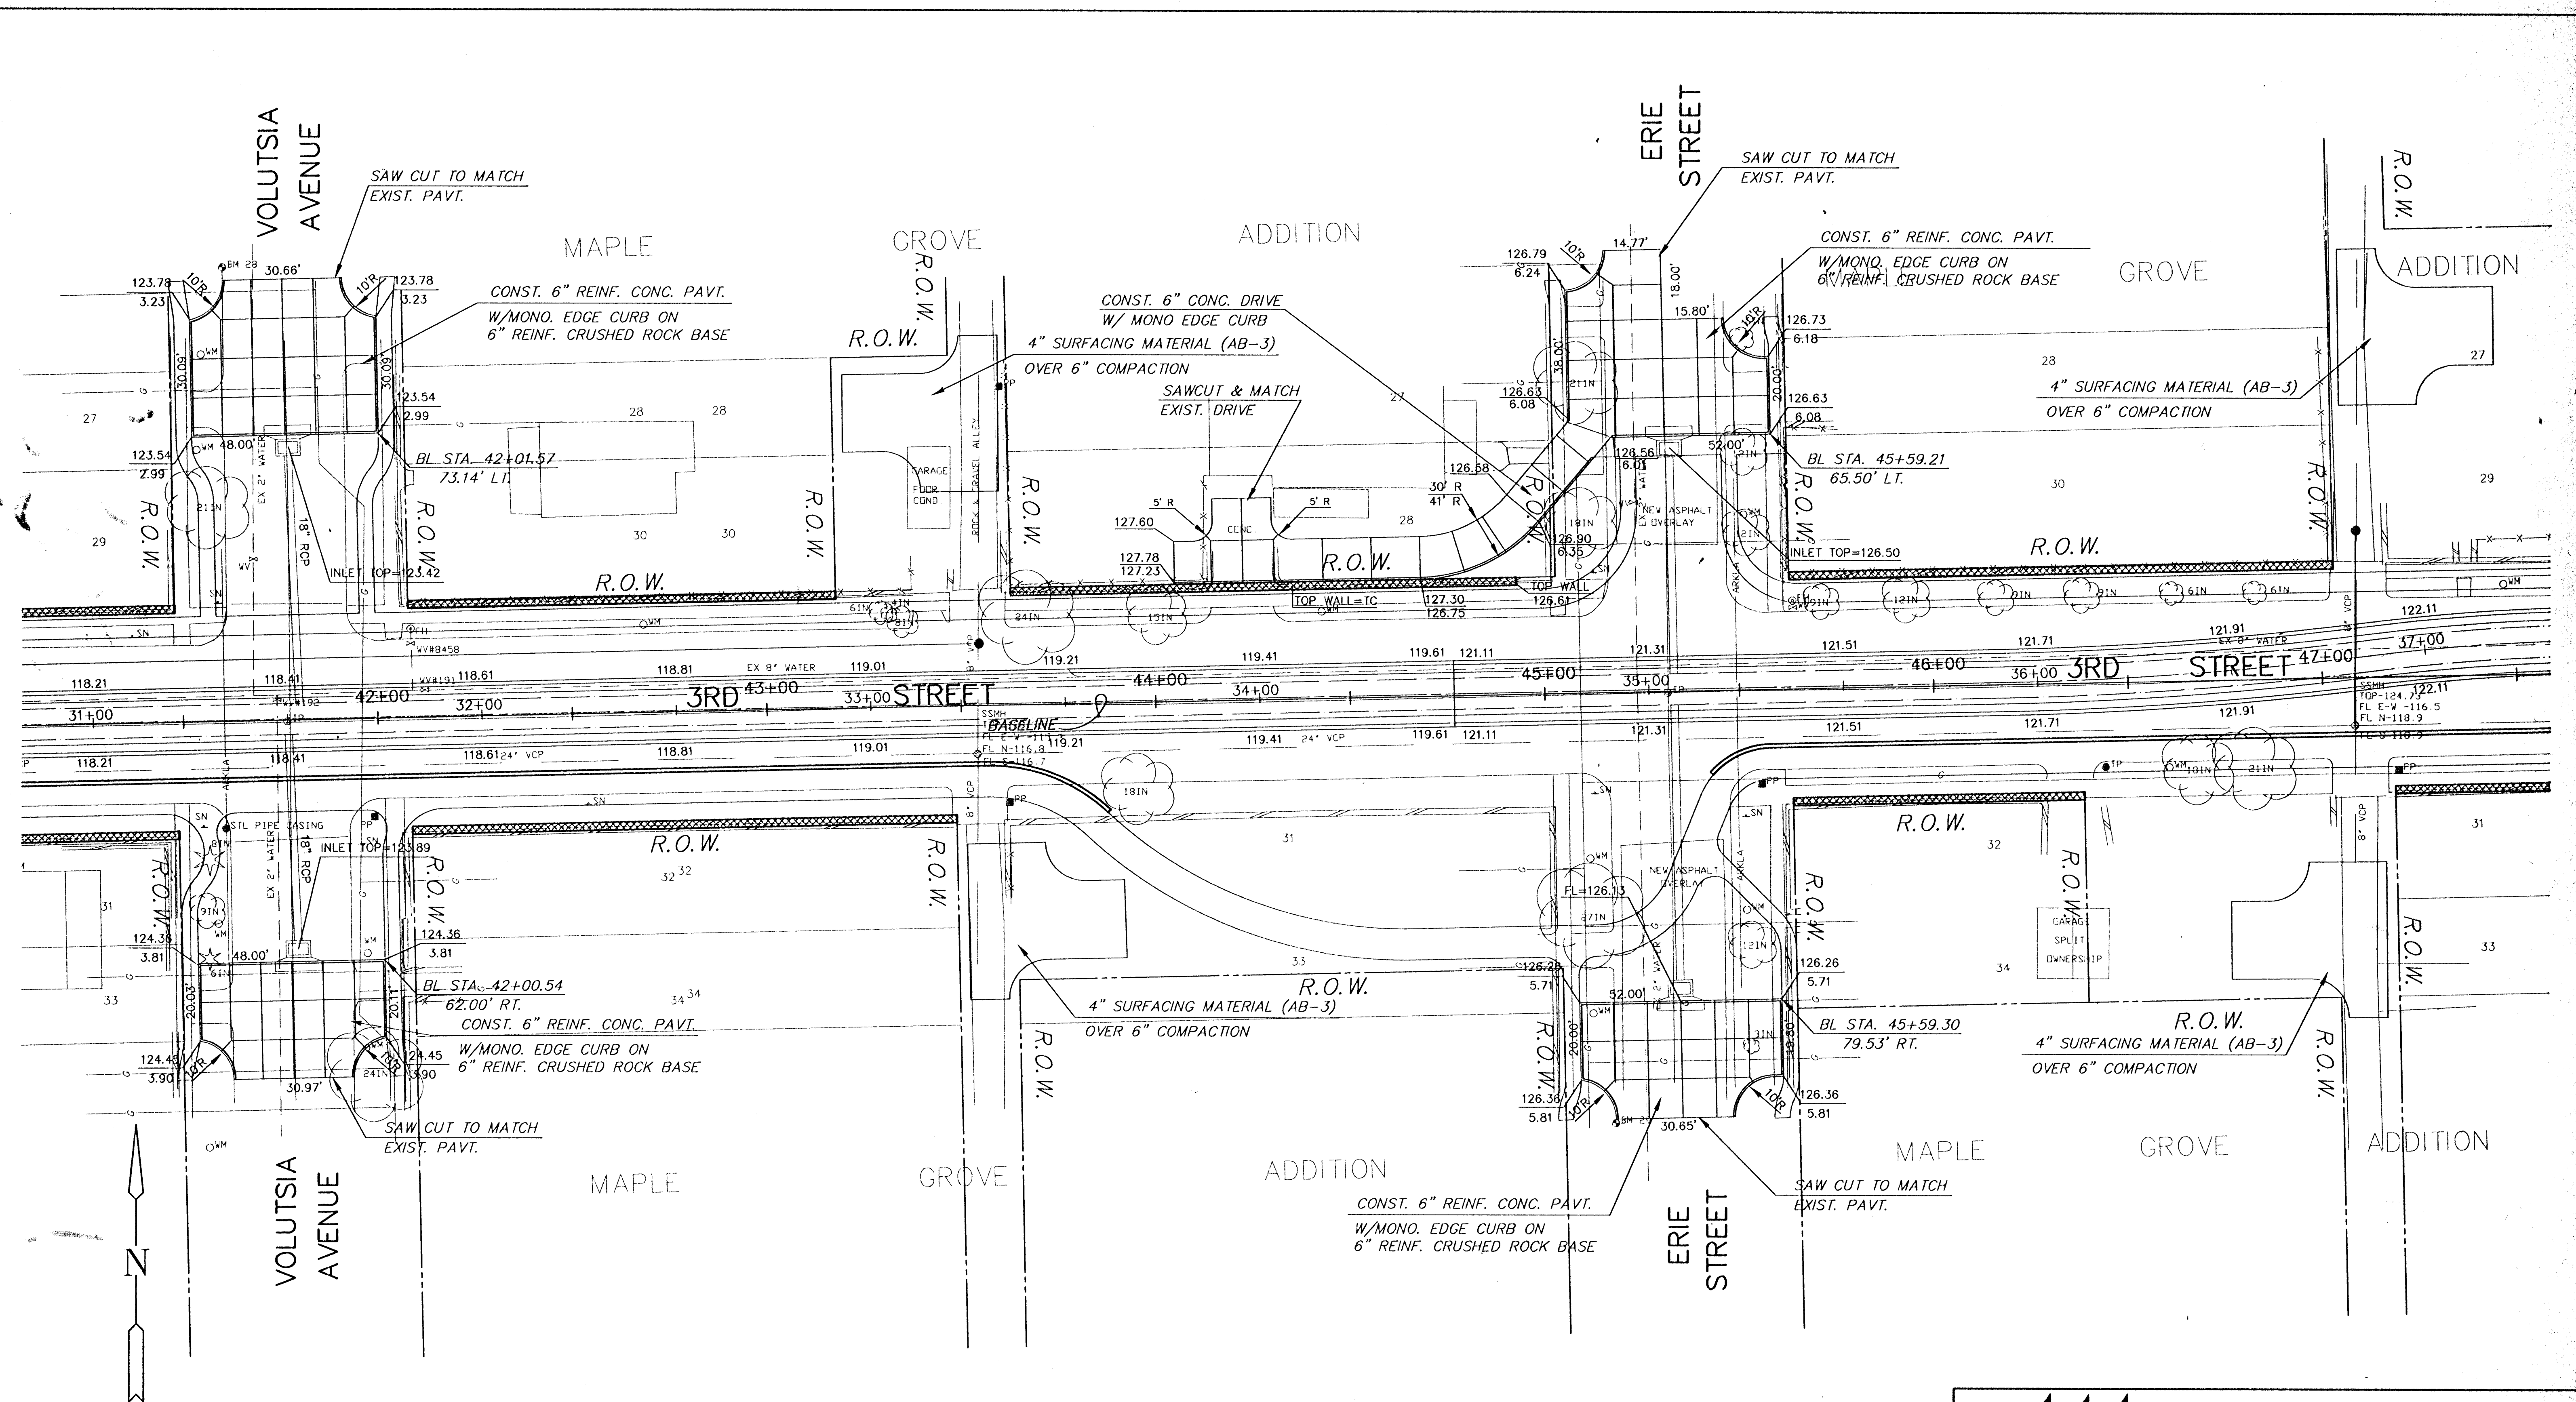

SCALE: 1"=20'

NOTE

- CUL-DE-SAC JOINT PATTERN & CONTROL SEE SHEET 31-33
- CONSTRUCTION OF SANITARY SEWER SEE SHEET 4-10
- CONSTRUCTION OF STORM WATER SEWER SEE SHEET 11-15
- CONSTRUCTION OF PAVED CHANNEL SEE SHEET 16-23
- CONSTRUCTION OF SIDEWALK/PATHWAY SEE SHEET 34-40
- CONSTRUCTION OF PEDESTRIAN BRIDGE SEE SHEET 41-42
- INSTALLATION OF LANDSCAPE SEE SHEET 43-49

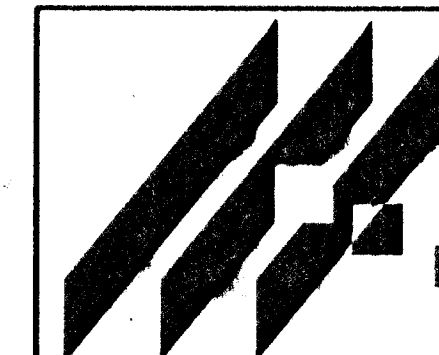

MID-KANSAS ENGINEERING
CONSULTANTS, INC.
411 N. WEBB ROAD
WICHITA, KS. 67206
316-684-9600

3RD STREET DRAINAGE
PROJECT NAME

PAVING PLANS
SHEET TITLE

DSS

DESIGN BY:

JUNE, 1996
DATE

KKL

DRAWN BY:

93031_E6
JOB NO.

KHB

CHECKED BY:

29 / 77
SHEET/OF