




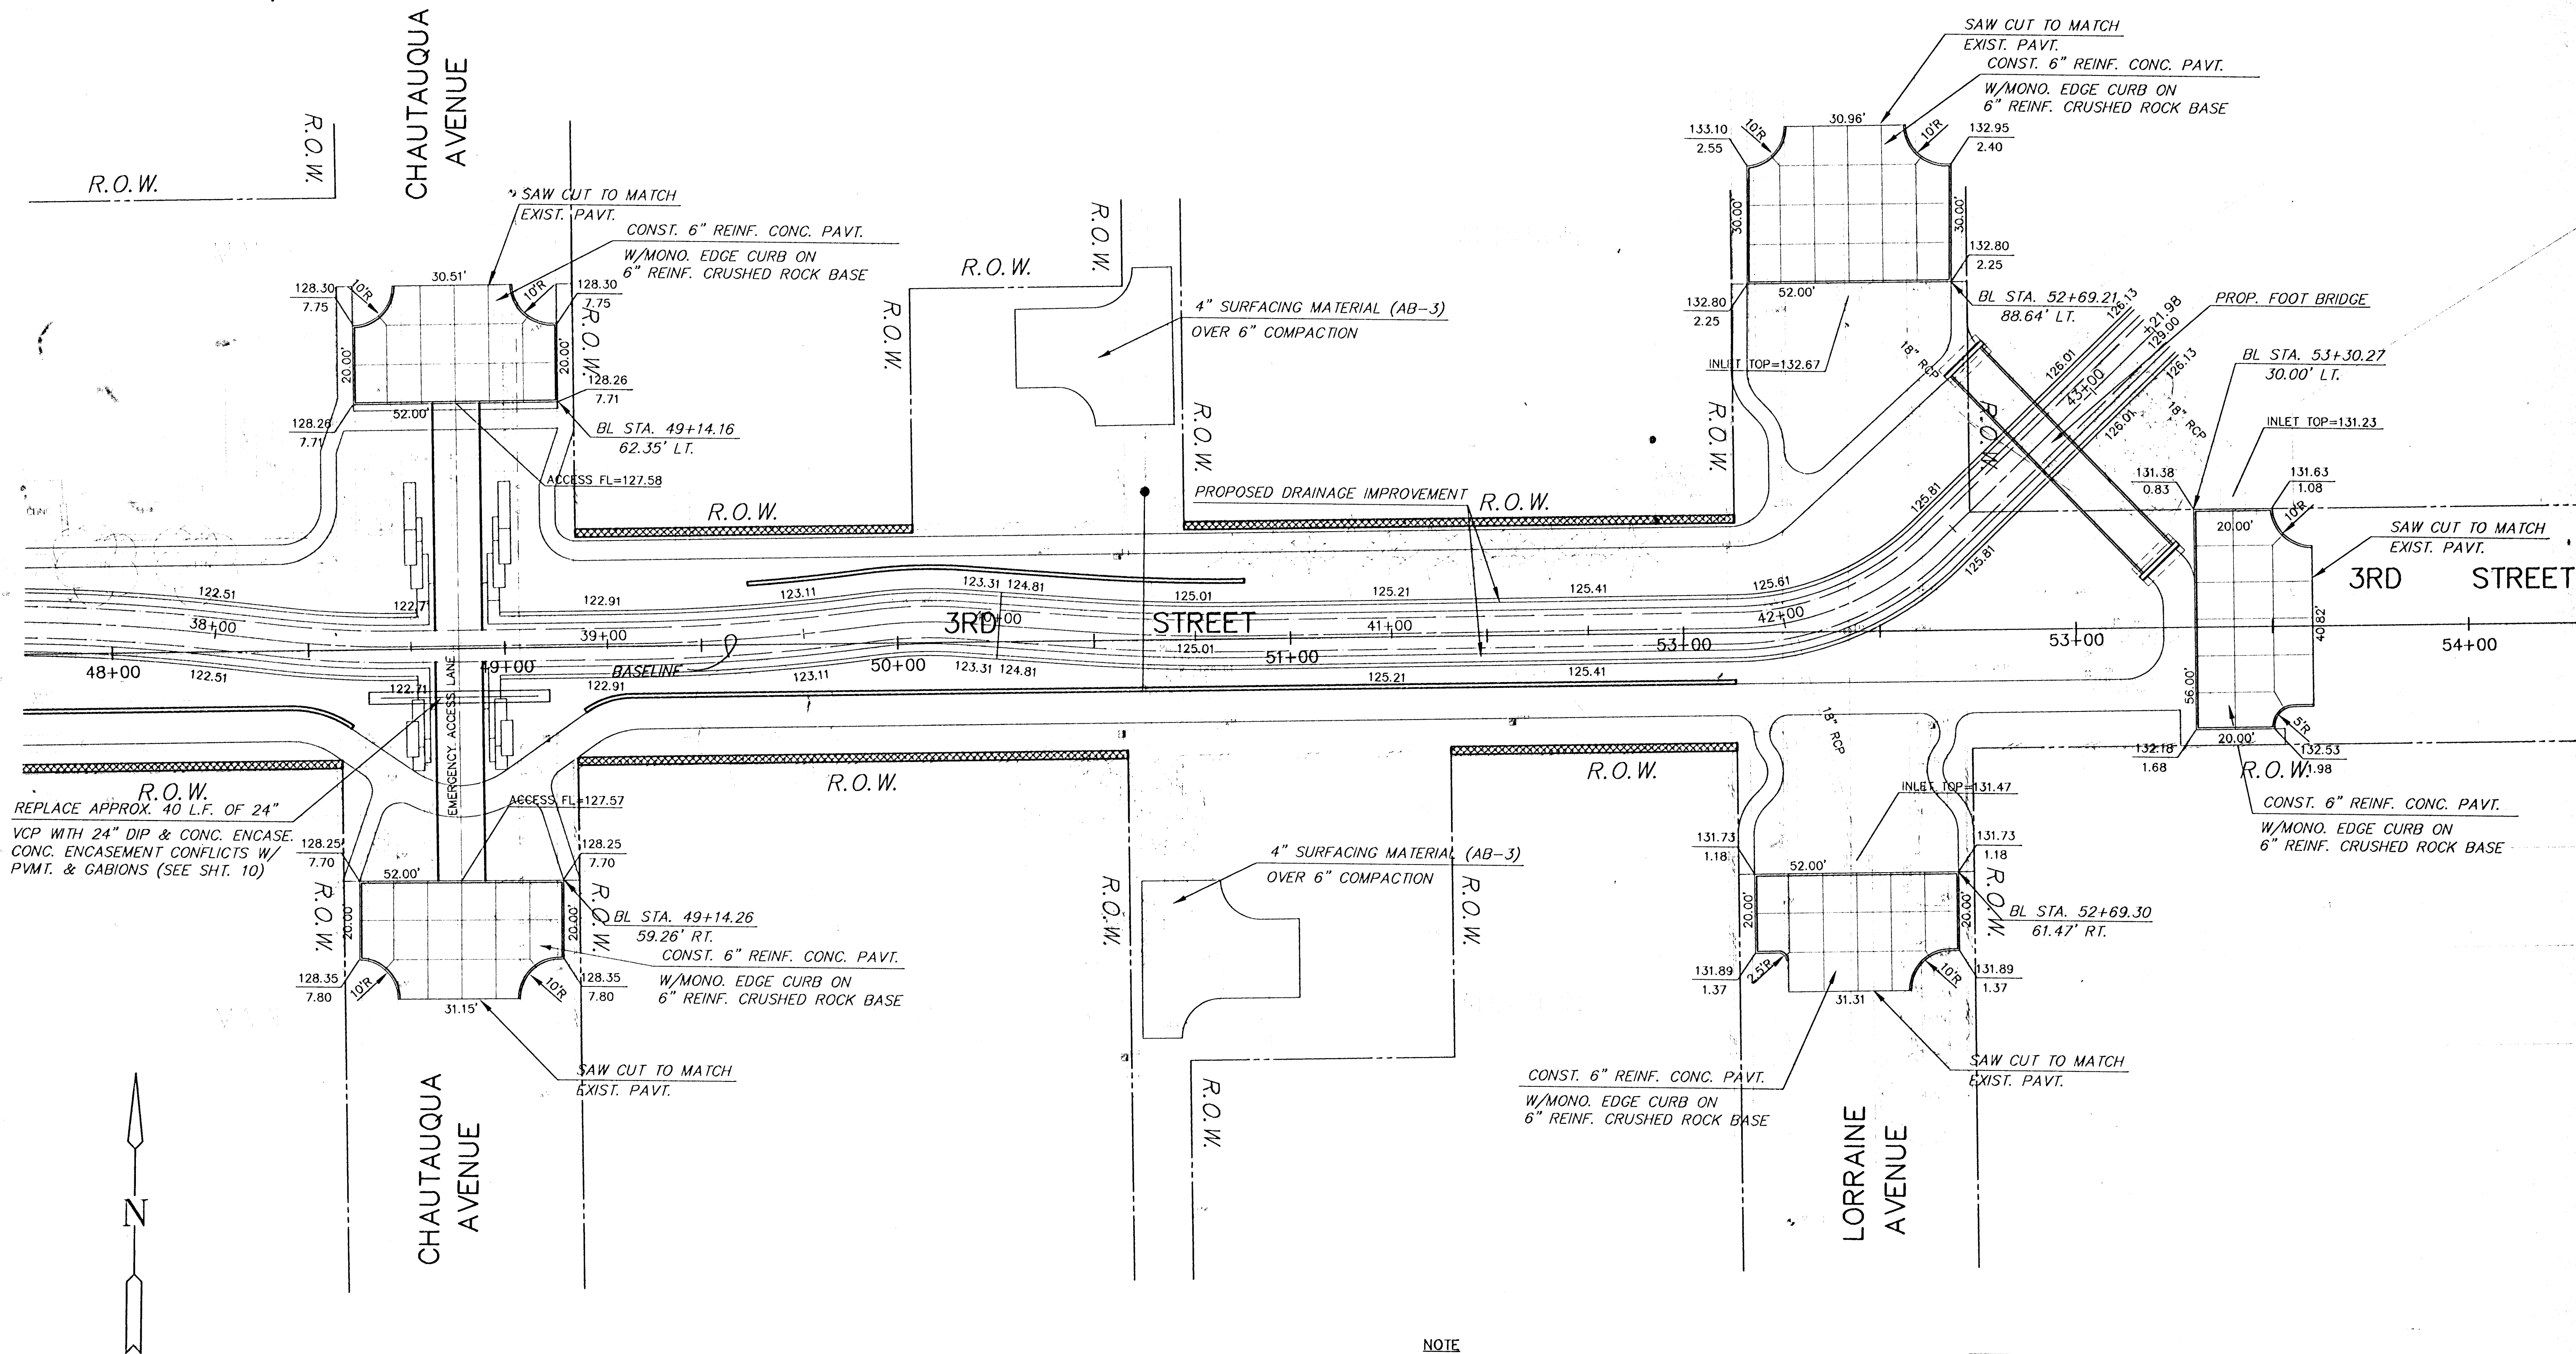

R.O.W.
REPLACE APPROX. 40 L.F. OF 24\"/>

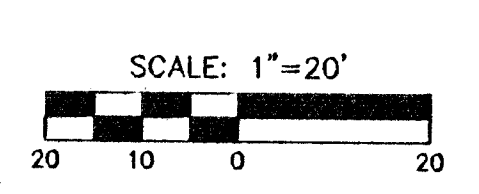

- NOTE**
- CUL-DE-SAC JOINT PATTERN & CONTROL SEE SHEET 31-33
 - CONSTRUCTION OF SANITARY SEWER SEE SHEET 4-10
 - CONSTRUCTION OF STORM WATER SEWER SEE SHEET 11-15
 - CONSTRUCTION OF PAVED CHANNEL SEE SHEET 16-23
 - CONSTRUCTION OF SIDEWALK/PATHWAY SEE SHEET 34-40
 - CONSTRUCTION OF PEDESTRIAN BRIDGE SEE SHEET 41-42
 - INSTALLATION OF LANDSCAPE SEE SHEET 43-49

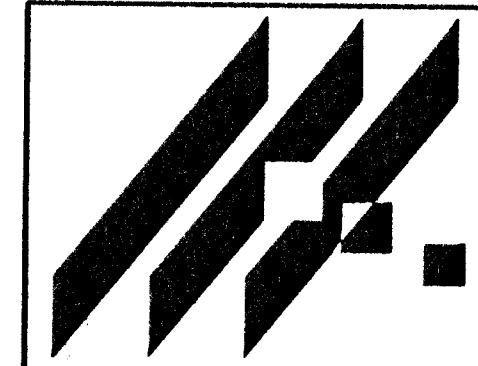

MID-KANSAS ENGINEERING
CONSULTANTS, INC.
411 N. WEBB ROAD
WICHITA, KS. 67206
316-684-9600

3RD STREET DRAINAGE
PROJECT NAME

PAVING PLANS
SHEET TITLE

DSS	KKL	KHB
DESIGN BY:	DRAWN BY:	CHECKED BY:
JUNE, 1996	93031_E7	30 / 77
DATE	JOB NO.	SHEET/OF