

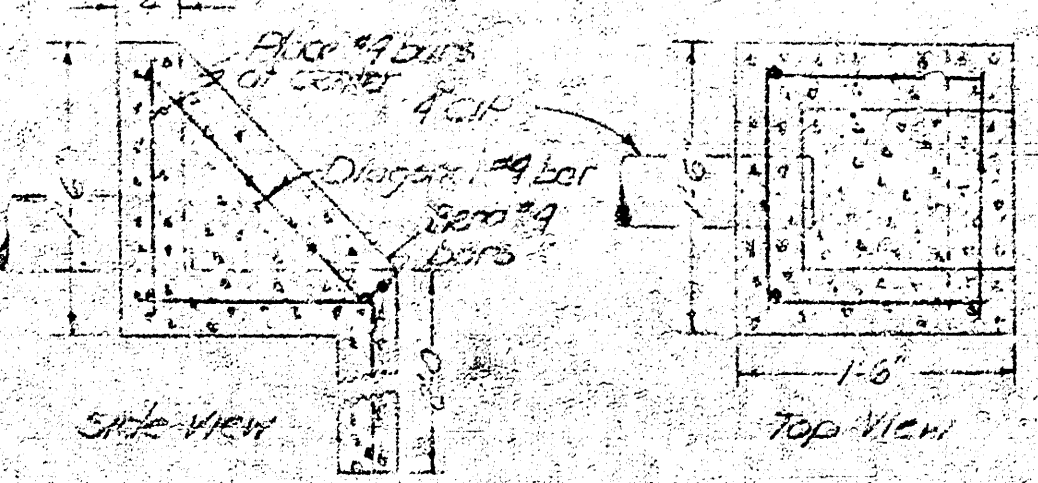


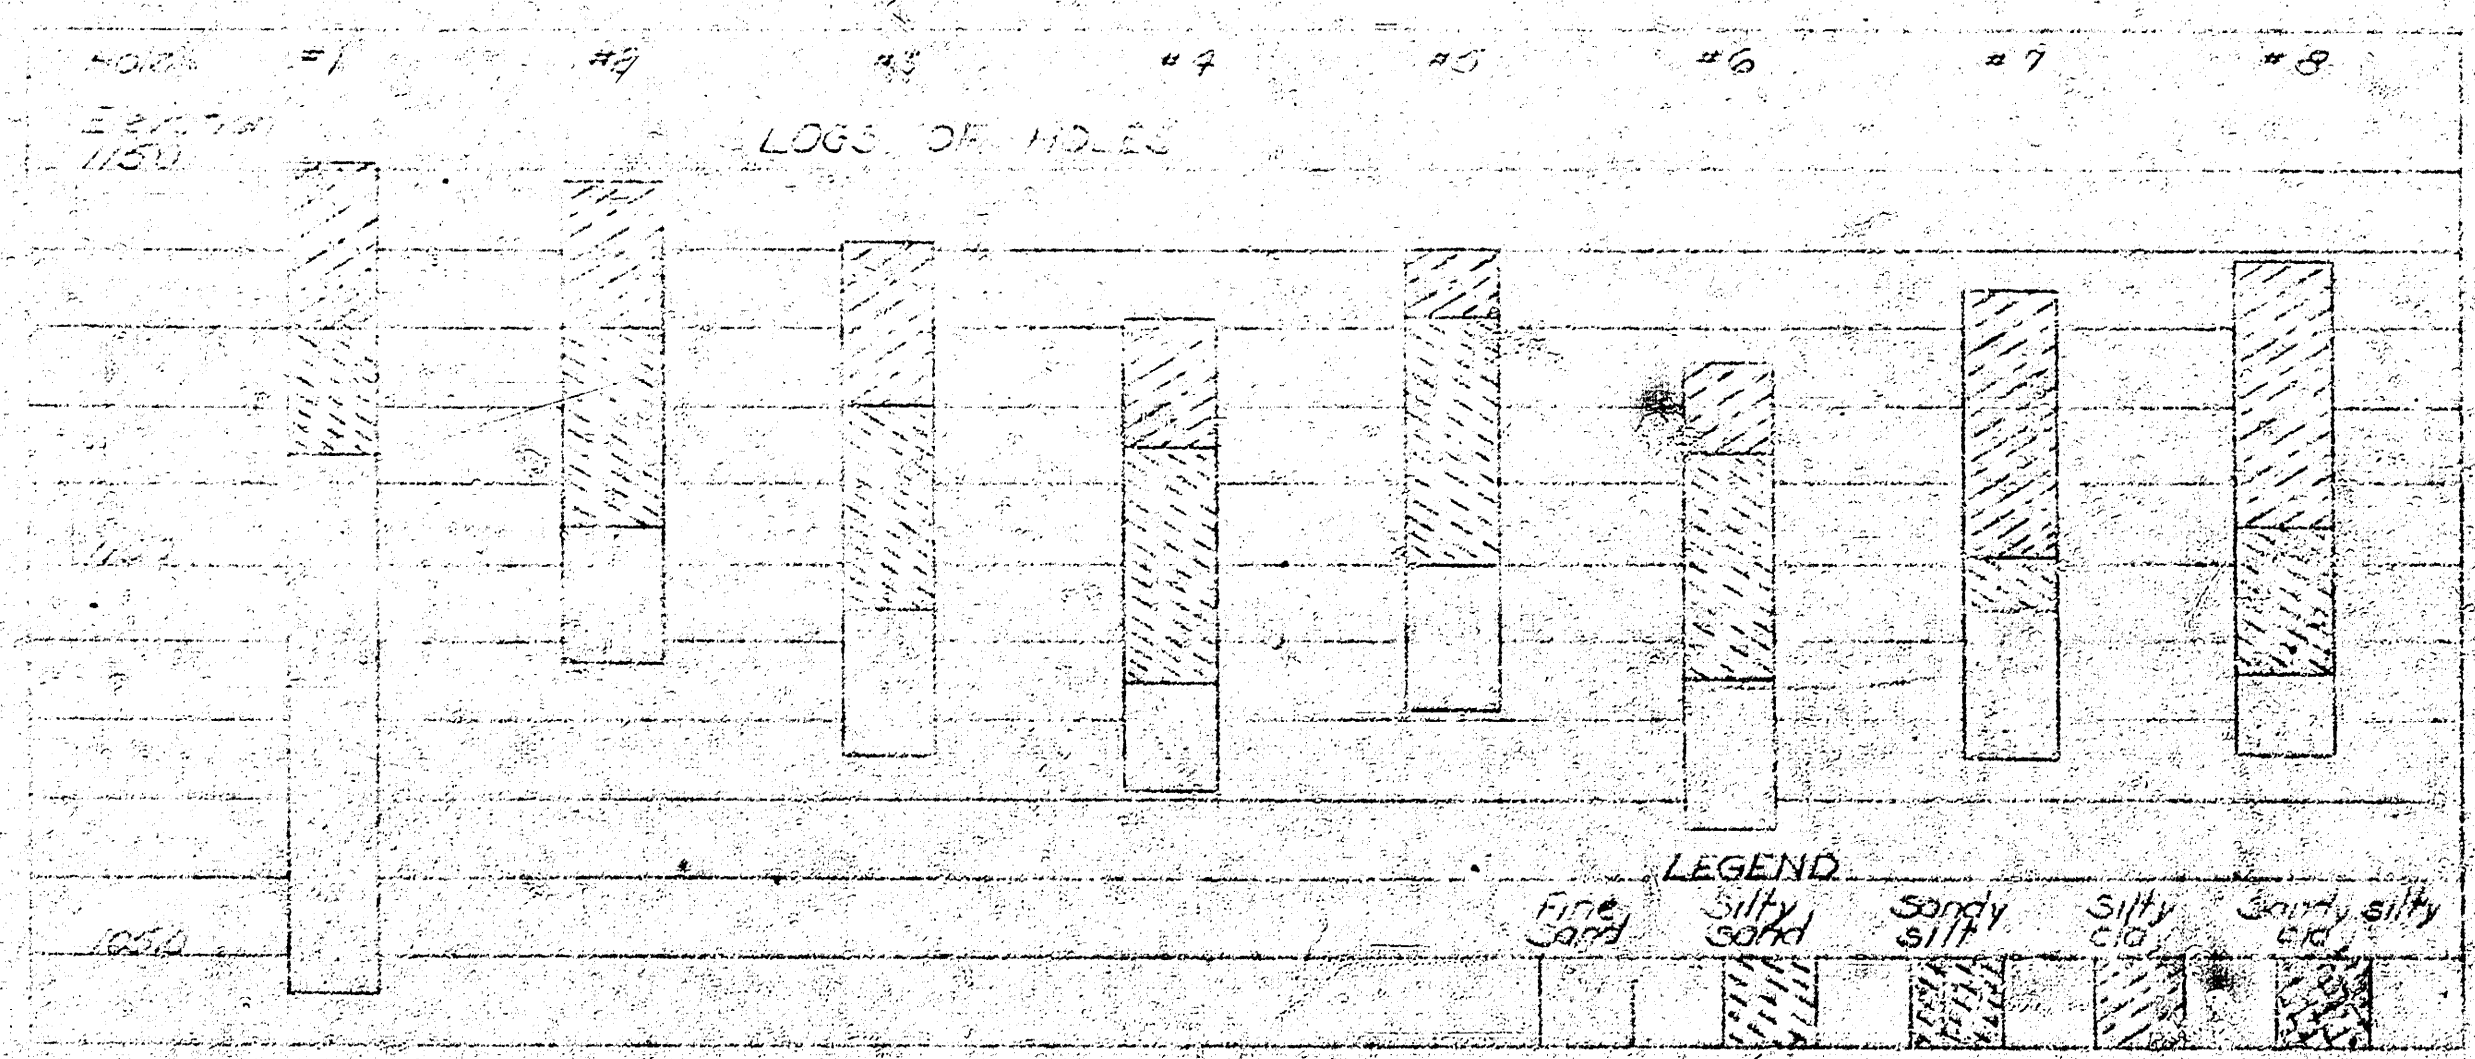

GRADING, DRAINAGE & PAVING PLAN
Scale 1"=50'

- 1. 12" DIA. 10' LONG
- 2. 12" DIA. 10' LONG
- 3. 12" DIA. 10' LONG
- 4. 12" DIA. 10' LONG
- 5. 12" DIA. 10' LONG
- 6. 12" DIA. 10' LONG
- 7. 12" DIA. 10' LONG
- 8. 12" DIA. 10' LONG
- 9. 12" DIA. 10' LONG
- 10. 12" DIA. 10' LONG

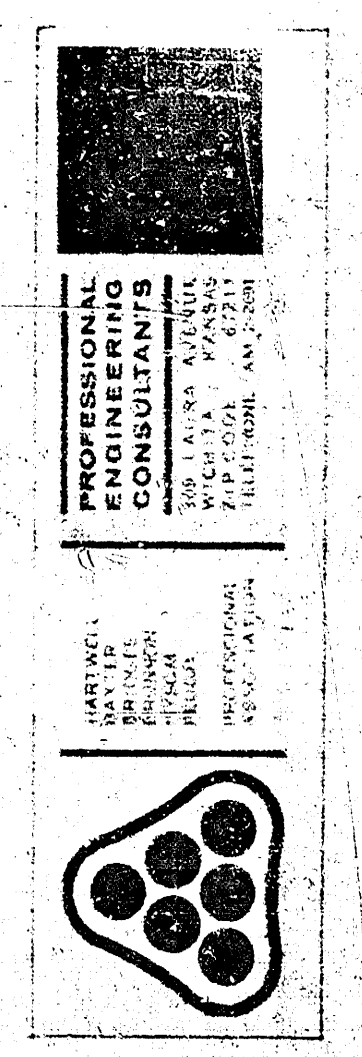

MAINS AND SERVICE BUILDING
FOR THE WICHITA WATER DEPARTMENT
WICHITA, KANSAS

CEA ARCHITECTS AIA
CALVIN PERKINS AND JONES, AIA
1000 S. W. 10TH AVENUE, SUITE 100
WICHITA, KANSAS 67203
ARCHITECT IN CHARGE

PROJECT: MAINS AND SERVICE BUILDING
DATE: 11/1/50
SHEET: 2
OF 15