



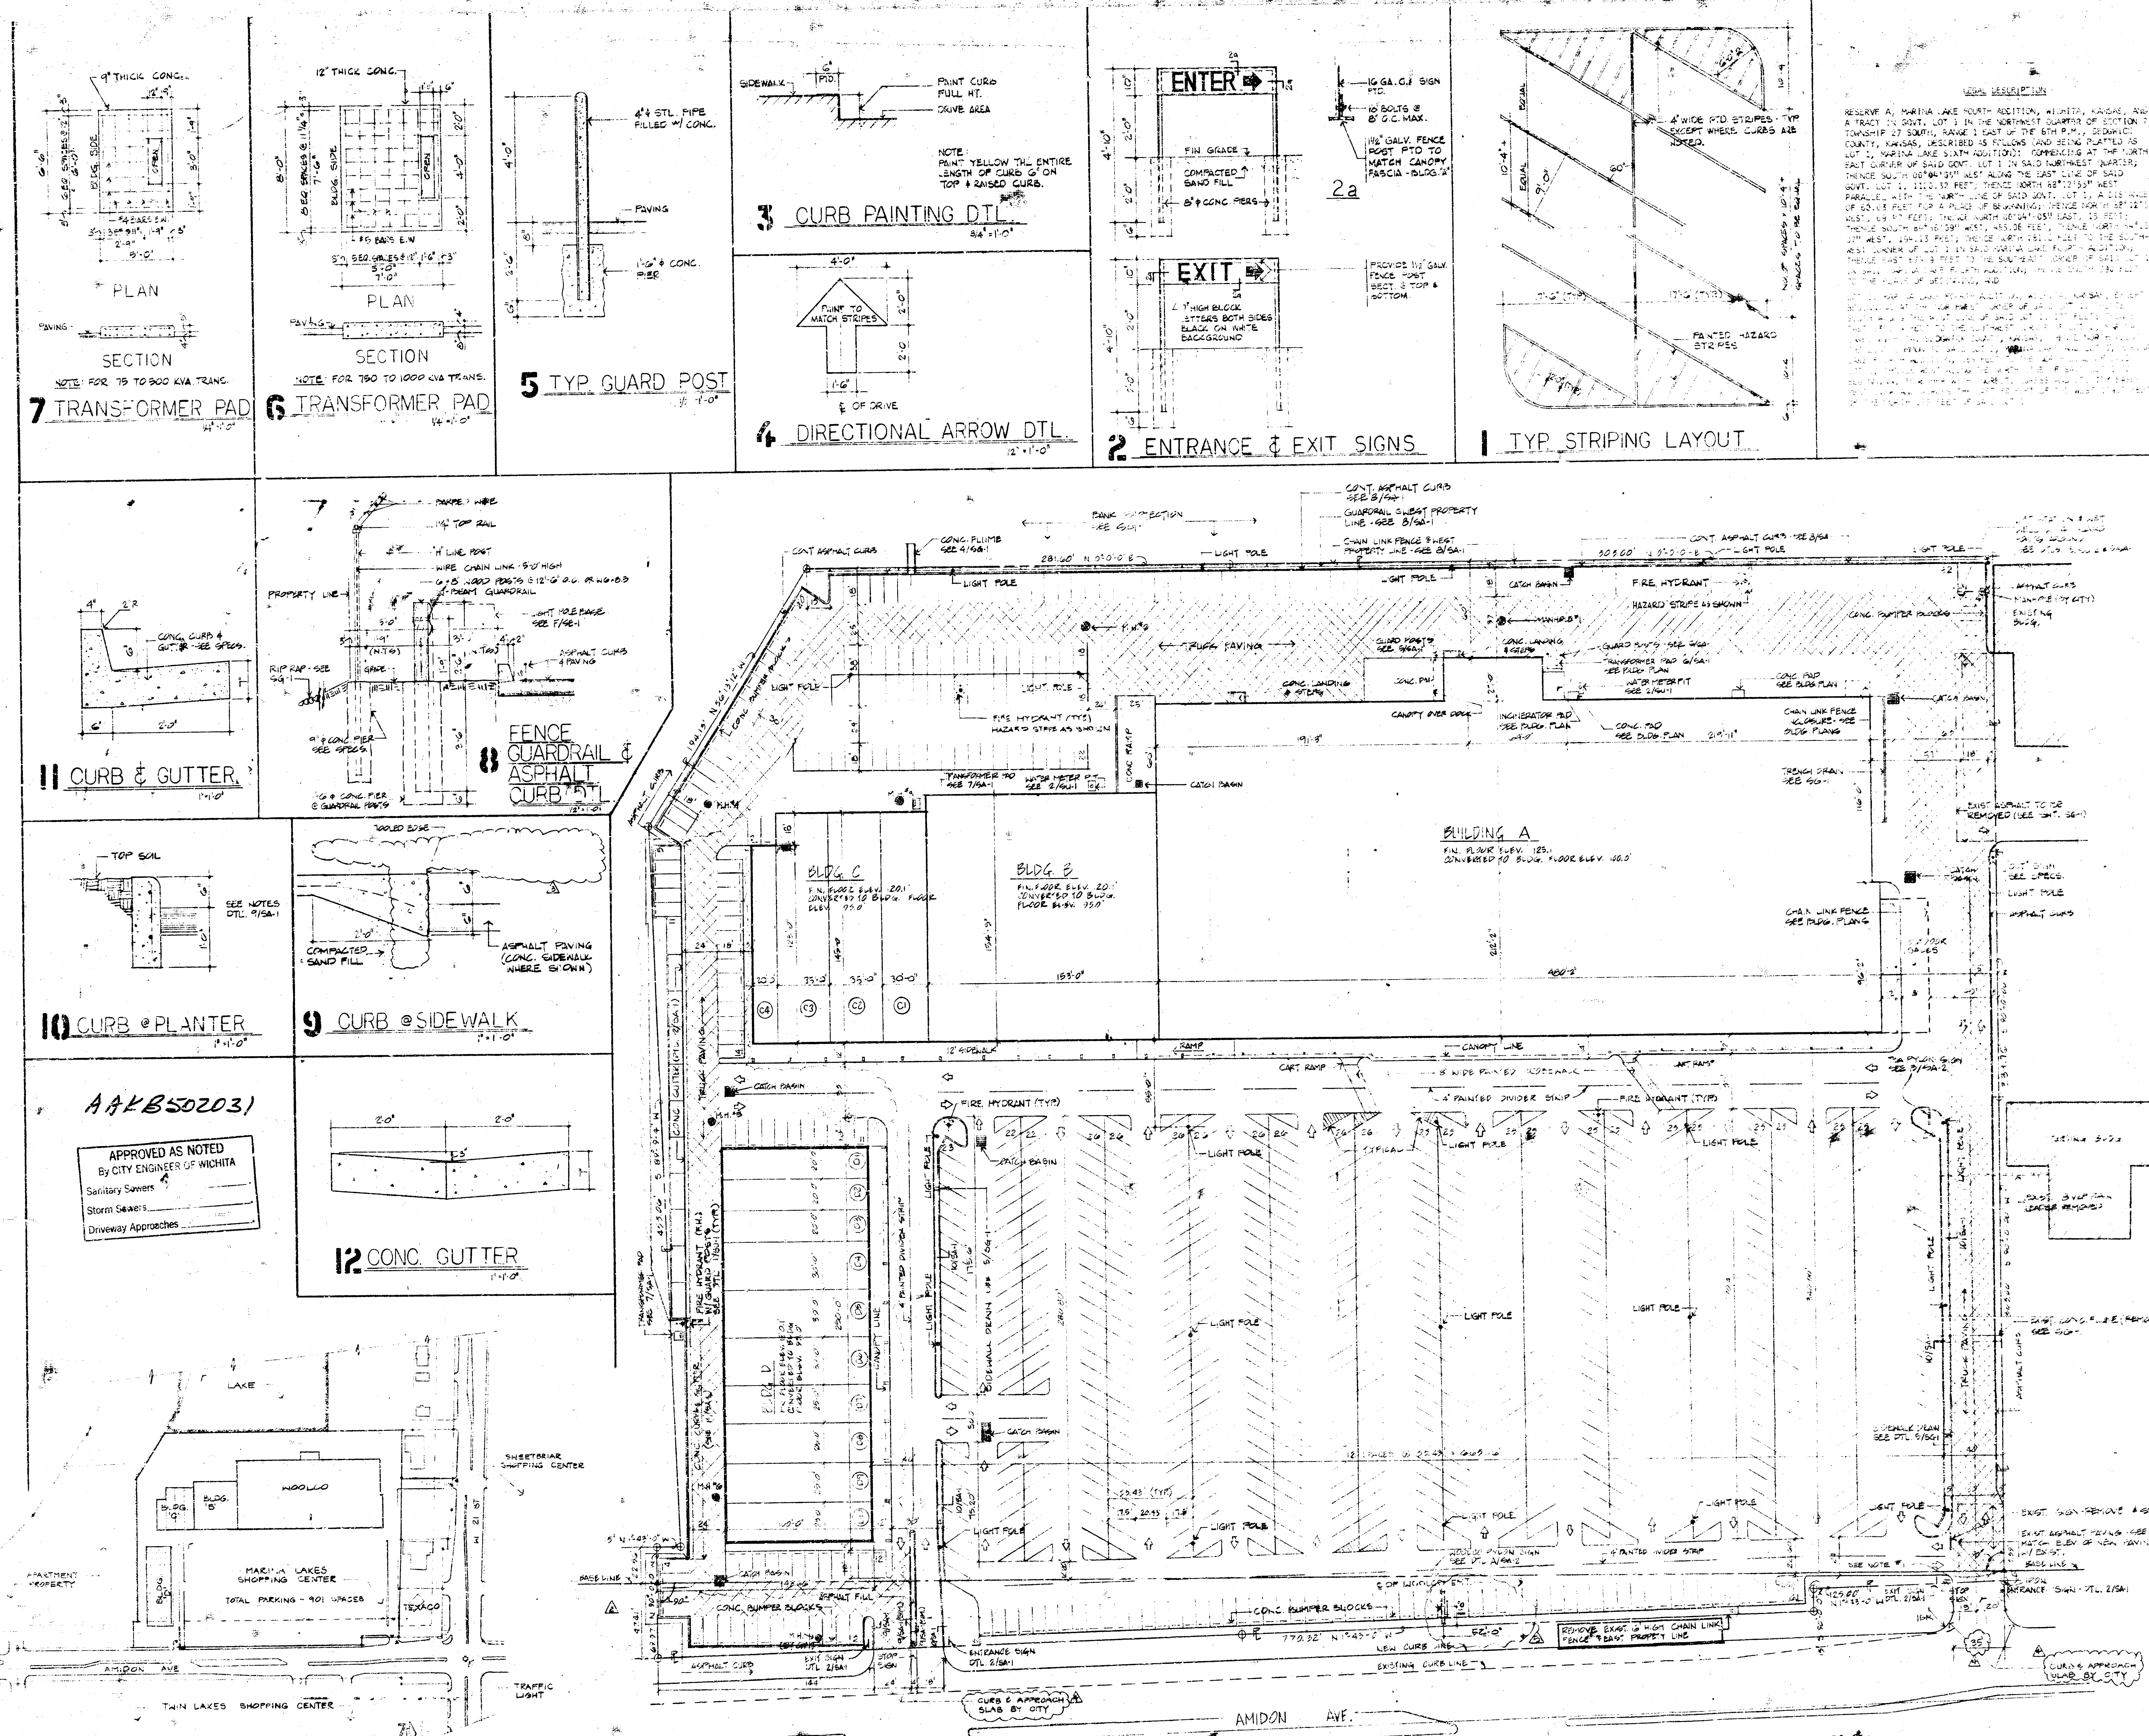


PRINTS ISSUED		
DATE	PURPOSE	NO.
8-10-72	FOR TENDANT NOTIFICATION	1
8-12-72	FOR RECORD - ENGINEER APPROVAL	2
8-21-72	FOR MARKET INSPECTION	3
8-21-72	FOR RESPONSE - CITY	4
8-21-72	FOR LINDSEY'S APPROVAL	5
8-21-72	FOR COMPTON'S APPROVAL	6
8-21-72	FOR TENDANT APPROVAL	7
8-21-72	FOR TENDANT APPROVAL	8
8-21-72	FOR TENDANT APPROVAL	9
8-21-72	FOR TENDANT APPROVAL	10

FOR CONSTRUCTION: 8-25-72

REVISIONS		
DATE	REVISION	NO.
8-10-72	SEE SHEET 1	1
8-10-72	SEE SHEET 1	2
8-10-72	SEE SHEET 1	3
8-10-72	SEE SHEET 1	4
8-10-72	SEE SHEET 1	5
8-10-72	SEE SHEET 1	6
8-10-72	SEE SHEET 1	7
8-10-72	SEE SHEET 1	8
8-10-72	SEE SHEET 1	9
8-10-72	SEE SHEET 1	10

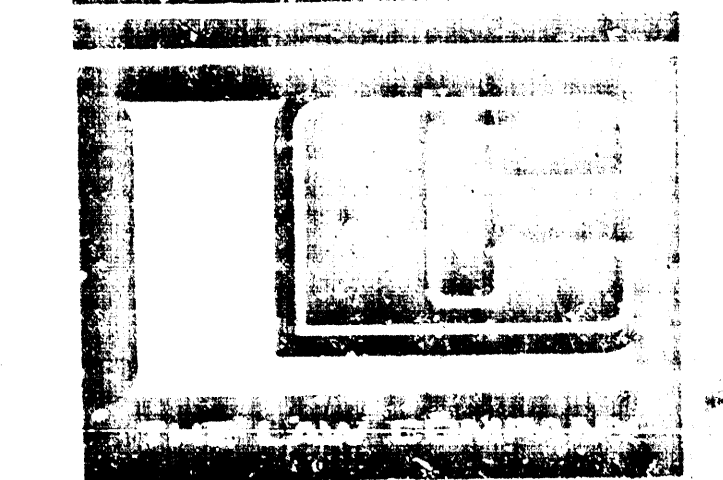

DAVID L. MCWHORTER
WICHITA, KANSAS
ENGINEER

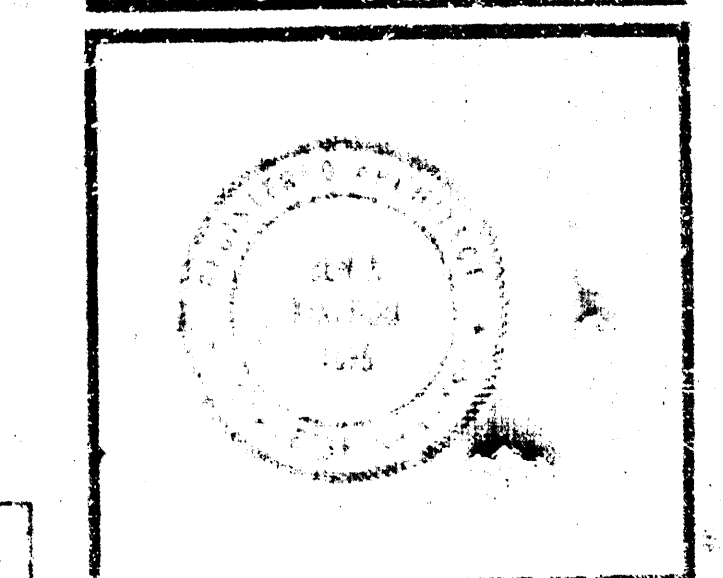










DRAWN		CHECKED	
NO.	BY	NO.	BY
1	CEL		

RELATED DRAWINGS	
SHELL	
DETAILS	
STRUCTURE	
MECHANICAL	
ELECTRICAL	
OTHER	

SEQUENCE NUMBER	
OF	10


MARINA LAKES SHOPPING CENTER	
WICHITA, KANSAS	
PROJECT NUMBER 7201	
KEY PLAN	

TENANT	
SITE PLAN	
TENANT NUMBER	SHEET NUMBER
	SA-1

   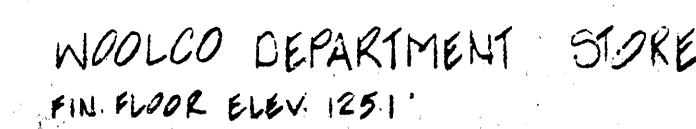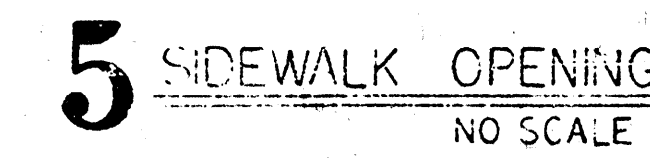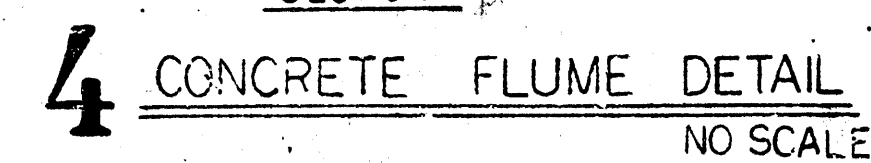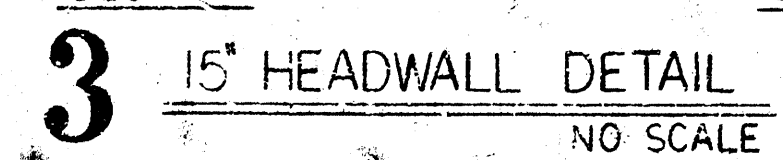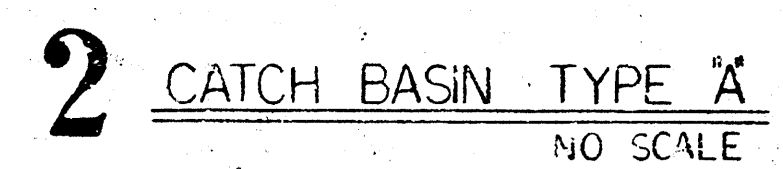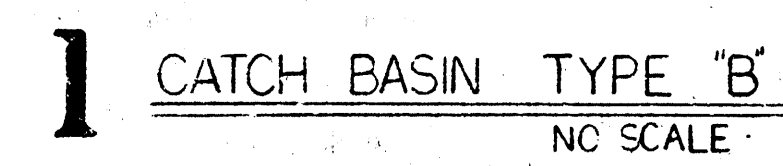

PRINTS ISSUED		
DATE	PURPOSE	NO.
2-10-72	FOR TENANT INFORMATION	
3-10-72	FOR CITY NATIONAL	2
5-21-72	FOR CITY APPROVAL	4
6-23-72	FOR INSURANCE EVAL	4
8-9-72	FOR CONSULTATION	58
1-8-73	FOR LAMON ENG'G	3

FOR CONSTRUCTION: 5-5-72

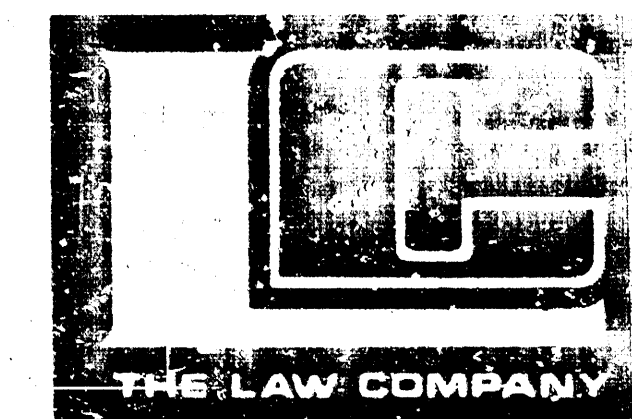
[illegible]

**CALVIN
KINDSON
SEDER** | P.A. 313 S. MARKET
WICHITA, KANS. 67202
PHONE 313/266-8884
ARCHITECTS & ENGINEERS


DRAWN		CHECKED	
DUTTON		RF	CAR
RELATED DRAWINGS			
SHELL			
DETAILS			
STRUCTURE			
MECHANICAL			
ELECTRICAL			
OTHER			
SEQUENCE NUMBER			
		Of _____ SHEETS	

**MARINA LAKES
SHOPPING CENTER**


WICHITA, KANSAS

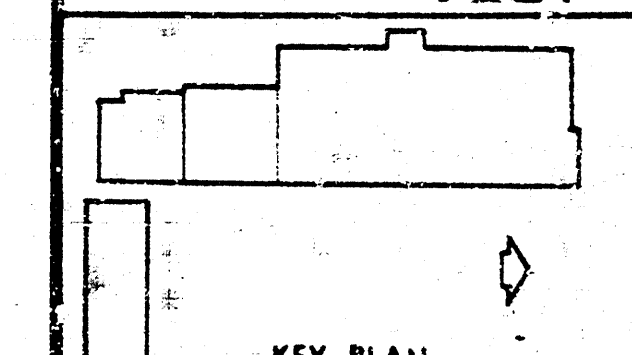


TENANT	
SITE GRADING PLAN	
SHEET TITLE	
TENANT NUMBER	SHEET NUMBER
	SG-1

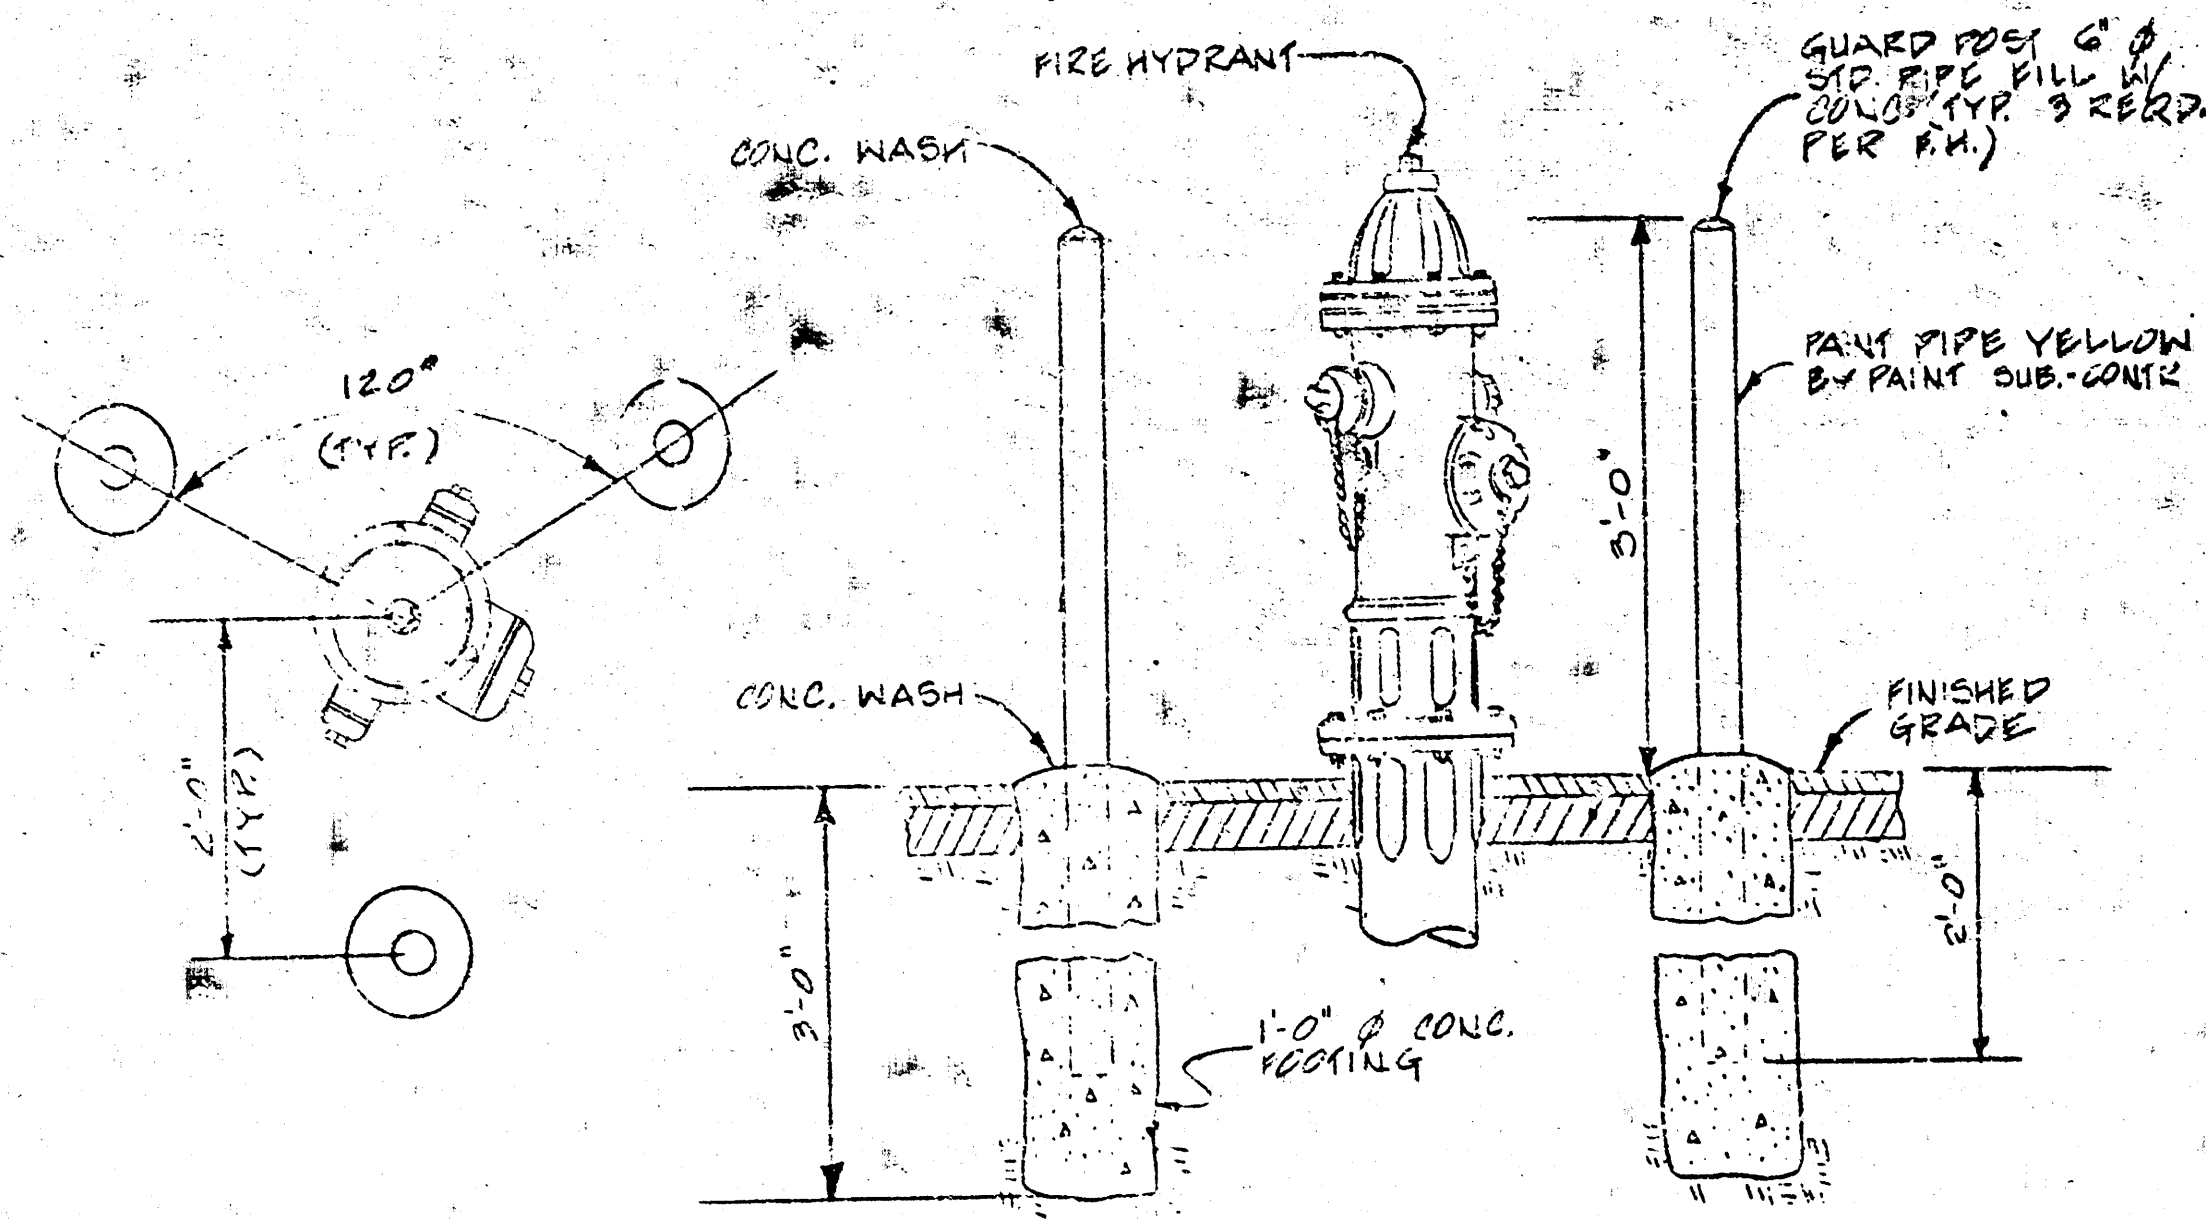


1 GUARD POST DETAIL
NO SCALE

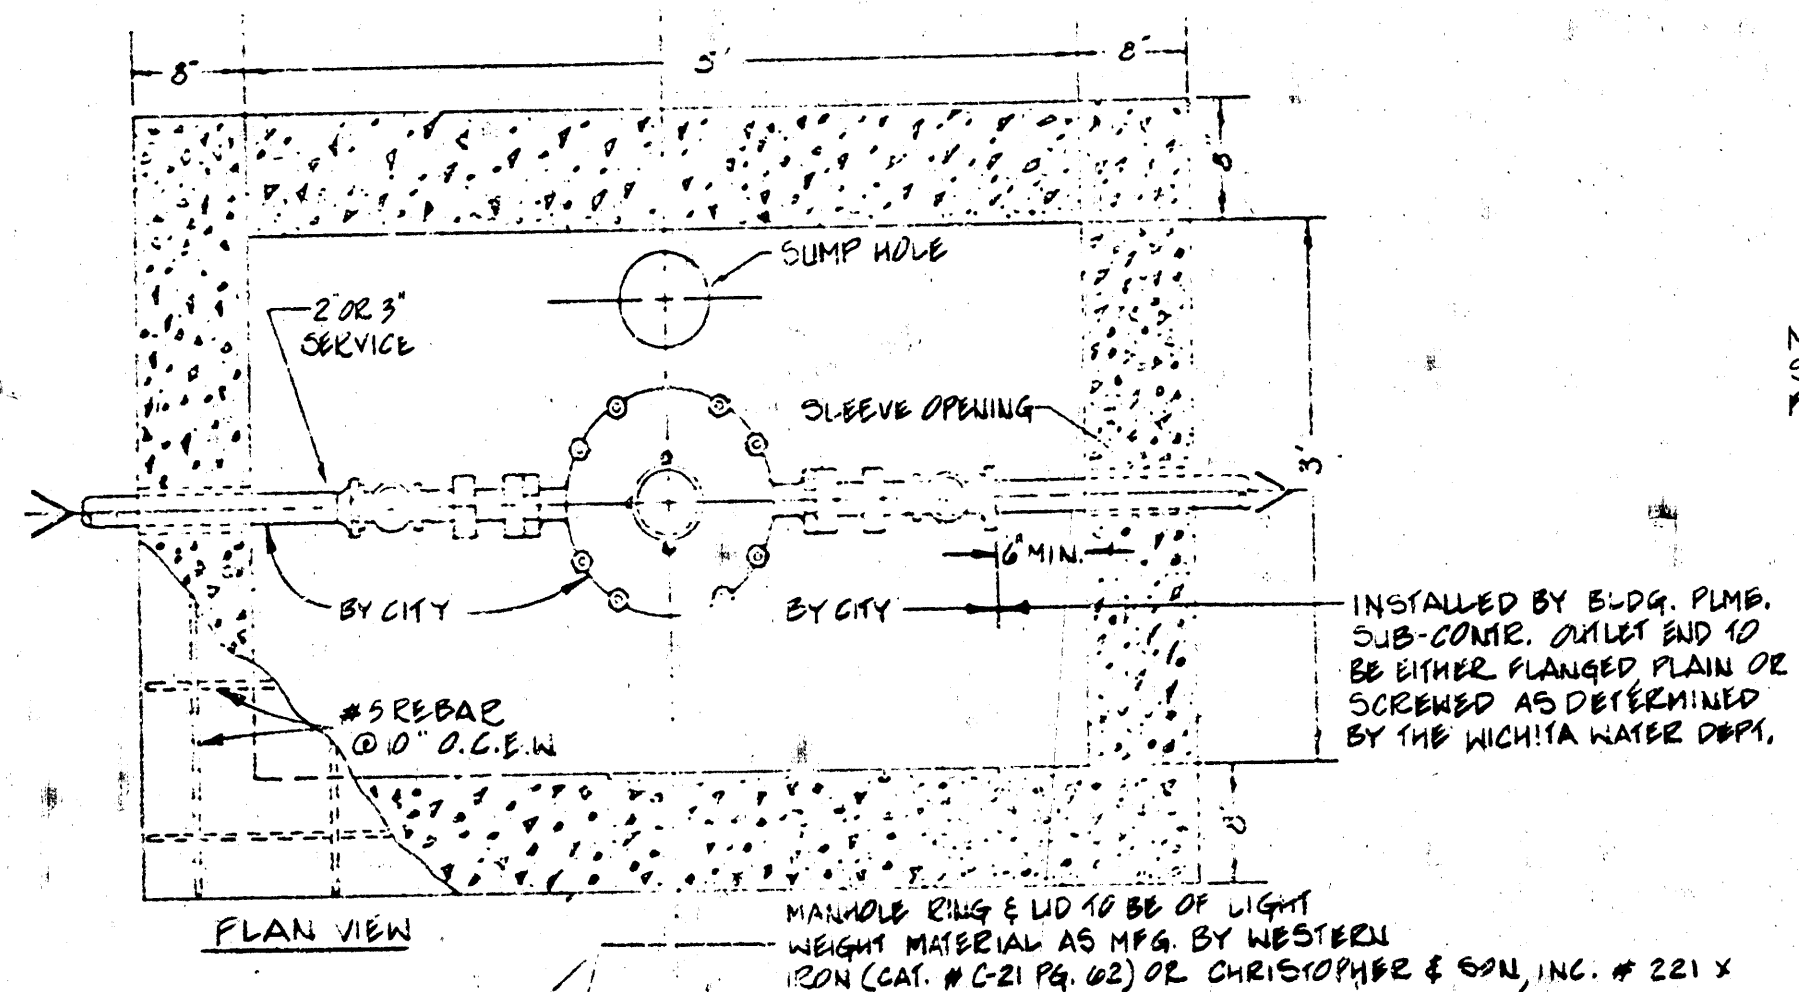

2 WATER METER PIT DETAIL
NO SCALE

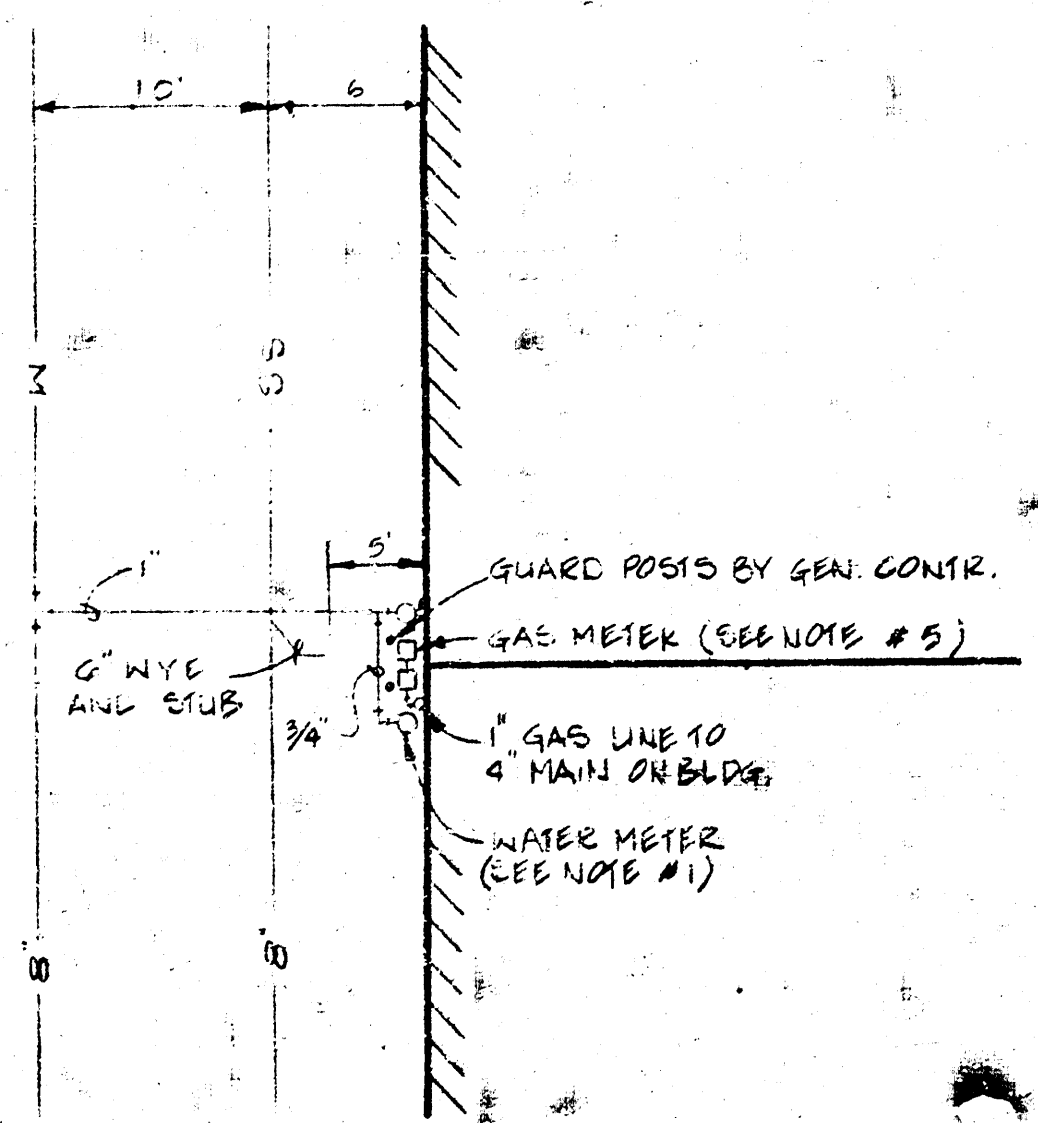

3 TYPICAL SERVICE DETAIL FOR SHOPS
NO SCALE

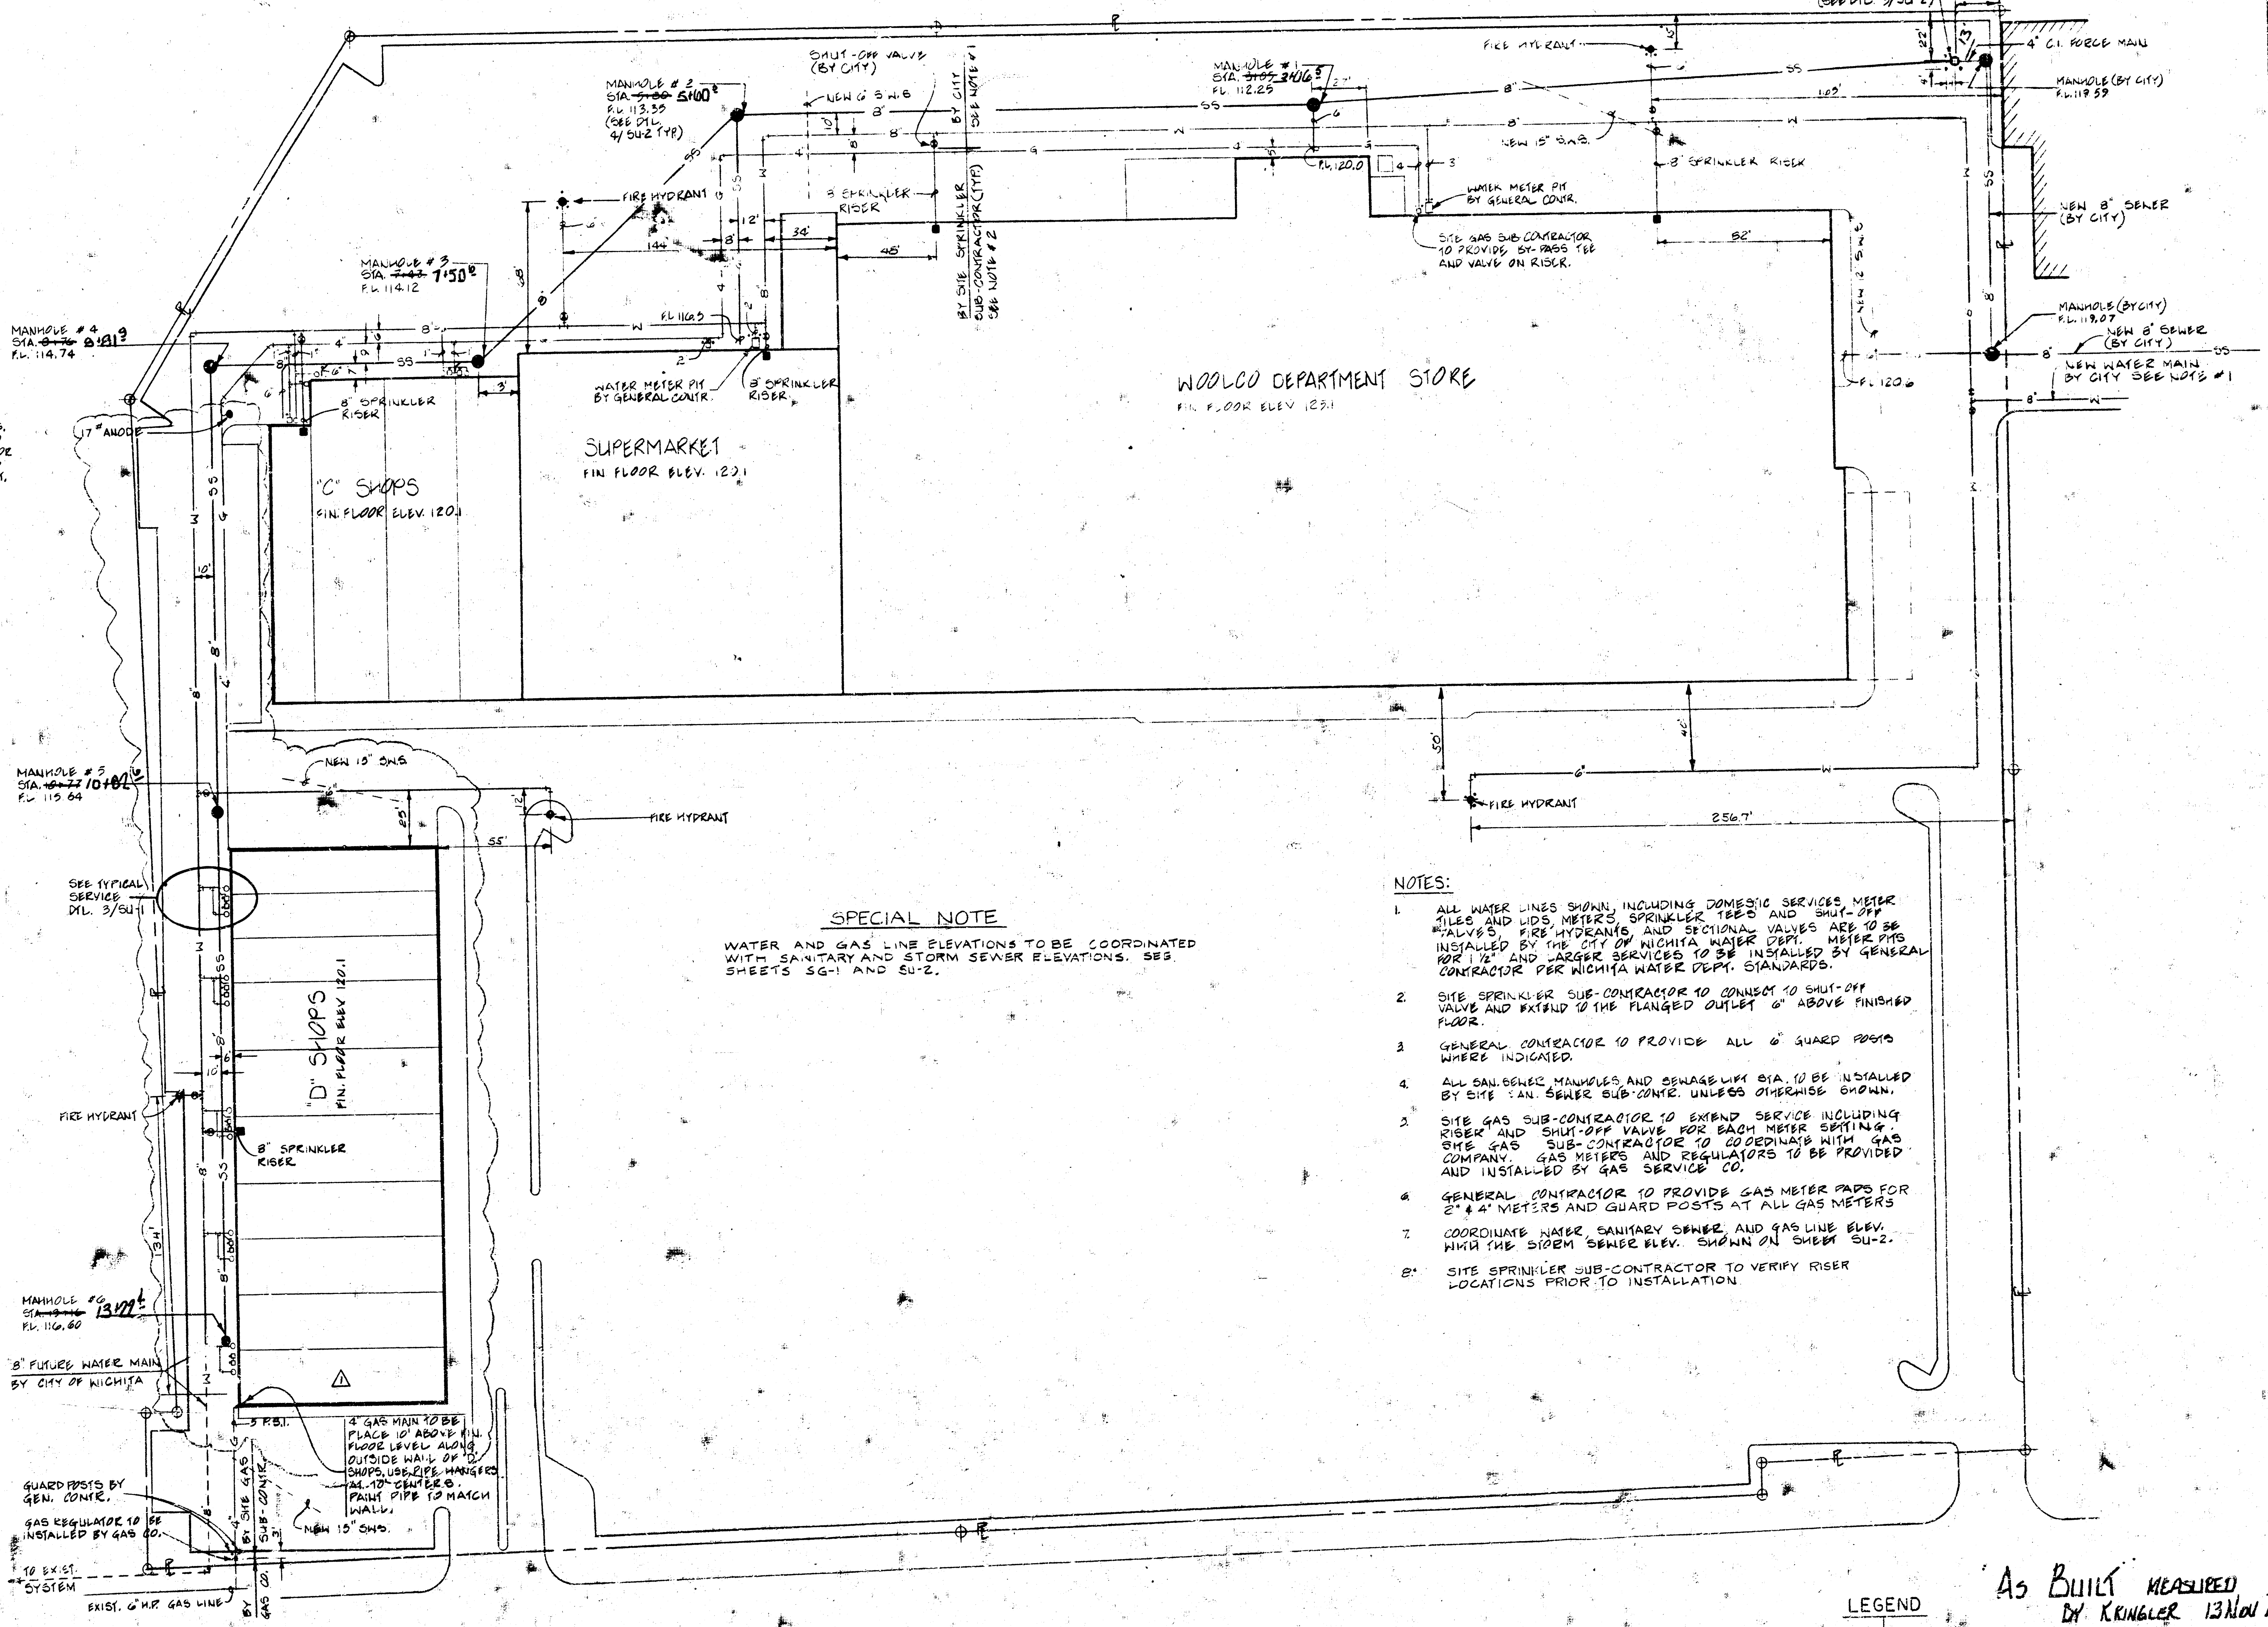

SPECIAL NOTE
WATER AND GAS LINE ELEVATIONS TO BE COORDINATED WITH SANITARY AND STORM SEWER ELEVATIONS. SEE SHEETS SG-1 AND SU-2.

- NOTES:**
1. ALL WATER LINES SHOWN INCLUDING DOMESTIC SERVICES, METER LINES AND WDS METERS, SPRINKLER RISERS AND SHUT-OFF VALVES, FIRE HYDRANTS AND SECTIONAL VALVES ARE TO BE INSTALLED BY THE CITY OF WICHITA WATER DEPT. METER PITS FOR 1/2" AND LARGER SERVICES TO BE INSTALLED BY GENERAL CONTRACTOR PER WICHITA WATER DEPT. STANDARDS.
 2. SITE SPRINKLER SUB-CONTRACTOR TO CONNECT TO SHUT-OFF VALVE AND EXTEND TO THE FLANGED OUTLET 6" ABOVE FINISHED FLOOR.
 3. GENERAL CONTRACTOR TO PROVIDE ALL 6" GUARD POSTS WHERE INDICATED.
 4. ALL SAN SEWER MANHOLES AND SEWAGE LIFT STA. TO BE INSTALLED BY SITE SAN. SEWER SUB-CONTRACTOR, UNLESS OTHERWISE SHOWN.
 5. SITE GAS SUB-CONTRACTOR TO EXTEND SERVICE INCLUDING RISER AND SHUT-OFF VALVE FOR EACH METER SETTING. THE GAS SUB-CONTRACTOR TO COORDINATE WITH GAS COMPANY. GAS METERS AND REGULATORS TO BE PROVIDED AND INSTALLED BY GAS SERVICE CO.
 6. GENERAL CONTRACTOR TO PROVIDE GAS METER PADS FOR 2" & 4" METERS AND GUARD POSTS AT ALL GAS METERS.
 7. COORDINATE WATER, SANITARY SEWER, AND GAS LINE ELEV. WITH THE SEWER ELEV. SHOWN ON SHEET SU-2.
 8. SITE SPRINKLER SUB-CONTRACTOR TO VERIFY RISER LOCATIONS PRIOR TO INSTALLATION.

LEGEND

As Built Measured
BY KRINGLER 13/NOV/22

REVISIONS	
DATE	ITEM
2-15-72	15078 6-11-72
3-27-72	15078 6-11-72
5-3-72	15078 6-11-72

FOR CONSTRUCTION

DATE	ITEM
2-15-72	15078 6-11-72
3-27-72	15078 6-11-72
5-3-72	15078 6-11-72

ARCHITECTS & ENGINEERS

CALVIN LINDEN PA
BERNARD
ARCHITECTS & ENGINEERS

215 S. WASH.
WICHITA, KANSAS 67202
PHONE 276-8888

DRAWN	CHECKED
DTN	PDF

RELATED DRAWINGS

SHELL	DETAILS	STRUCTURE	MECHANICAL	ELECTRICAL	OTHER

SEQUENCE NUMBER

05

MARINA LAKE SHOPPING CENTER


WICHITA, KANSAS

PROJECT NUMBER 720


KEY PLAN

TENANT


SITE UTILITY PLAN

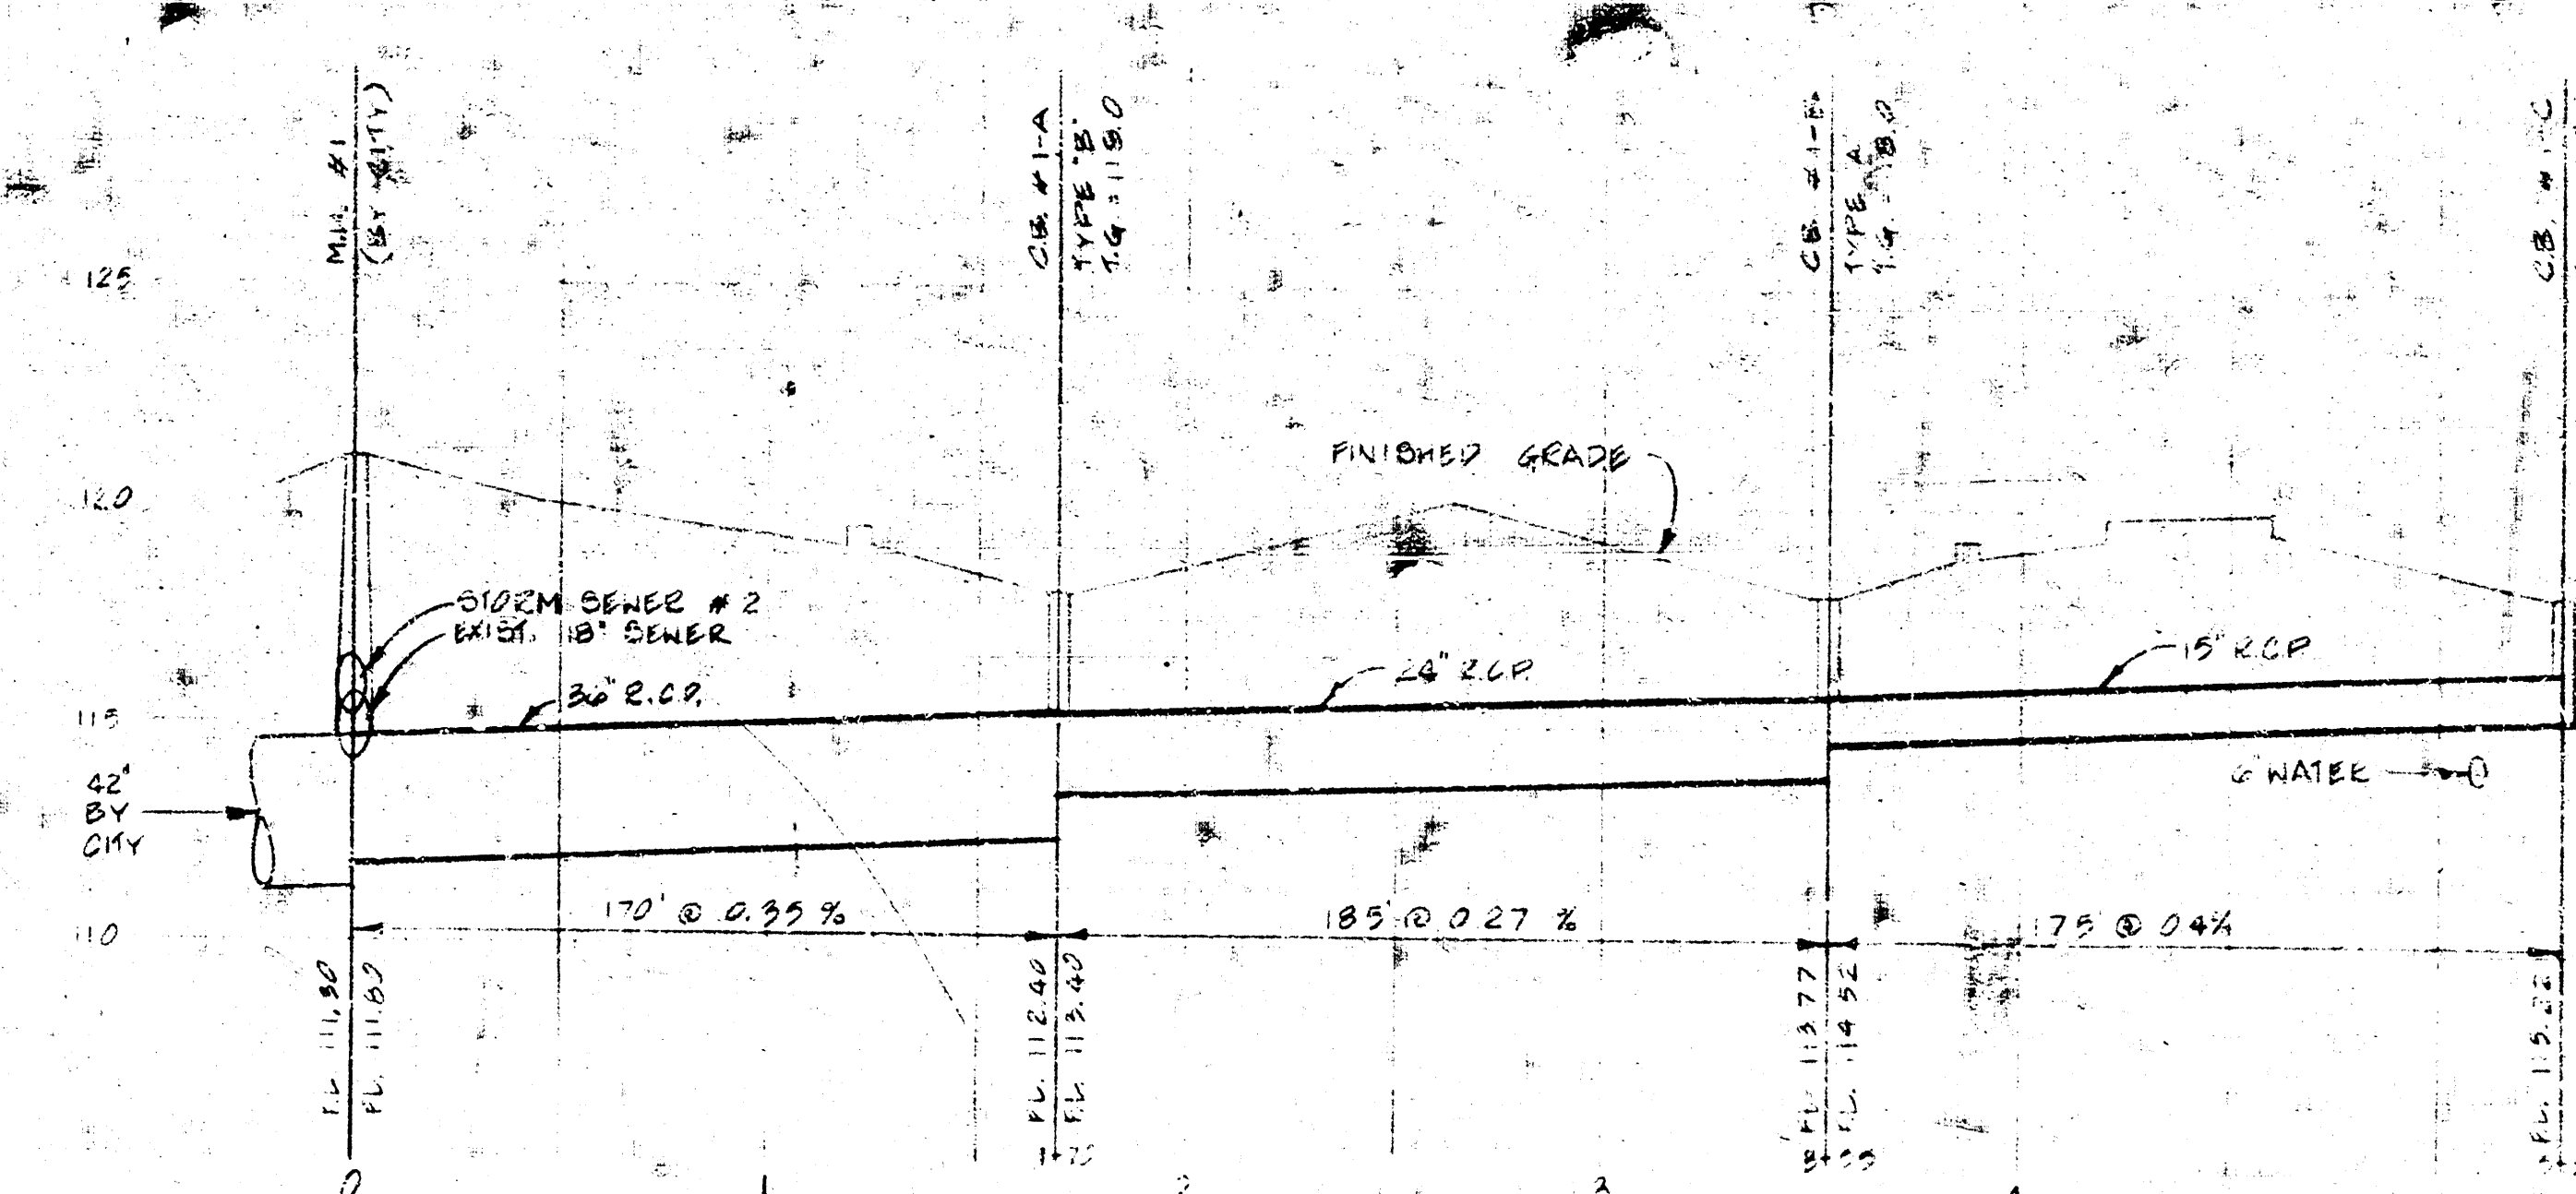

1 SANITARY SEWER PROFILE

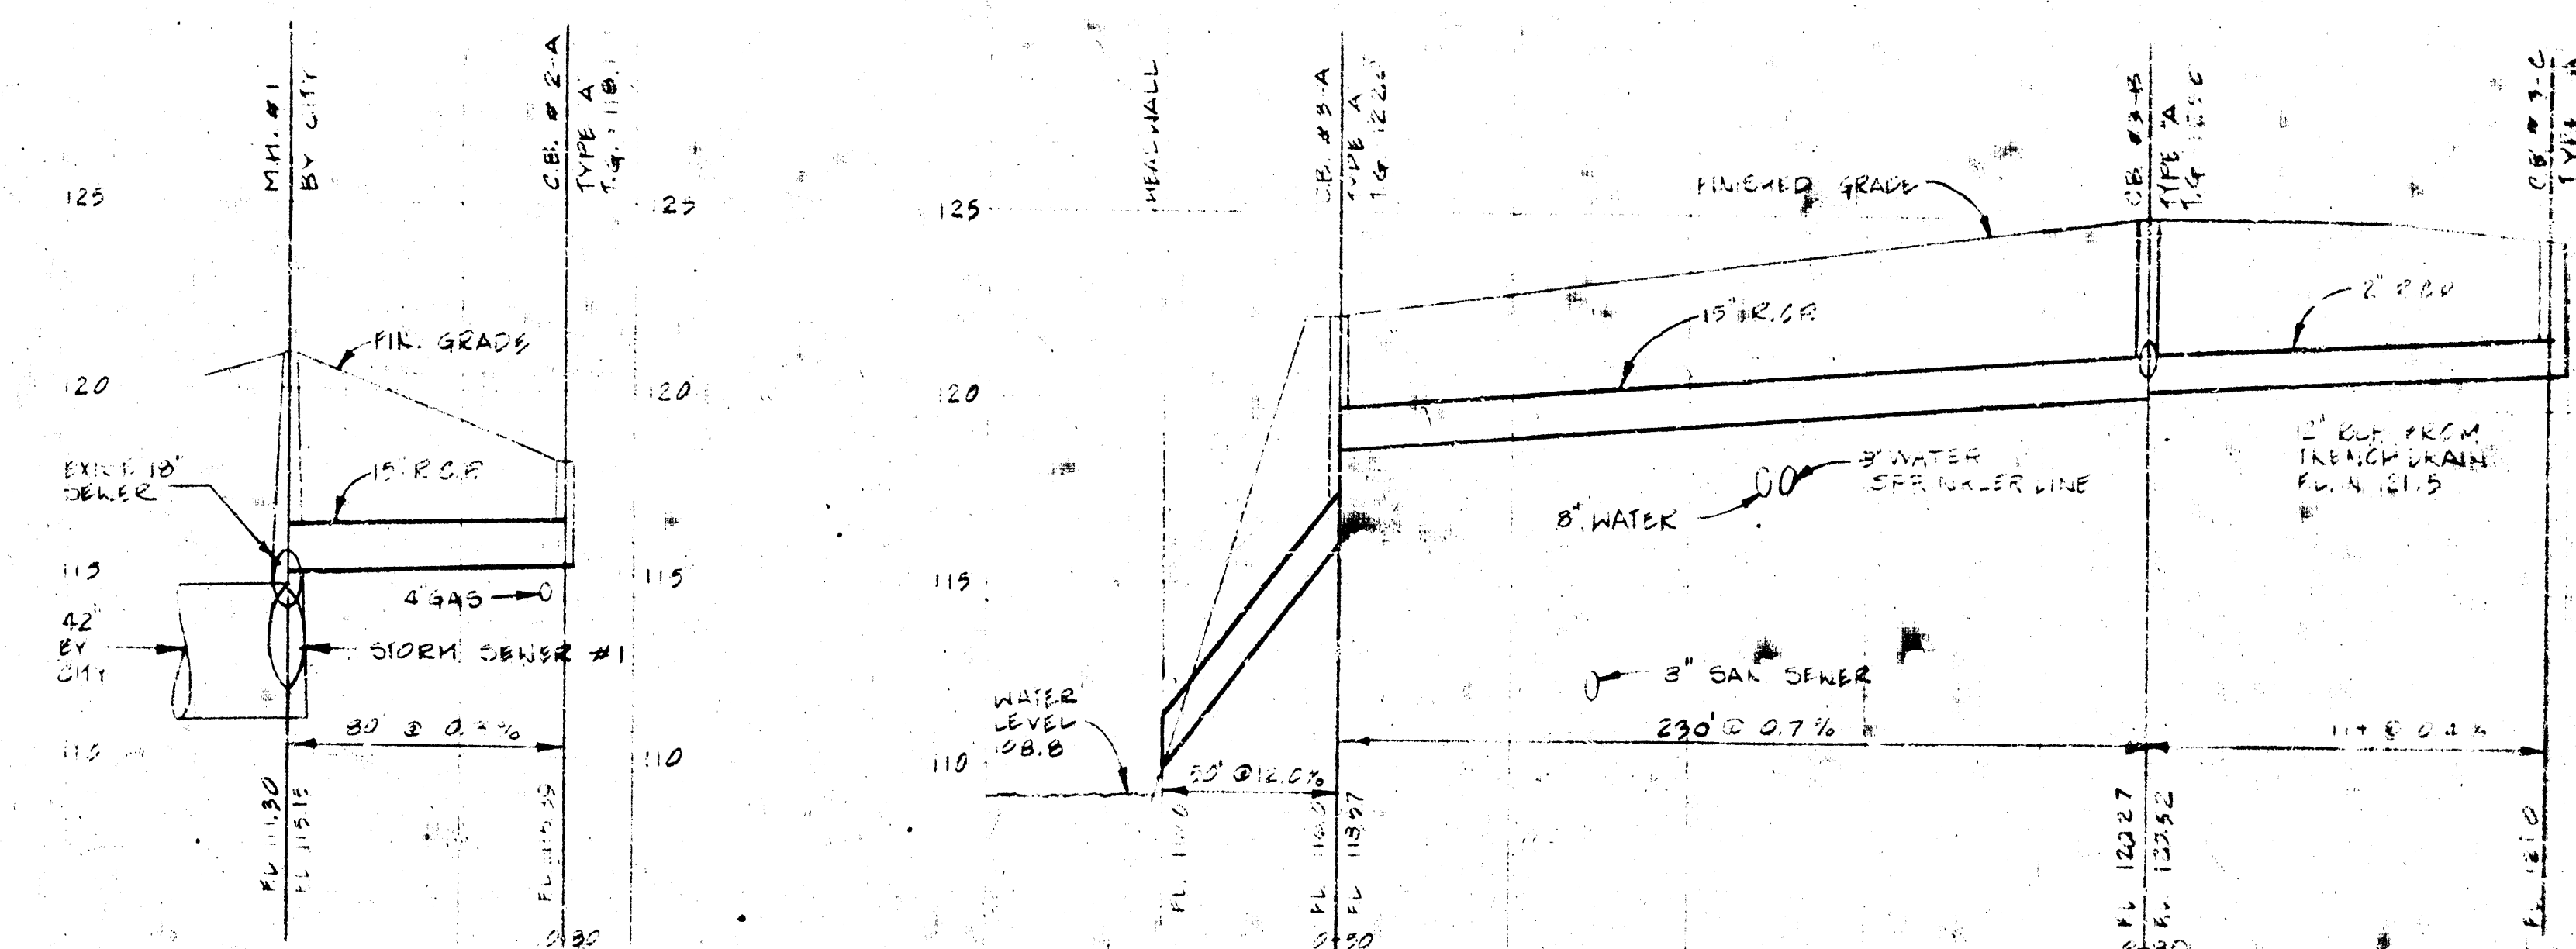

STORM SEWER # 3

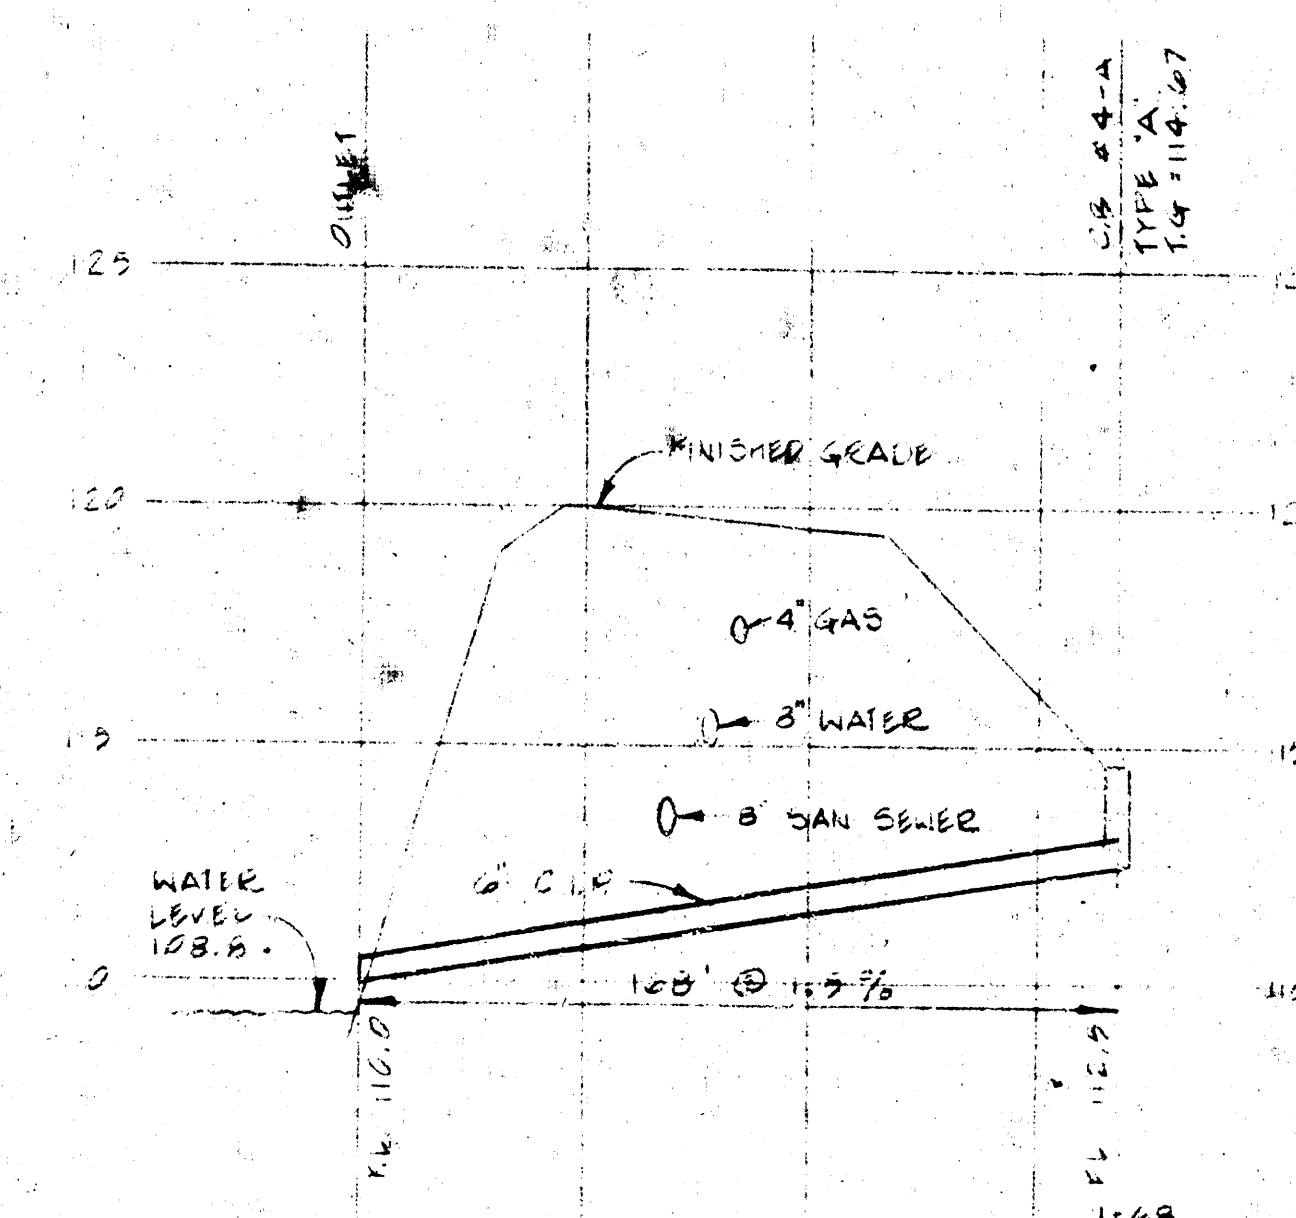

STORM SEWER #4

2 STORM SEWER PROFILES

4 TYPE "A" MANHOLE
NO SCALE

[illegible]

FOR CONSTRUCTION

[illegible]

CALVIN KINGDON P.A.
MERGER
ARCHITECTS & ENGINEERS

DRAWN		CHECKED	
DATE		BY	
RELATED DRAWINGS			
SHELL			
DETAILS			
STRUCTURE			
MECHANICAL			
ELECTRICAL			
OTHER			
SEQUENCE NUMBER			

**MARINA LAKE
SHOPPING CENT**

WICHITA, KANSAS

PROJECT NUMBER 72

1	2	3	466
---	---	---	---	---	---	---	---	---	----	----	-----	-----	
100

114 JOURNAL OF DOCUMENTATION

100

100

KEY PLAN

1992, 1993, 1994, 2673, 26

...the ...