


PROJECT NO.	SHEET NO.	TOTAL SHEETS
472-83255	3	66

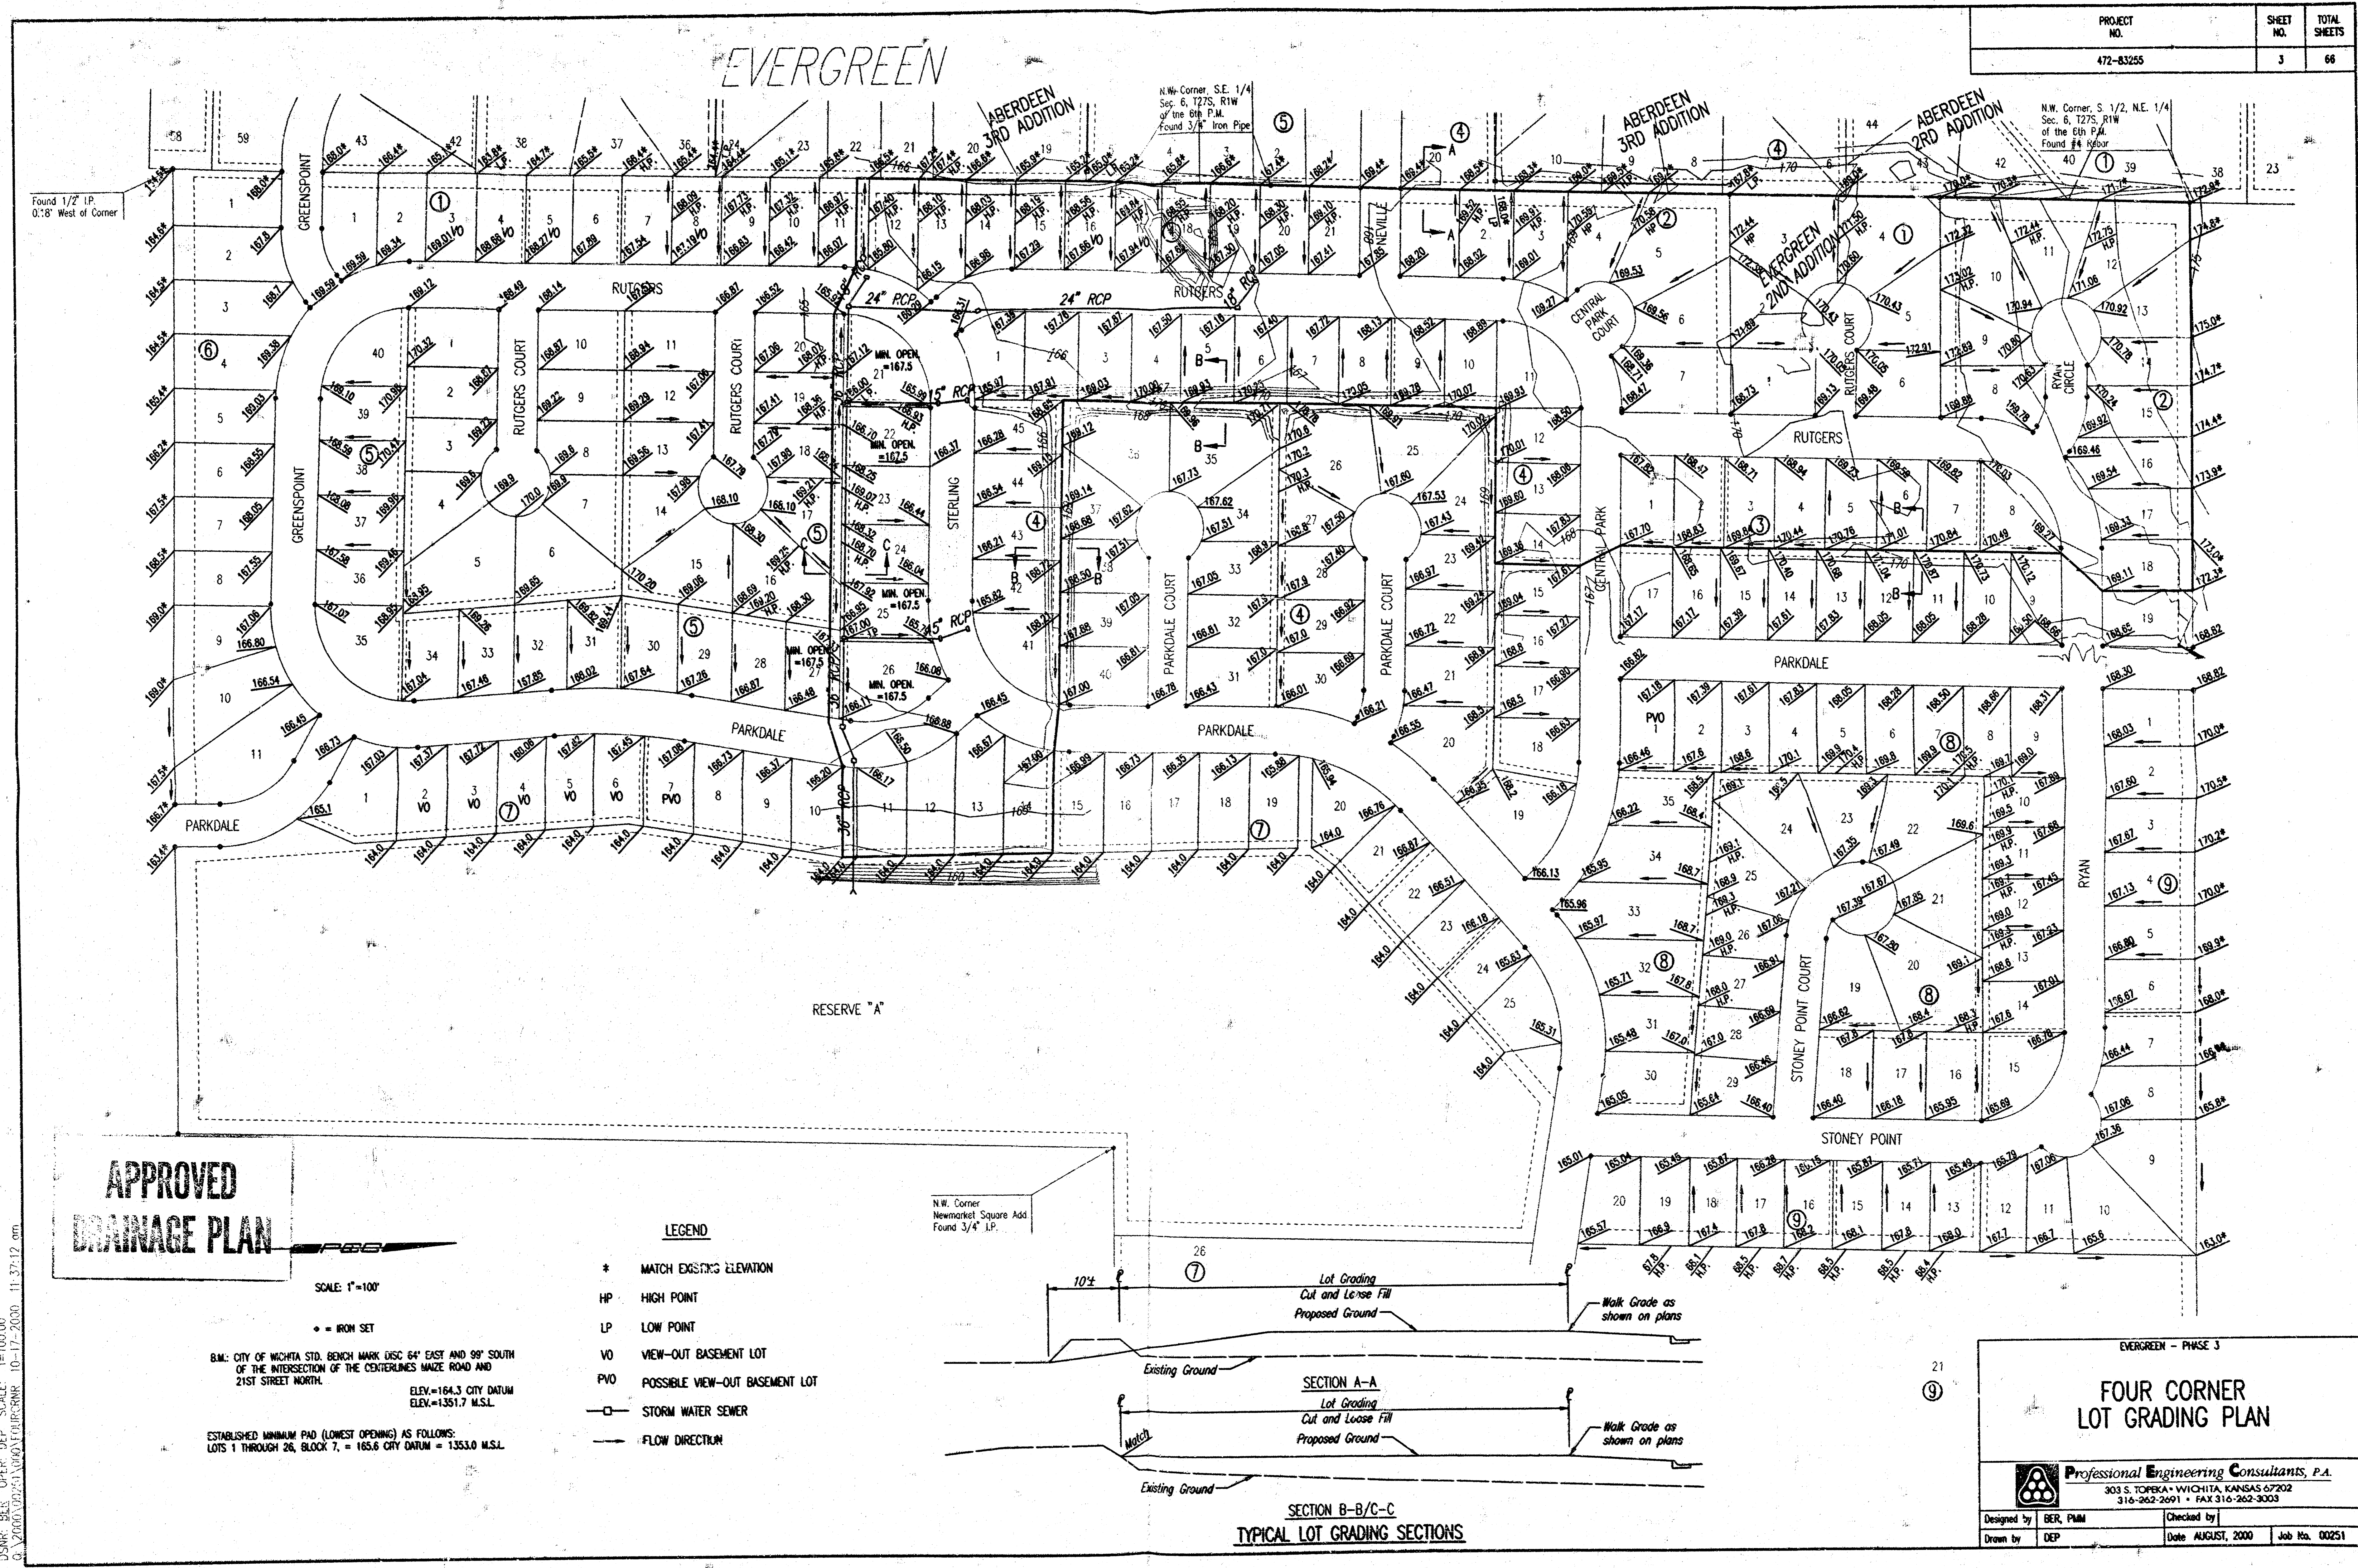

DSMR: 655 OPER. DEF. SCALE: 1"=100.00  
 G:\ARCH\2003\472-83255\472-83255-03-17-2000-11-31-12.dwg

EVERGREEN - PHASE 3

**FOUR CORNER LOT GRADING PLAN**

Professional Engineering Consultants, P.A.  
 303 S. TORNSKA • WICHITA, KANSAS 67202  
 316-262-2691 • FAX 316-262-3003

Designed by: BER, P/M  
 Drawn by: DEP  
 Checked by: \_\_\_\_\_  
 Date: AUGUST, 2000  
 Job No. 00251