


F:\CIVIL\98135.DWG Tue Feb 02 09:36:17 1999

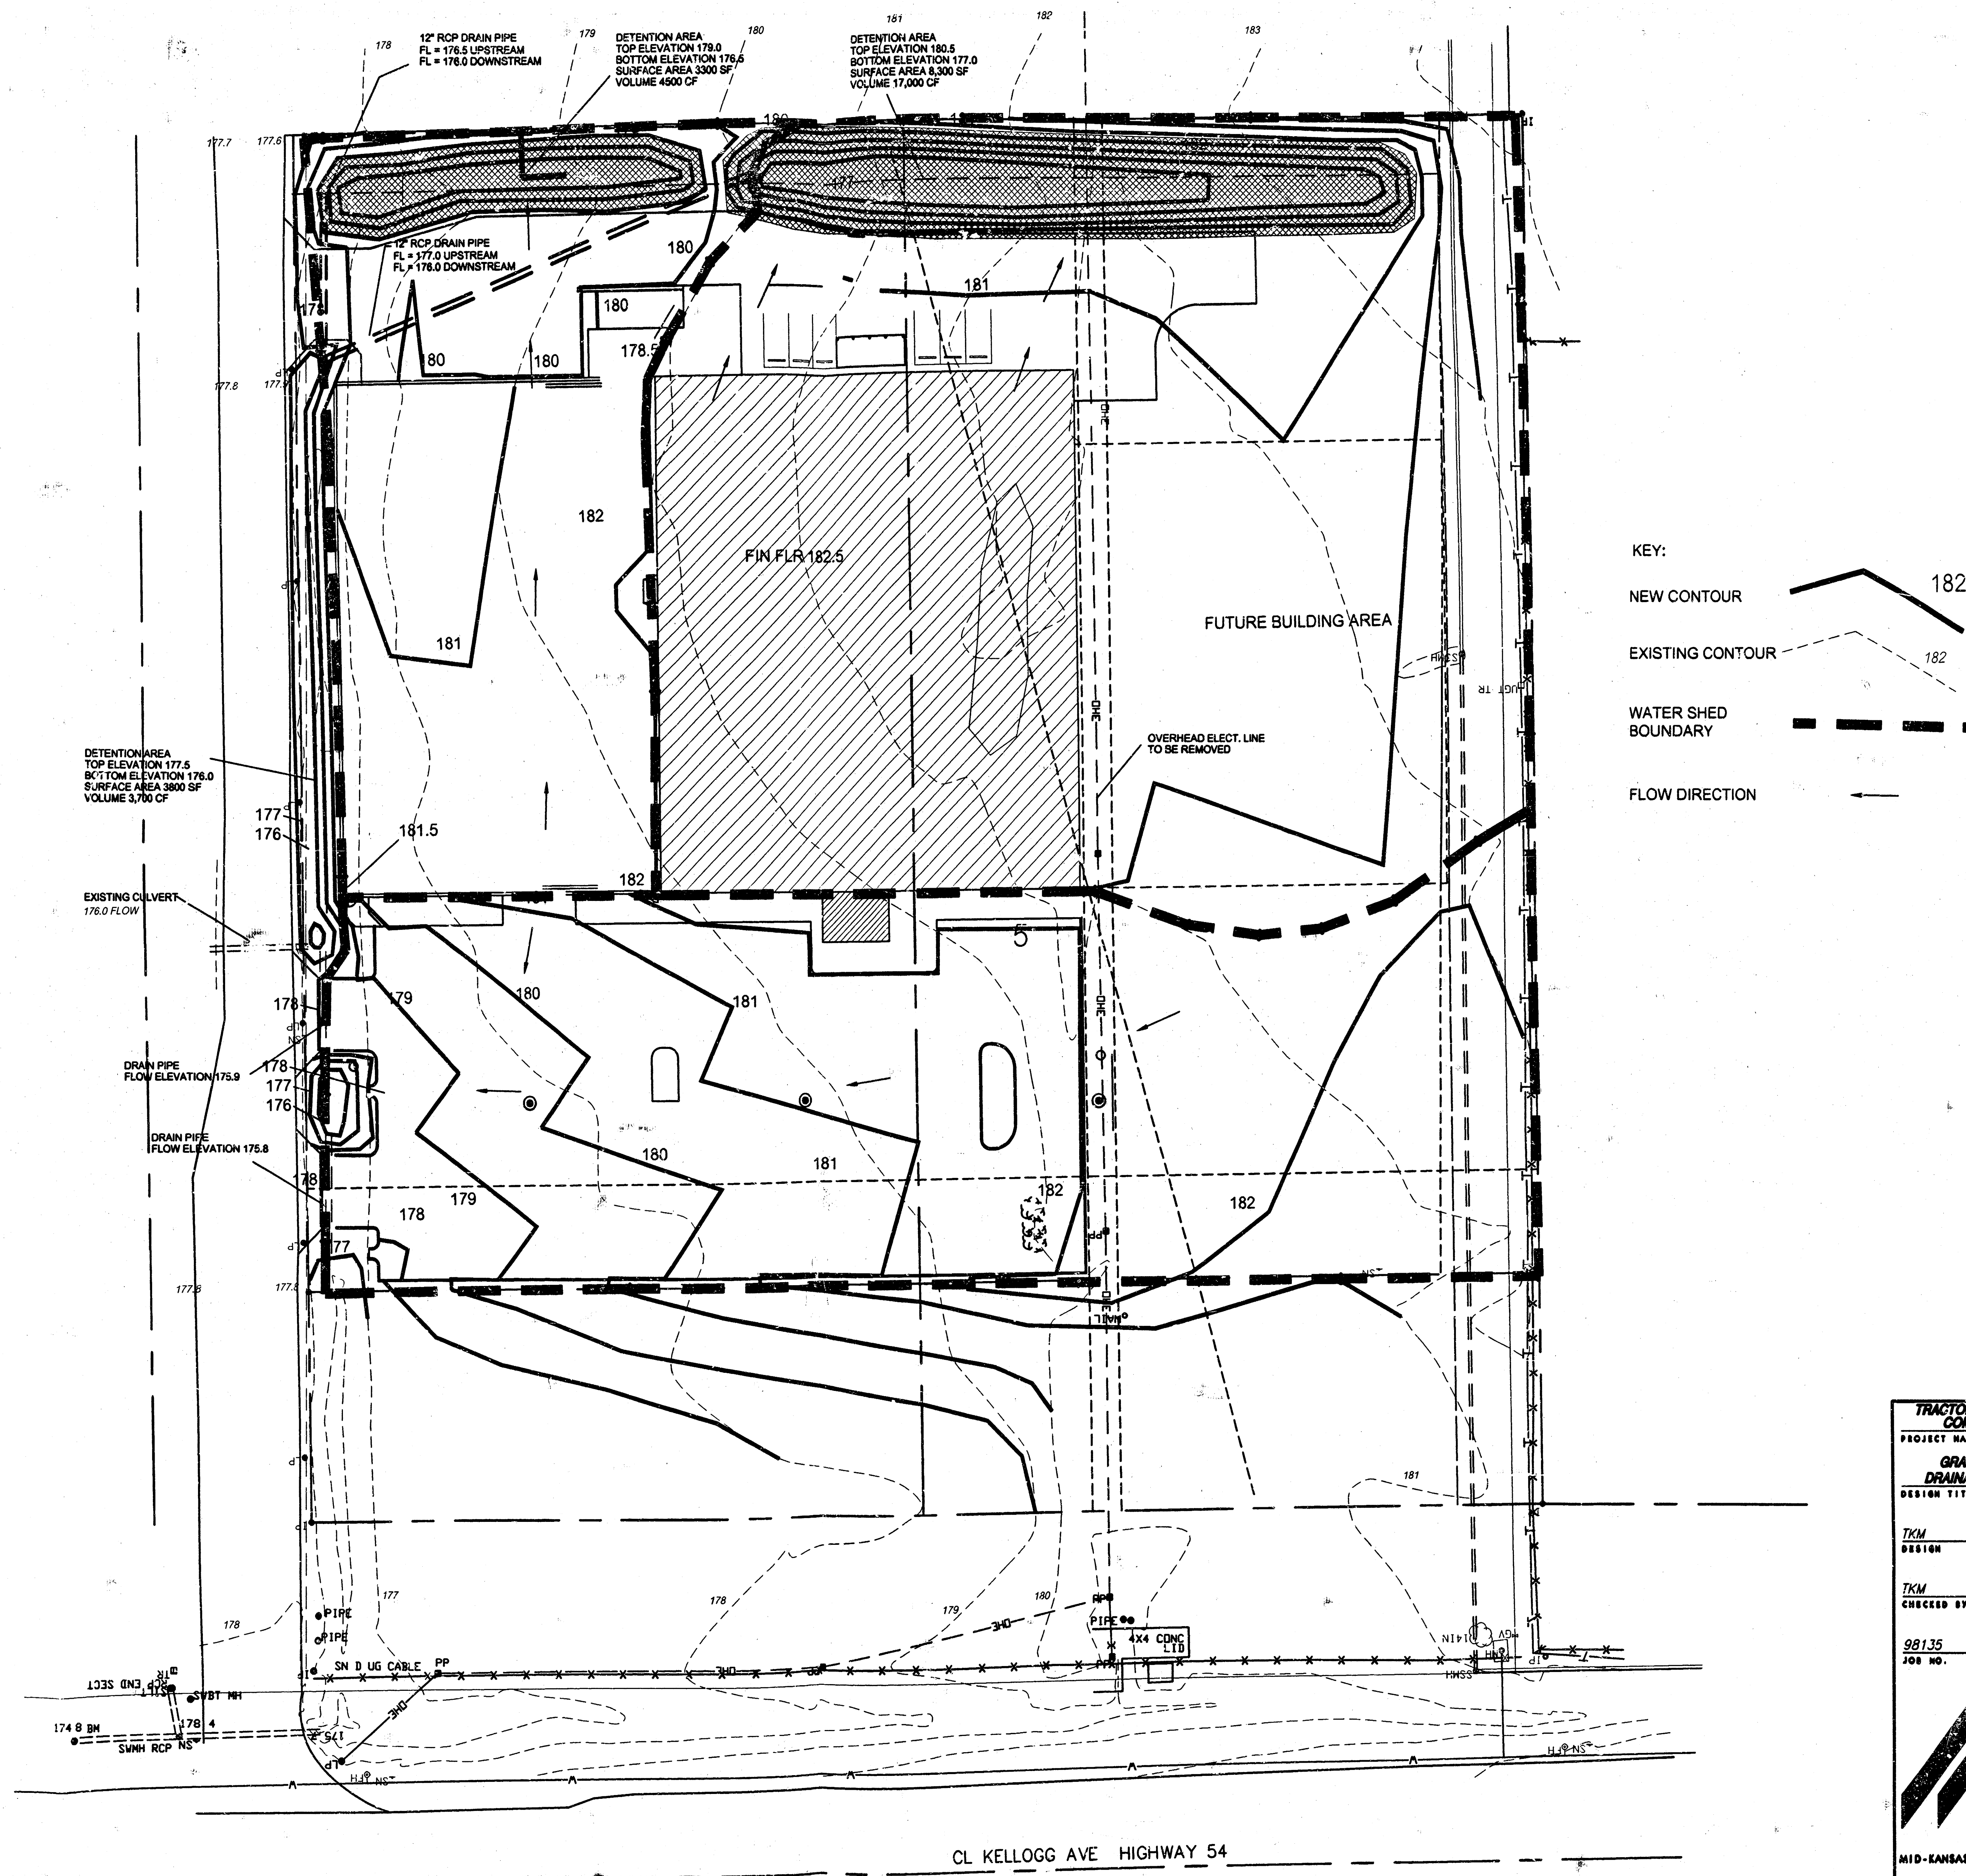

GRADING & DRAINAGE PLAN

SCALE: 1" = 30'

TRACTOR SUPPLY COMPANY	
PROJECT NAME	
GRADING & DRAINAGE PLAN	
DESIGN TITLE	
TKM	DAC
DESIGN	DRAWN BY:
TKM	FEB. 1999
CHECKED BY:	DATE
98135	1 / 1
JOB NO.	SHEET/OF
MID-KANSAS ENGINEERING CONSULTANTS, INC.	
411 N WEBB ROAD	
WICHITA, KS 67206	
316-684-9600	

ISSUE DATE
GRADING PLAN

SP2

TRACTOR SUPPLY COMPANY
DEVELOPMENT FOR WALTER LEWIS

KELLOGG AND WEBB ROAD
WICHITA, KANSAS

SPANGENBERG - PHILLIPS
ARCHITECTURE

224 E. Douglas, Fifth Floor Wichita, KS 67202 T 316-267-4002 F 316-267-1509