



REGION NO.	STATE	PROJECT NO.	YEAR	SHEET NO.	TOTAL SHEETS
7	KANSAS	(BC) 96-87-K044-1(28)	1978	111	143

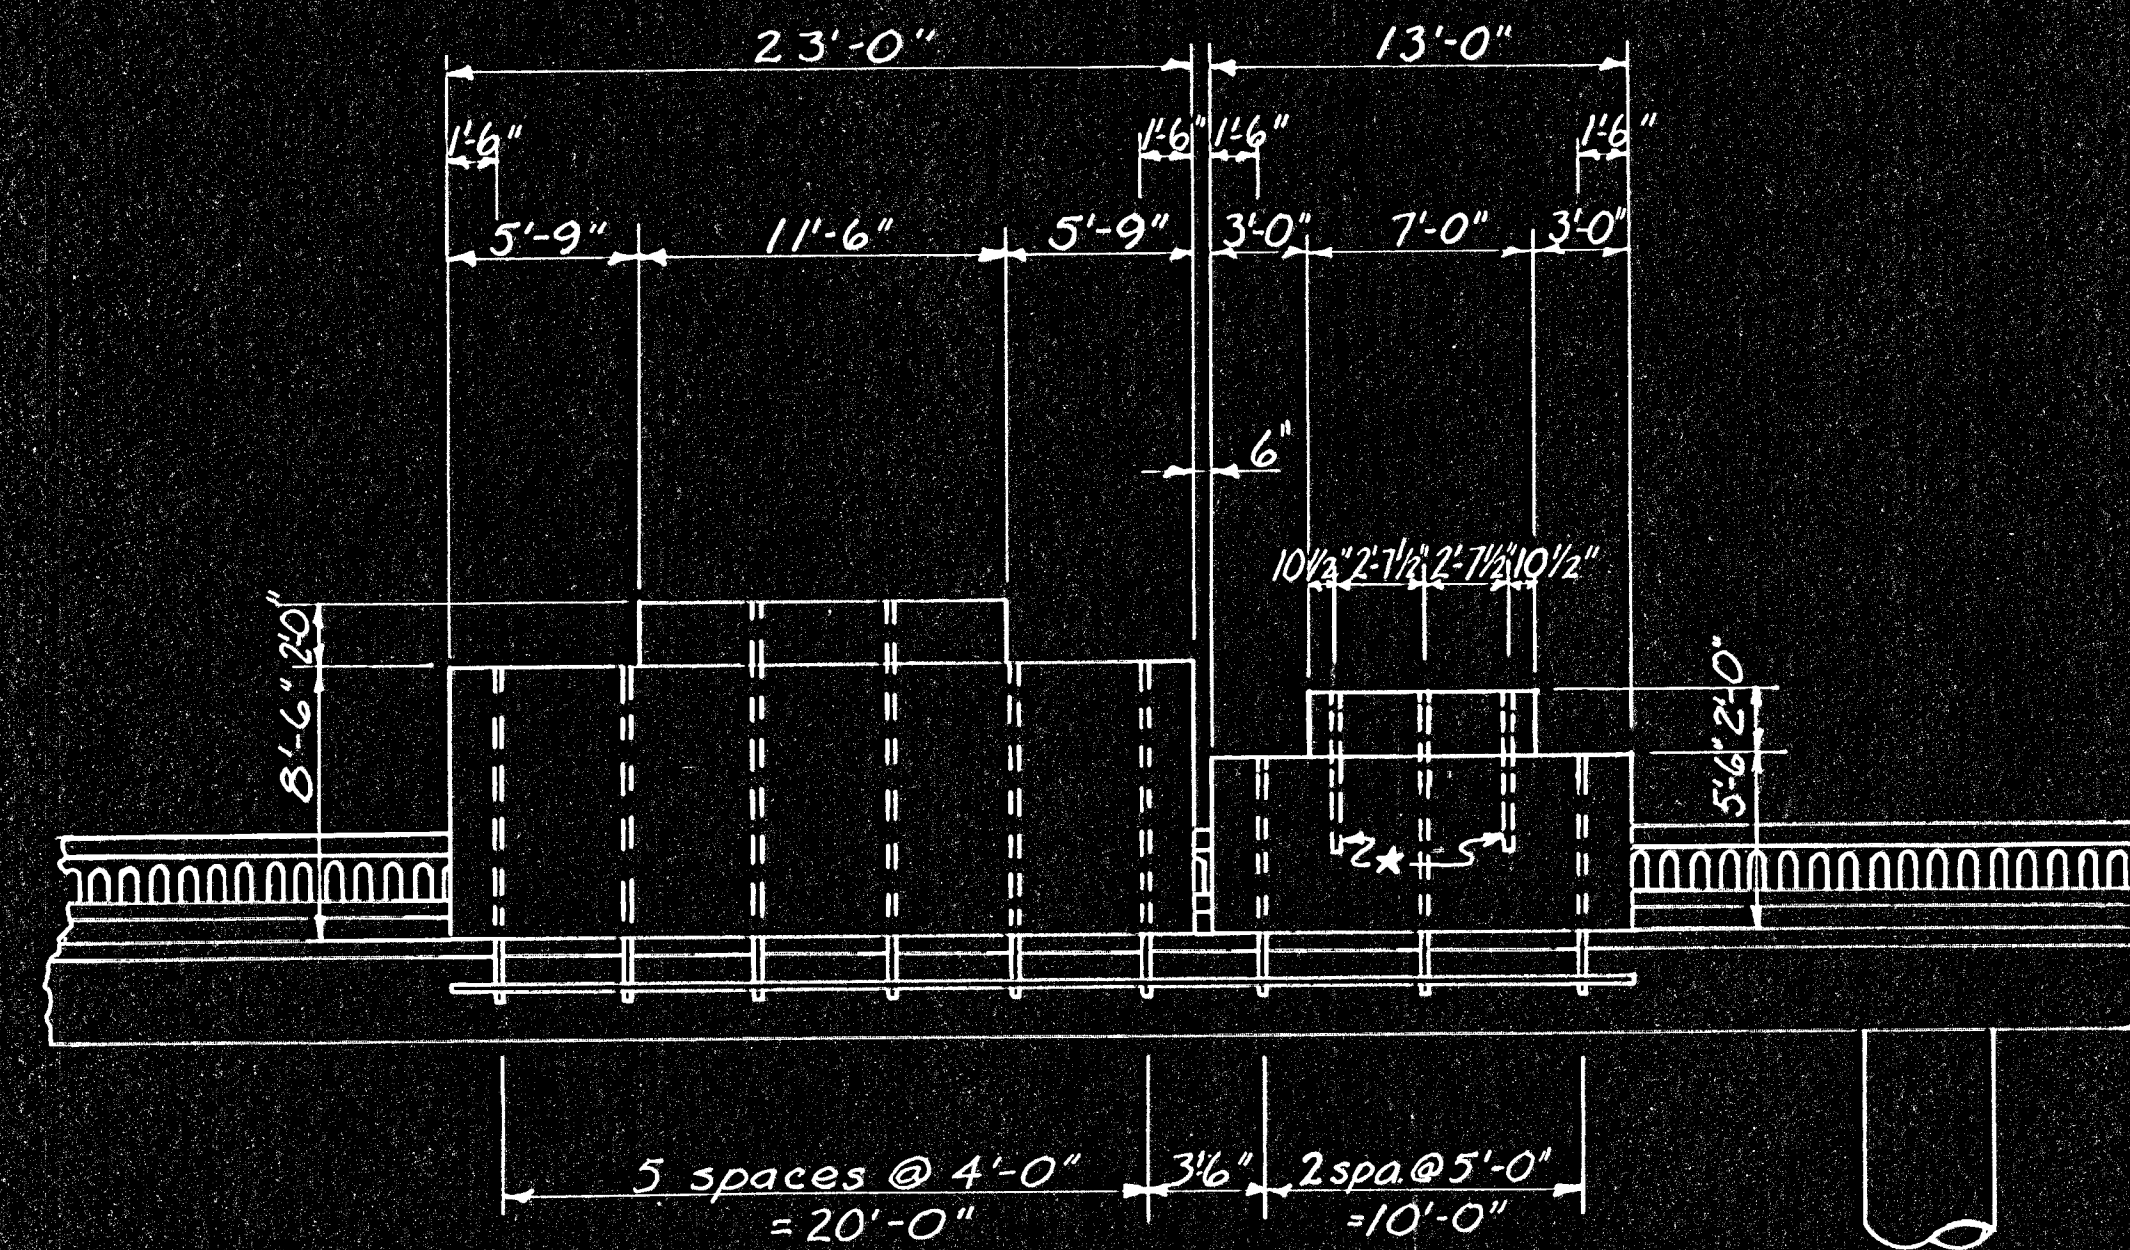

ELEVATION

*Note: Mount the Exit Number sign with two 3 I 225 x 5'-0" aluminum beams. Refer to the "Mounting of Structural Sign Panel" sheet. These beams shall be included in the linear feet of the bid item "3 I 2.25 Aluminum I-Beam."

Note: Bridge Mounted Sign Attachment shall be grounded by means of #6 A.W.G. insulated copper ground wire carried on structure and down pier in 1/2" conduit. Conduit clamps on 6" centers. See "Sign Lighting Fixtures and Electrical Details" sheet.

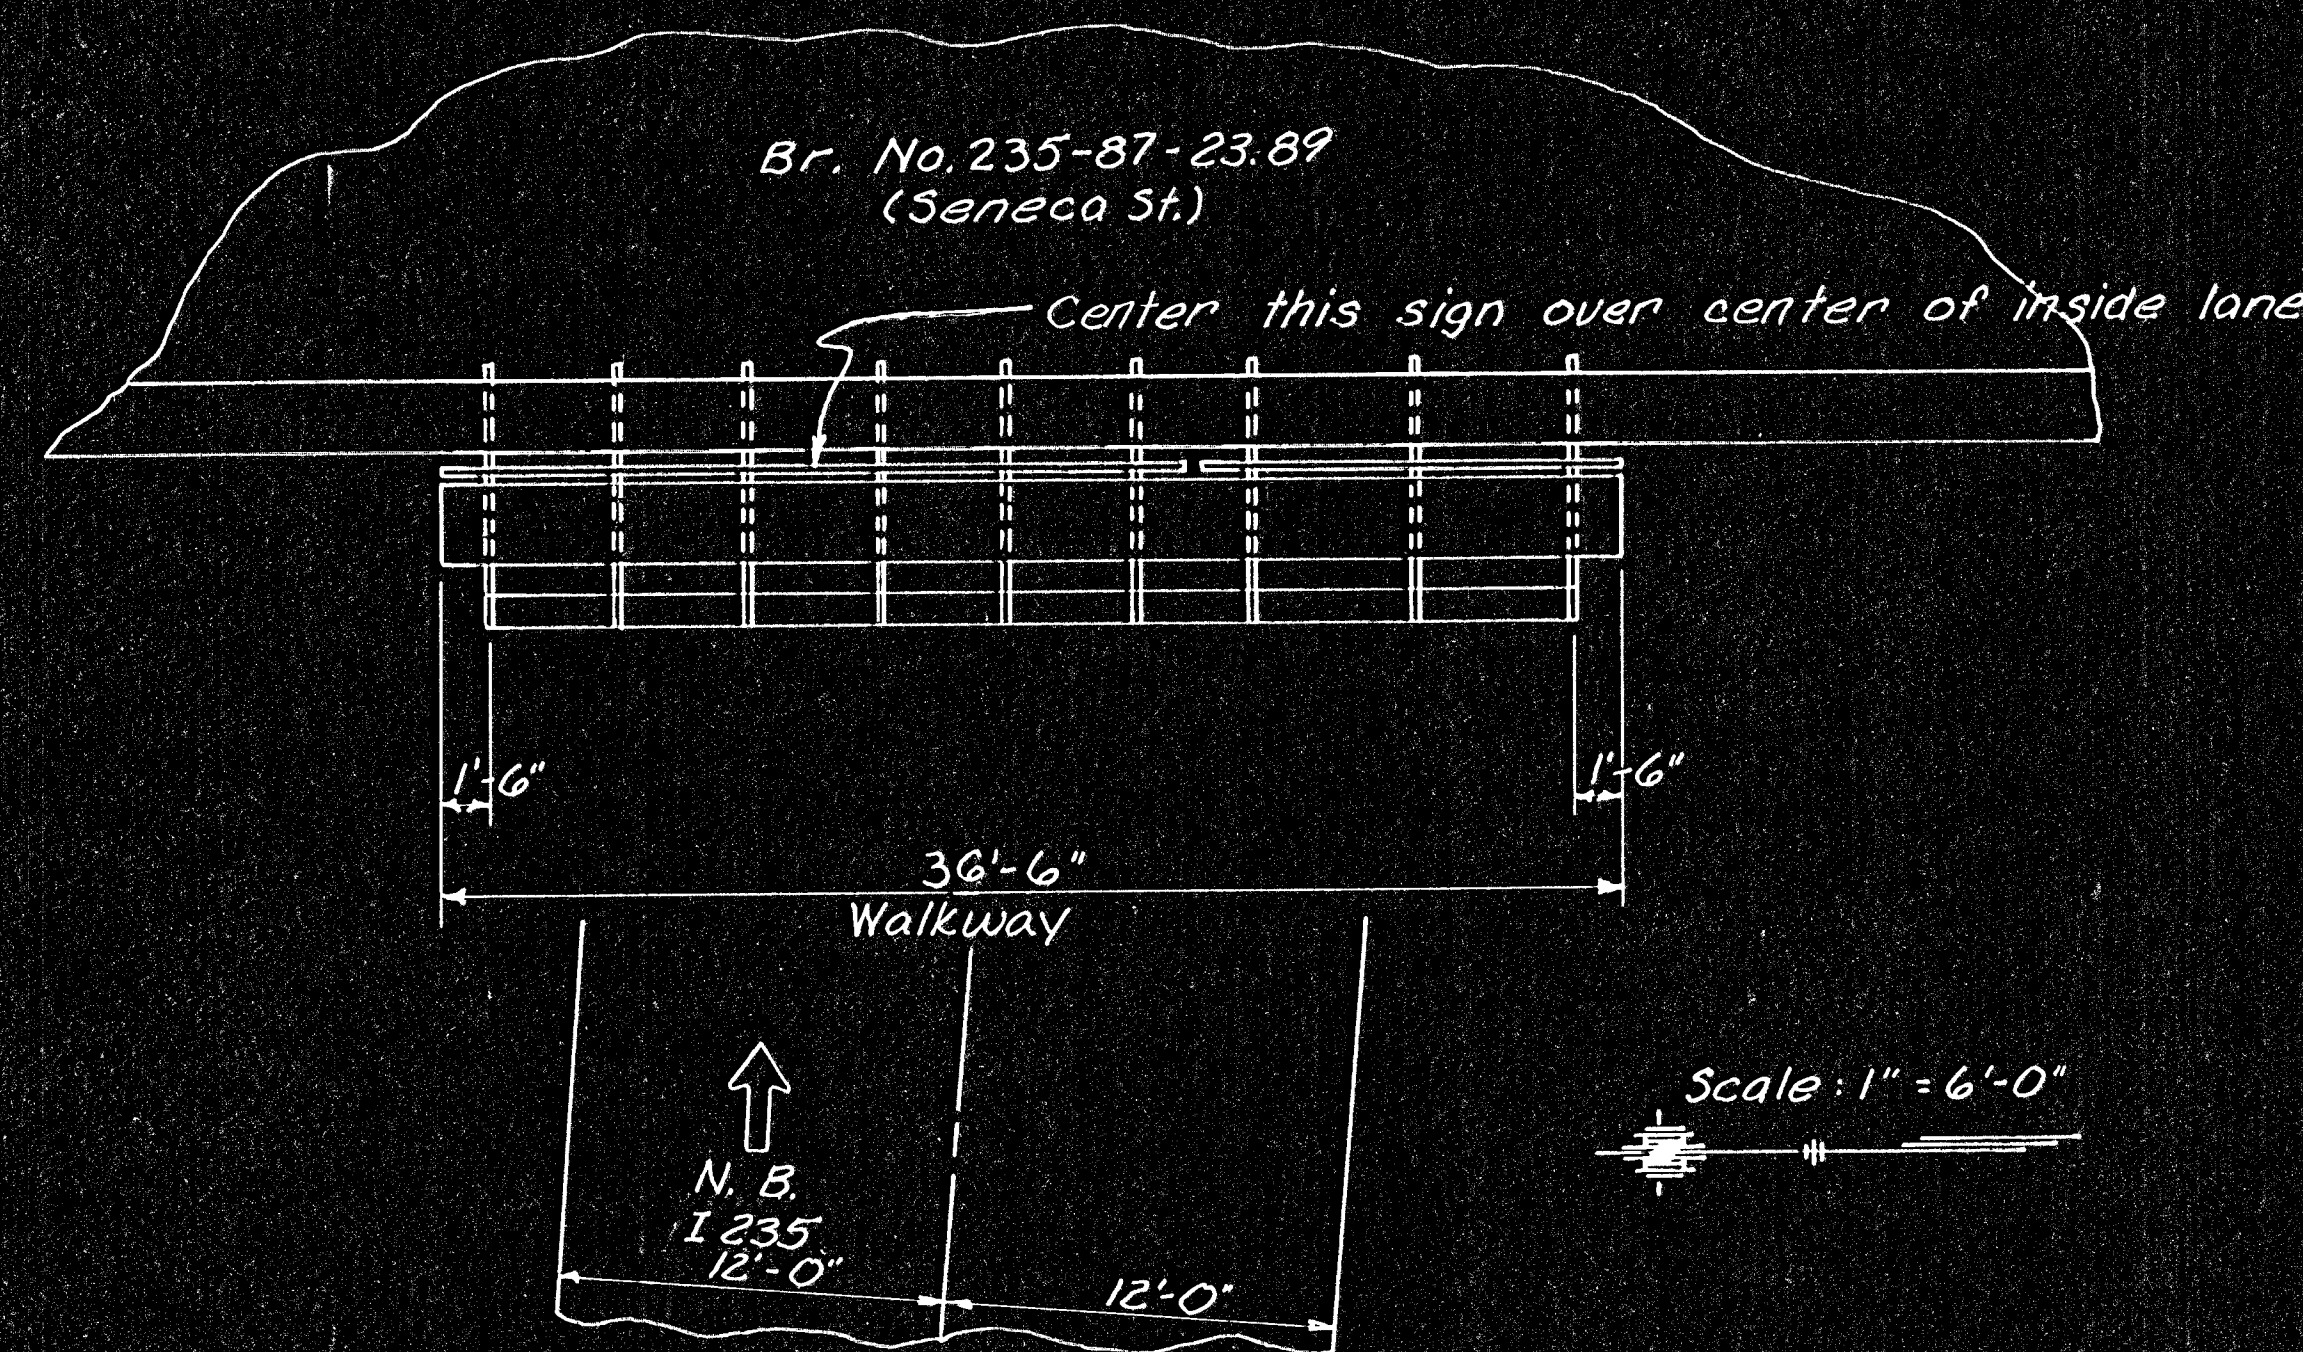

PLAN

Scale: 1" = 6'-0"

3					
2					
1					
NO.	DATE	REVISIONS	BY	APP'D.	

KANSAS DEPARTMENT OF TRANSPORTATION					
N.B. I235			BR. NO. 235-87-2389		
CONSTRUCTION LAYOUT					
BRIDGE MOUNTED SIGN ATTACHMENT					
PROJ. NO. (BC) 96-87-K044-1(28) SEDGWICK CO.					
SHEET NO. 111 OF 143		SCALE	APP'D.	QUANTITIES	TRACED
DESIGNED L.E.S.		DETAILED L.E.S.		QUAN. CK.	TRACE CK. S.D.
DESIGN CK. DRE		DETAIL CK. DRE			TRACE CK. LES