


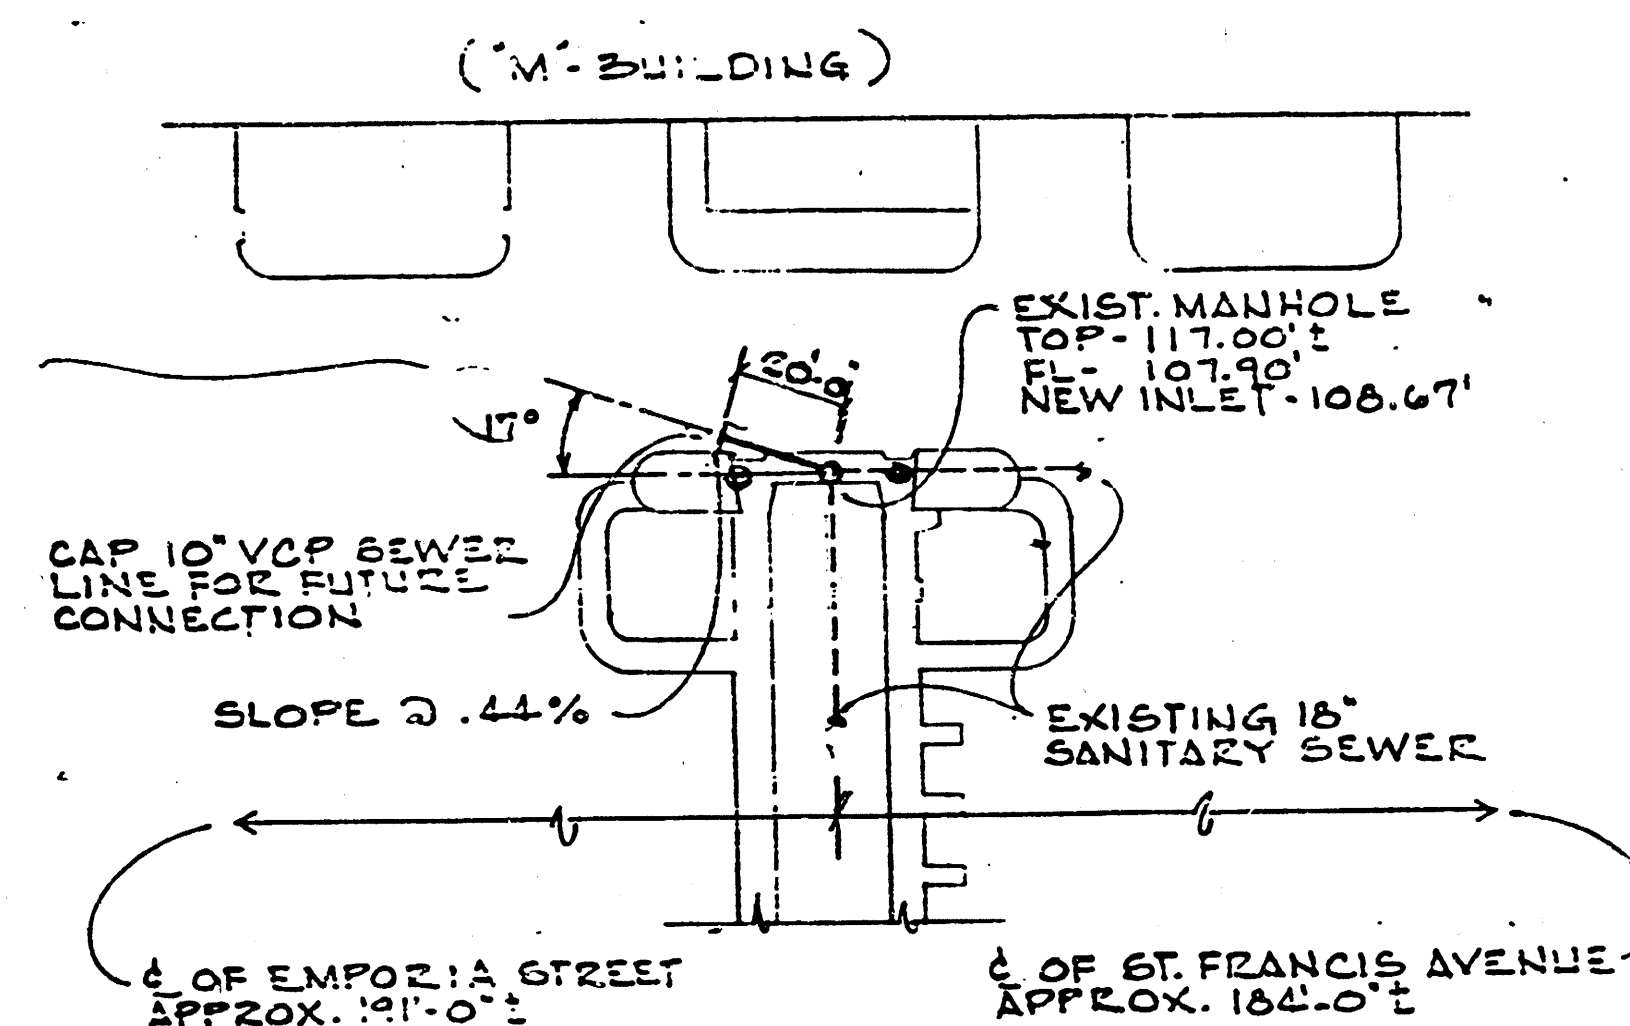

10-26-83 PARTIAL SITE PLAN

APPROVED AS NOTED
By CITY ENGINEER OF WICHITA
Sanitary Sewers *P.S.H.*
Storm Sewers _____
Driveway Approaches _____

SCALE 1" = 40'-0"

NOTE TO CONTRACTOR

This project will be constructed under the supervision of the CITY ENGINEER and conforming to the SPECIFICATIONS of the CITY OF WICHITA. The CONTRACTOR will prepay the City of Wichita for all costs of Inspection.

SEWER EXTENSION
FOR

ST. FRANCIS REGIONAL MEDICAL CENTER
WICHITA, KANSAS
Proj. # 468-76-245-80000-000-000-008
MARBAGLIA - NEUSTROM - DREDSON INC.
KANSAS CITY MISSOURI

BERT S. KENDALL
KENDALL INC.
267-6261

DATE: 10-1-83
DRAWN BY: REB
SHEET NO: SP-1

14 4 5 8