


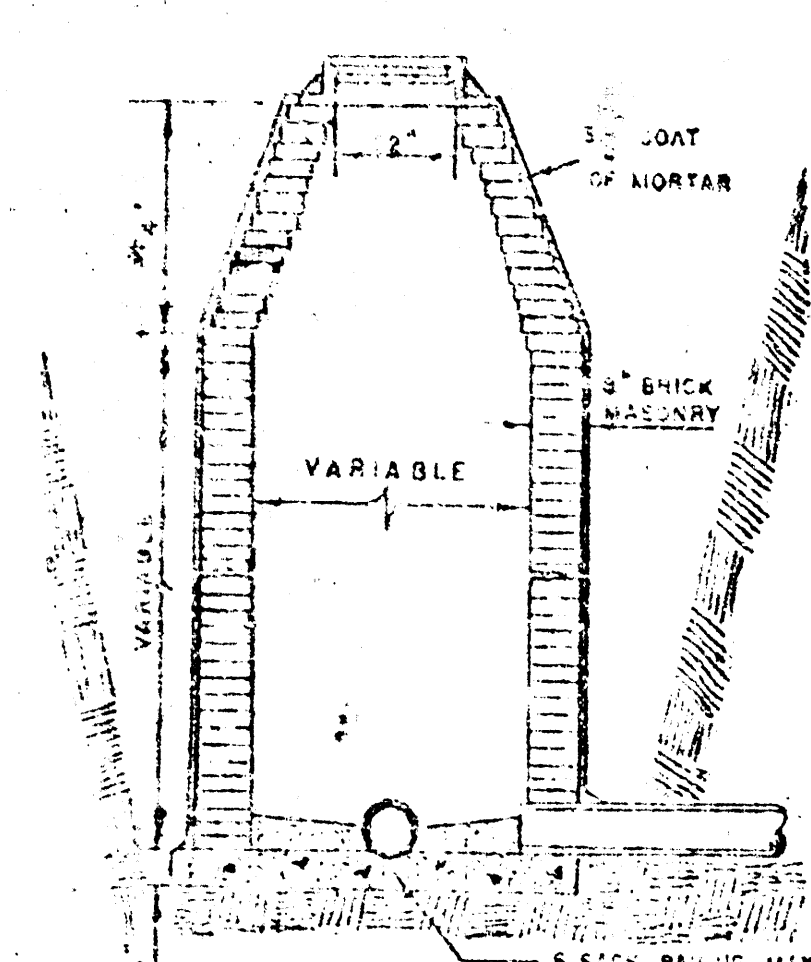


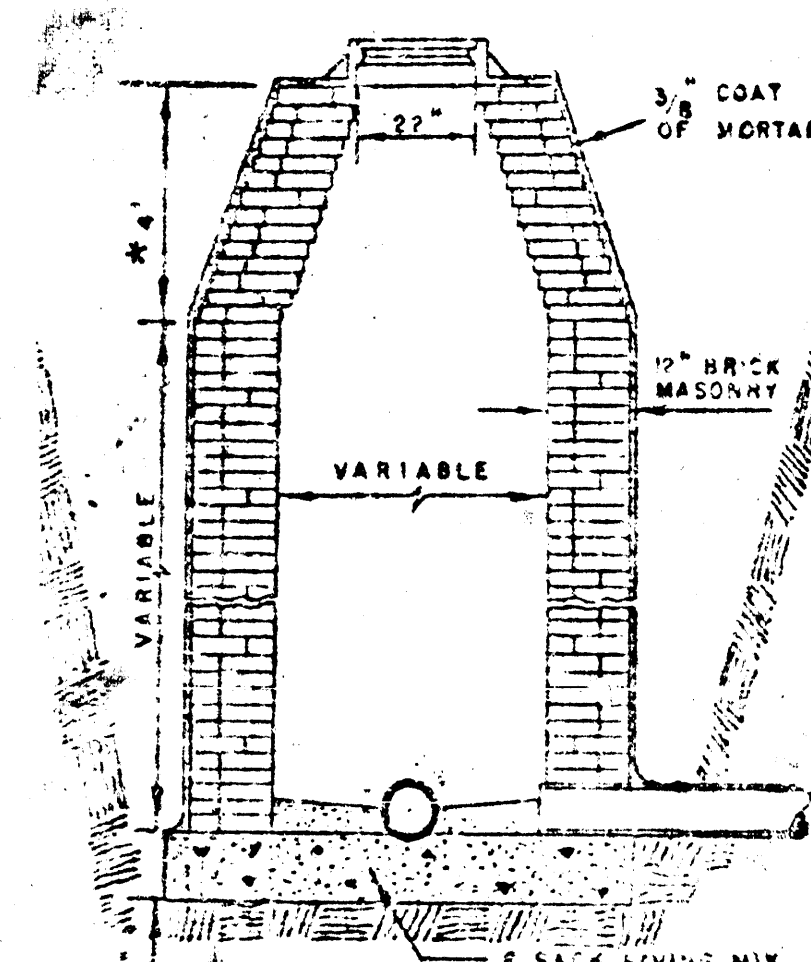


STANDARD MANHOLE
TYPE "A"
4' H. ON 5' DIA. M.H.

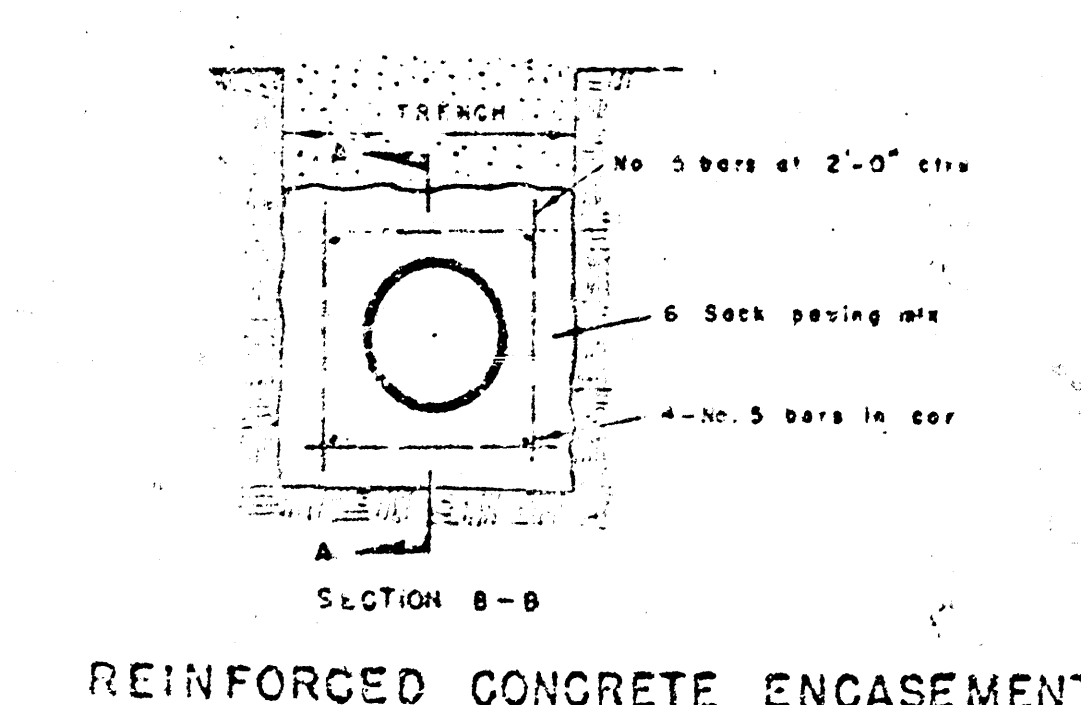

STANDARD MANHOLE
TYPE "B"

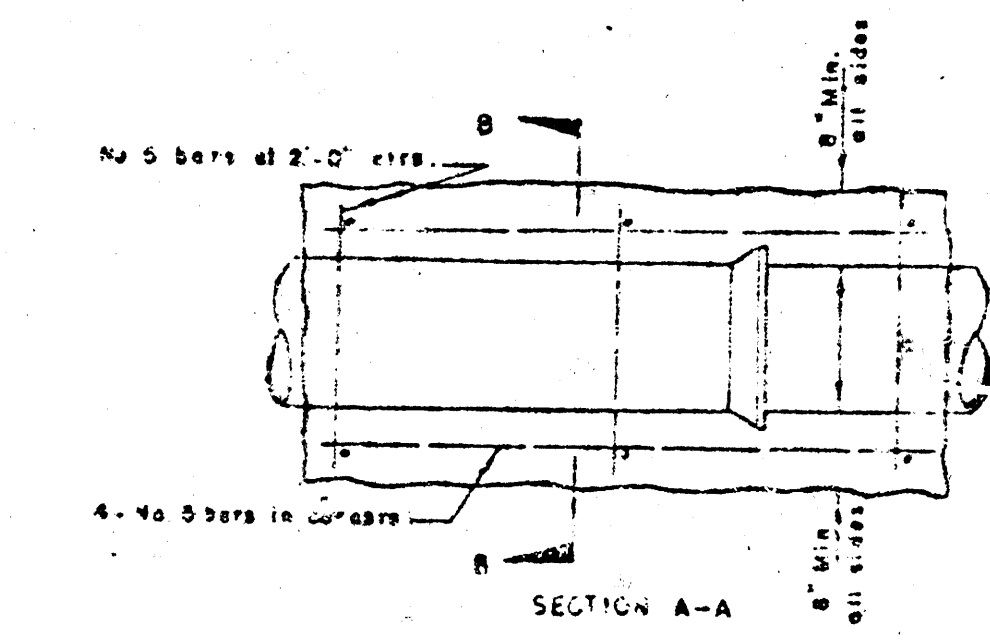

REINFORCED CONCRETE ENCASUREMENT

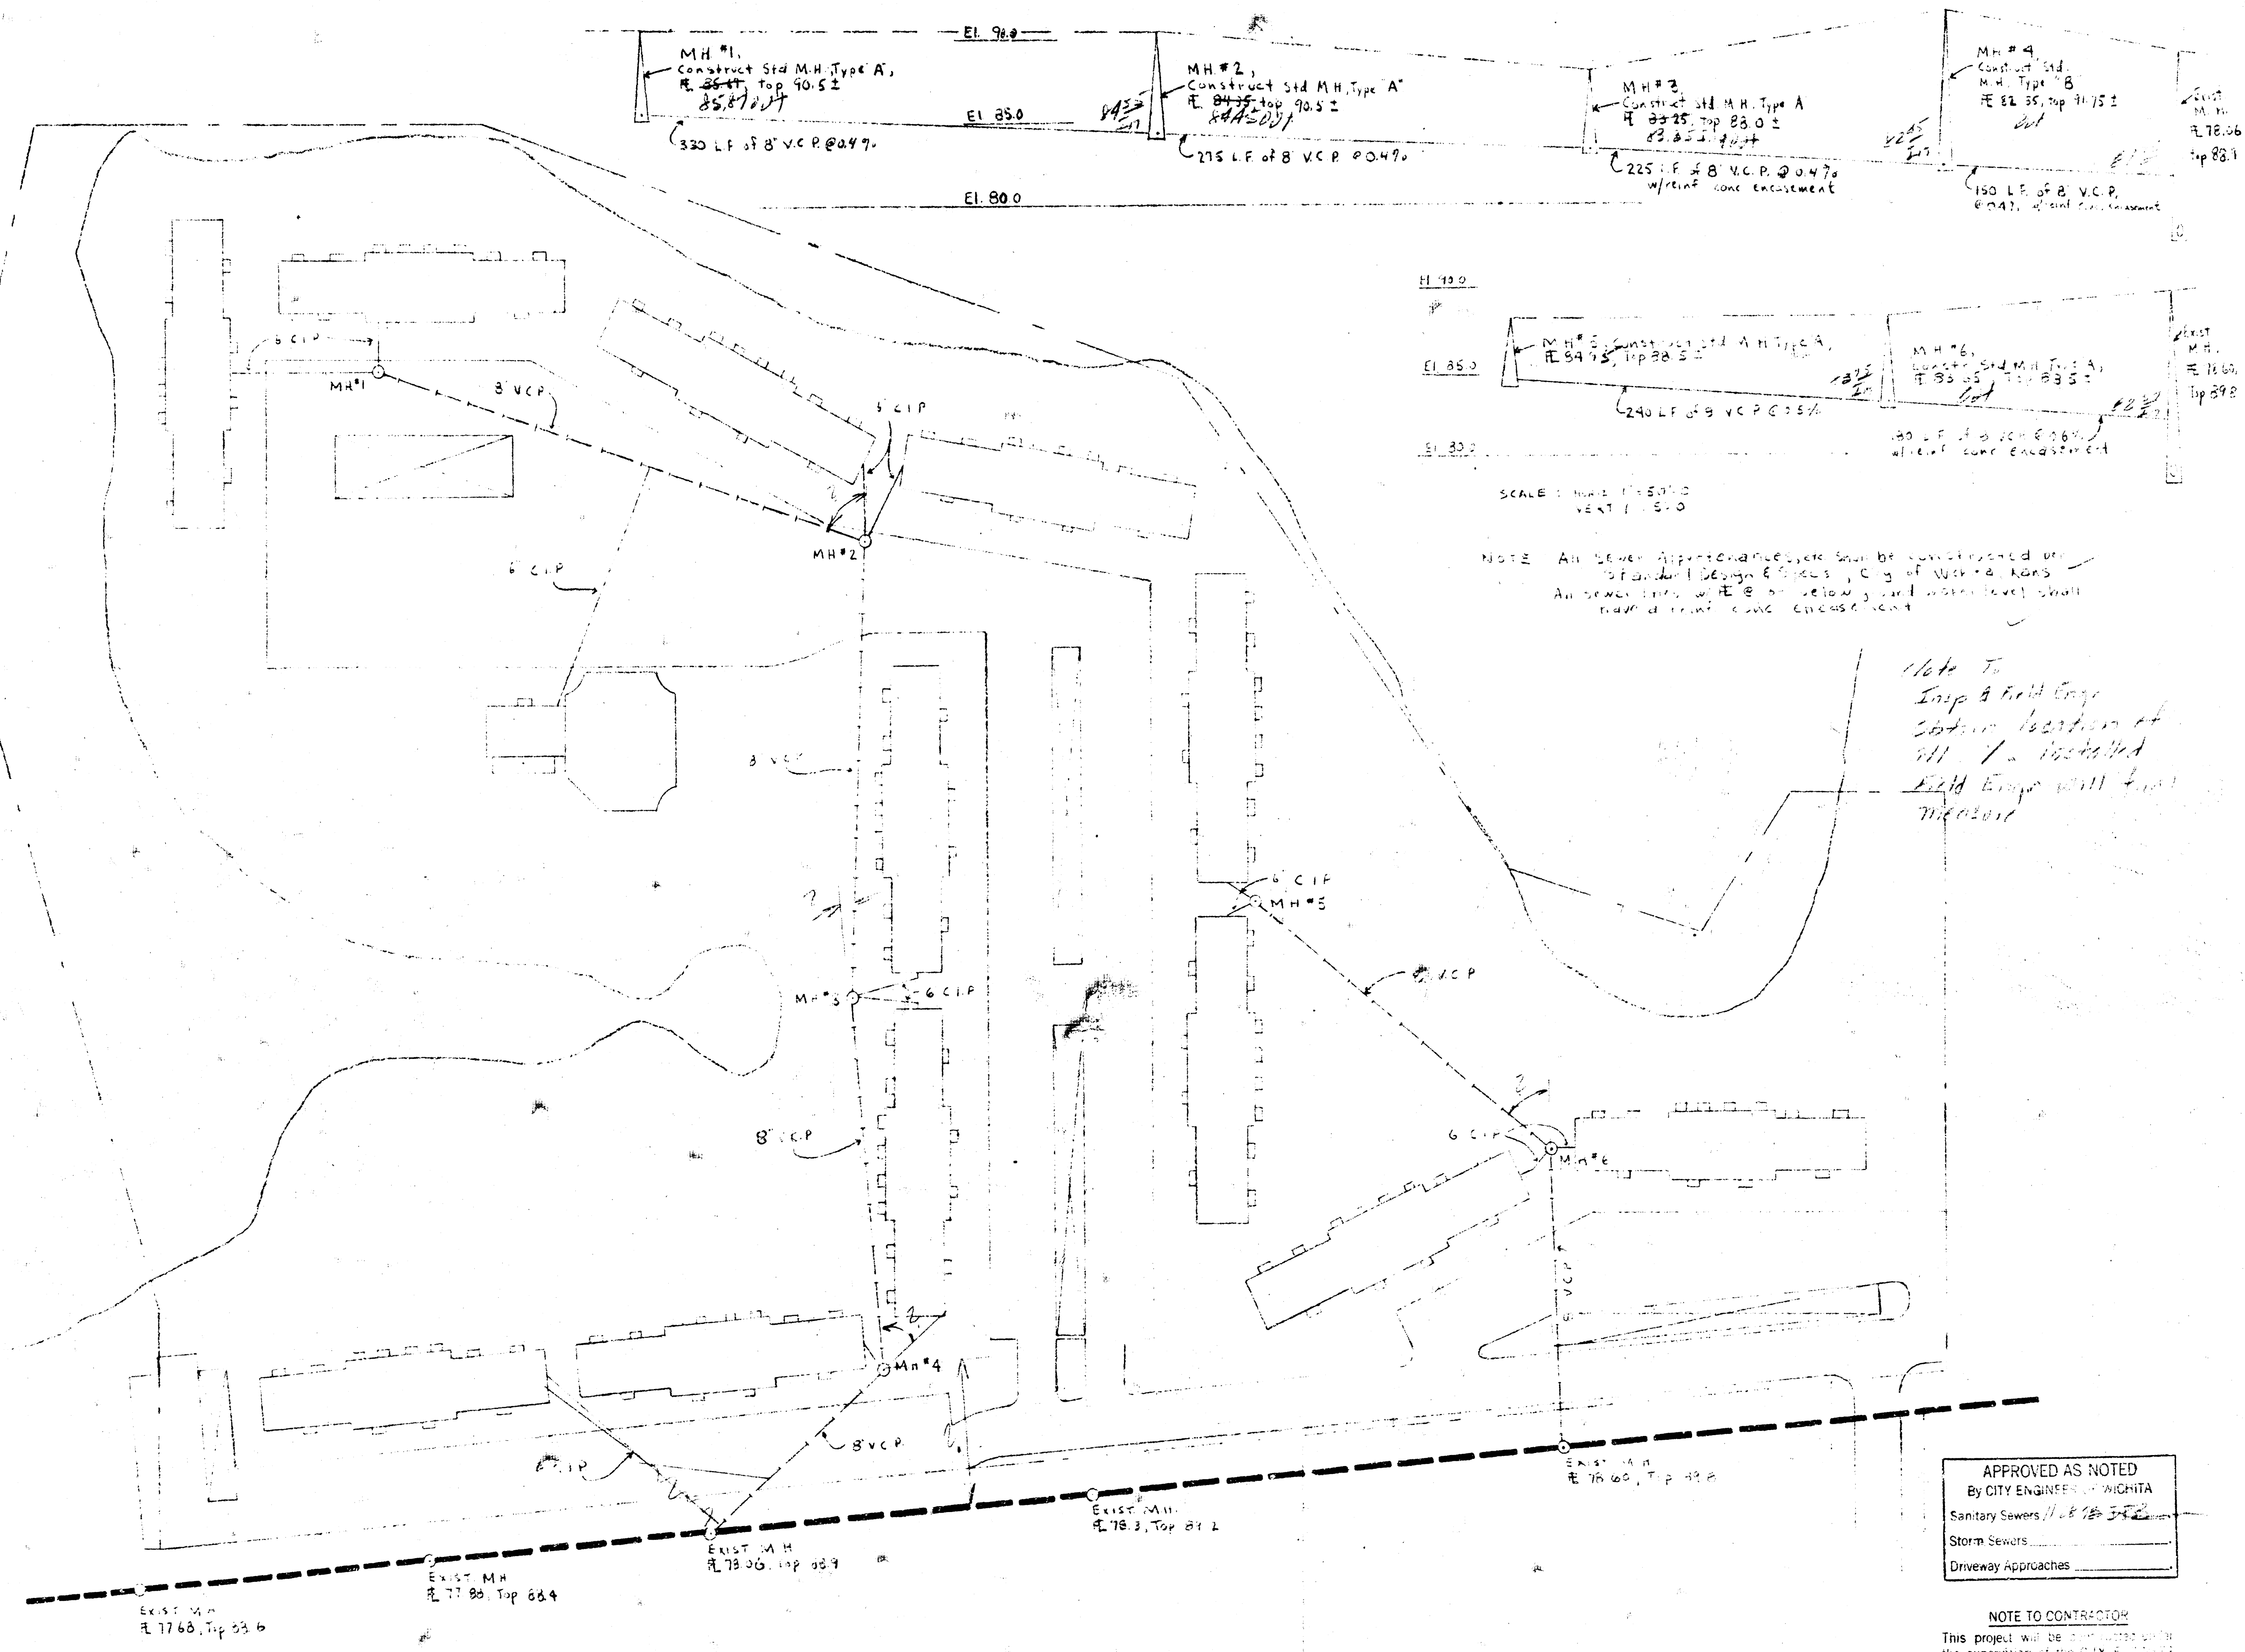

UTILITY PLAN
SCALE: 1" = 50'-0"

APPROVED AS NOTED
By CITY ENGINEER OF WICHITA
Sanitary Sewers 11/18/85 JFB
Storm Sewers
Driveway Approaches

NOTE TO CONTRACTOR
This project will be constructed under the supervision of the City Engineer and the City Engineer's Office. The City Engineer's Office will be responsible for the design and construction of the project. The City Engineer's Office will be responsible for the design and construction of the project.

SOUTHLAKE VILLAGE
DICK BRABHAM ARCH. IS