

SITE COORDINATES

POINT NO.	NORTH	EAST	DESCRIPTION
1	1338.000	558.000	MANHOLE #1-2
2	1338.000	600.000	MANHOLE #1-3
3	1356.000	634.000	MANHOLE #1-4


WATER LINES

10	1329.000	622.000	45° BEND
11	1332.000	622.000	45° BEND
12	1337.000	647.000	90° BEND
13	1125.000	700.000	45° BEND
14	1125.000	700.000	90° BEND
15	1125.000	693.000	90° BEND
16	1146.000	947.000	45° BEND
17	1616.000	946.000	45° BEND
18	1630.000	953.000	45° BEND
19	1693.000	960.000	45° BEND
20	1805.000	950.000	90° BEND
21	1825.000	654.000	TEE
22	1756.000	647.000	90° BEND

STAKE OUT NOTE
 THE CONTRACTOR SHOULD USE THE COORDINATE POINTS TO LOCATE CRITICAL POINTS ON THE SITE. DIMENSION STRINGS AS SHOWN ON SHEET S-1 SHOULD VERIFY THE COORDINATES HOWEVER ANY DISCREPANCIES SHOULD BE REPORTED TO THE ARCHITECT PRIOR TO PROCEEDING. REFER TO SHEET S-1 FOR ADDITIONAL COORDINATE INFORMATION.

NOTES

- REFER TO PLUMBING PLANS FOR CONTINUATION OF SANITARY SEWER, DOMESTIC WATER METERS, AND WATER SERVICE LINES FROM THE METER TO THE BUILDING.
- SITE GAS LINES TO BE DESIGNED AND CONSTRUCTED BY GAS COMPANY AND ARE NOT SHOWN ON THIS PLAN. CONTRACTOR TO COORDINATE LOCATION WITH GAS COMPANY.
- CONTRACTOR TO COORDINATE WATER LINE ELEVATIONS WITH SANITARY AND STORM WATER SEWERS. WATER LINES TO HAVE A MINIMUM OF 36" COVER.
- REFER TO ARCHITECTURAL AND PLUMBING PLANS FOR EXACT LOCATION AND DETAILS OF SPRINKLER RISERS. THE DETAIL OF THE SPRINKLER RISER SHOWN IS FOR GENERAL REFERENCE ONLY AND NOT FOR CONSTRUCTION.
- ALL WATER AND SEWER LINE CONSTRUCTION TO BE IN ACCORDANCE WITH "CITY OF WICHITA" STANDARDS AND SPECIFICATIONS.

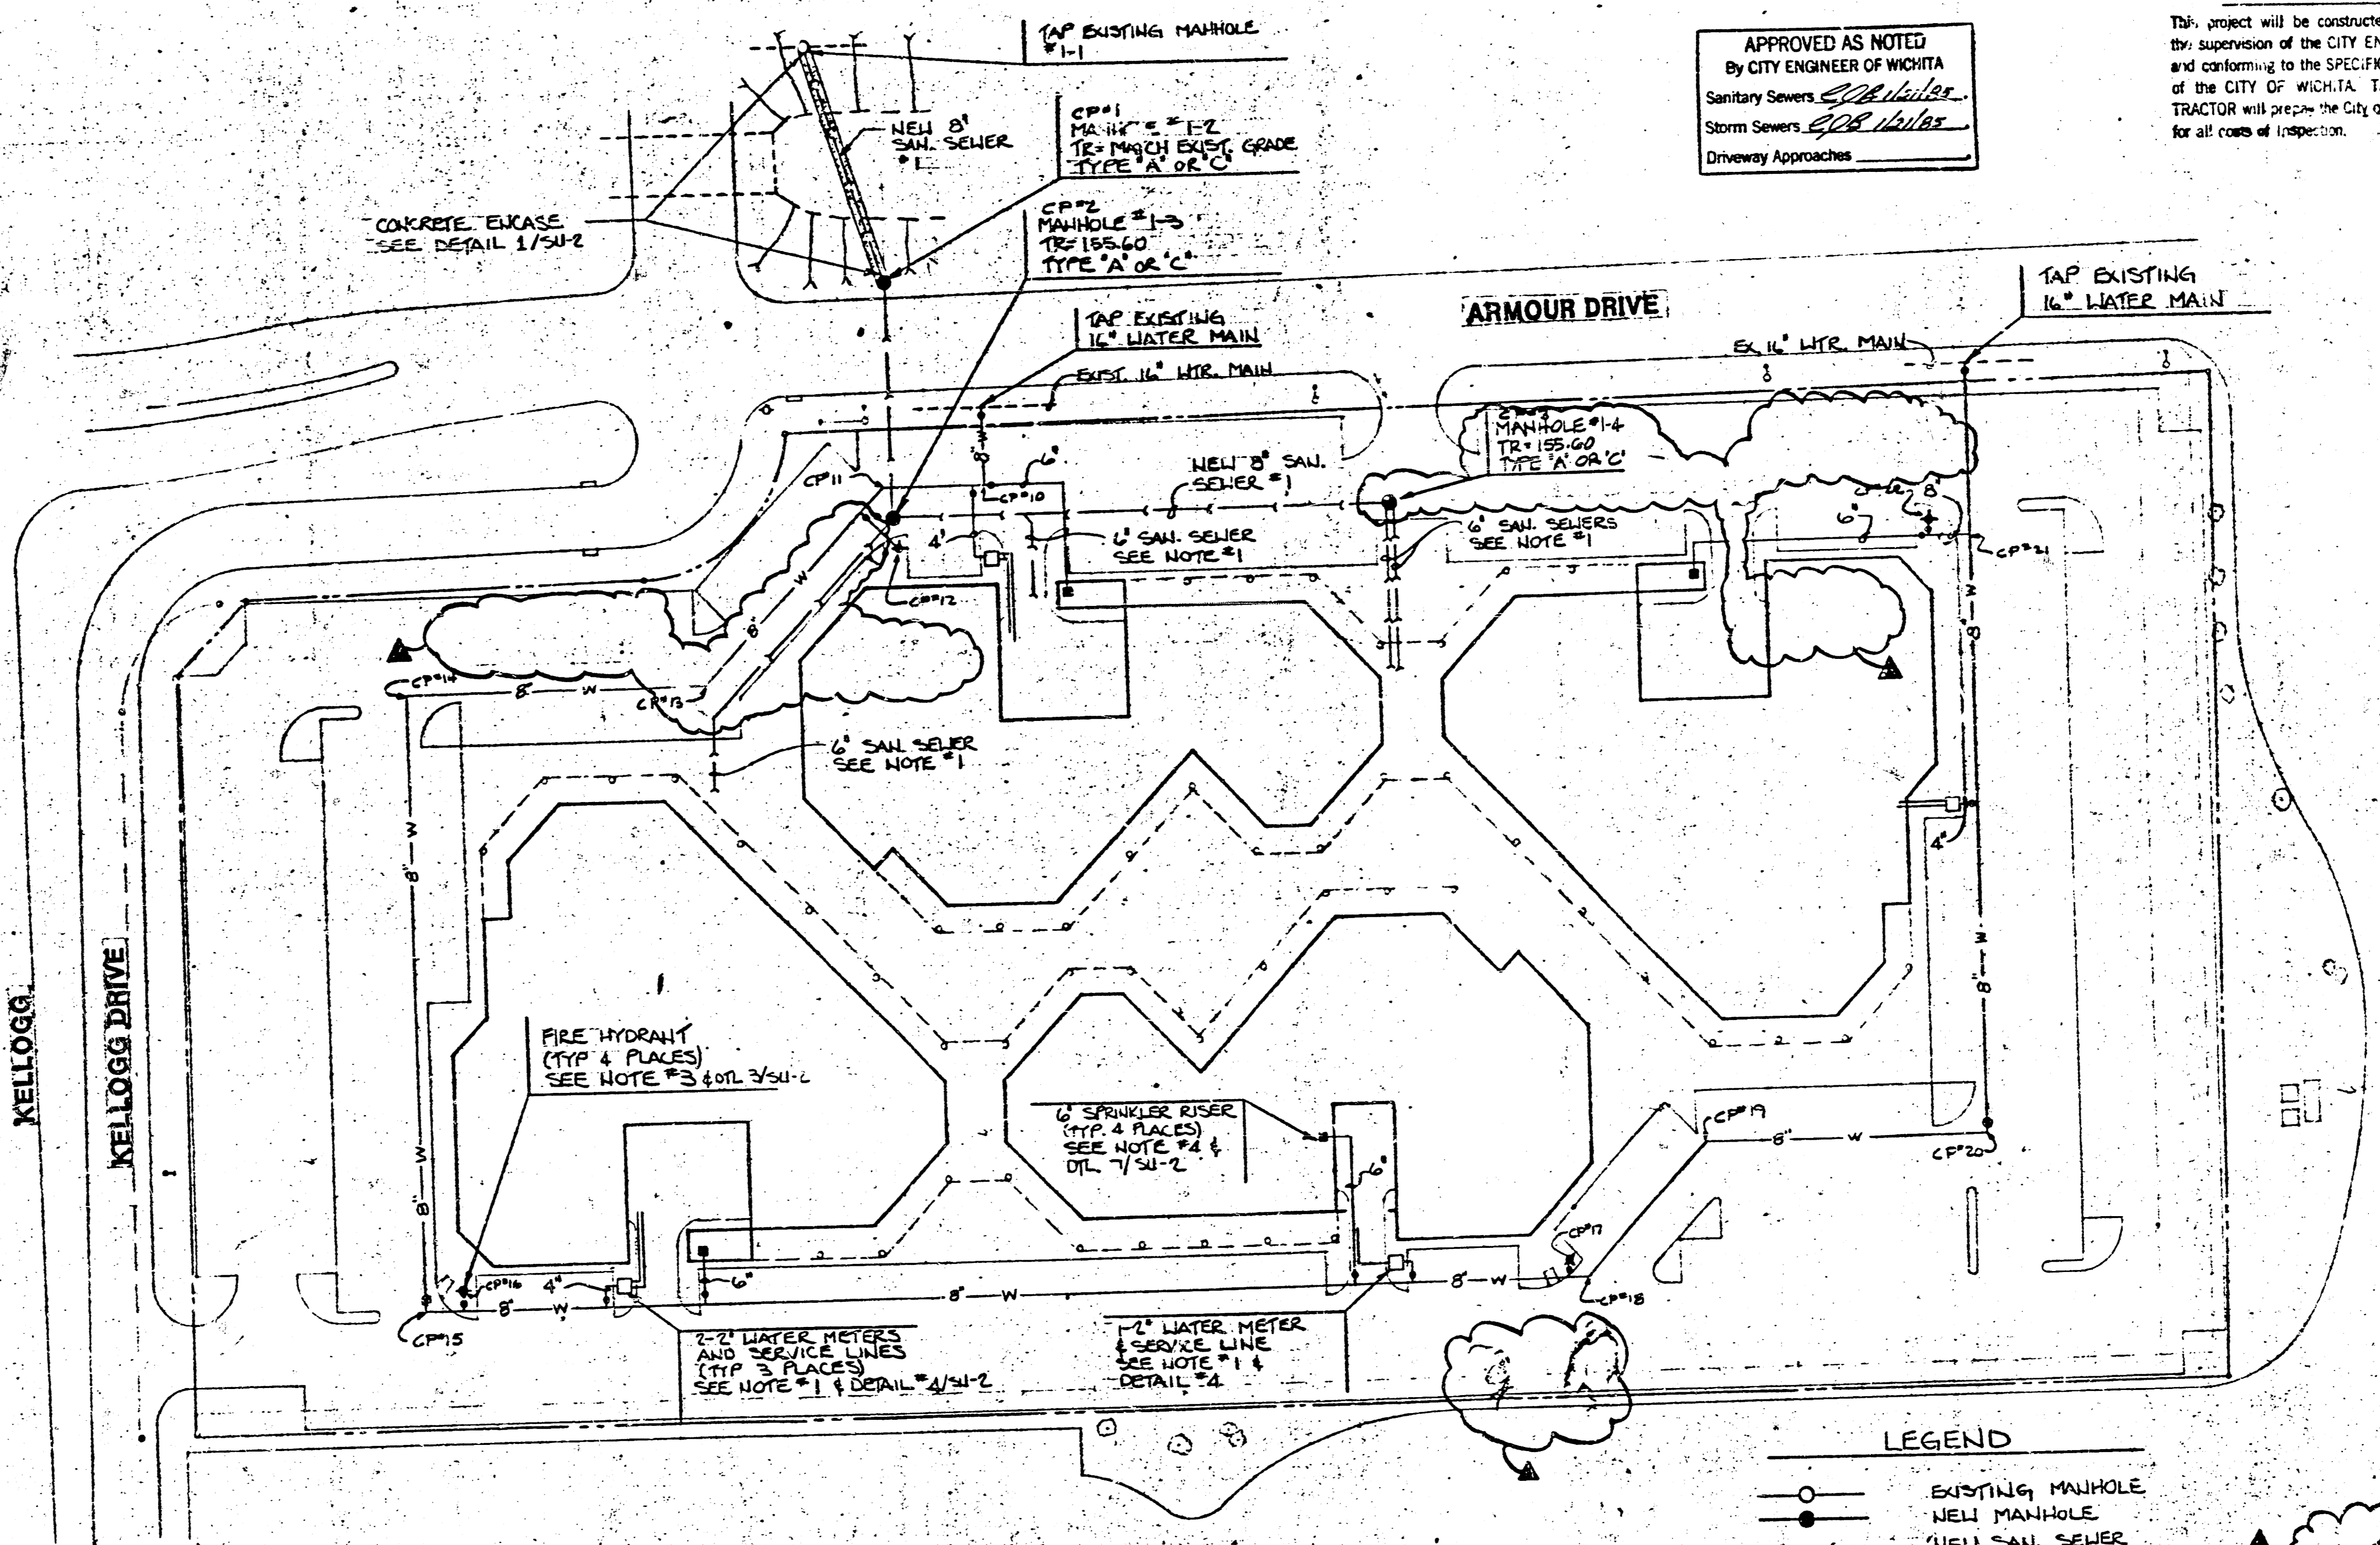


APPROVED AS NOTED
 By CITY ENGINEER OF WICHITA
 Sanitary Sewers: *[Signature]*
 Storm Sewers: *[Signature]*
 Driveway Approaches

NOTE TO CONTRACTOR
 This project will be constructed under the supervision of the CITY ENGINEER and conforming to the SPECIFICATIONS of the CITY OF WICHITA. THE CONTRACTOR will prepare the City of Wichita for all costs of inspection.


A SITE UTILITY PLAN
 SCALE: 1"=40'
 Has been reduced to 1"=50'

- LEGEND**
- EXISTING MANHOLE
 - NEW MANHOLE
 - NEW SAN. SEWER
 - NEW WATER MAIN
 - EXISTING FIRE HYDRANT
 - NEW FIRE HYDRANT
 - NEW WTR. VALVE & BOX

NO.	DATE	REVISIONS	BY	CHKD.
1				
2	11/1/84	REV SAN. SEWER		
3	11/1/84	REV FOR CITY REVIEW		

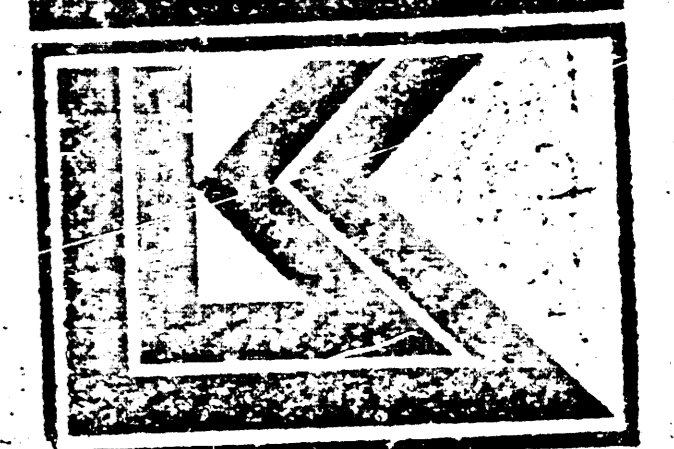

LAW/KINGDON, INC.
 ARCHITECTS & ENGINEERS
 1000 SHAWNEE, WICHITA, KANSAS 67202
 Phone (316) 266-2556 Copyright © 1984

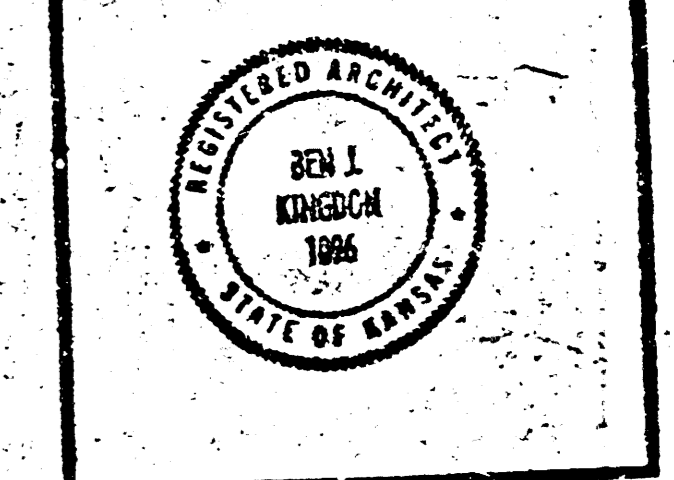


REVISION	CHECKED

RELATED DRAWINGS

SHEET	DETAILS	STRUCTURE	MECHANICAL	ELECTRICAL	OWNER








SEQUENCE NUMBER: 1 OF 1 SHEETS

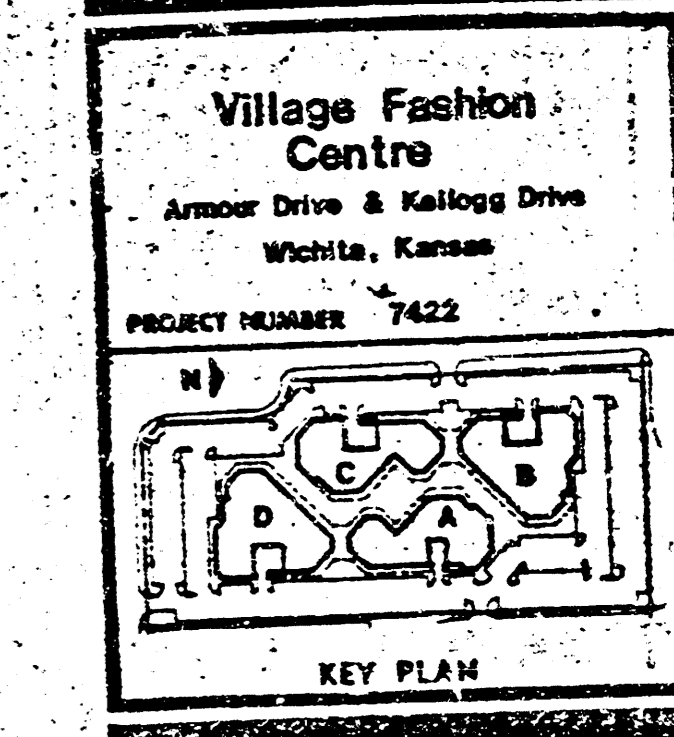

Village Fashion Centre
 Armour Drive & Kellogg Drive
 Wichita, Kansas
 PROJECT NUMBER 7422

SITE UTILITY PLAN
 SHEET TITLE: SU1
 SHEET NUMBER: 1 OF 1 SHEETS

FILMED FROM THE BEST AVAILABLE COPY....

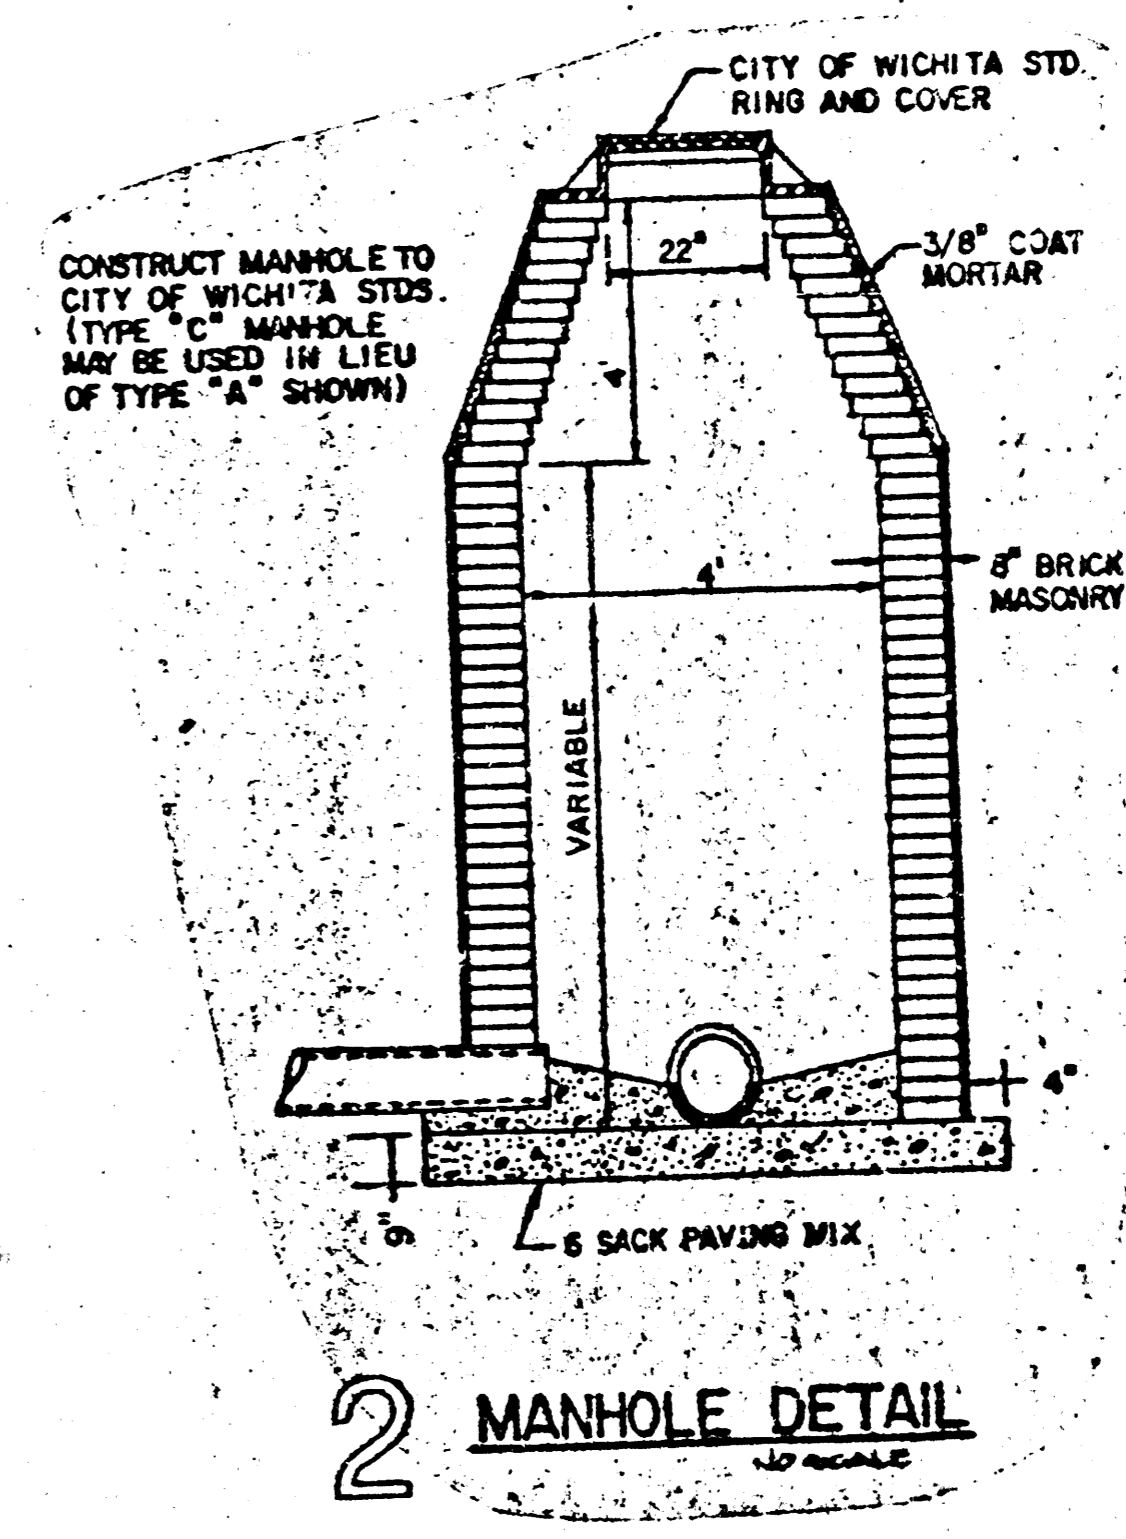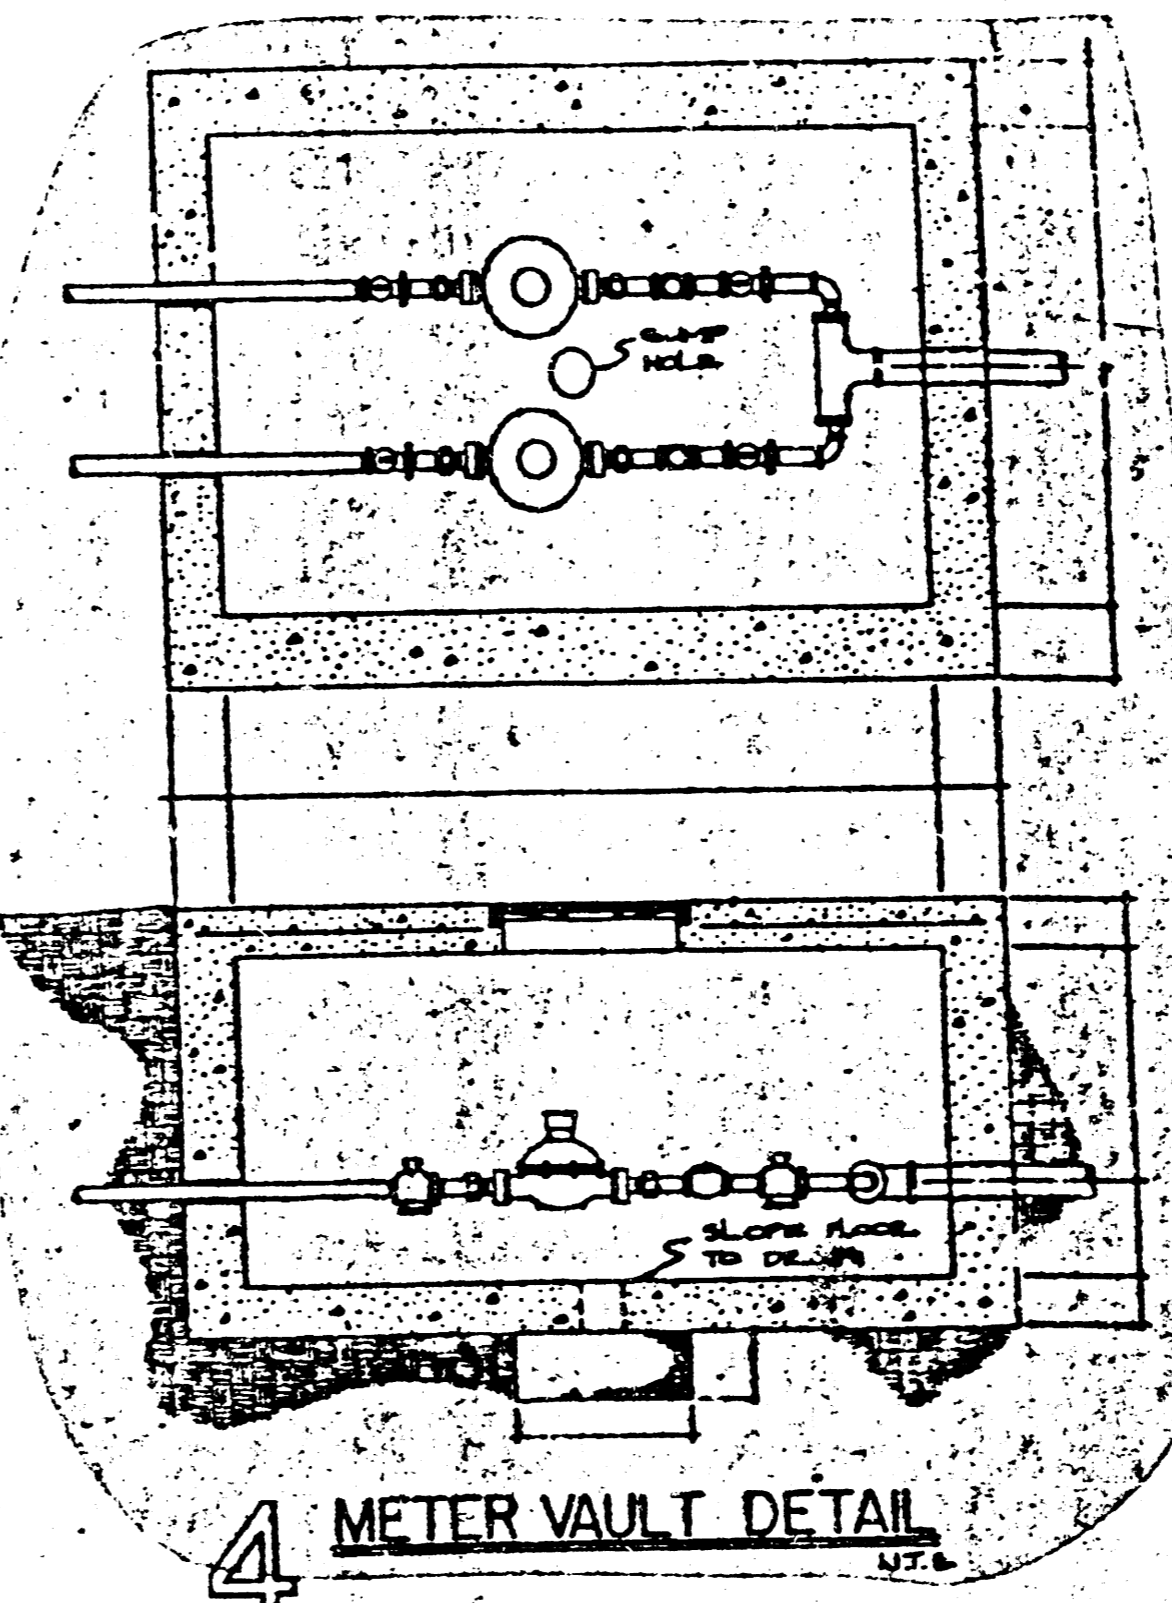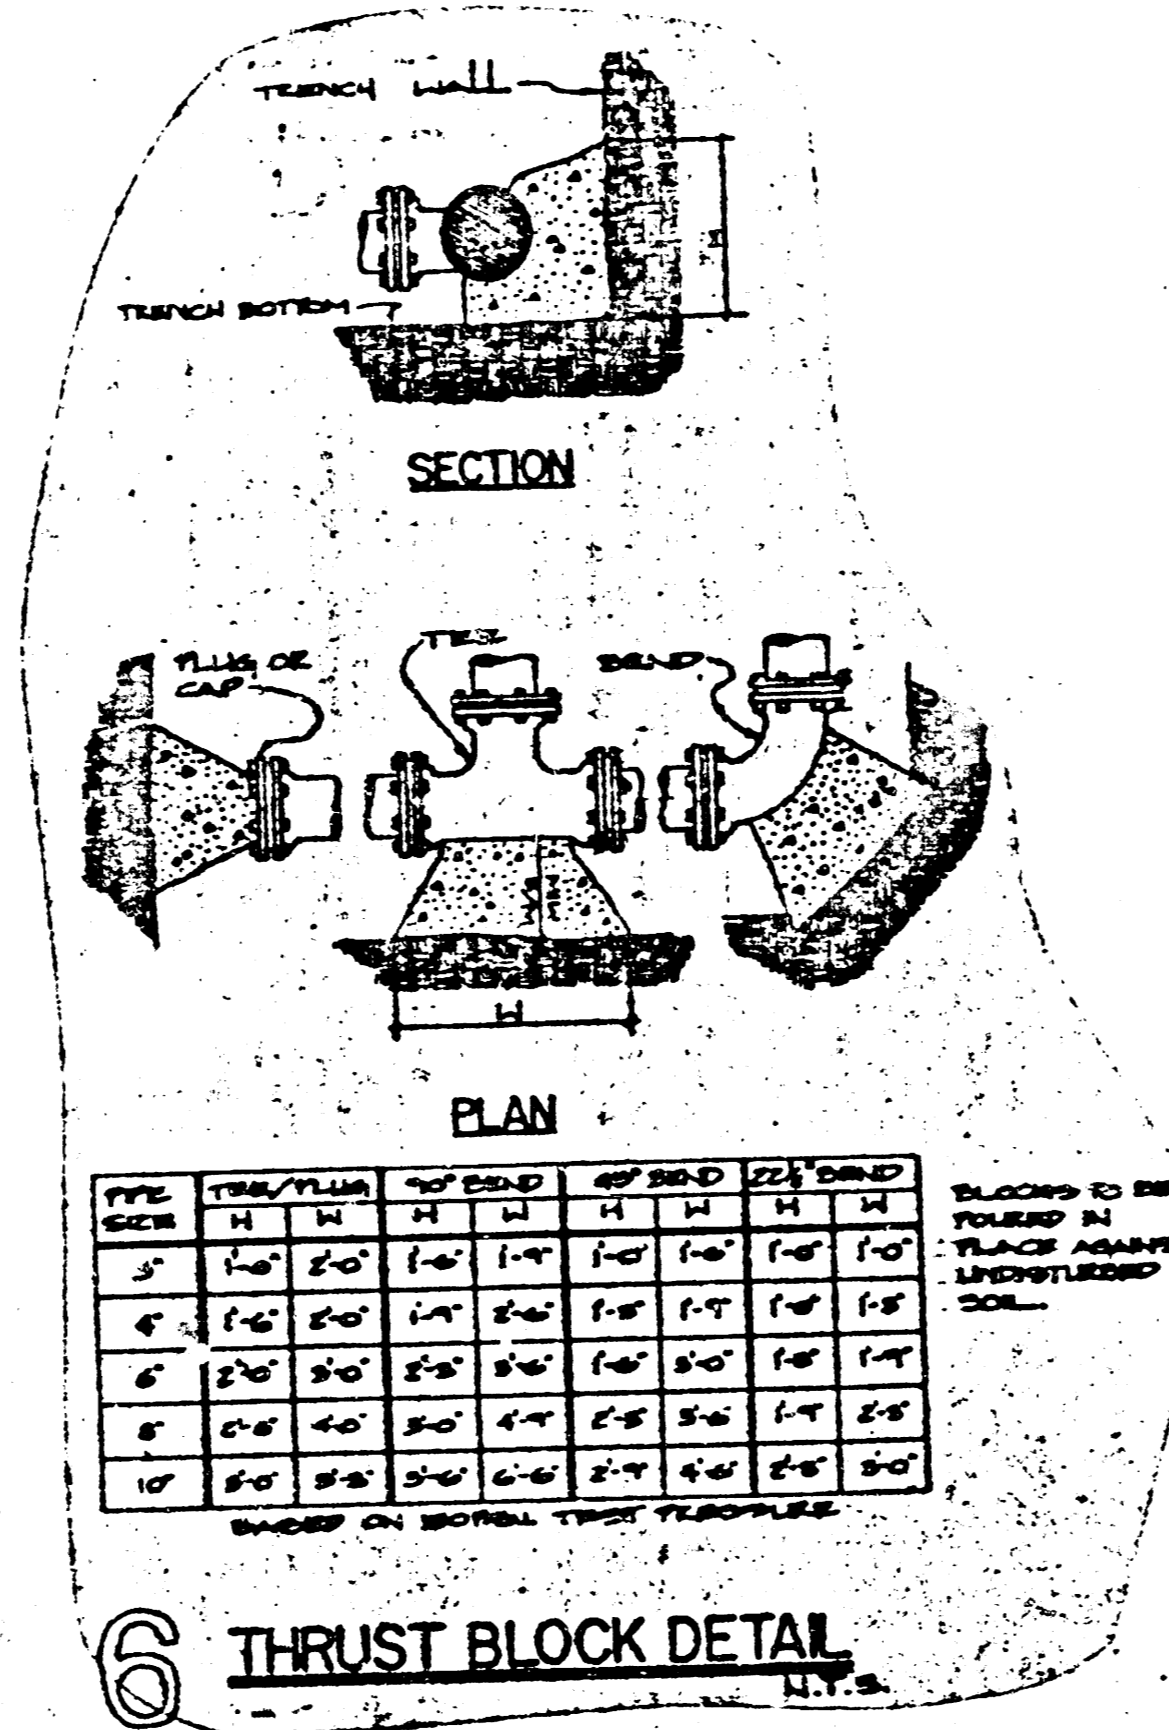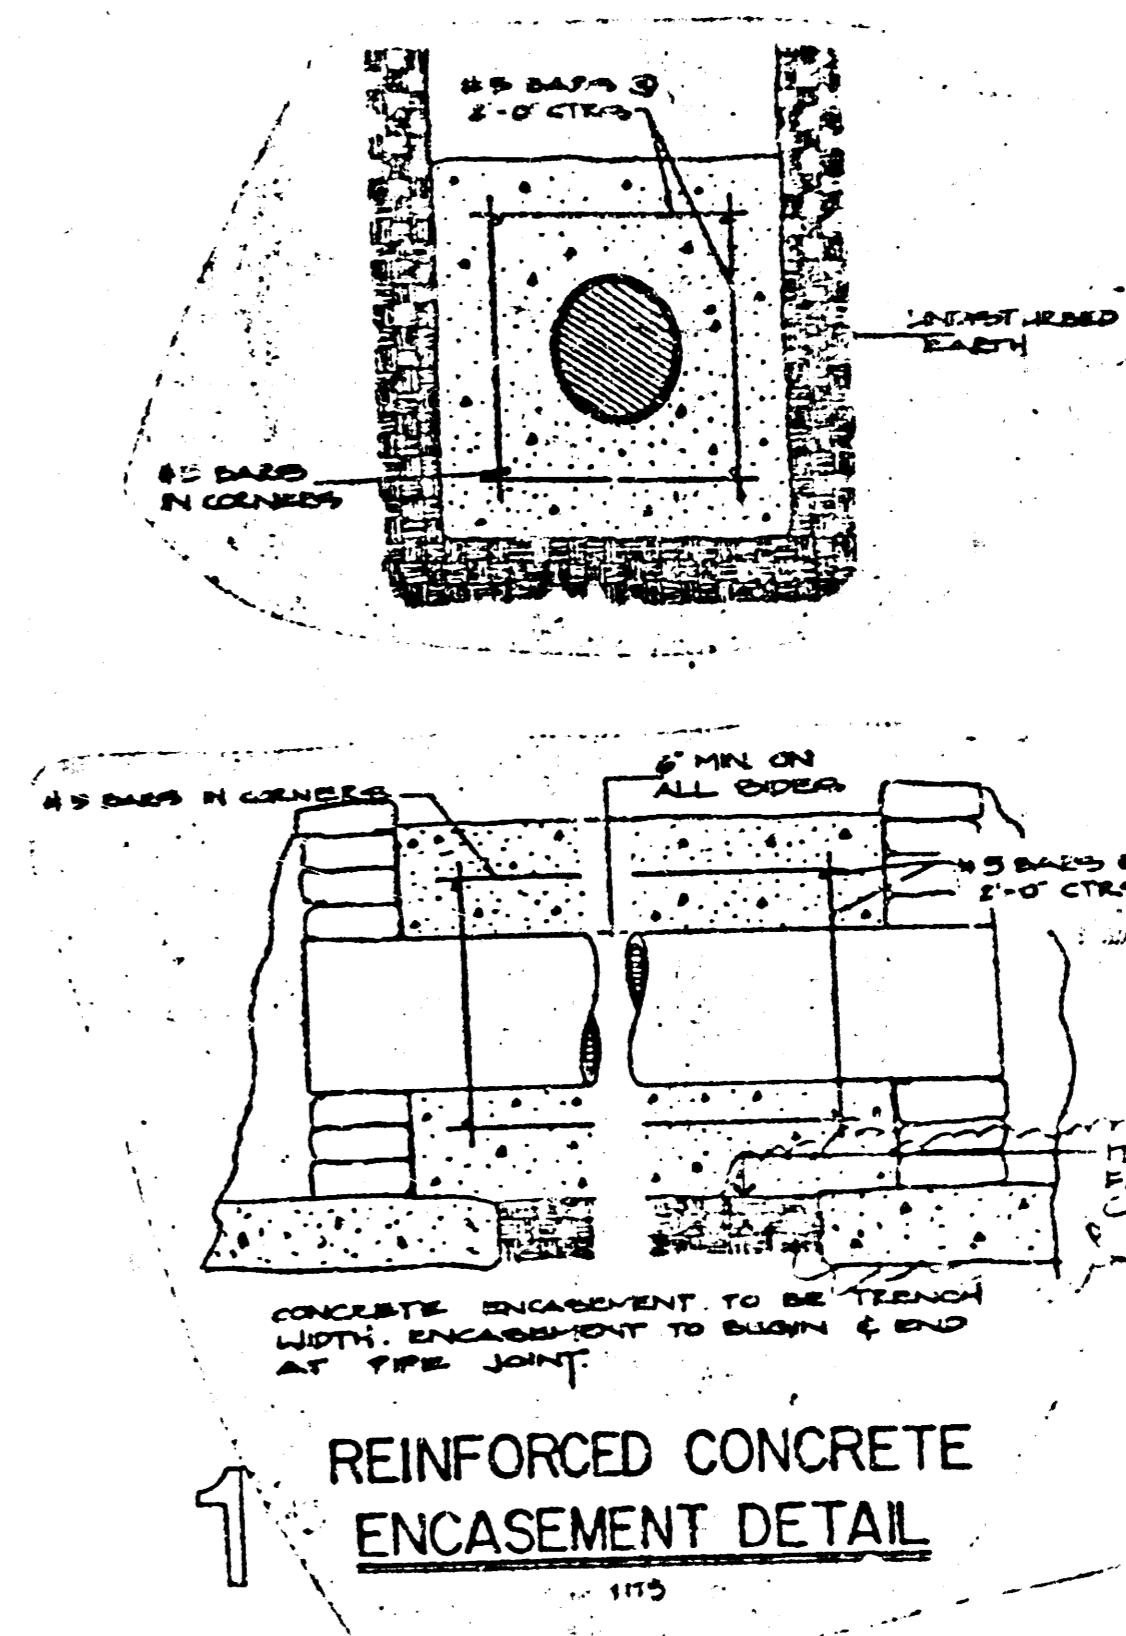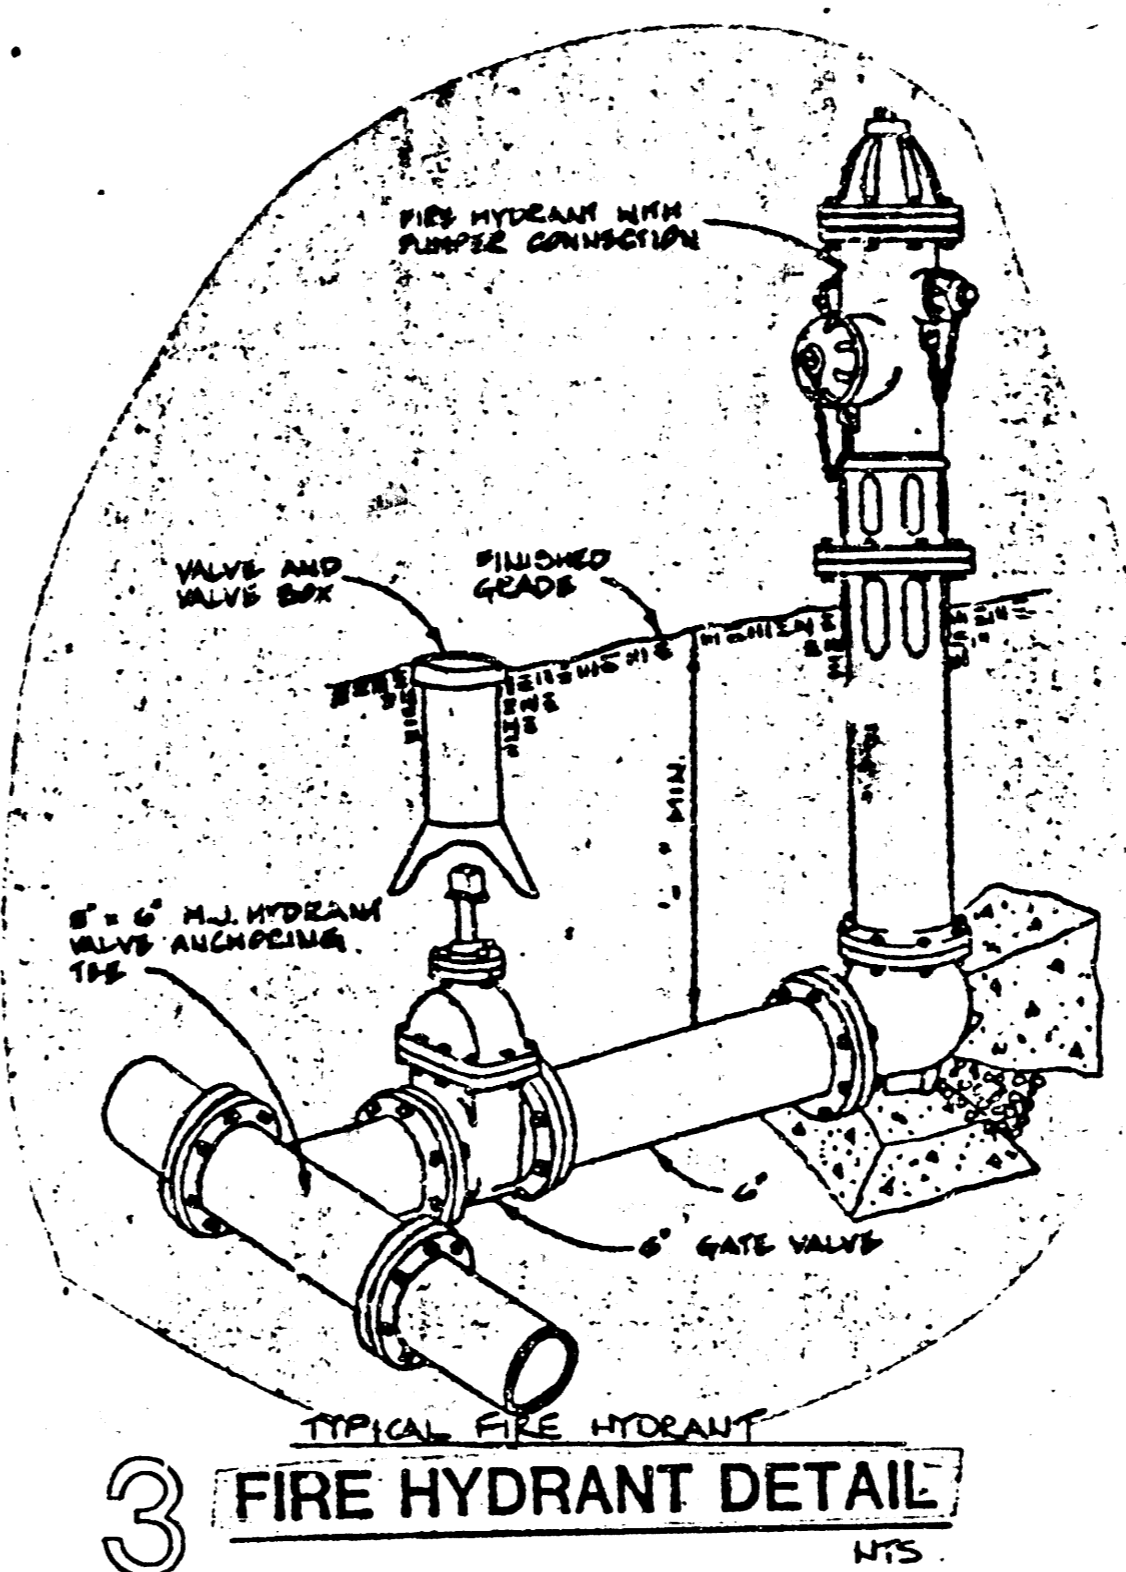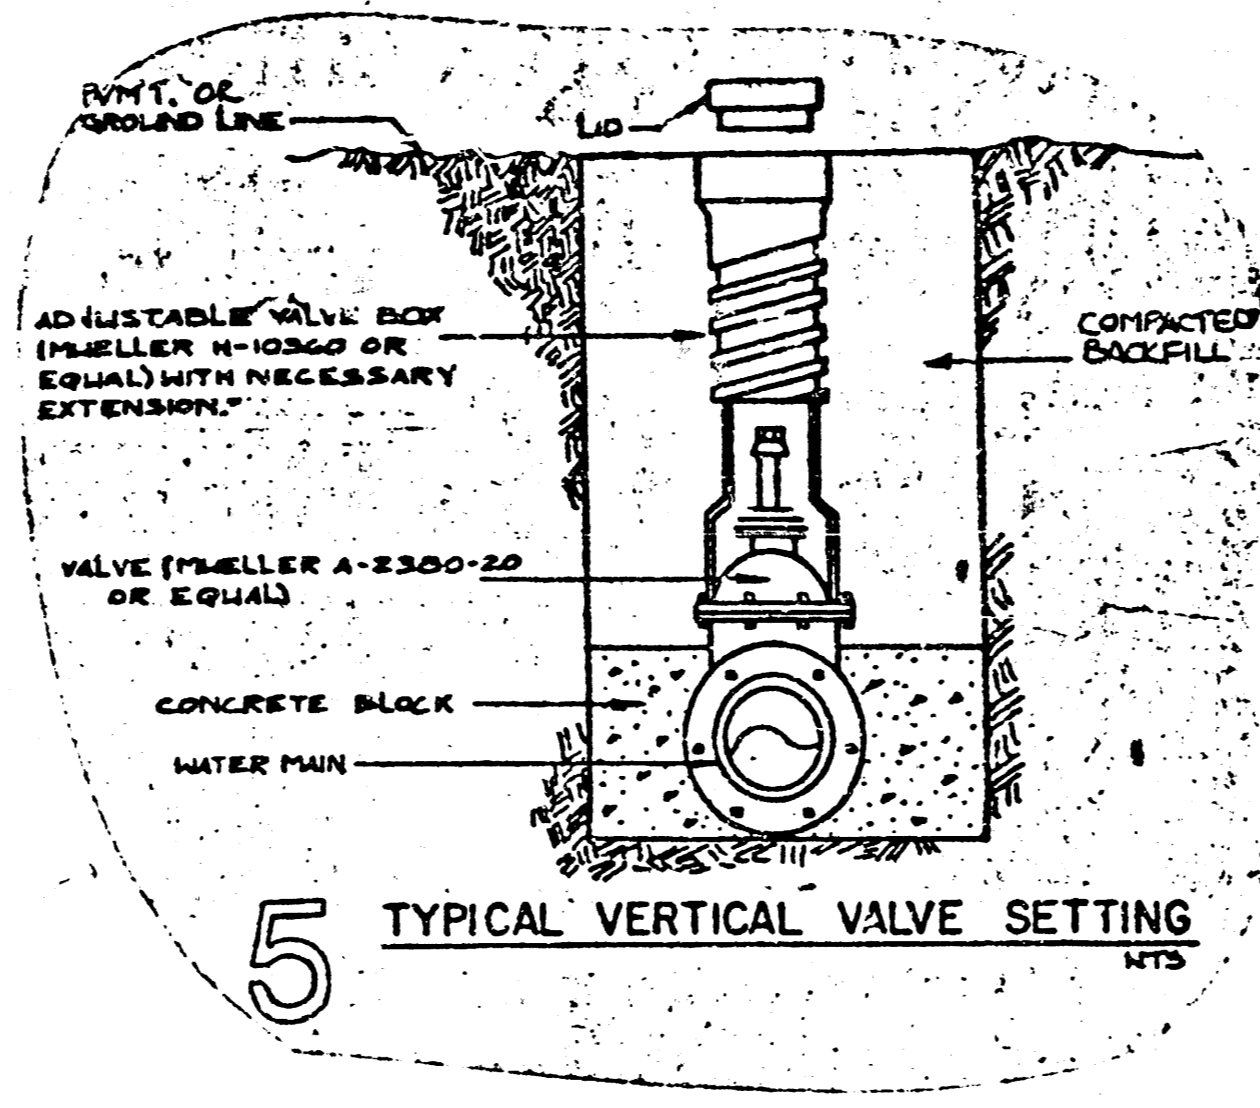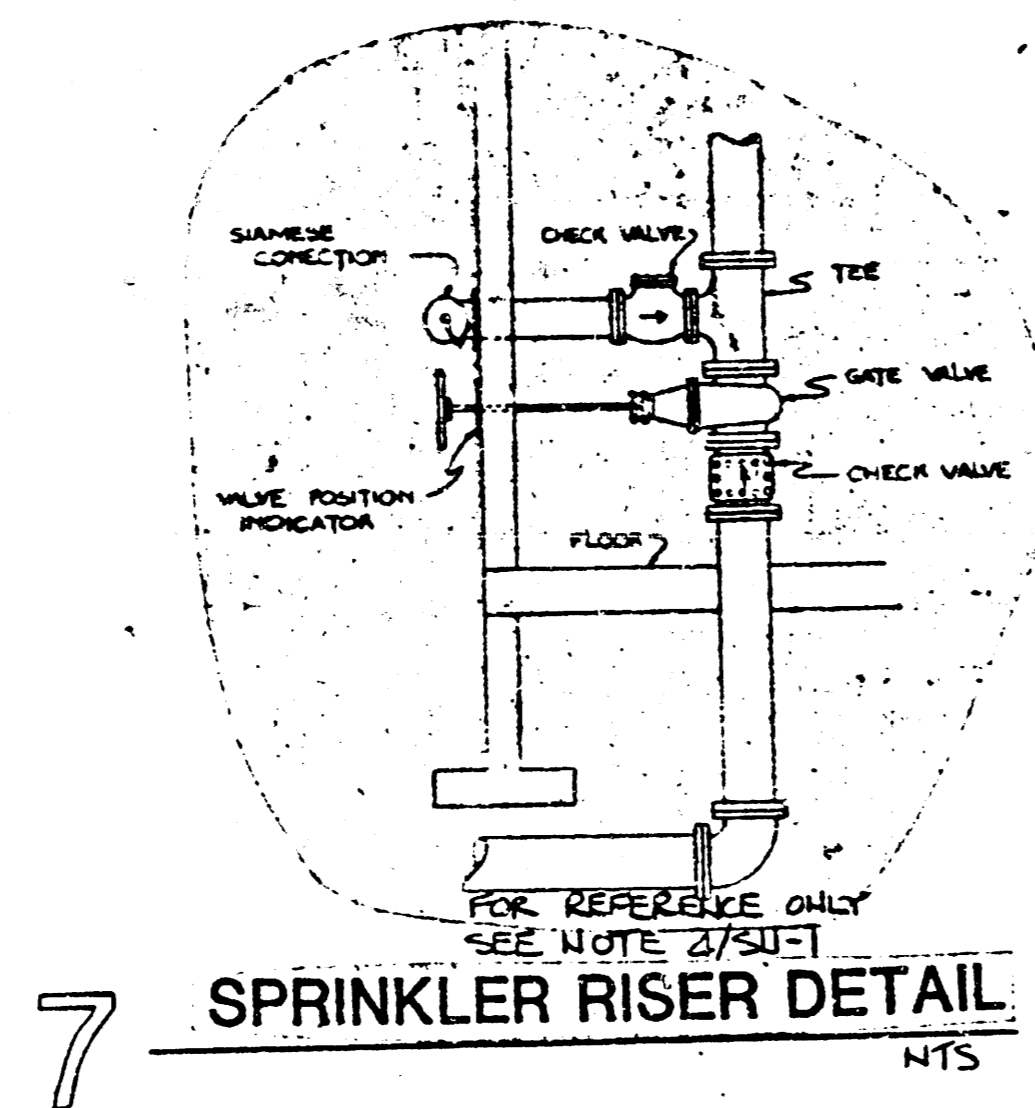


PIPE SIZE	TYPE/CLASS	1" BOLD	2" BOLD	3" BOLD	4" BOLD	6" BOLD	8" BOLD	10" BOLD
3"	1-4"	2'-0"	1'-4"	1'-0"	1'-0"	1'-0"	1'-0"	1'-0"
4"	1-4"	2'-0"	1'-4"	1'-0"	1'-0"	1'-0"	1'-0"	1'-0"
6"	2'-0"	2'-0"	2'-0"	2'-0"	2'-0"	2'-0"	2'-0"	2'-0"
8"	2'-0"	2'-0"	2'-0"	2'-0"	2'-0"	2'-0"	2'-0"	2'-0"
10"	2'-0"	2'-0"	2'-0"	2'-0"	2'-0"	2'-0"	2'-0"	2'-0"


BASED ON SERIAL TEST RESULTS

PRINTS ISSUED		
DATE	PURPOSE	NO.
1/28/84	FOR CONSTRUCTION	32
2/1/84	REV FOR CONSTRUCTION	33

REVISIONS		
DATE	ITEM	NO.
11/21/83	REV FOR CITY REVIEW	1

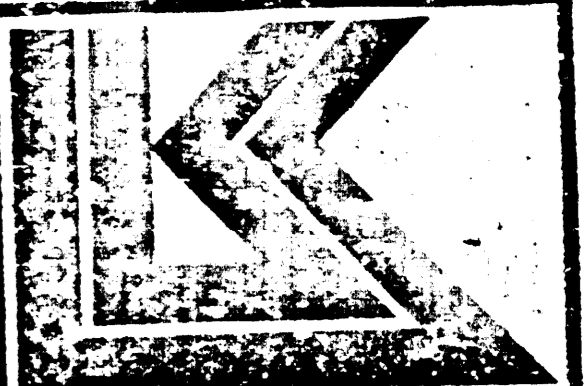

LAW/KINGDON, INC.
ARCHITECTS & ENGINEERS
648 SPRINGWOOD, WICHITA, KANSAS 67202
PHONE (316) 266-8230 Copyright © 1984

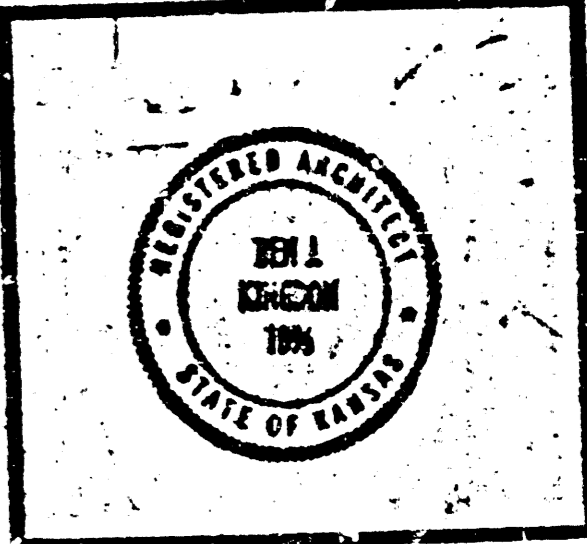

DESIGN	CHECKED

RELATED DRAWINGS

SMALL	
DETAILS	
STRUCTURE	
MACHINICAL	
ELECTRICAL	
OTHER	

SEQUENCE NUMBER _____ OF _____ SHEETS


Village Fashion Centre
Armour Drive & Kellogg Drive
Wichita, Kansas

PROJECT NUMBER 7422



KEY PLAN

SITE UTILITY DETAILS
SHEET TITLE
SHEET NUMBER

SU2
OF 2 SHEETS

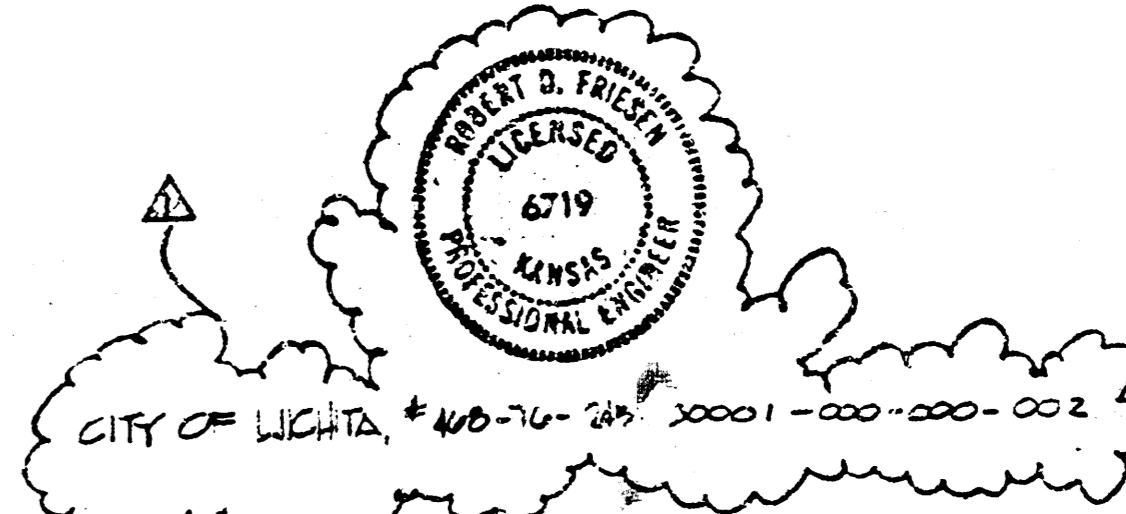

FILMED FROM THE BEST AVAILABLE COPY....

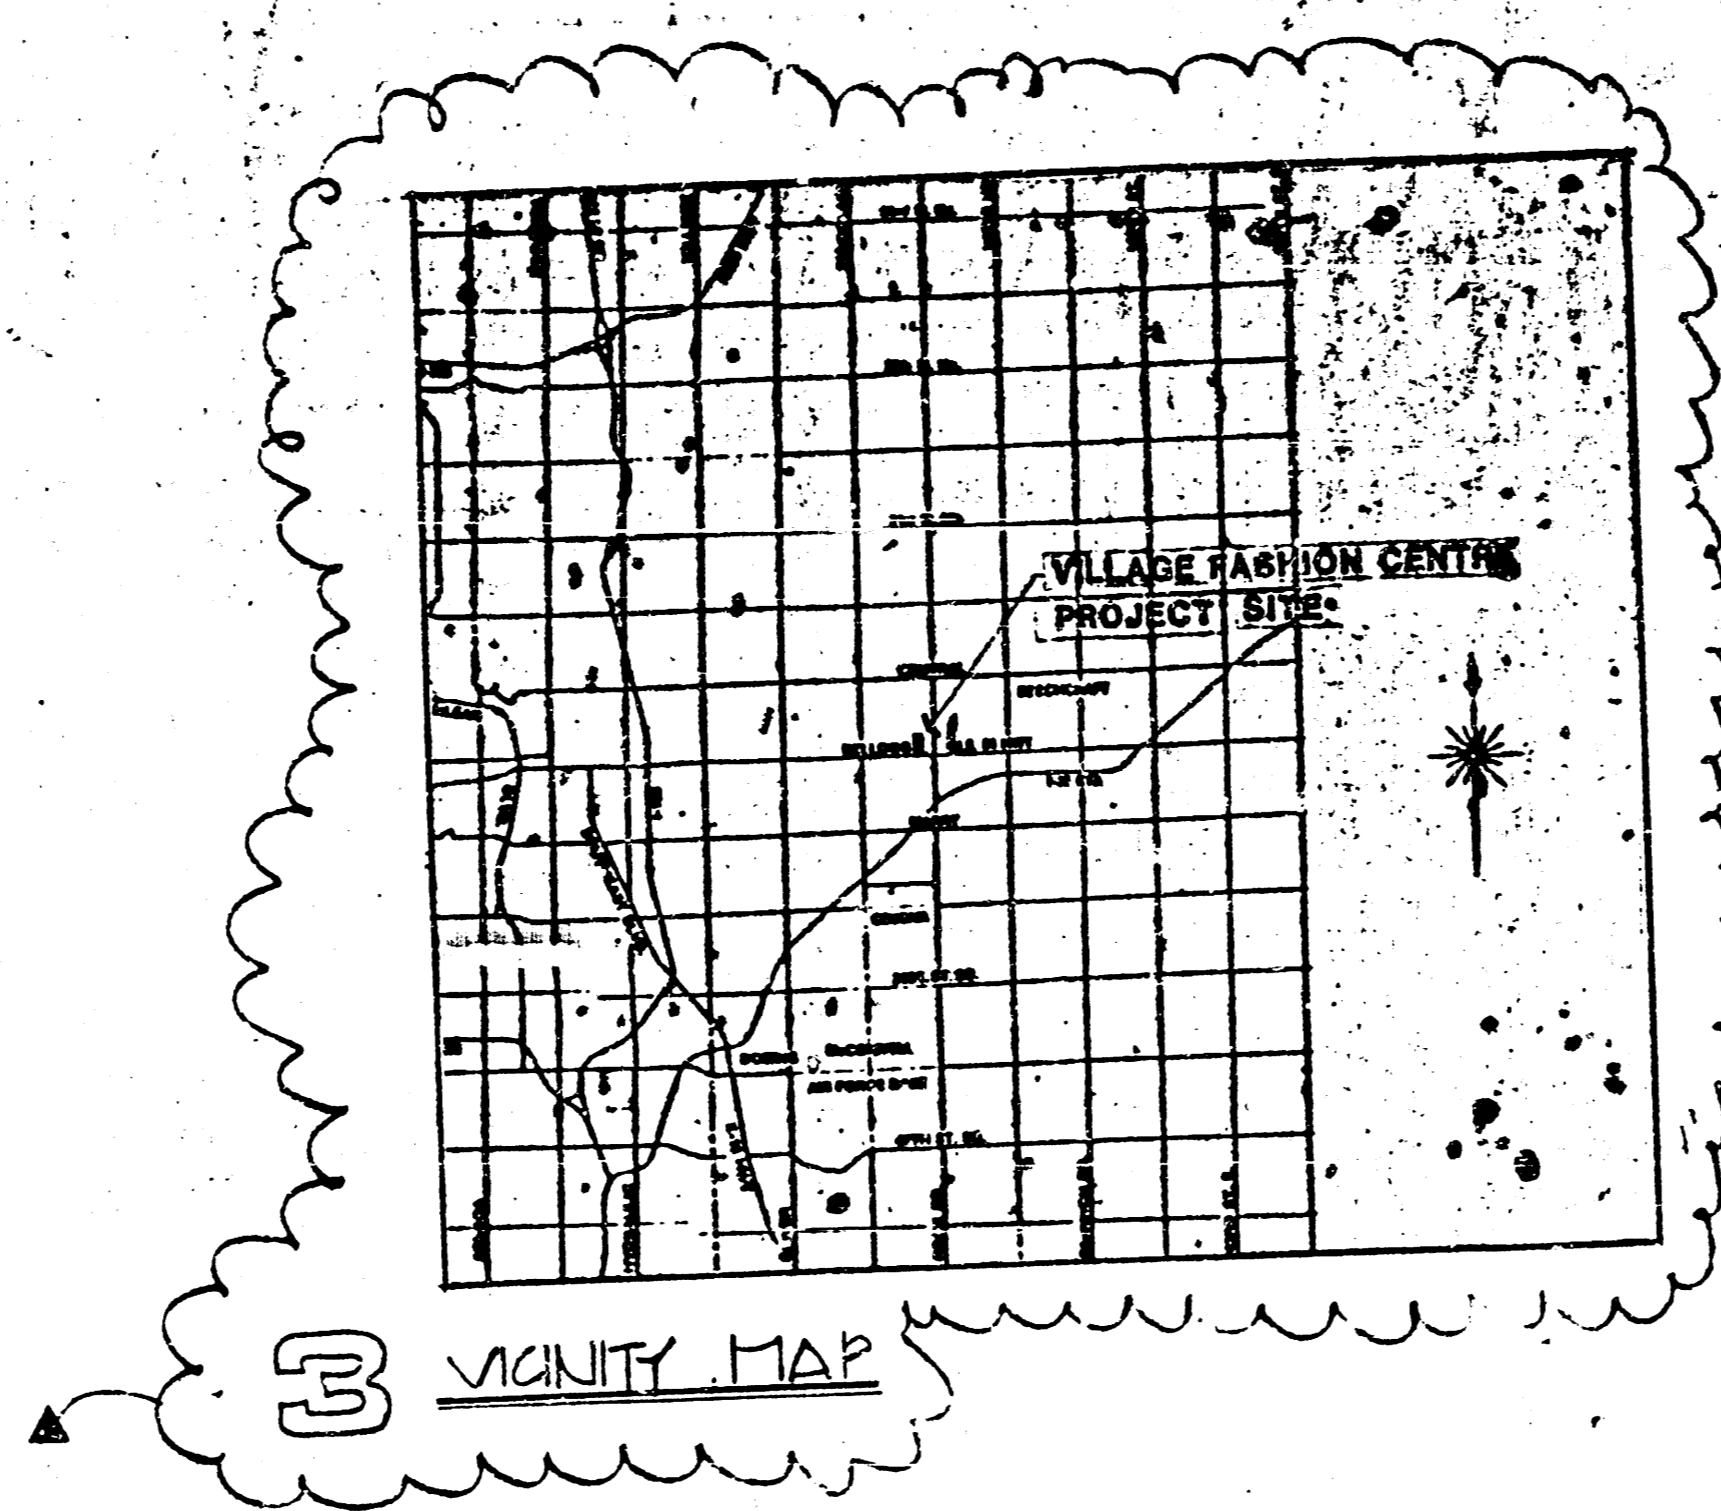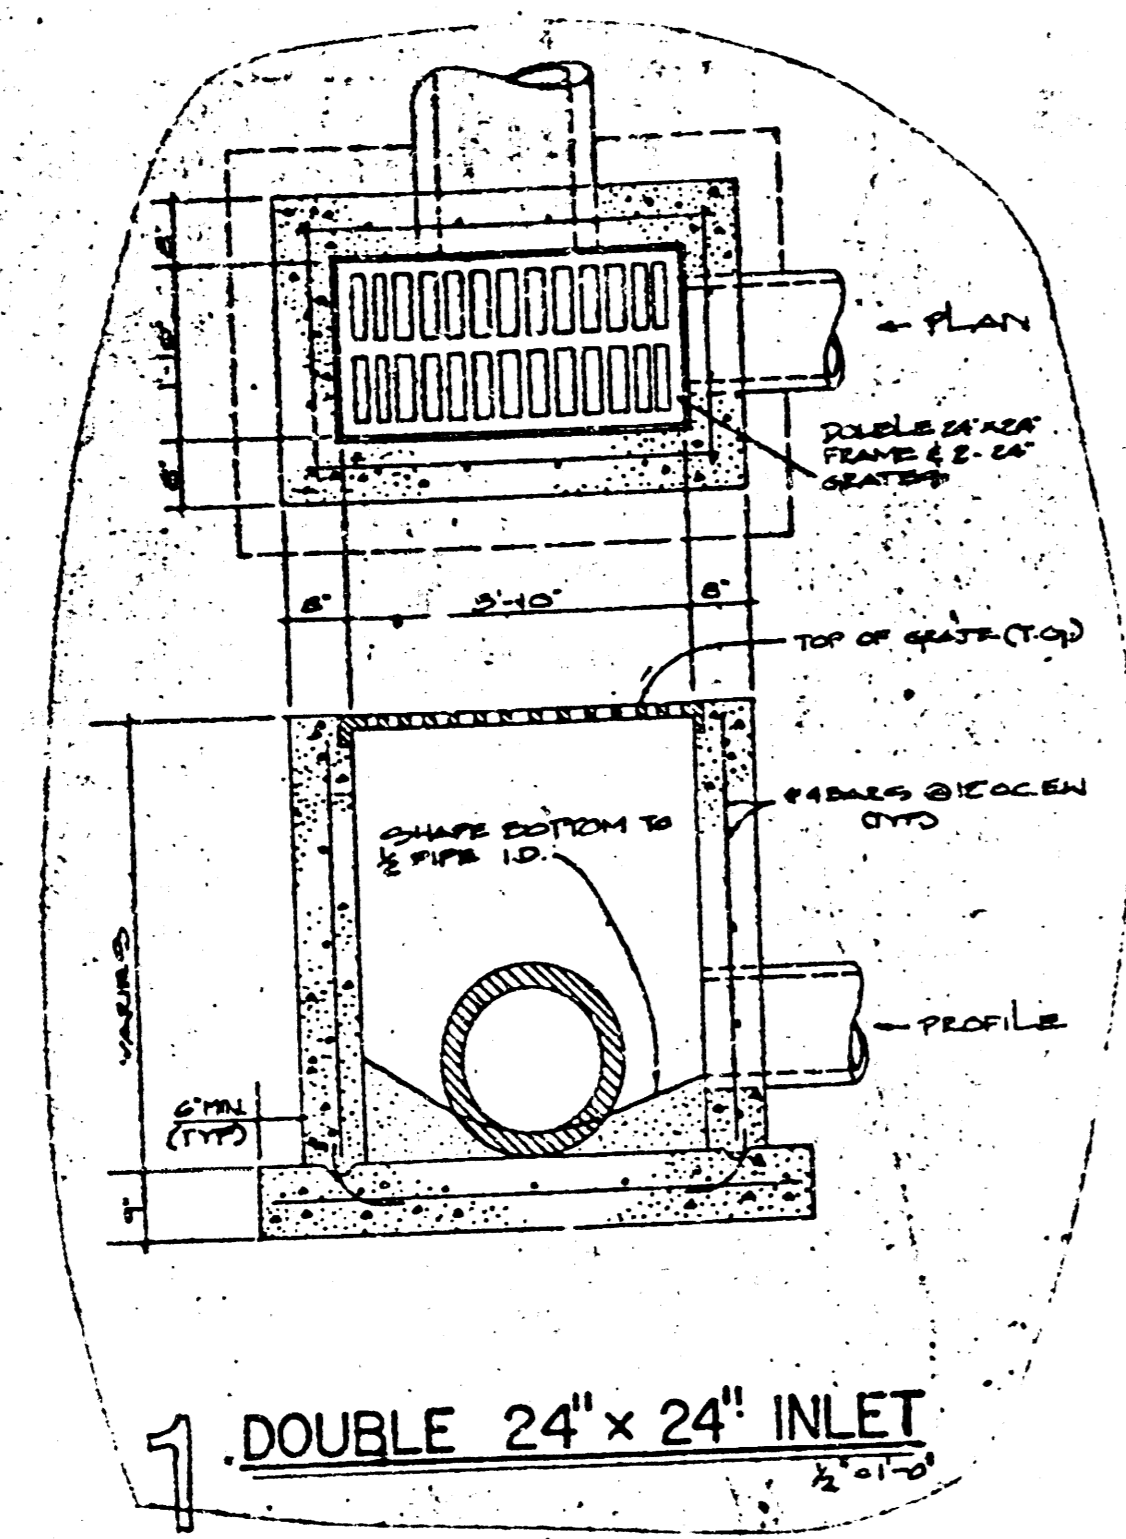


POINT	NORTH	EAST	DESCRIPTION
1	1318.000	814.000	INLET # A-1
2	1301.000	800.000	INLET # A-2
3	1284.000	786.000	INLET # A-3
4	1267.000	772.000	INLET # A-4
5	1250.000	758.000	INLET # A-5
6	1233.000	744.000	INLET # A-6
7	1216.000	730.000	INLET # A-7
8	1199.000	716.000	INLET # A-8
9	1182.000	702.000	INLET # A-9
10	1165.000	688.000	INLET # A-10
11	1148.000	674.000	INLET # A-11
12	1131.000	660.000	INLET # A-12
13	1114.000	646.000	INLET # A-13
14	1097.000	632.000	INLET # A-14
15	1080.000	618.000	INLET # A-15
16	1063.000	604.000	INLET # A-16
17	1046.000	590.000	INLET # A-17
18	1029.000	576.000	INLET # A-18
19	1012.000	562.000	INLET # A-19
20	995.000	548.000	INLET # A-20
21	978.000	534.000	INLET # A-21
22	961.000	520.000	INLET # A-22
23	944.000	506.000	INLET # A-23
24	927.000	492.000	INLET # A-24
25	910.000	478.000	INLET # A-25
26	893.000	464.000	INLET # A-26
27	876.000	450.000	INLET # A-27
28	859.000	436.000	INLET # A-28
29	842.000	422.000	INLET # A-29
30	825.000	408.000	INLET # A-30

NOTES


- REFER TO SHEET SA-2 FOR EXACT ELEVATIONS OF SIDEWALKS, SERVICE COURTS, COURTYARDS, ETC. ADJACENT TO BUILDINGS.
- REFER TO PLUMBING PLANS FOR CONTINUATION OF COURTYARD DRAINS, ROOF DRAINS, ETC.
- DOE TO THE MINIMUM COVER AVAILABLE. THE CONTRACTOR IS REQUIRED TO USE EXTRA CAUTION TO PROTECT STORM WATER SEWER FROM DAMAGE UNTIL PAVEMENT IS IN PLACE. DO NOT ALLOW HEAVY TRUCKS TO CROSS PIPE WITH LESS THAN 12" COVER. DAMAGED PIPE WILL NEED TO BE REMOVED AND REPLACED PRIOR TO PAVING.

PRINTS ISSUED	
DATE	AMOUNT
11/24	FOR CONSTRUCTION
12/24	REV FOR CONSTRUCTION

FOR CONSTRUCTION: 11/1/84	
REVISIONS	
DATE	ITEM
11/24	DEPT DRIVE
11/24	REV FOR CIV REVELL

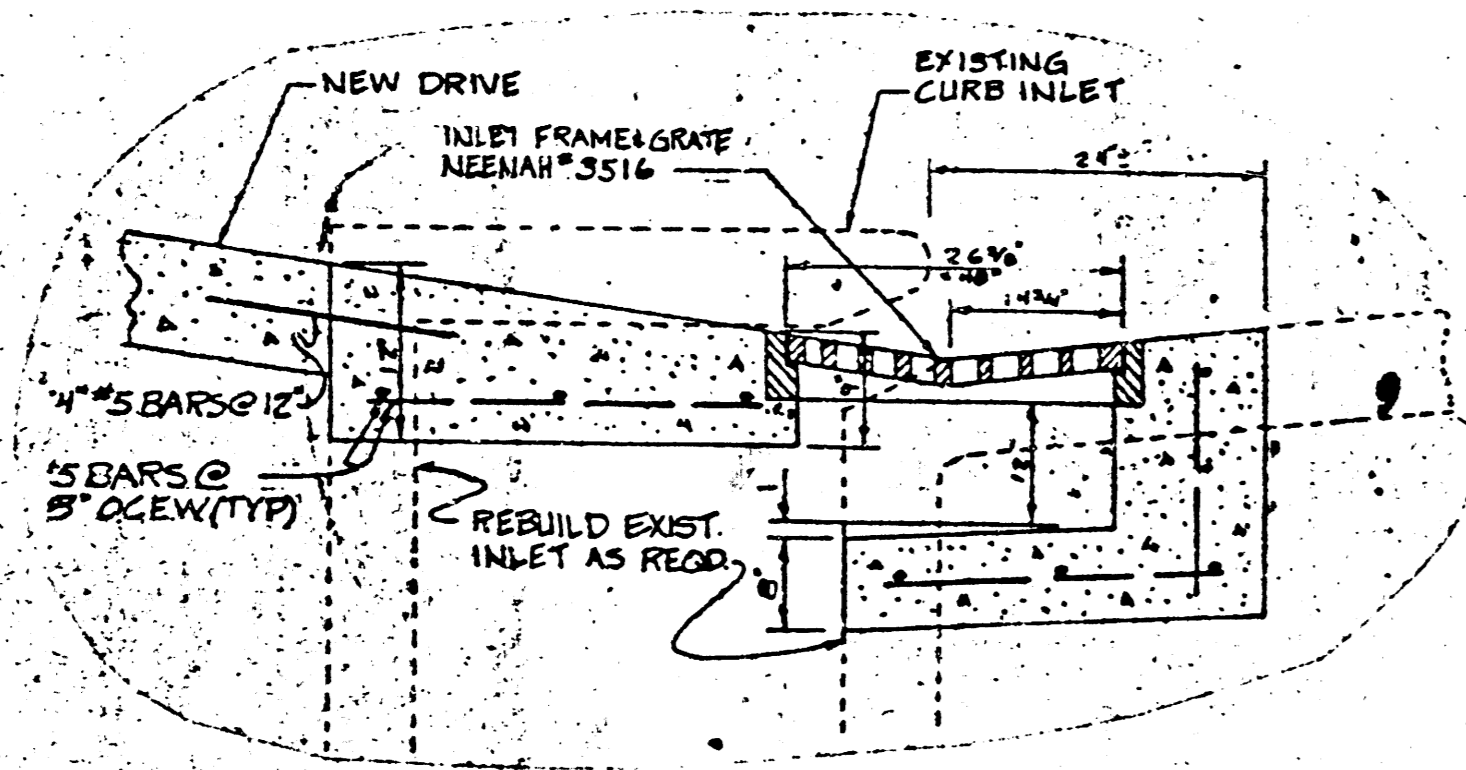


2 REBUILT CURB INLET NTS

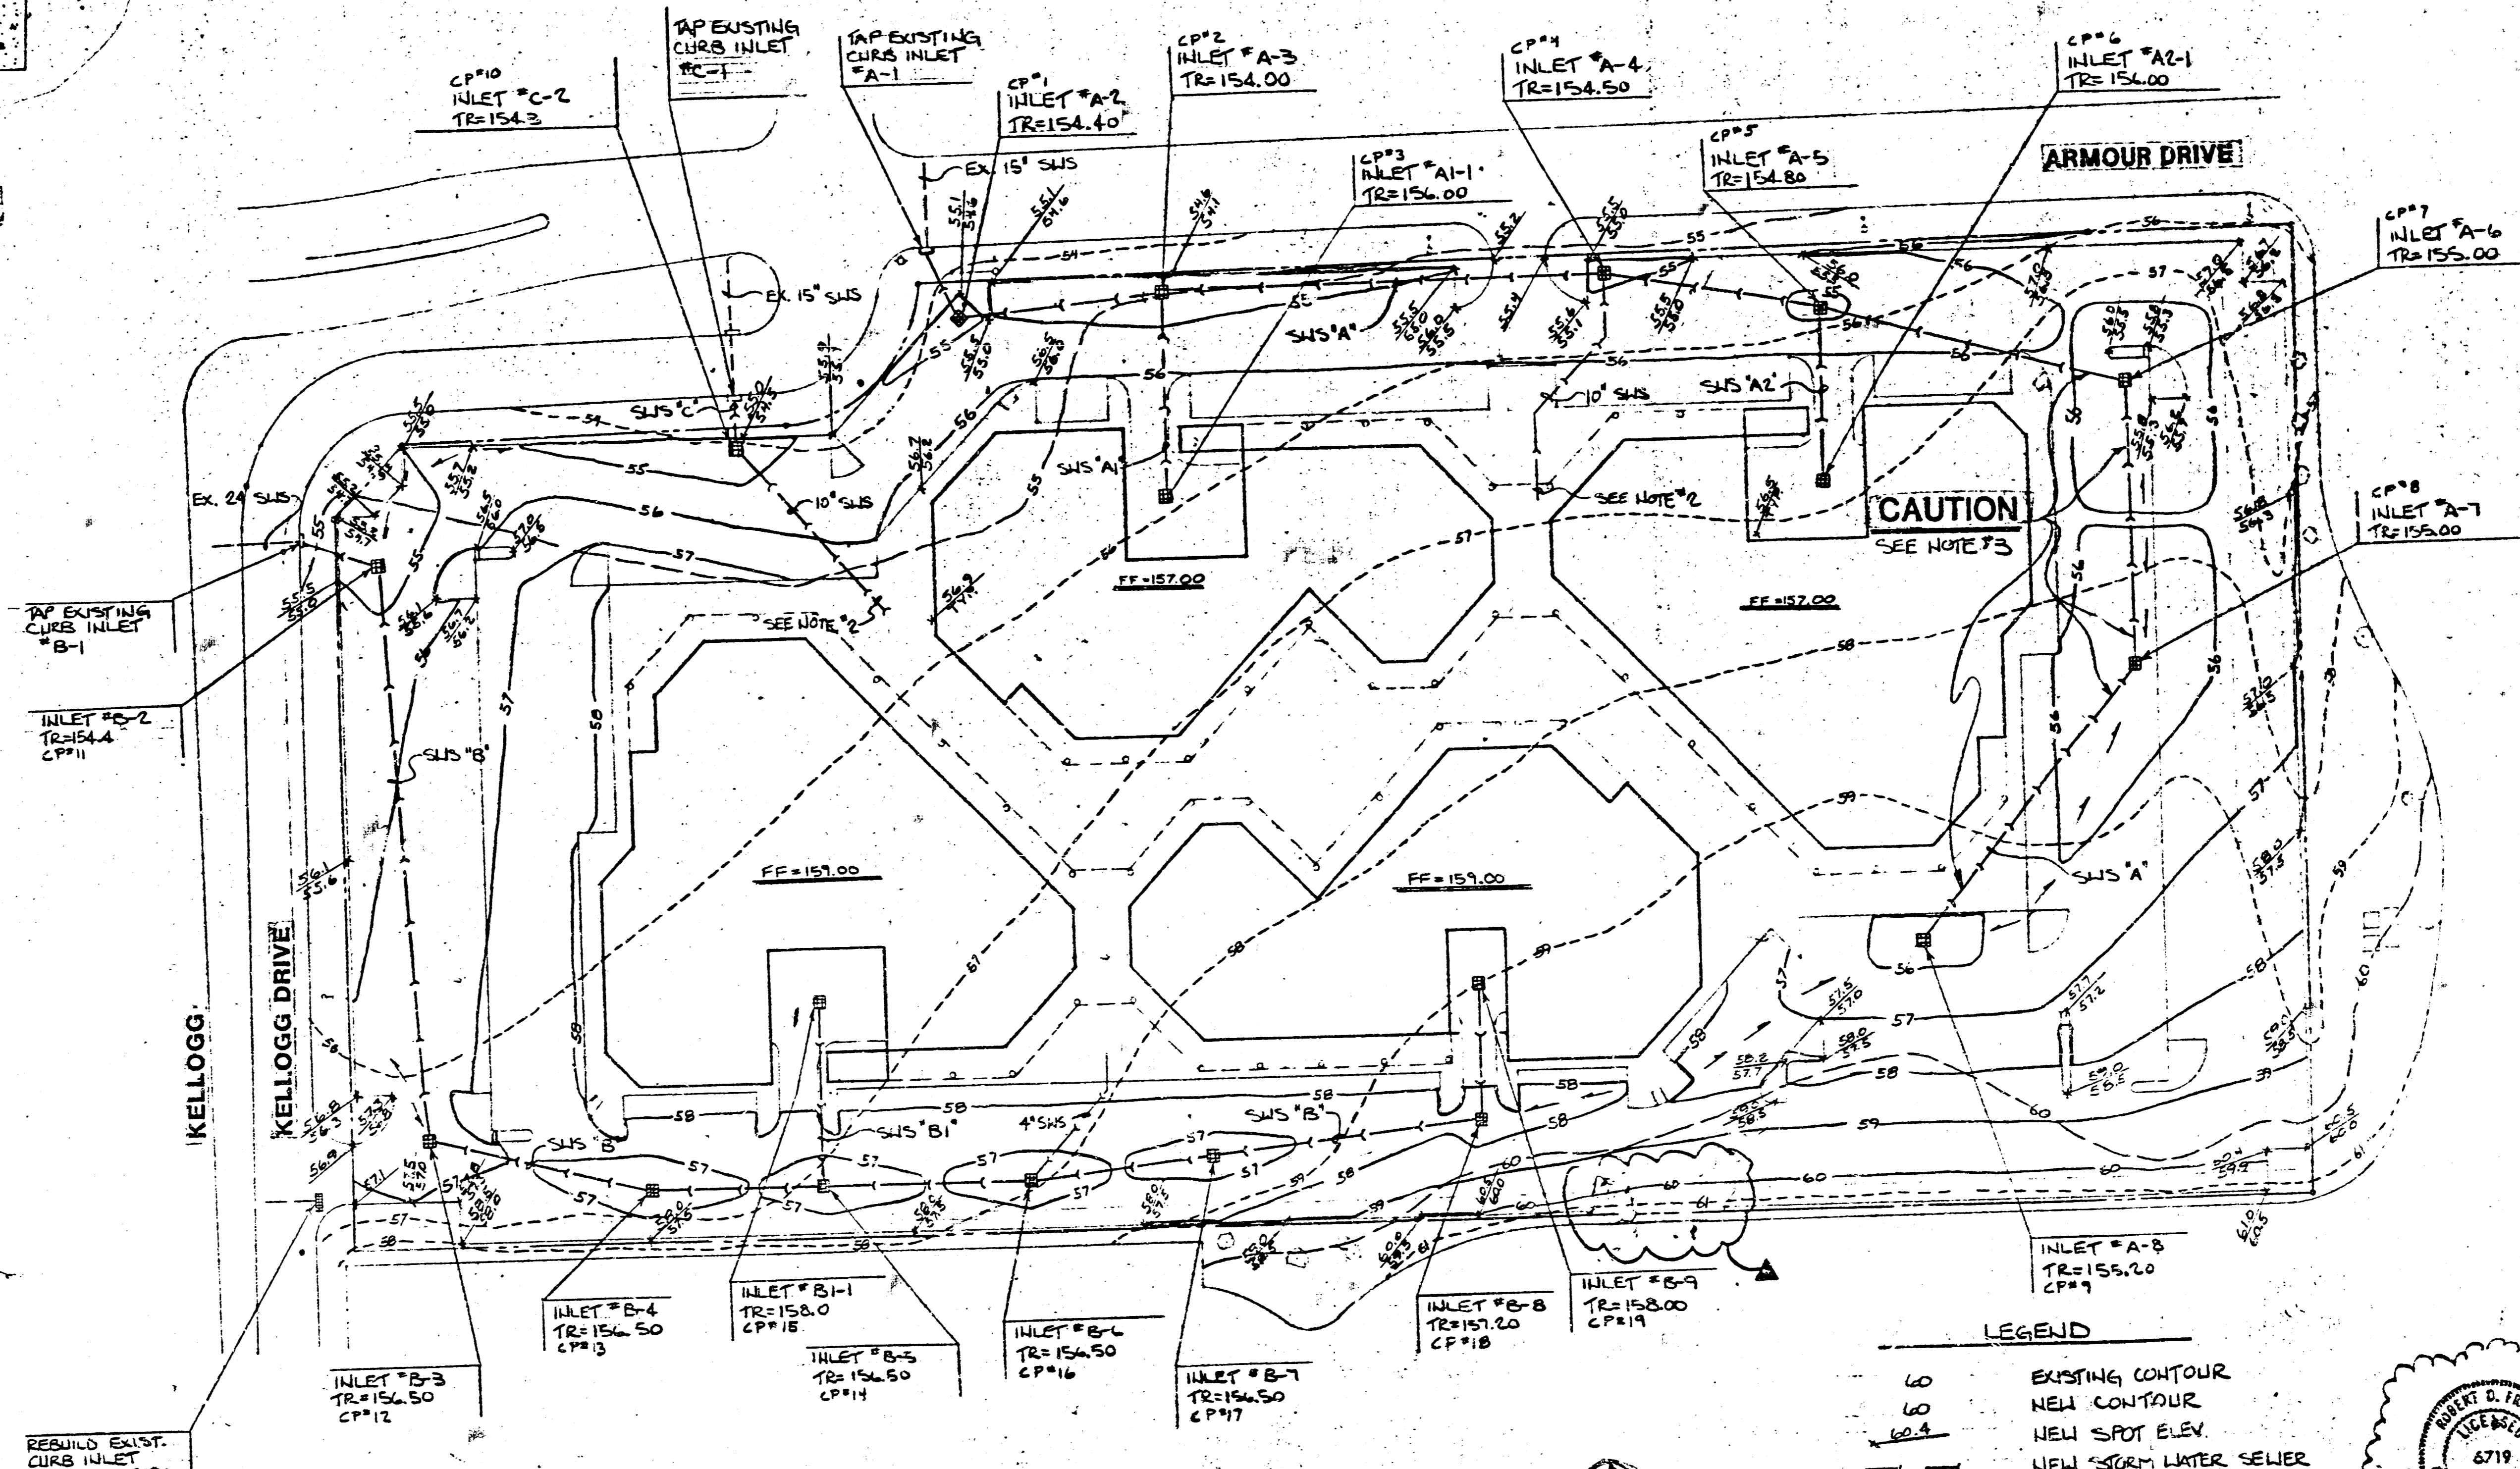


A SITE GRADING PLAN
SCALE: 1" = 40'
HAS BEEN REDUCED TO 1" = 50'

LEGEND

— 60	EXISTING CONTOUR
— 64	NEW CONTOUR
— 64	NEW SPOT ELEV
—	NEW STORM WATER SEWER
—	NEW INLET
—	DRAINAGE

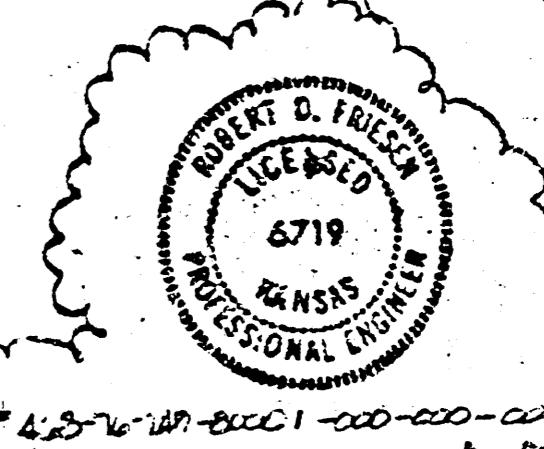

LAWKINGTON, INC.
ARCHITECTS & ENGINEERS
540 UNIVERSITY, WICHITA, KANSAS 67208
PHONE: (316) 262-2700 COUNCIL # 1000

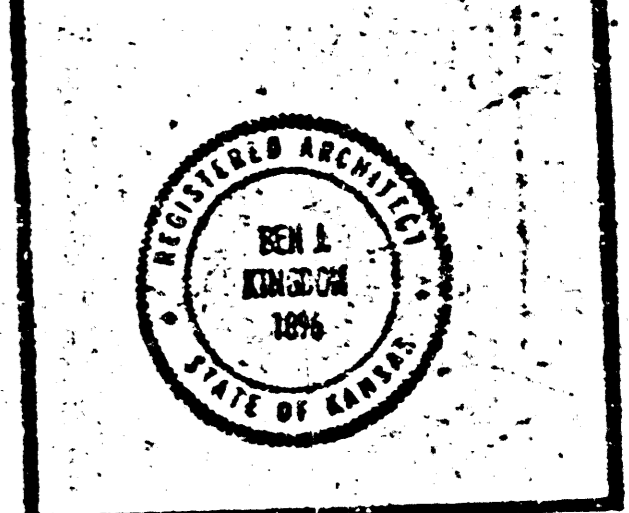

REVISION	CHECKED

RELATED DRAWINGS	
SHEET	DATE






Village Fashion Centre
Armour Drive & Kellogg Drive
Wichita, Kansas
PROJECT NUMBER - 7422

KEY PLAN

SITE GRADING PLAN
SHEET TITLE
SHEET NUMBER

SG1
OF SHEETS

FILMED FROM THE BEST AVAILABLE COPY....

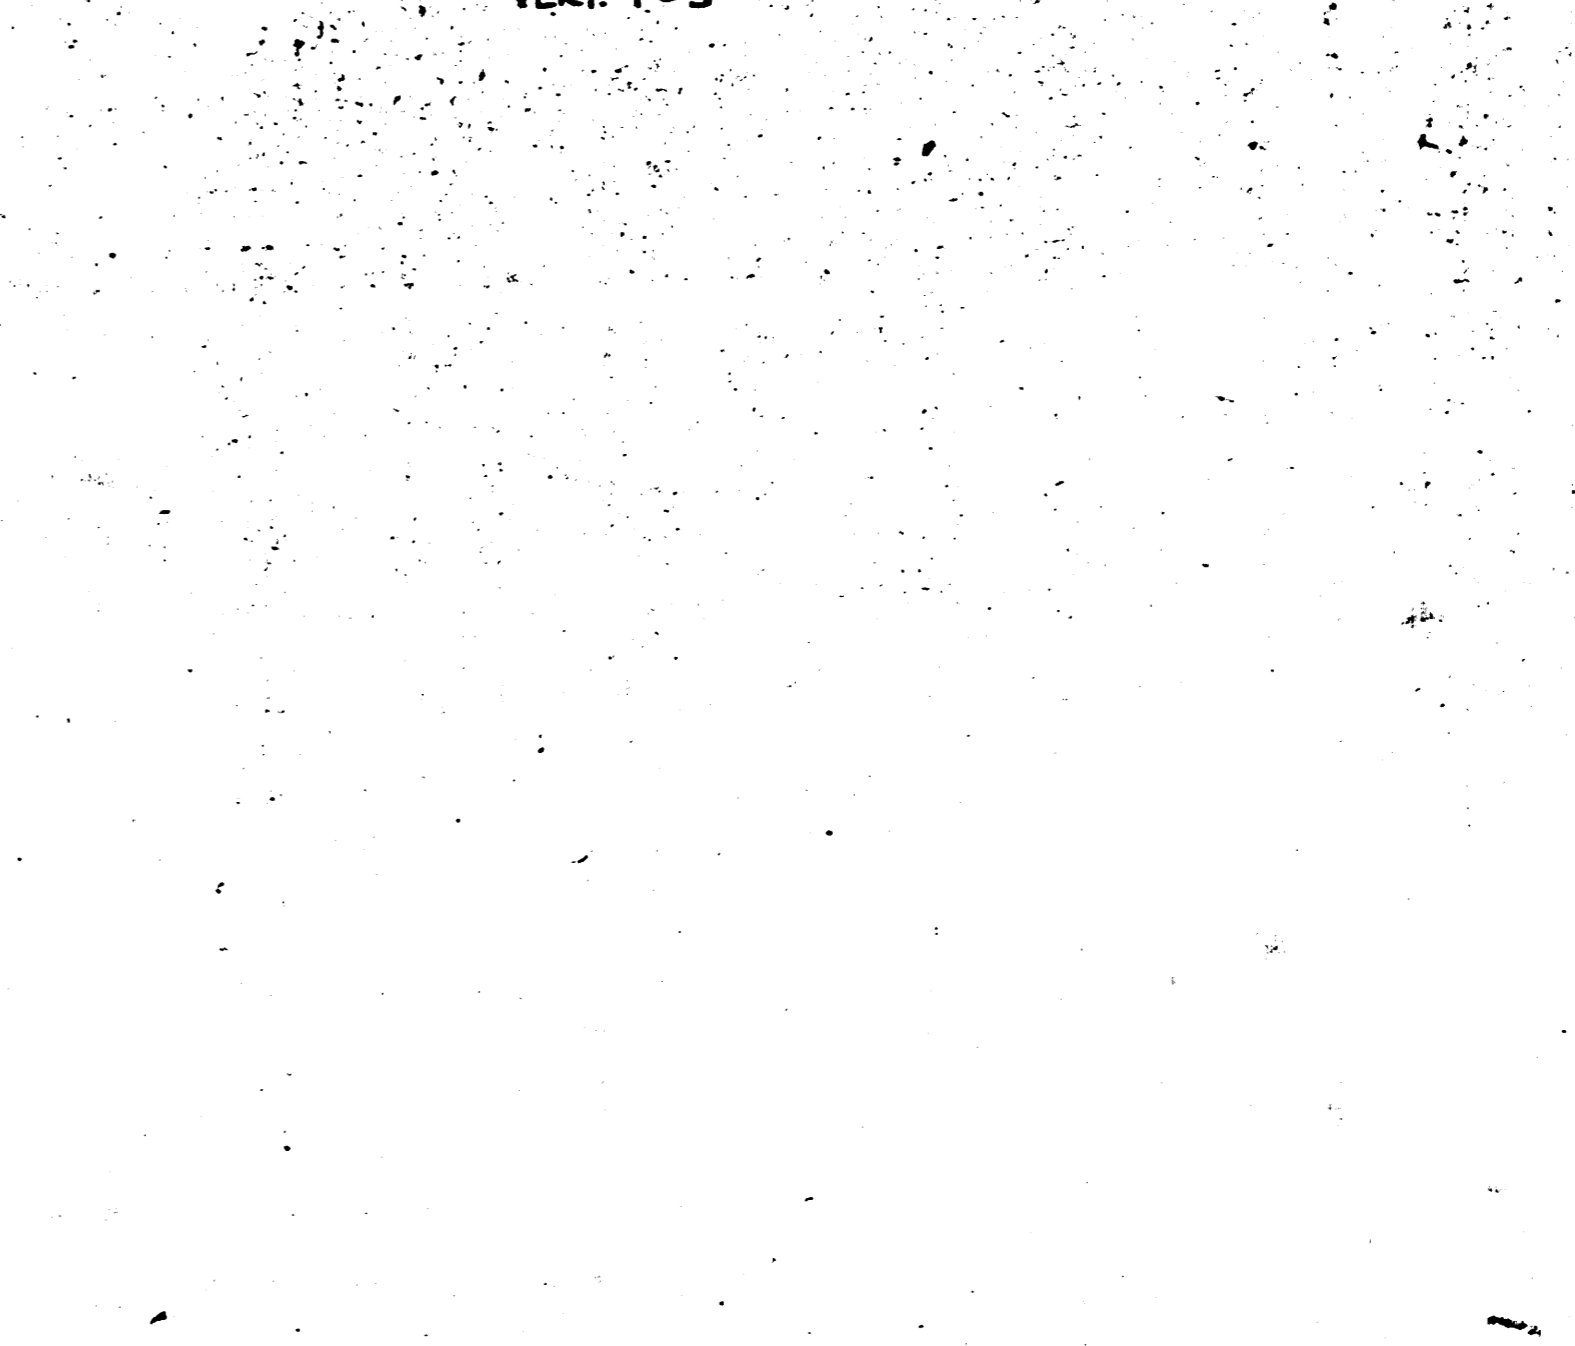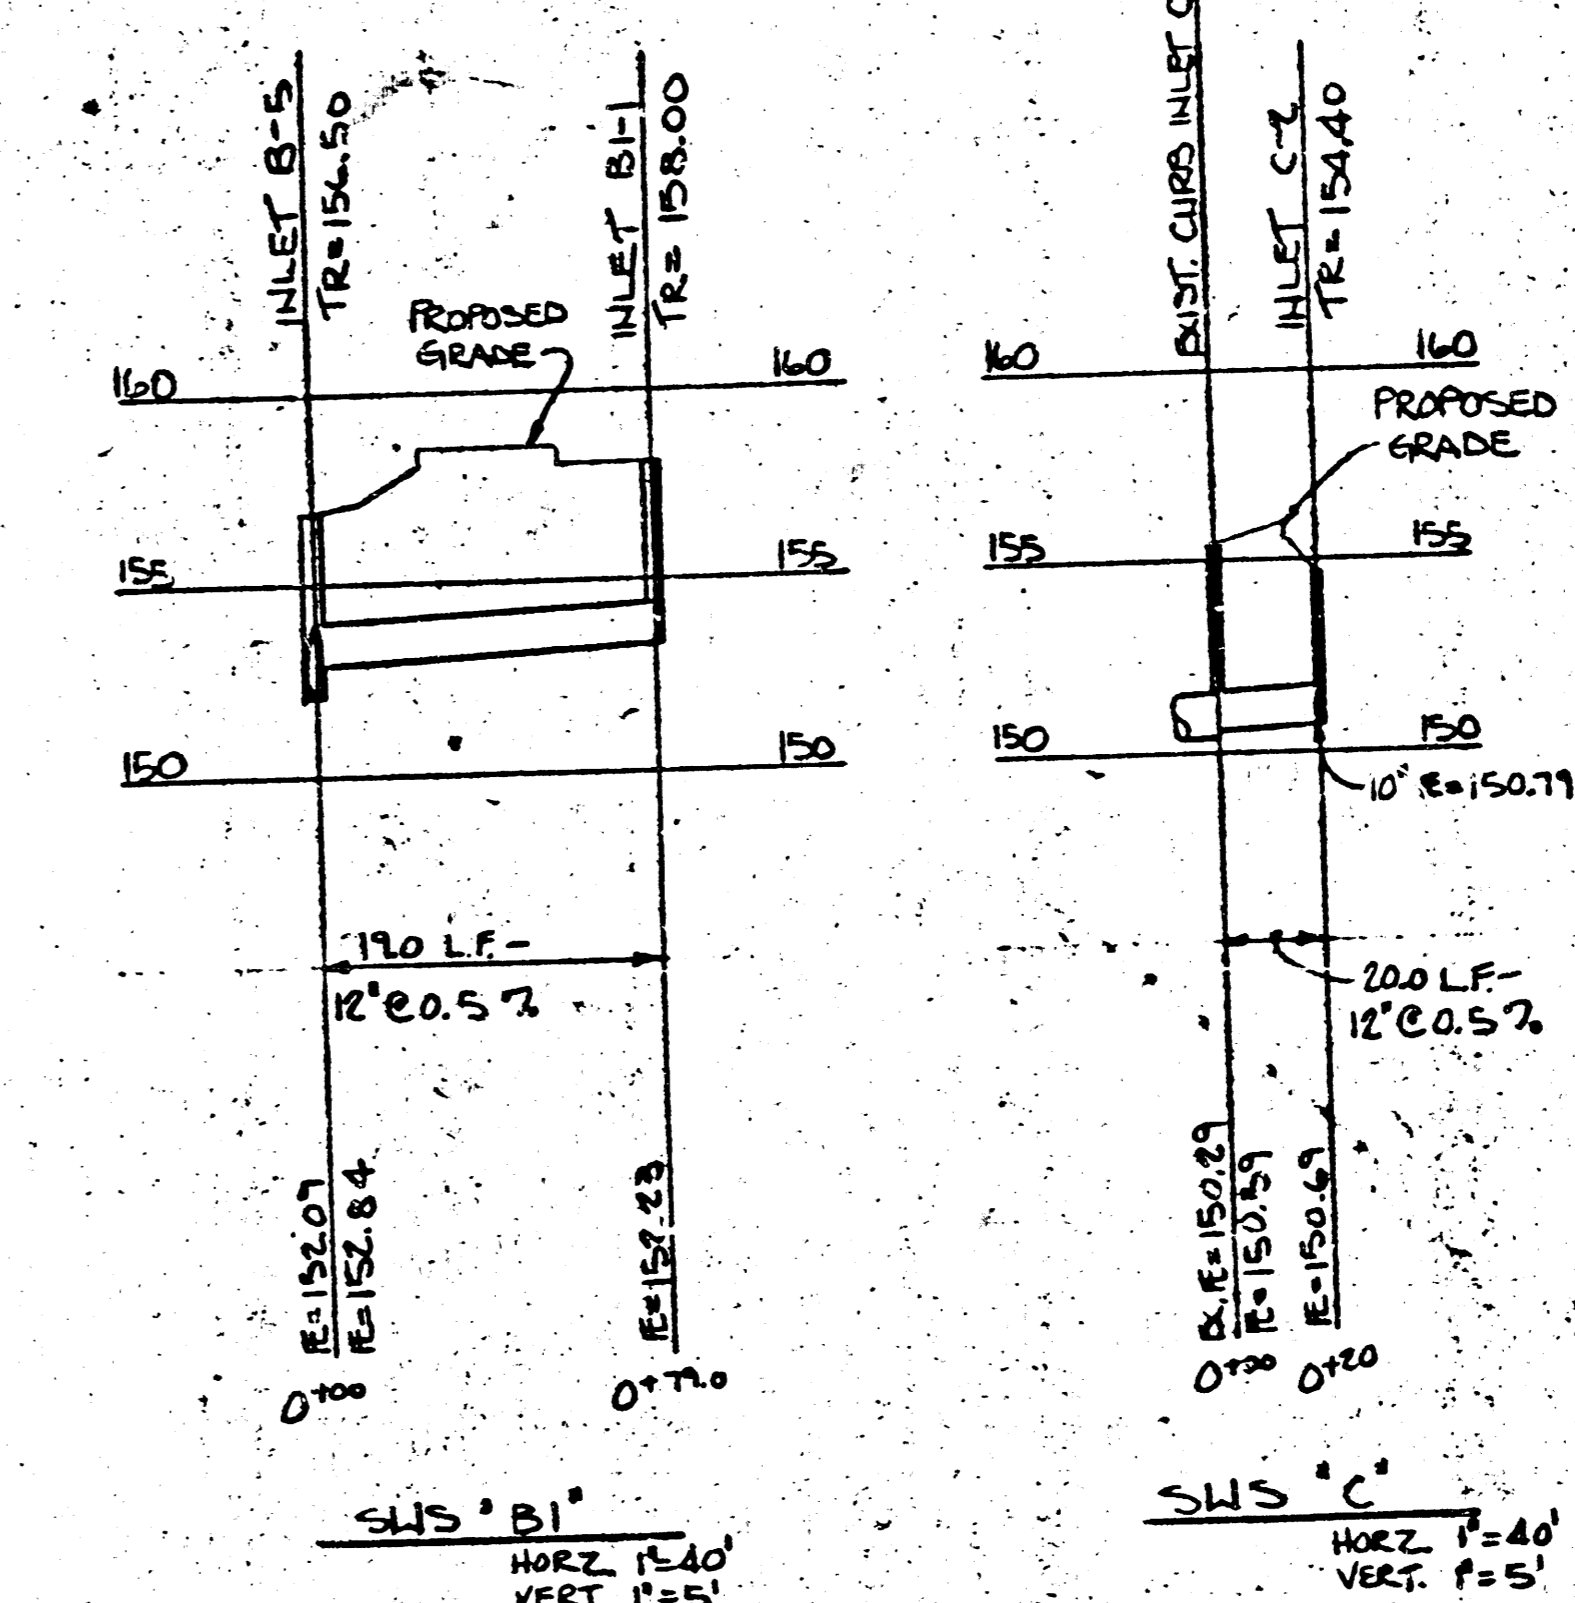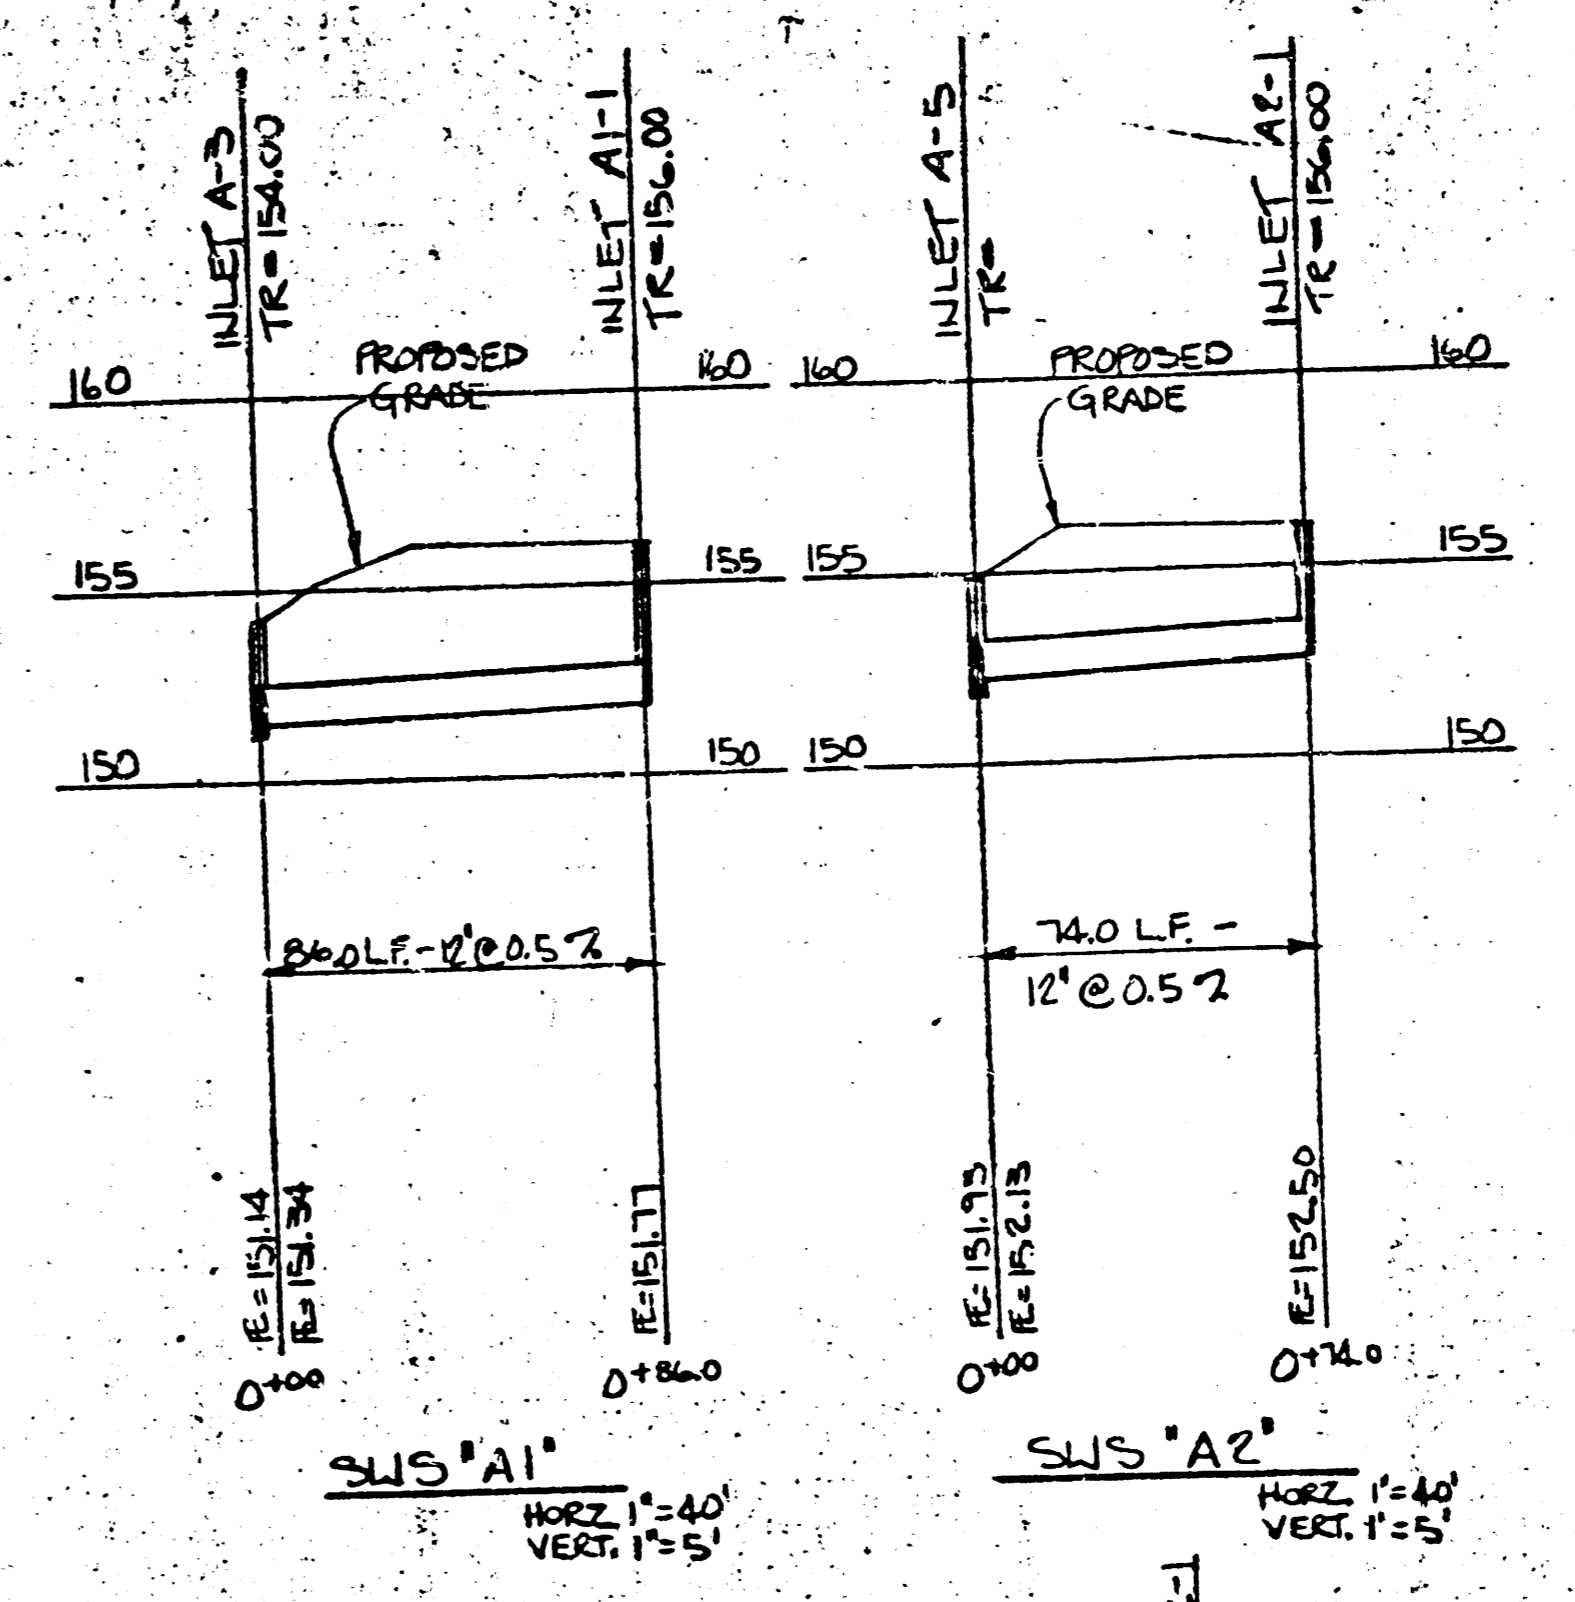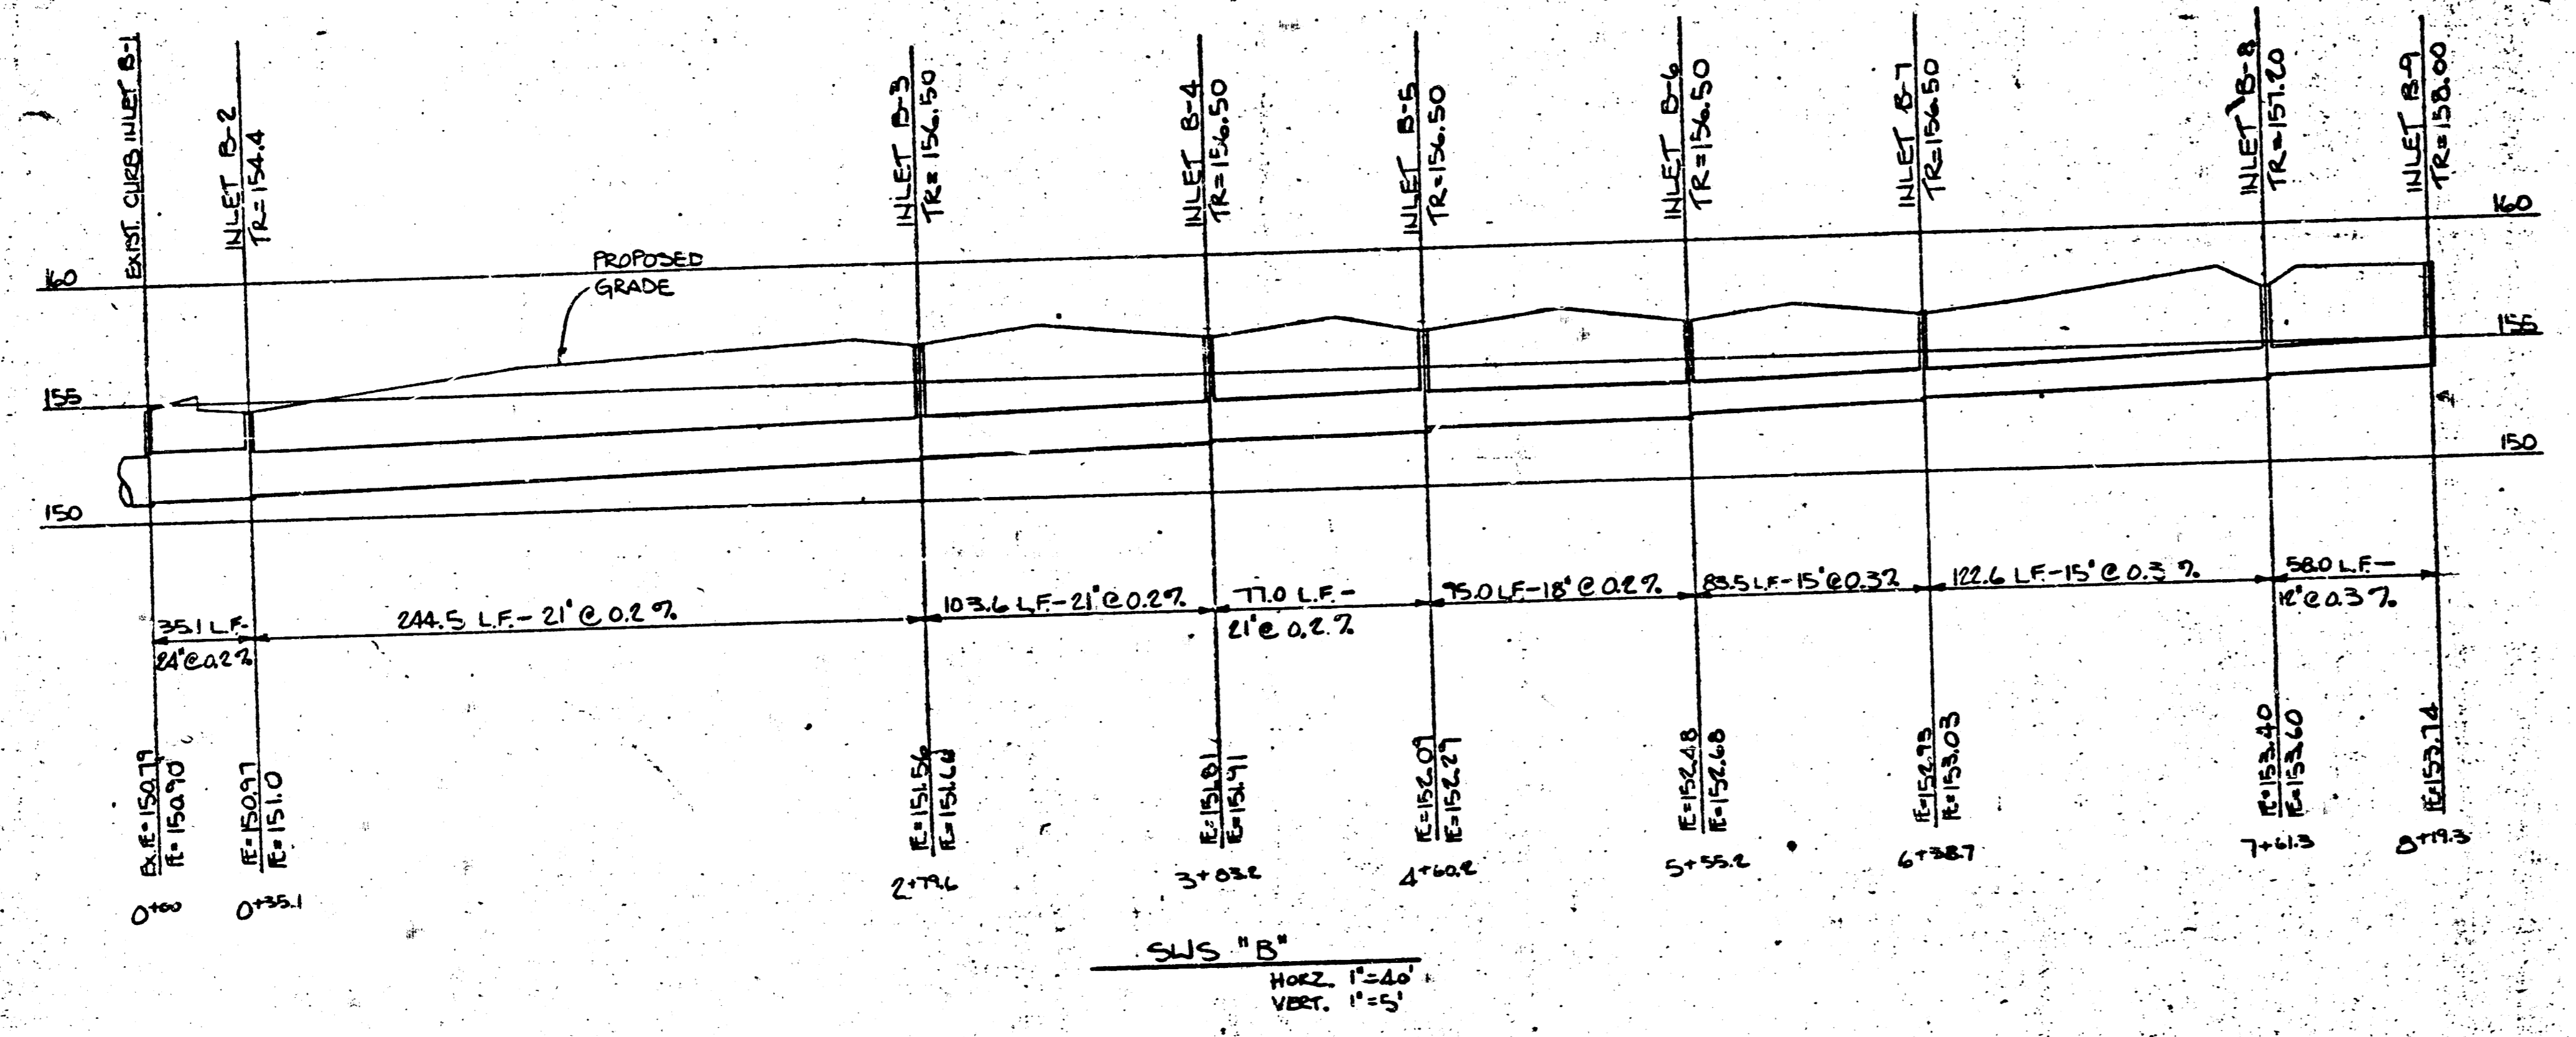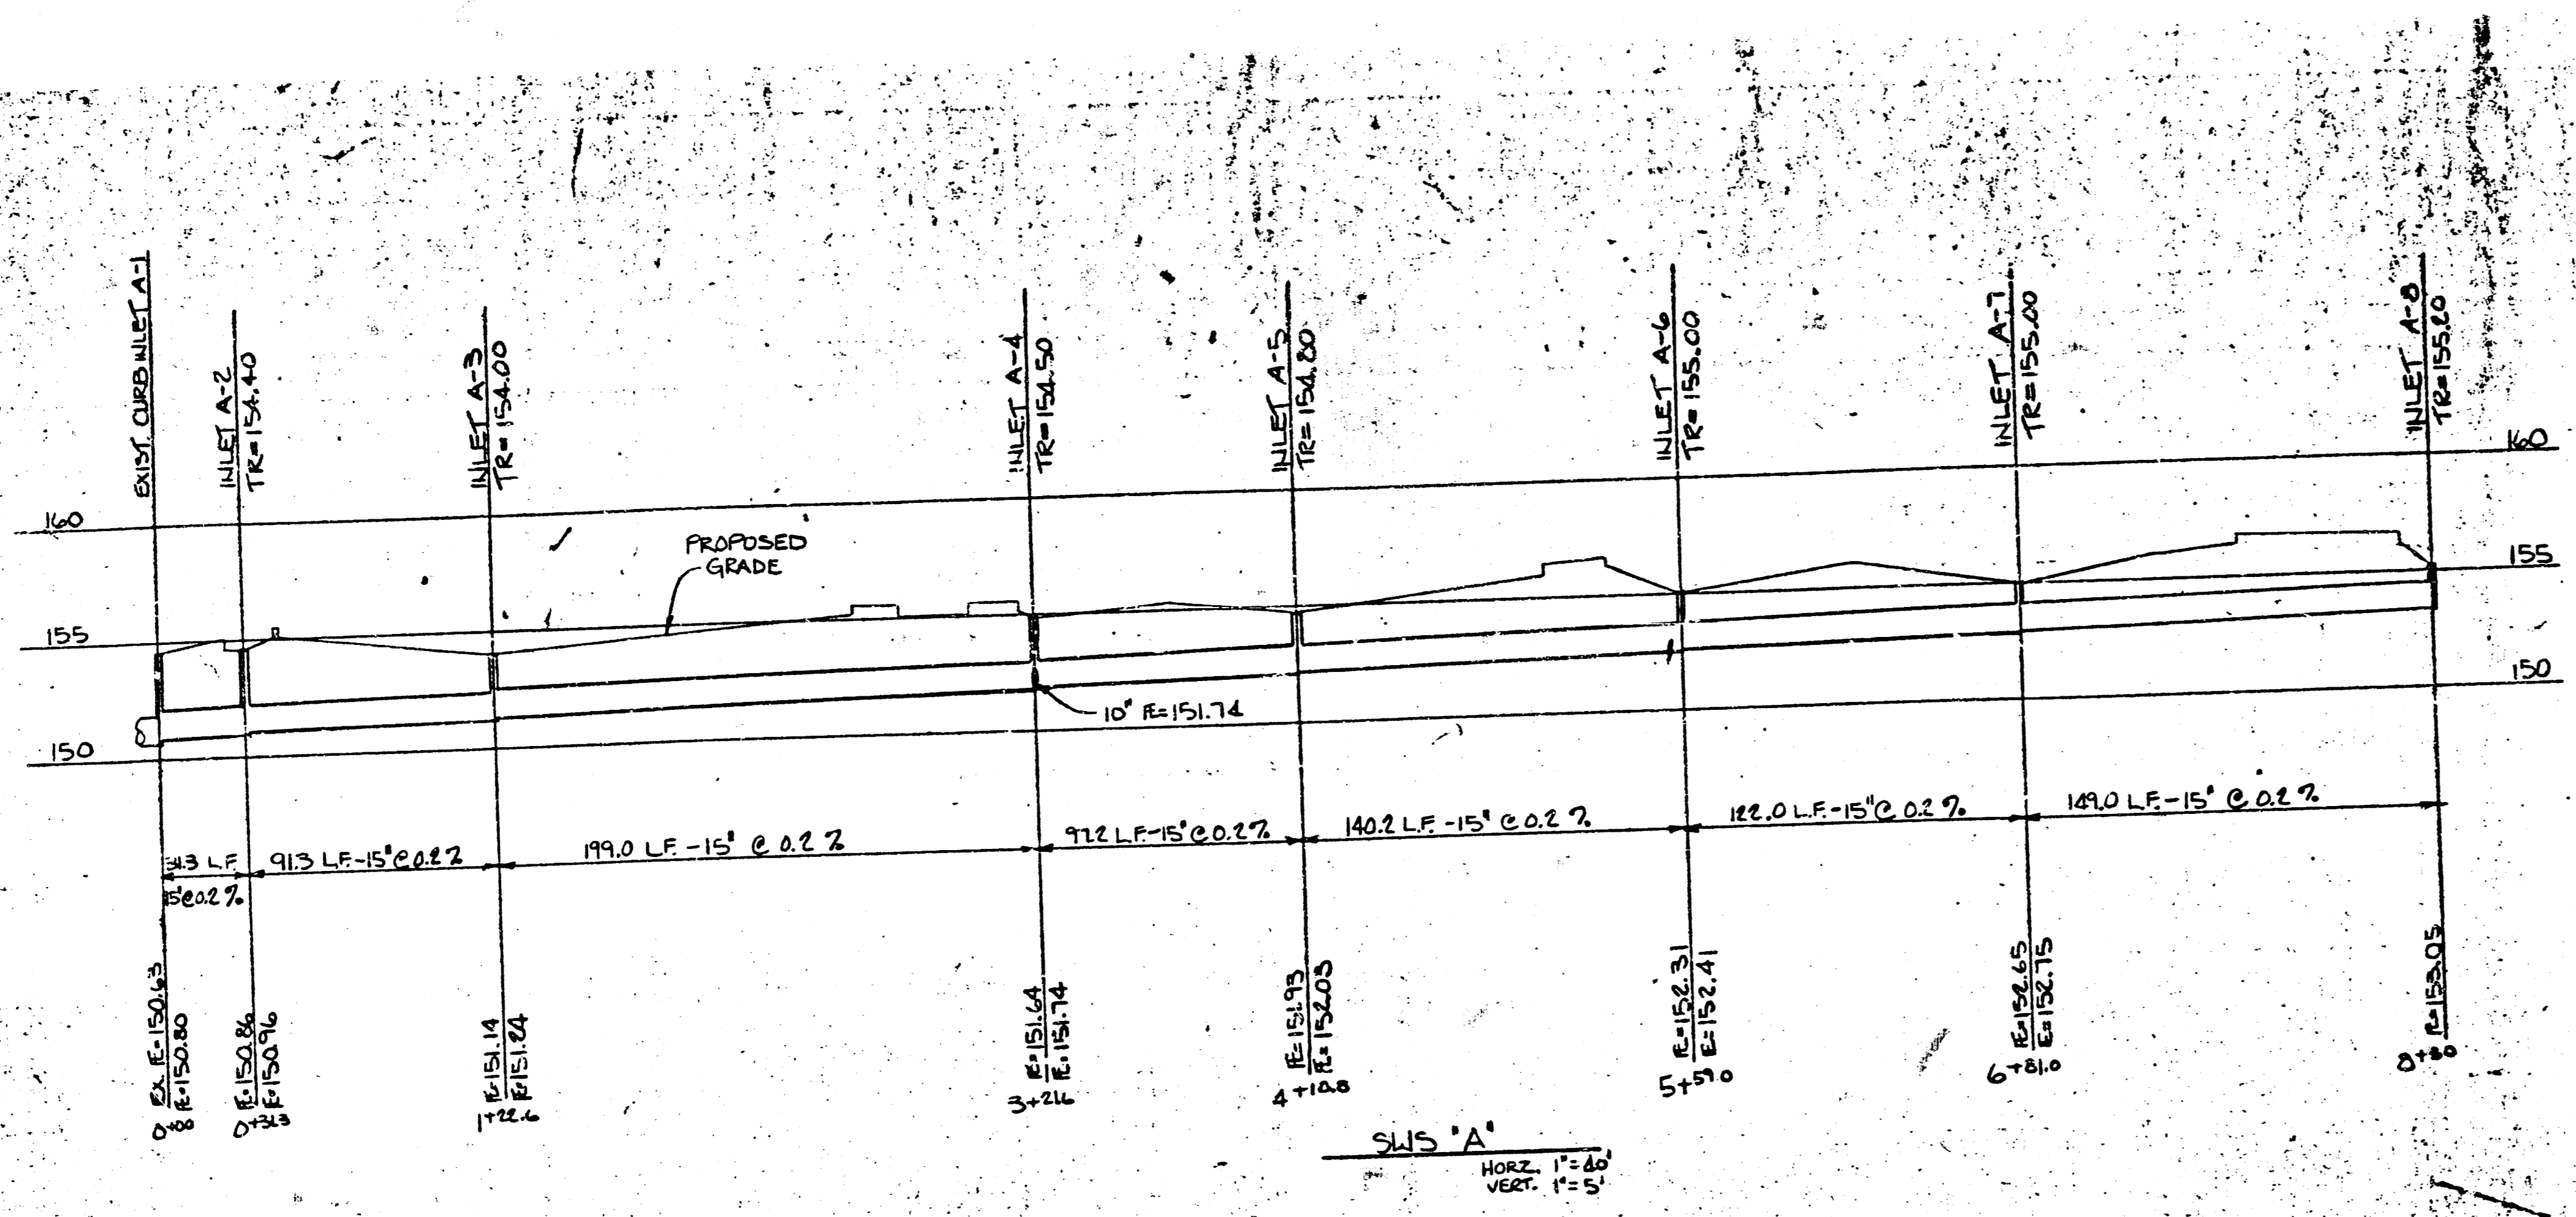

PRINTS ISSUED		
DATE	PURPOSE	NO.
11/1/84	FOR CONSTRUCTION	25
11/1/84	REV. FOR CONSTRUCTION	26

FOR CONSTRUCTION: 11/1/84

REVISIONS		
DATE	BY	NO.
11/1/84	REV. FOR CONSTRUCTION	1



LAW/KINGDOM, INC.
 ARCHITECTS & ENGINEERS
 240 WEST 10TH AVENUE, SUITE 200
 DENVER, COLORADO 80202
 Phone (303) 555-0222




NO.	DESCRIPTION

RELATED DRAWINGS



SEQUENCE NUMBER

OF SHEETS

Village Fashion Centre
 Armour Drive & Kellogg Drive
 Wichita, Kansas
 PROJECT NUMBER 3422

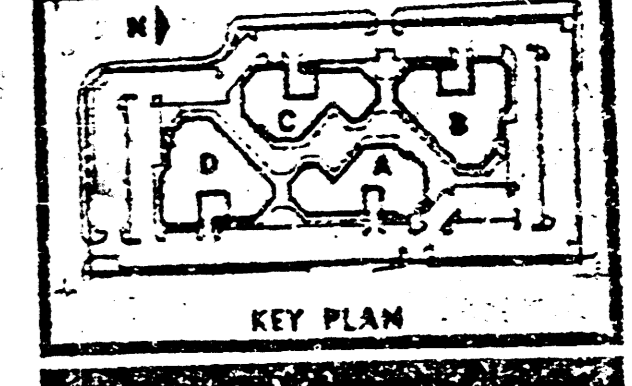

STORM WATER
 SEWER PROFILES
 SHEET TITLE

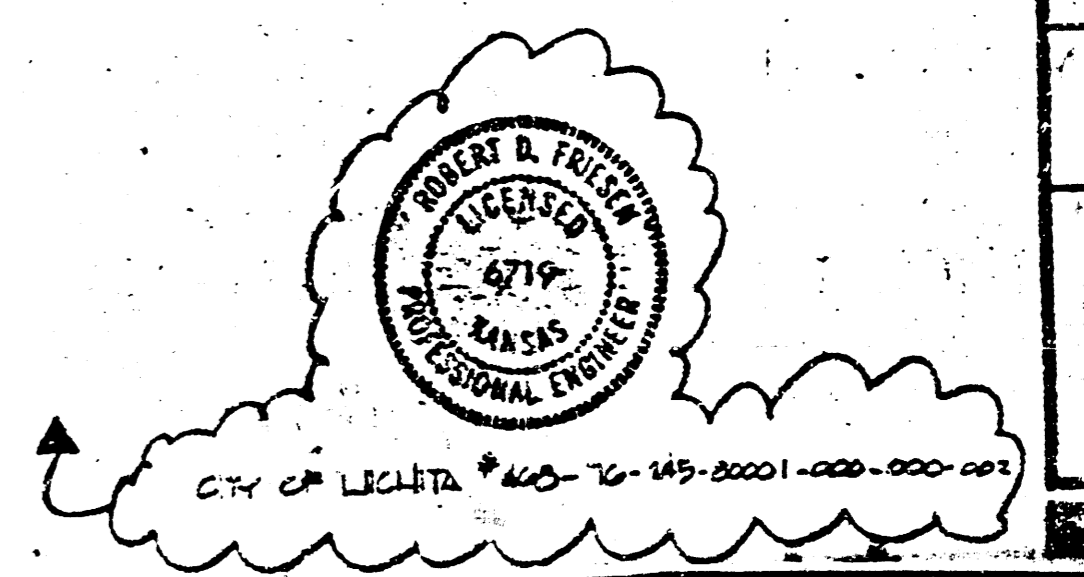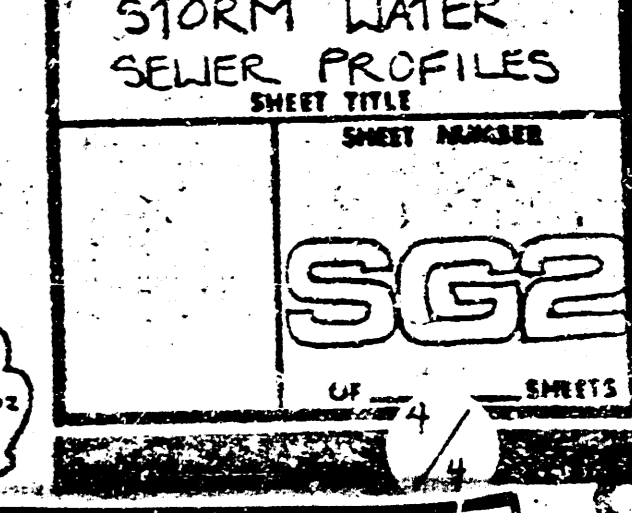

FILMED FROM THE BEST AVAILABLE COPY