



B SITE UTILITY PLAN 1" = 50'-0"

NOTE:
 1) STREET CROSSING PER OF WICHITA REQUIREMENTS.
 2) REFER TO MECHANICAL AND PLUMBING FLOOR PLANS SHEET
 10-1 FOR EXACT LOCATIONS OF UTILITY LINES AT THE BLDG.

APPROVED AS NOTED
 BY CITY ENGINEER OF WICHITA
 7-19-77
 [Signature]

NOTE TO CONTRACTOR
 THIS PROJECT WILL BE CONSTRUCTED UNDER
 THE SUPERVISION OF THE CITY ENGINEER
 AND CONFORMING TO THE SPECIFICATIONS
 OF THE CITY OF WICHITA. THE CON-
 TRACTOR WILL REIMBURSE THE CITY OF
 WICHITA FOR ALL COST OF INSPECTION.

A SITE GRADING PLAN 1" = 20'-0" Sanitary Sewer for Boston Park 468-76-245-80805-000-000-008

PRINTS ISSUED		
DATE	PURPOSE	NO.
		1

FOR CONSTRUCTION		
DATE	ITEM	NO.
		1

L&K

LAW KINGDON, P.A.
 110 N. MARKET WICHITA, KANSAS 67202
 PHONE (316) 261-1111
 TELEX 150000 L&K

Copyright © 1978 Law/Kingdon, P.A.

DRAWN	CHECKED

RELATED DRAWINGS	
SHELL	
DETAILS	
STRUCTURE	
MECHANICAL	
ELECTRICAL	
OTHER	

SEQUENCE NUMBER	OF SHEETS


**Boston Park
 Swimming Pool
 & Bathhouse
 Wichita, Kansas**

PROJECT NUMBER 7810



KEY PLAN

TENANT
**SITE UTILITY AND
 GRADING**
 SHEET TITLE
 TENANT NUMBER SHEET NUMBER
SG-1
 OF 2 SHEETS



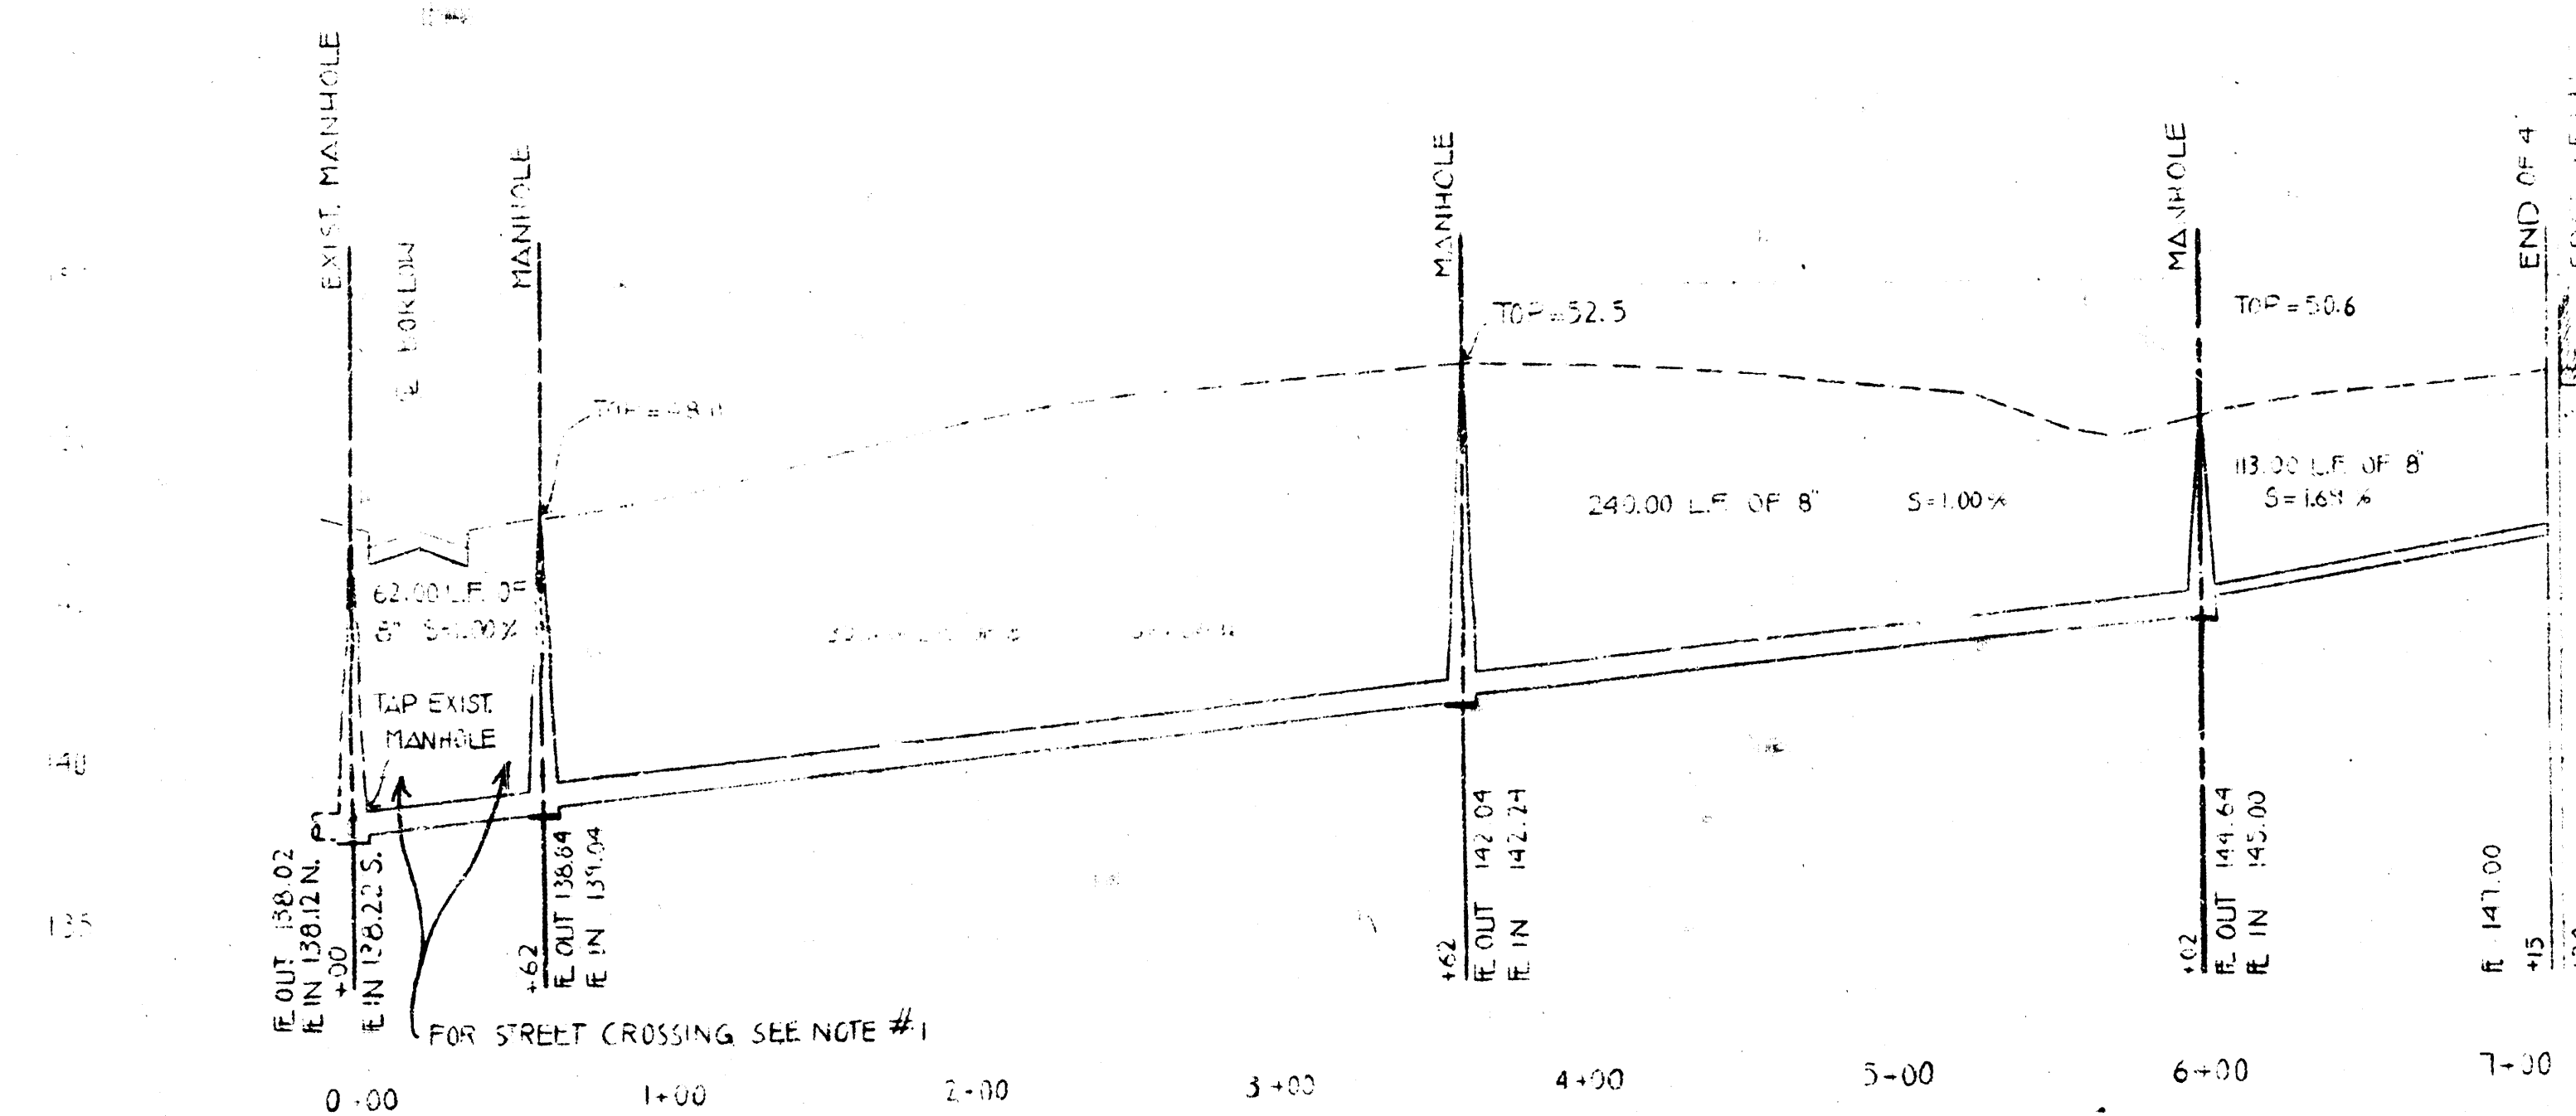


SANITARY SEWER PROFILE

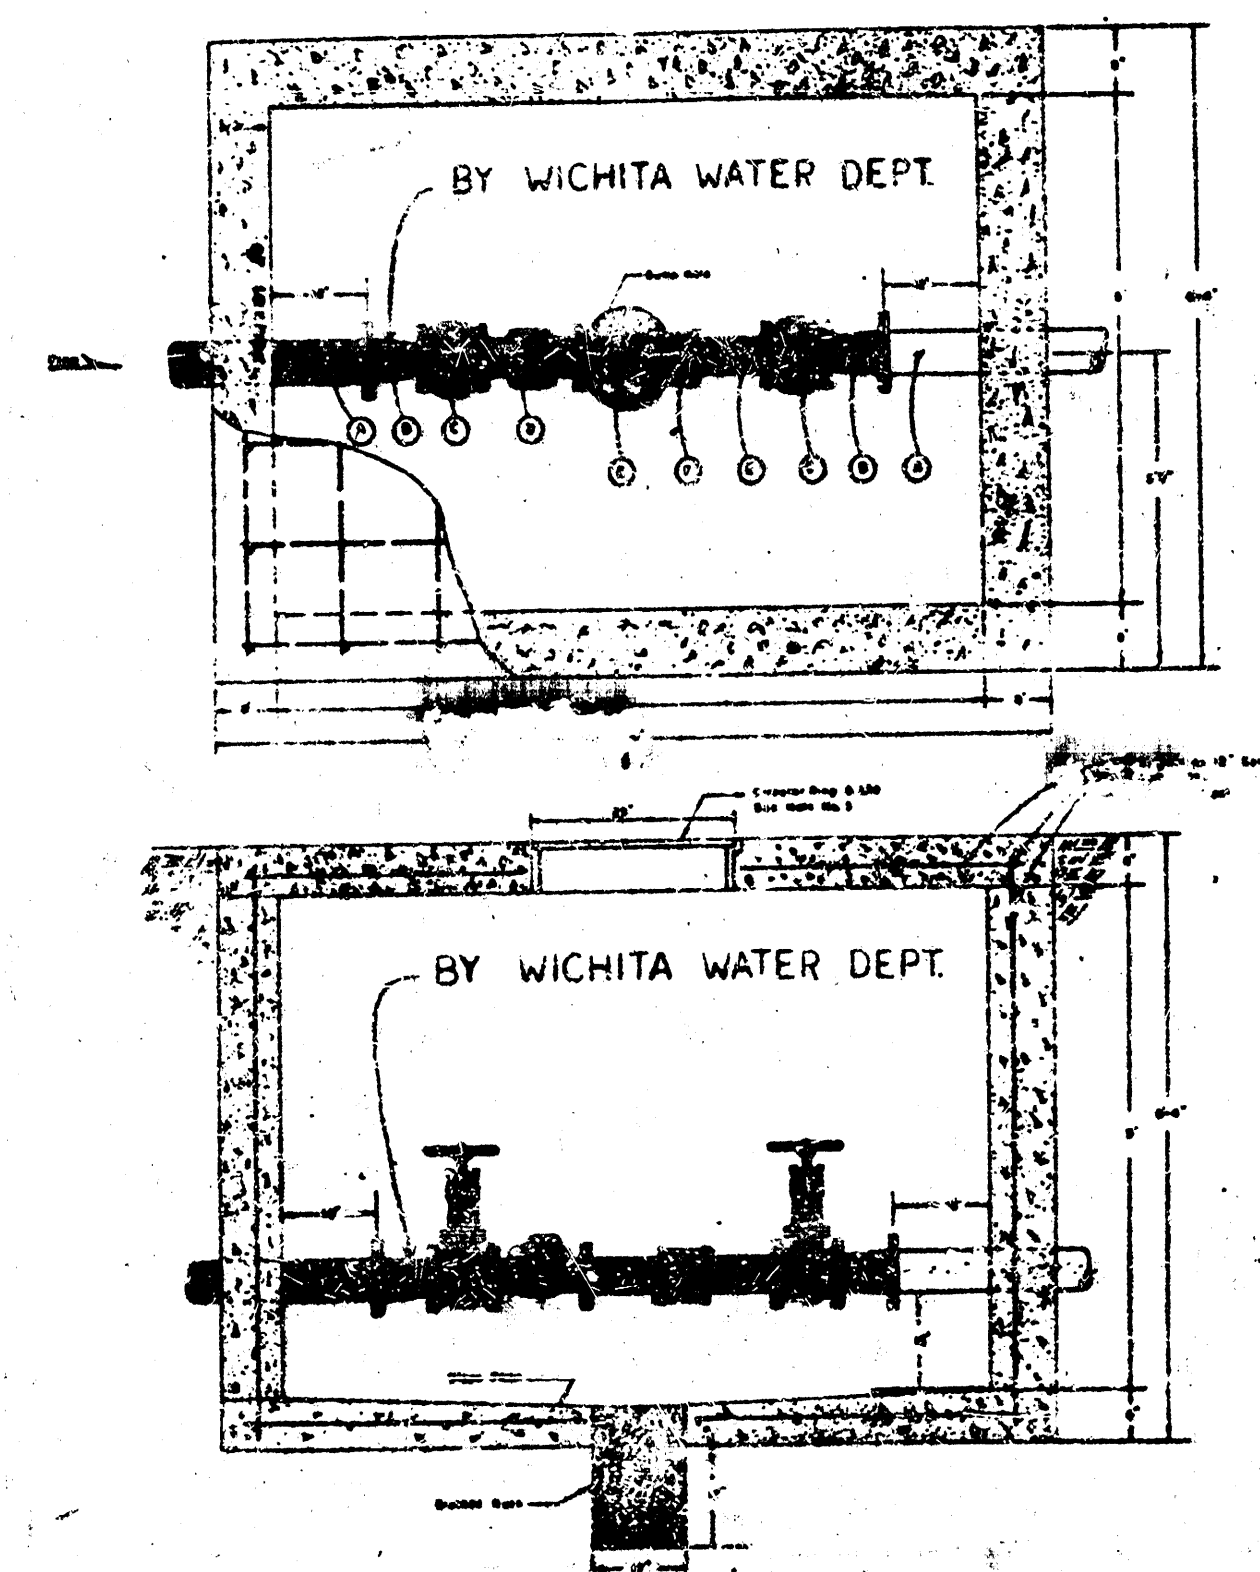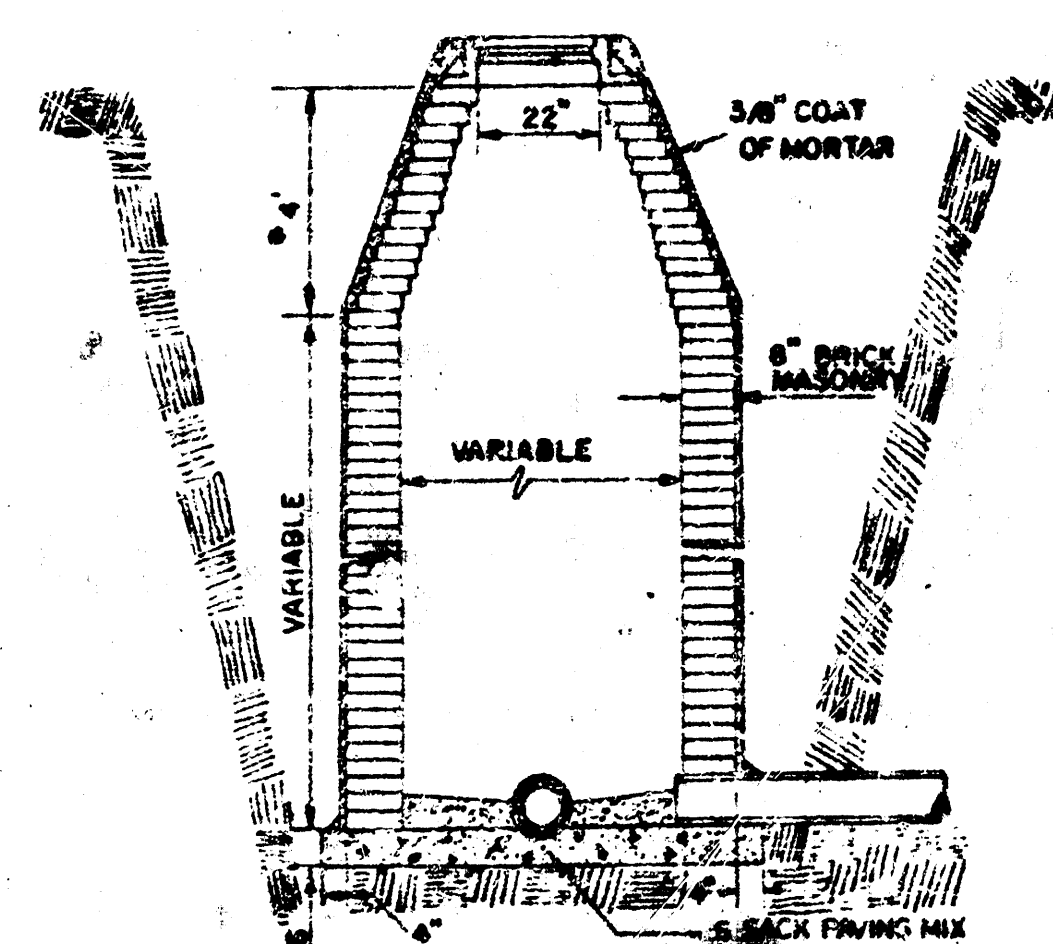

- [illegible]


NOTES:

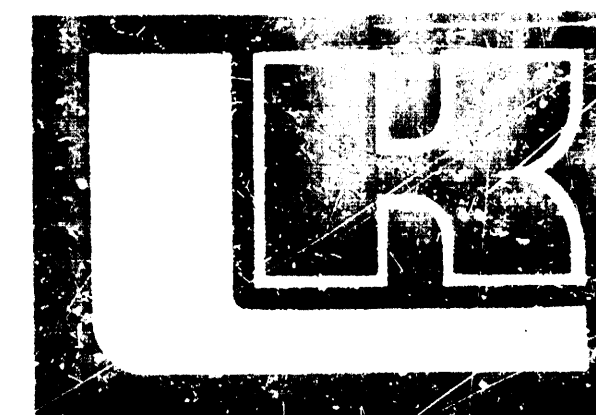[illegible][illegible]

Copyright © 1978 Law, Kingdon, P.

DRAWN		CHECKED	
B-D			
RELATED DRAWINGS			
SEE			
DESIGN			
STRUCTURE			
Mechanical			
ELECTRICAL			
OTHER			
SEQUENCE NUMBER			
OF		SHEET	

**Boston Park
Swimming Pool
& Bathhouse
Wichita, Kansas**

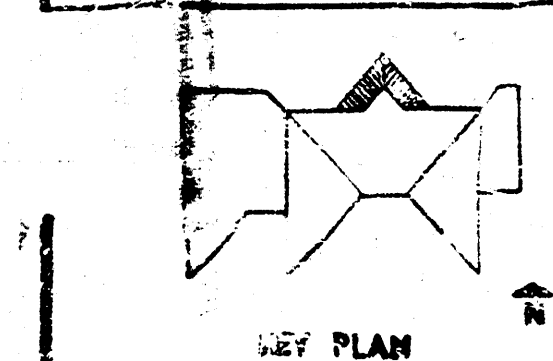

TENANT	
SANITARY SEWER PROFILES AND DETAILS	
SHEET TITLE	
TENANT NUMBER	SHEET NUMBER
	61
	C 1 SHEET