
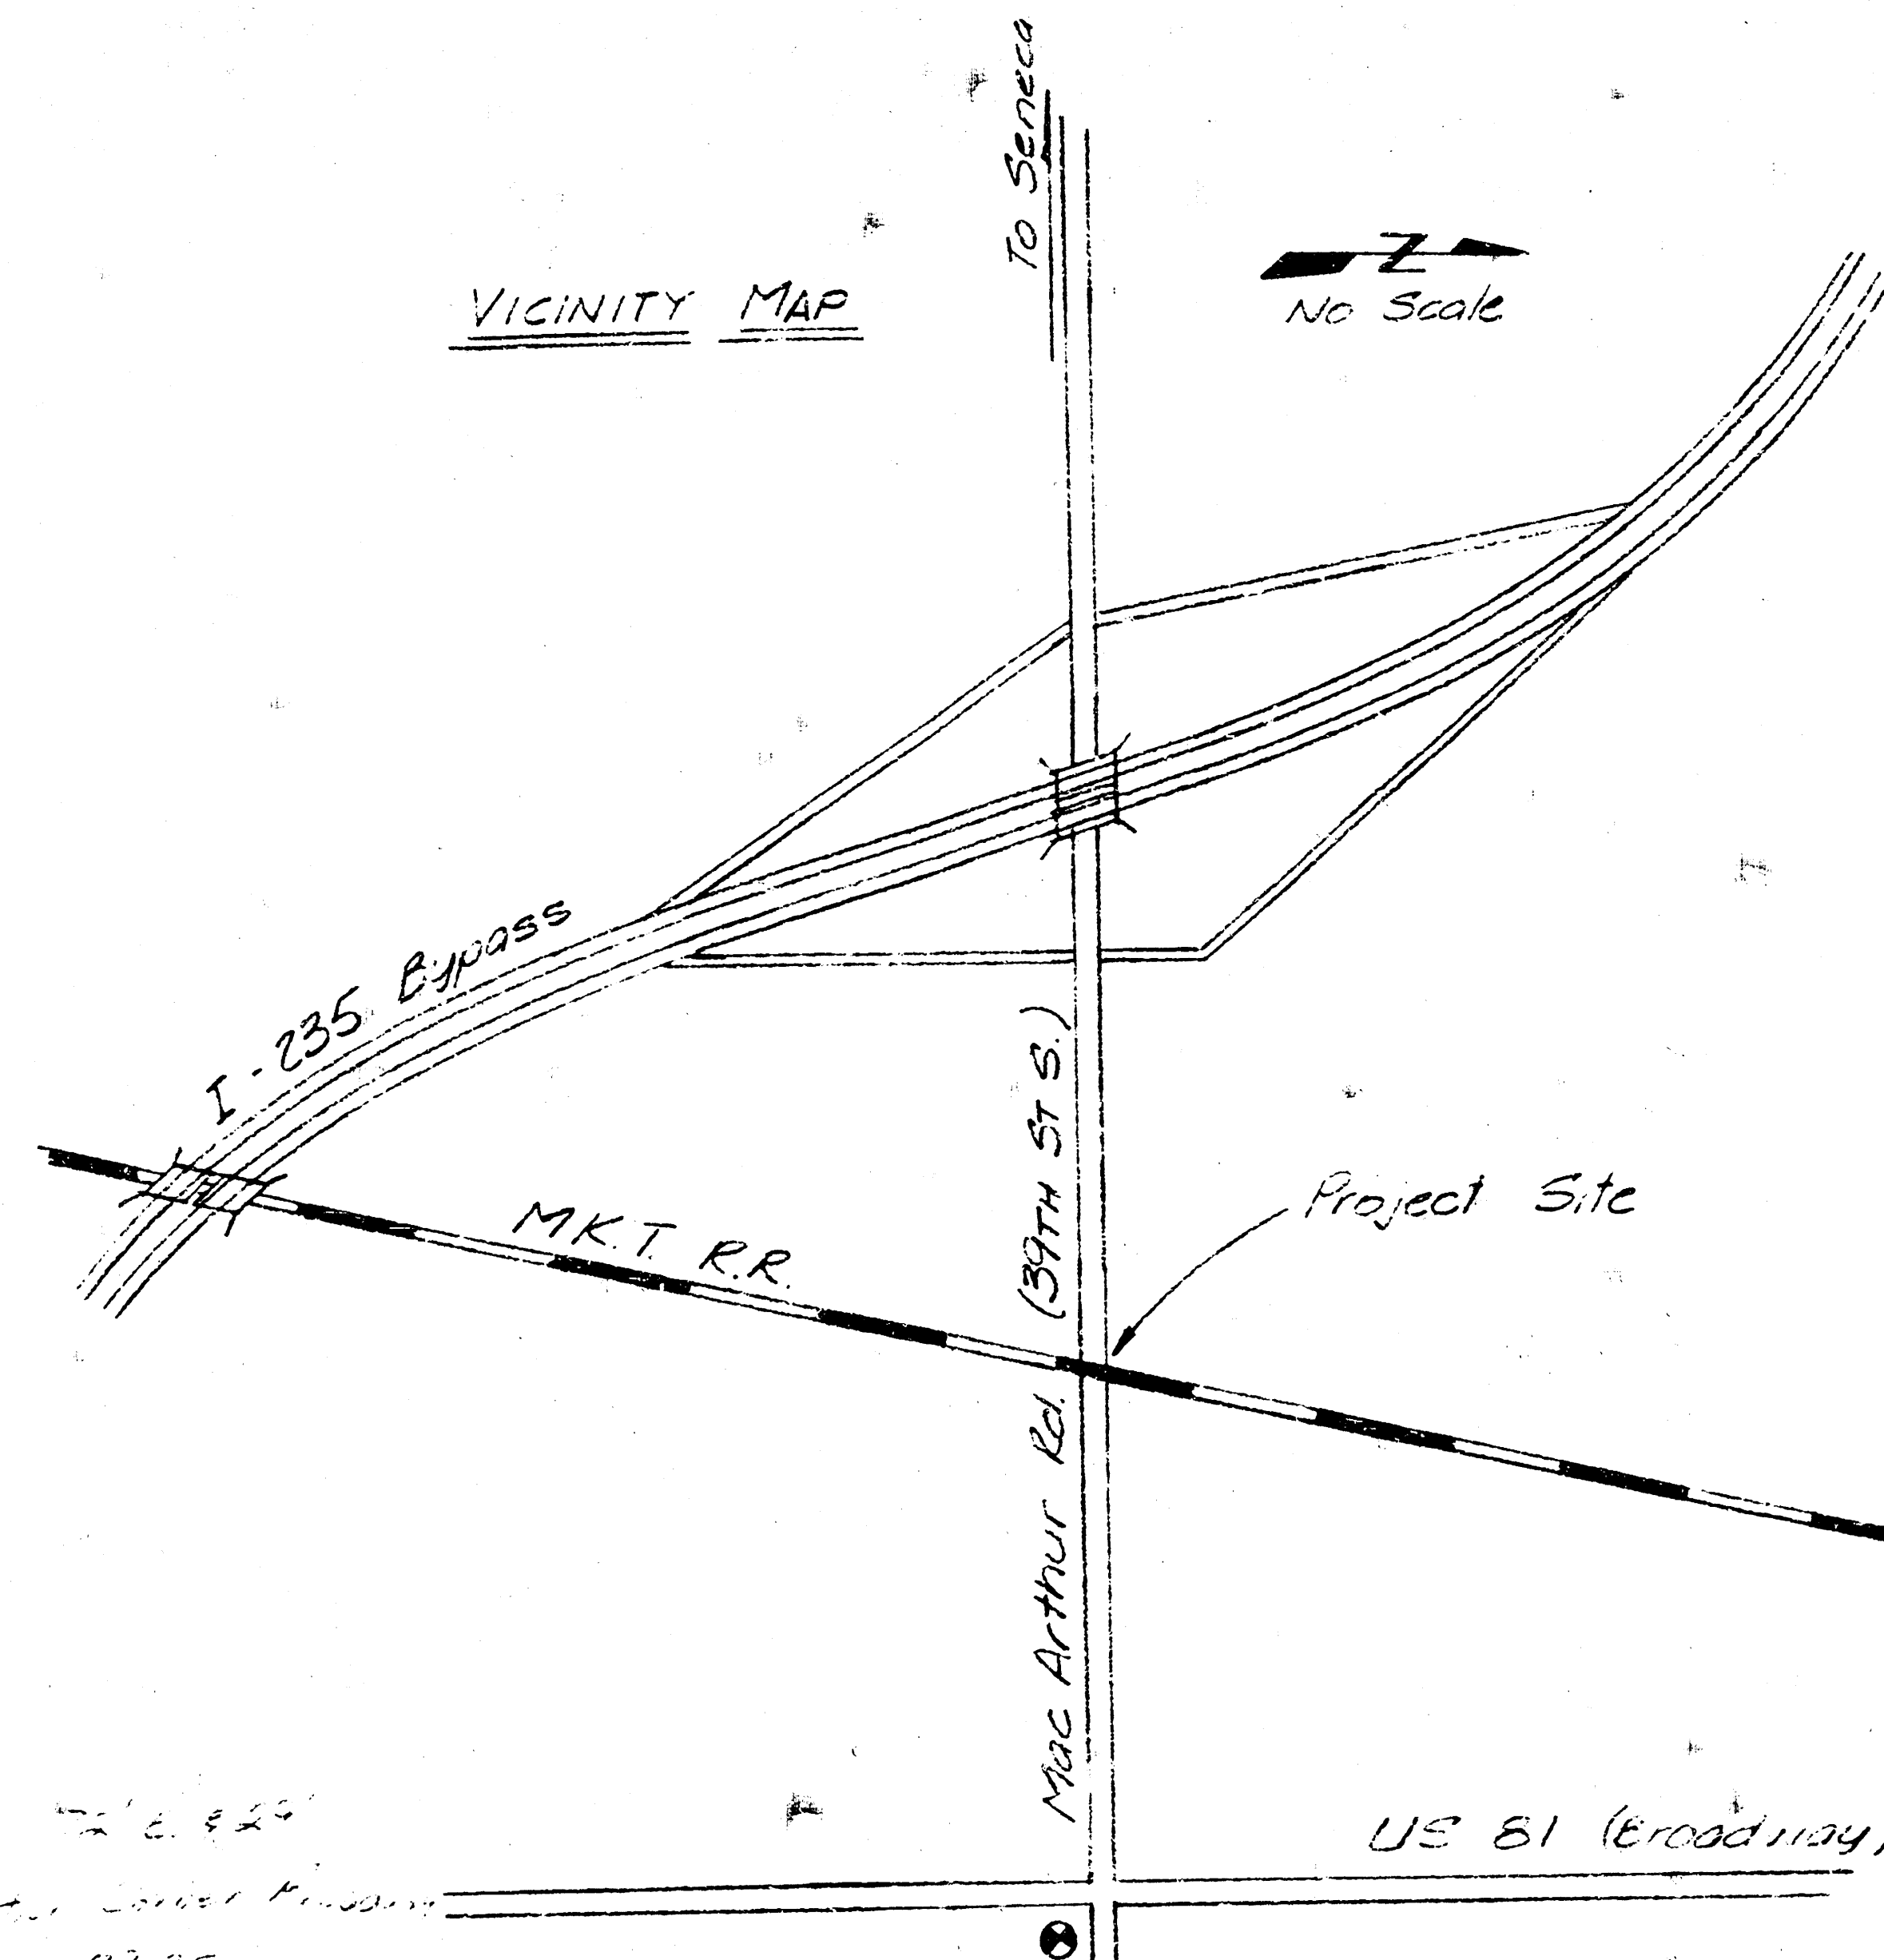


PLAN
 SURVEYED
 BY
 DATE
 NOTE BOOK
 ALIGNED CHAINED
 BY OF WAY (FEET)
 NO.

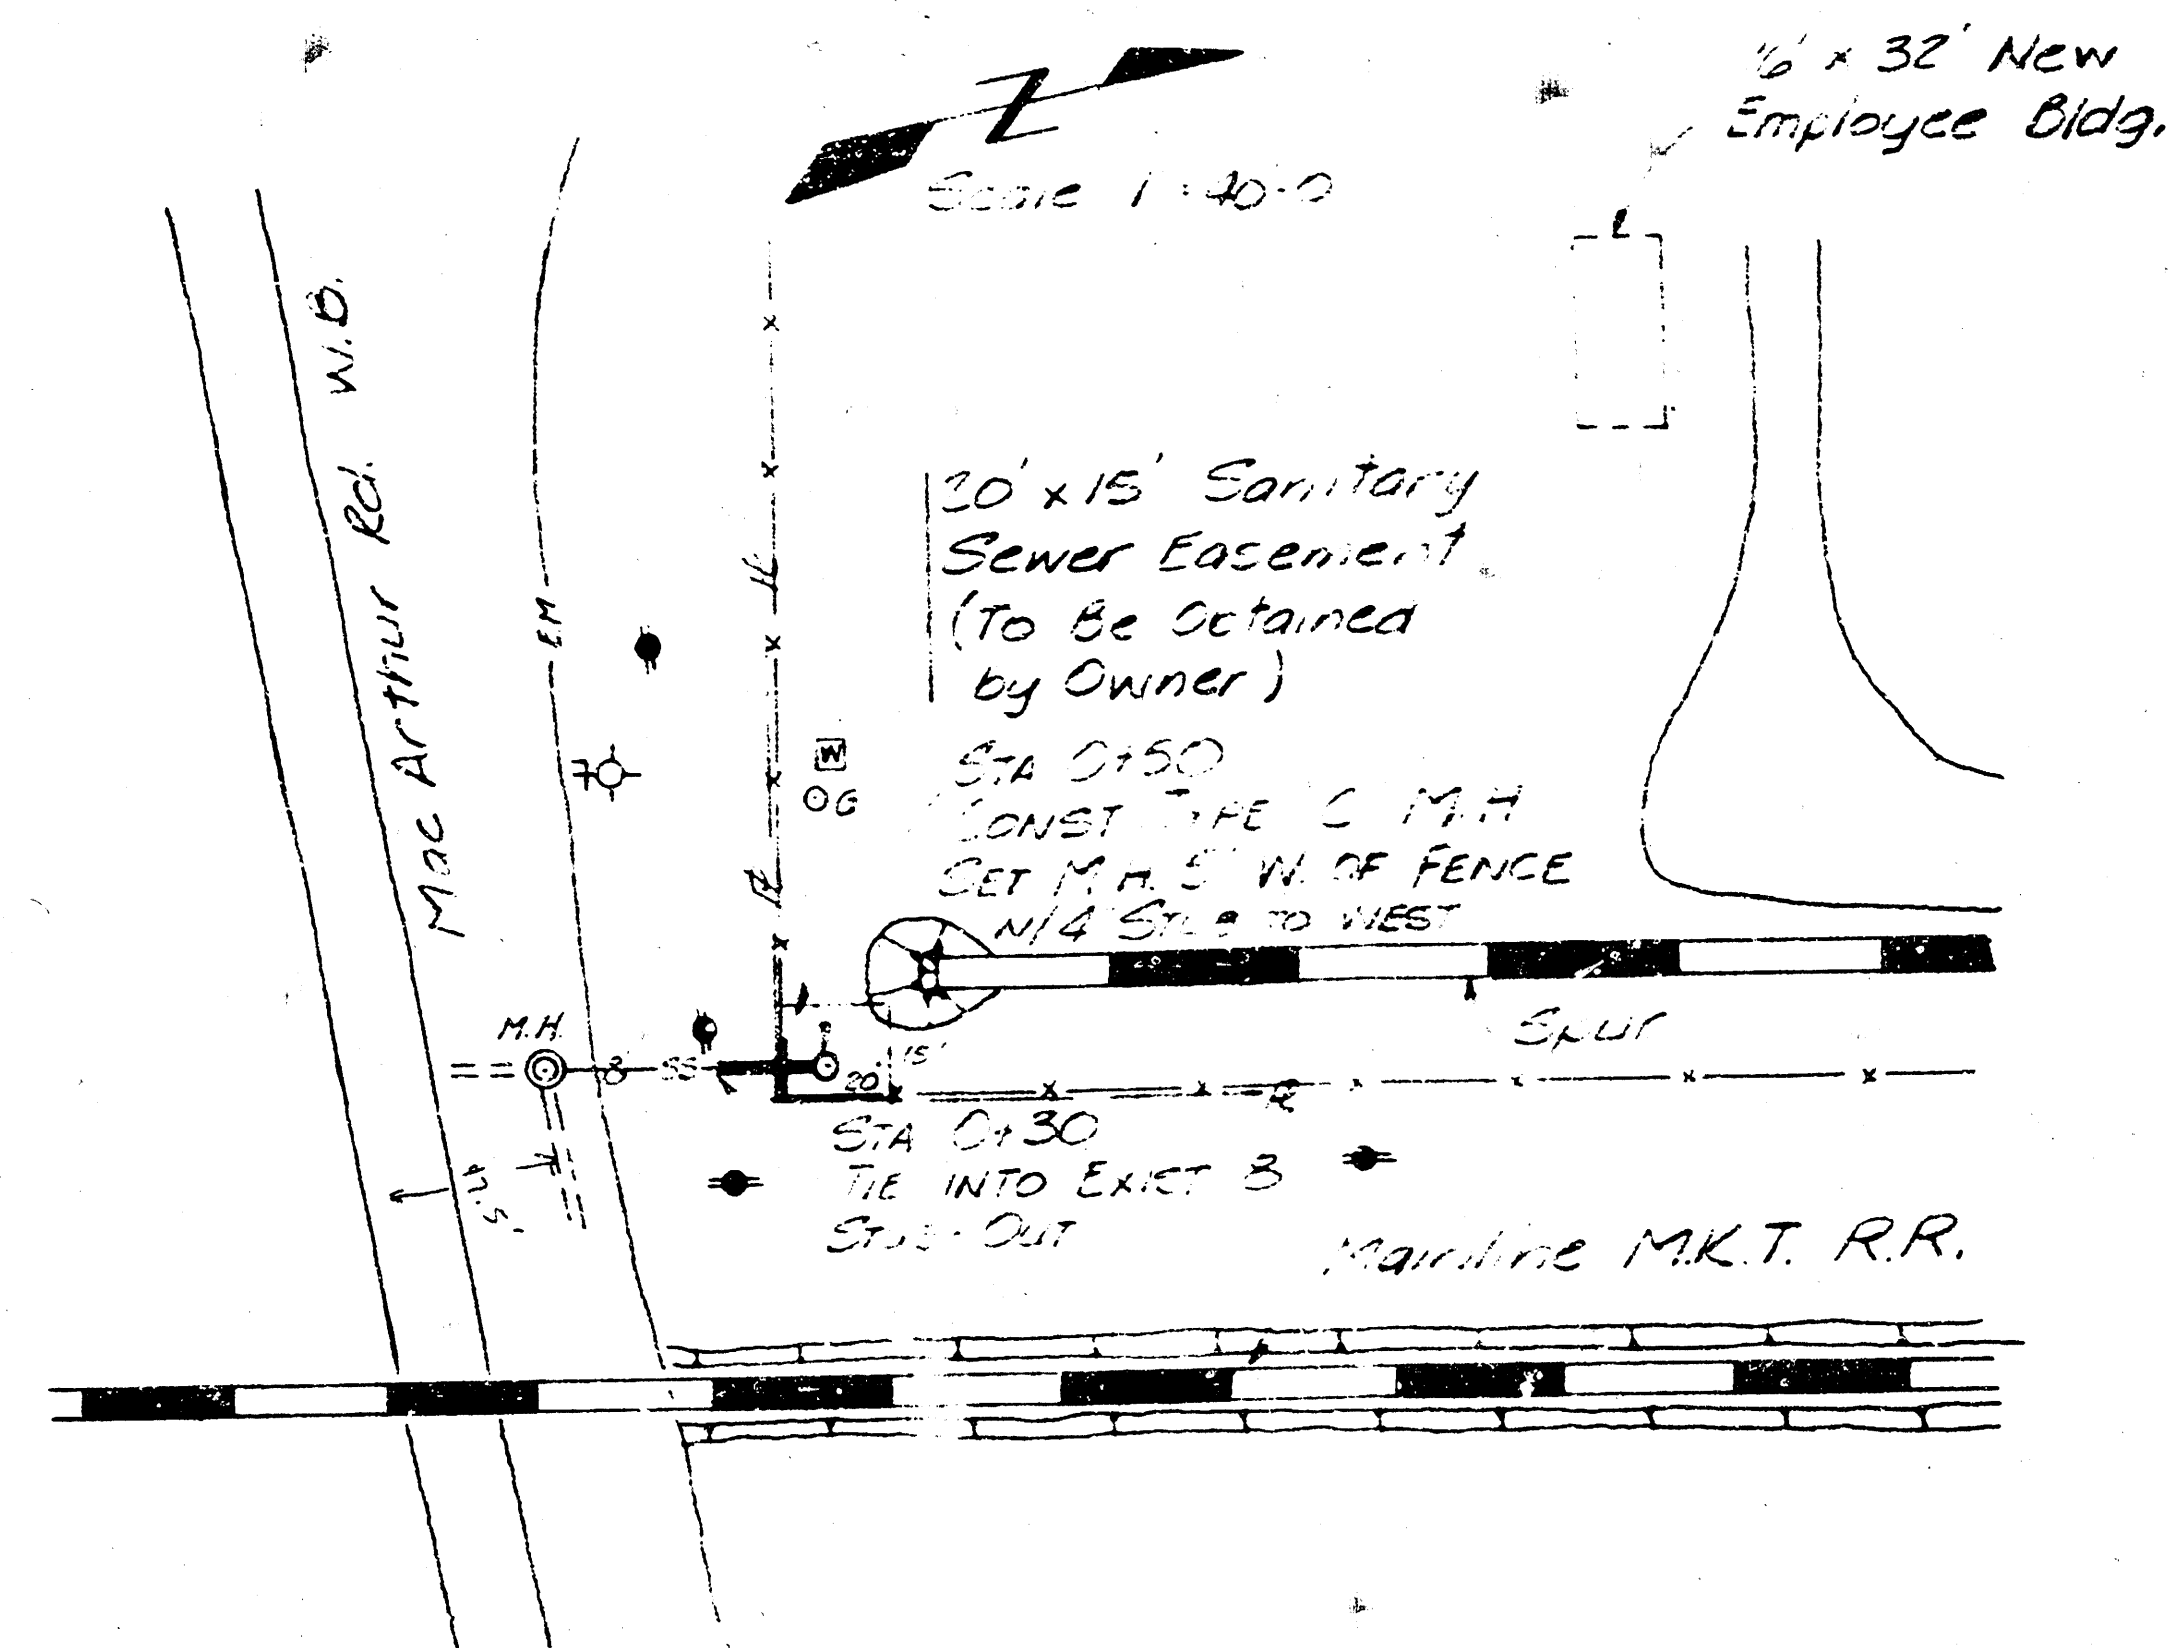


T.B.M. 92.62 Bolt between
 E & L" top flange fire
 hydrant 37' W of exist.
 M.H. & N. side MacArthur

T.B.M. 90.96 1/2" Edge M.H. Rim N. Side
 MacArthur Road and W.
 of Mainline M.K.T. R.R.
 (Assumed)

B.M.
 City 4th St. E. & 2nd
 87.22 (Assumed)
 87.65

PROFILE
 SURVEYED
 BY
 DATE
 NOTE BOOK
 ALIGNED CHAINED
 BY OF WAY (FEET)
 NO.

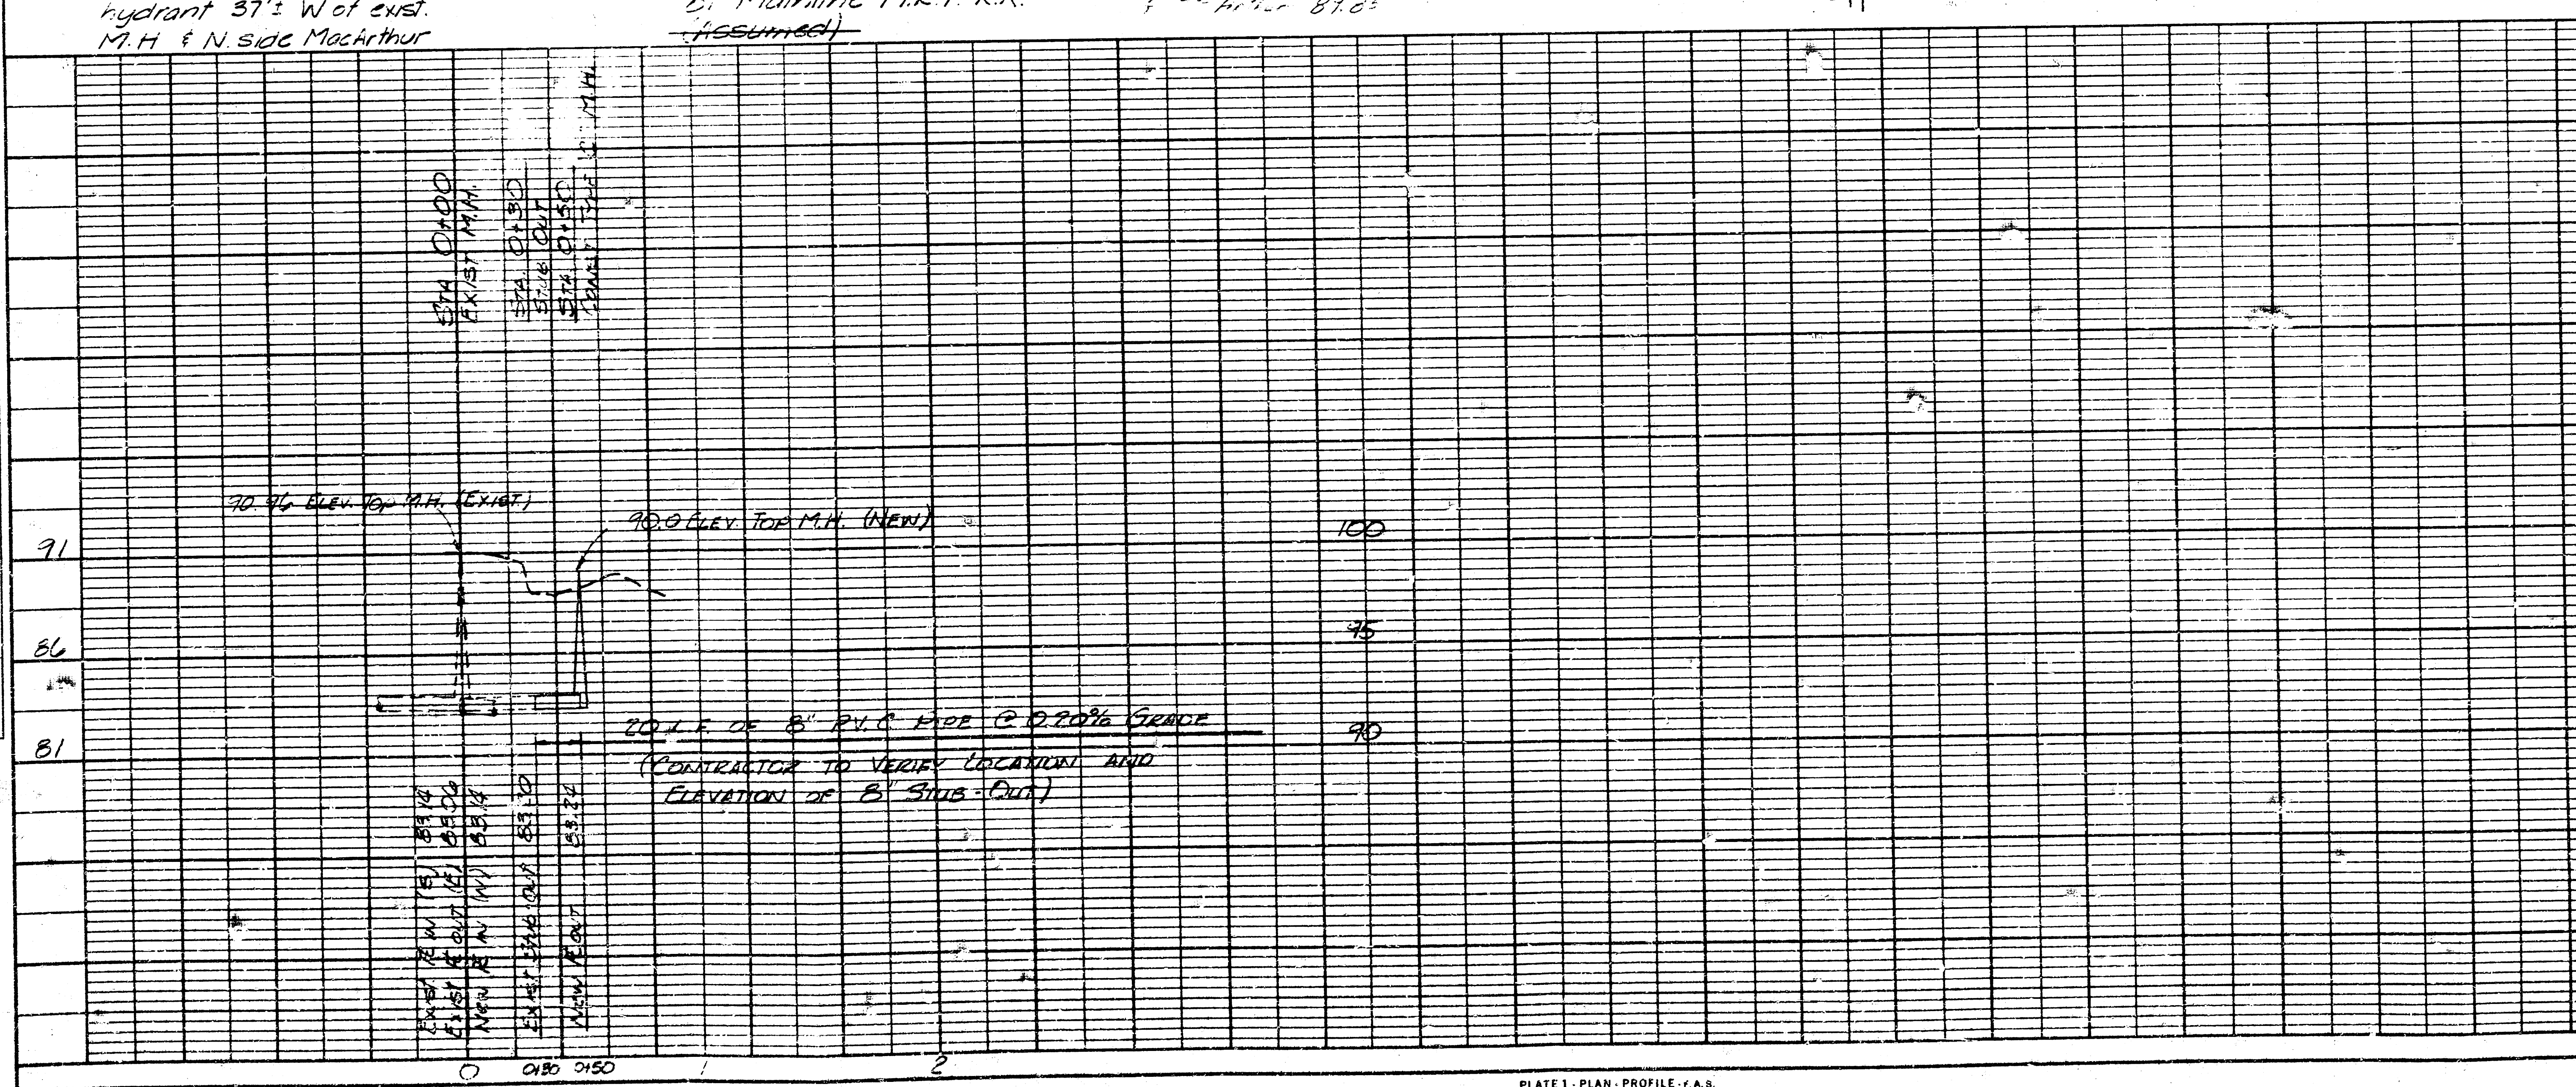

APPROVED AS NOTED
 BY CITY ENGINEER OF WICHITA
 Sanitary Sewer
 Storm Sewer
 Sewerage Approaches

NOTA TO CONTRACTOR
 THIS PROJECT IS TO BE
 CONSTRUCTED IN ACCORDANCE
 WITH THE CITY OF WICHITA
 STANDARD SPECIFICATIONS
 FOR HIGHWAY CONSTRUCTION
 1984 EDITION
 FOR ALL DETAILS OF CONSTRUCTION

REVISED 10/1/80 NOTED BY San. Sewer Dept.
 REVISED 10/1/80 NOTED BY City of Wichita Road Dept. (W.D.)

WICHITA, KANSAS
 SANITARY SEWER EXTENSIONS
 PLAN AND PROFILE
 DALLAS WEST ROBBINS PLANT
 PROJ. NO. 465 WORKS 88-00-000-000-000
 CAMPBELL & CASTLE
 ENGINEERS
 WICHITA, KANSAS
 DATE: SEPTEMBER 1984
 SHEET NO. 1 OF 1