




ADMINISTRATION PLUMBING FLOOR PLAN
SCALE 1/4" = 1'-0"

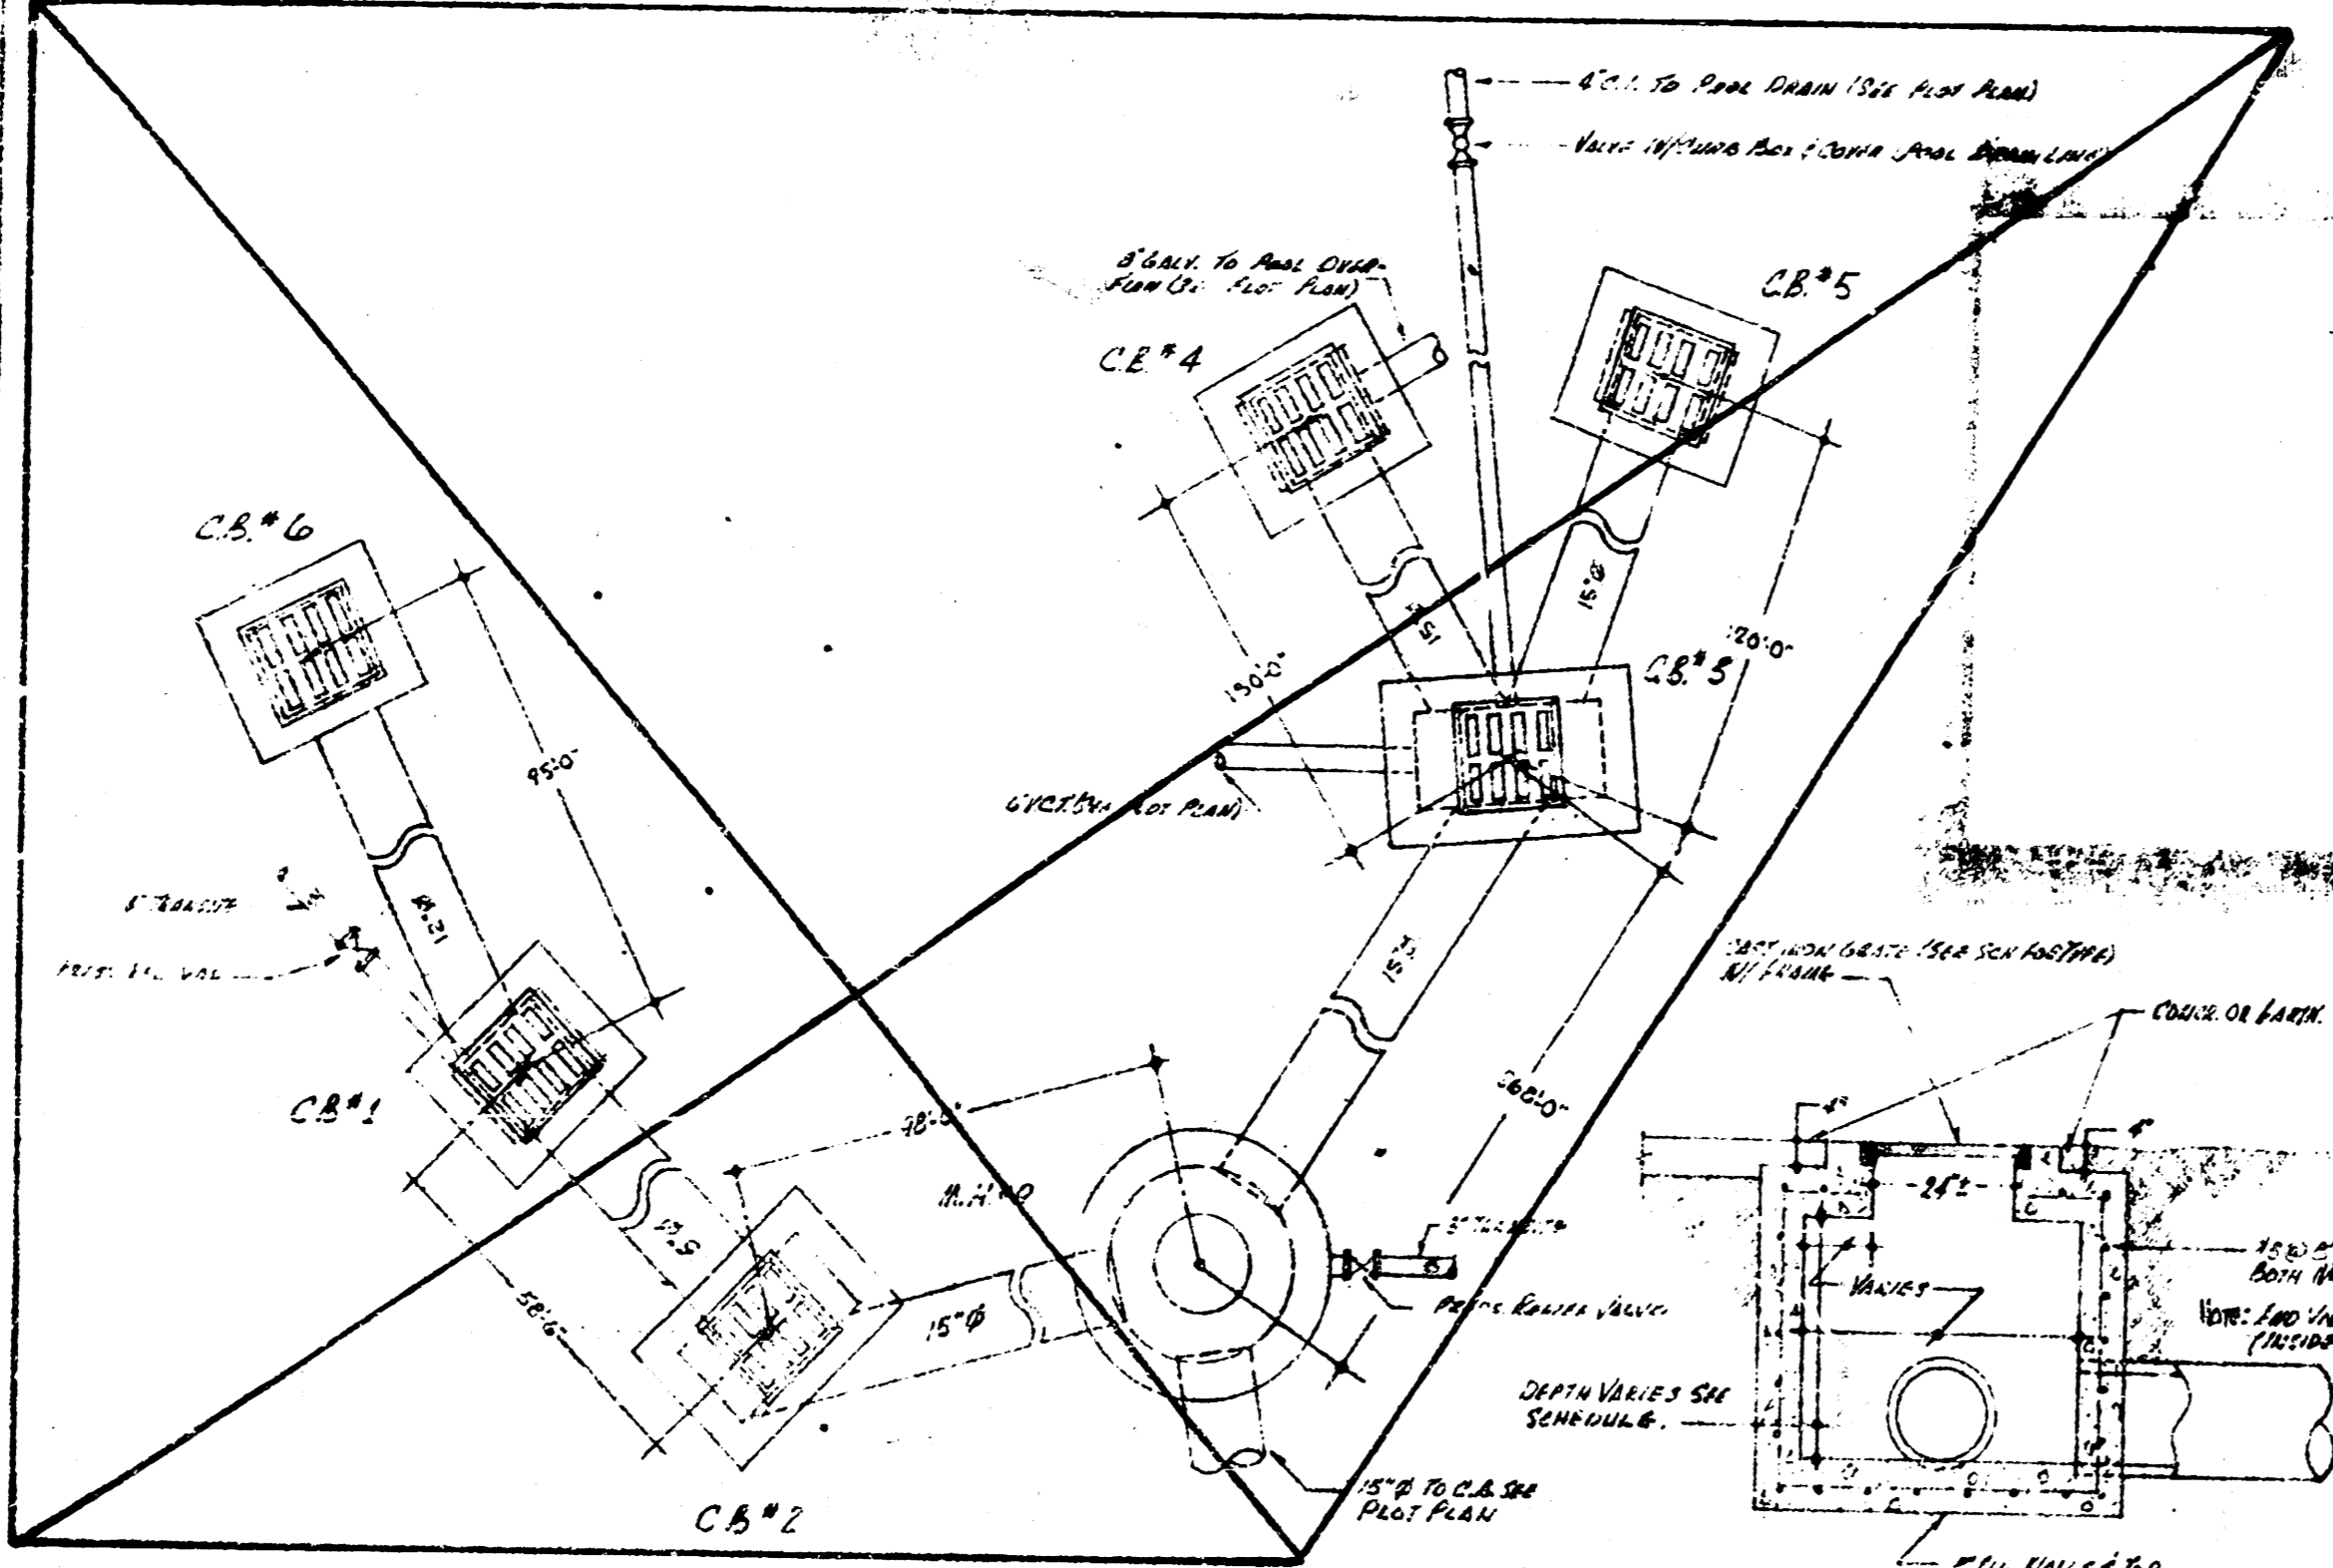


CATCH BASIN PIPING LAYOUT
SCALE 1/4" = 1'-0"

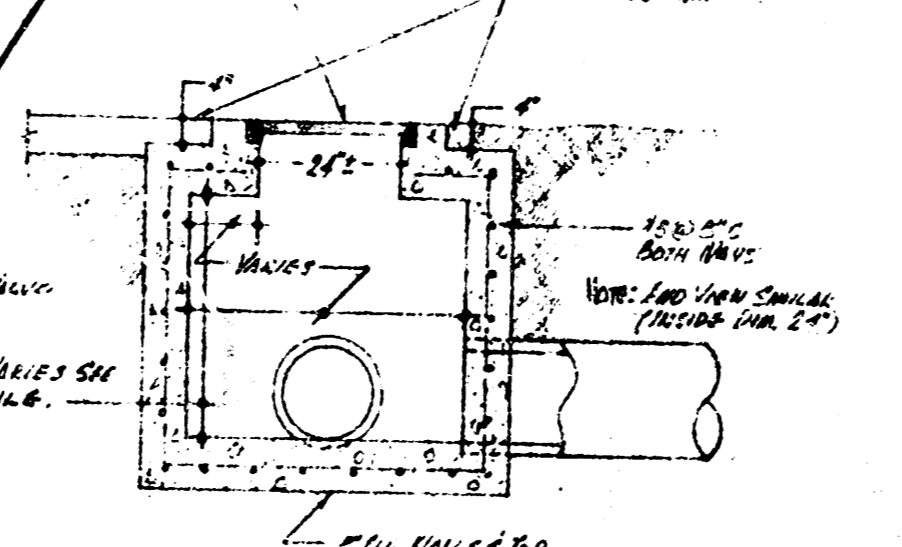


TYPICAL SECTION THRU CATCH BASIN
SCALE 1/4" = 1'-0"

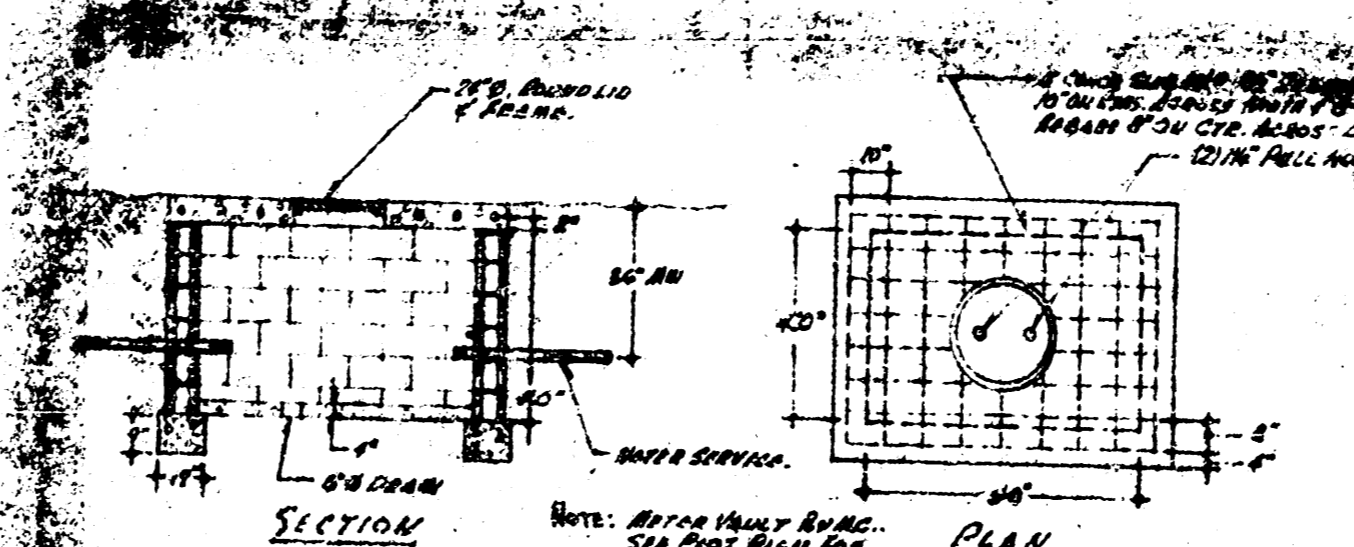

WATER METER VAULT DETAIL
SCALE 1/4" = 1'-0"

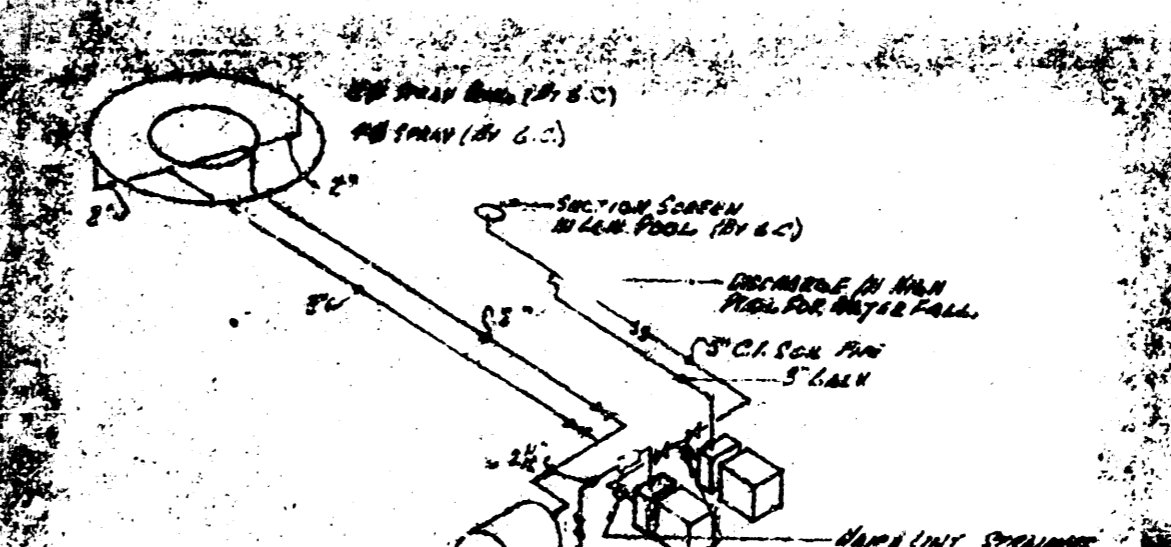

PUMP DETAIL FOR FOUNTAIN
NO SCALE

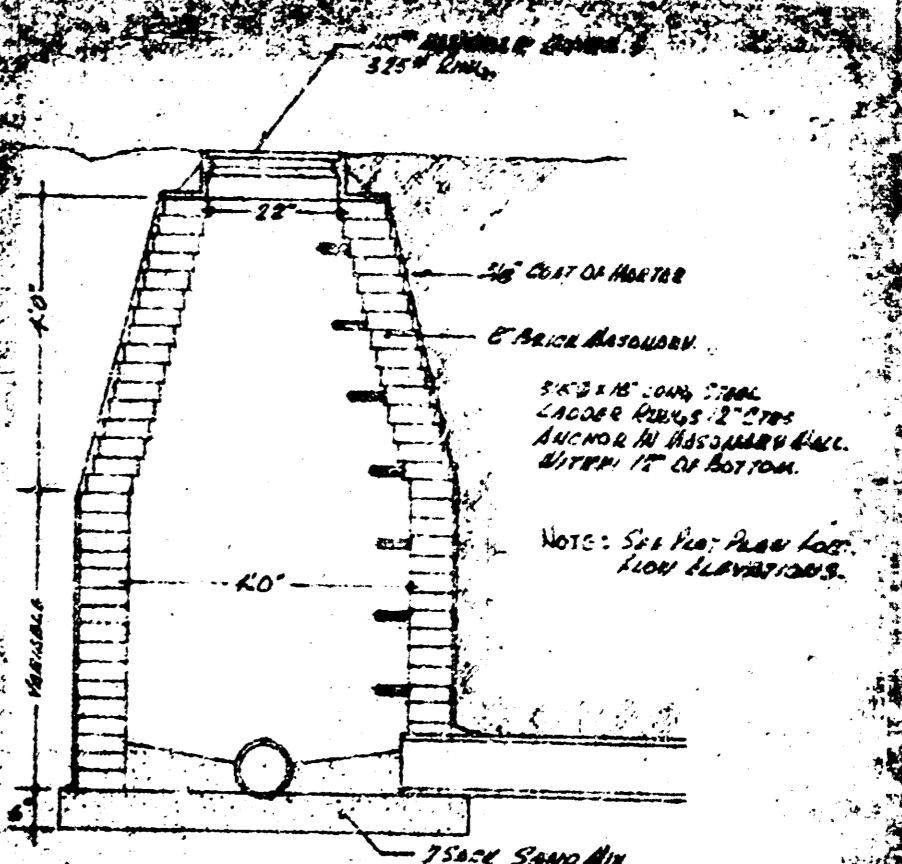

MANHOLE DETAIL
NO SCALE

HOME FOR ELDERLY — ABE. WICHITA, KANSAS

ALPH L. HOLLS — A.P.A.
WICHITA, KANSAS

11-9-68 COMM NO 6208 M-4

