

NO.	DESCRIPTION
1	AS SHOWN
2	AS SHOWN
3	AS SHOWN
4	AS SHOWN
5	AS SHOWN
6	AS SHOWN
7	AS SHOWN
8	AS SHOWN
9	AS SHOWN
10	AS SHOWN
11	AS SHOWN
12	AS SHOWN
13	AS SHOWN
14	AS SHOWN
15	AS SHOWN
16	AS SHOWN
17	AS SHOWN
18	AS SHOWN
19	AS SHOWN
20	AS SHOWN
21	AS SHOWN
22	AS SHOWN
23	AS SHOWN
24	AS SHOWN
25	AS SHOWN
26	AS SHOWN
27	AS SHOWN
28	AS SHOWN
29	AS SHOWN
30	AS SHOWN
31	AS SHOWN
32	AS SHOWN
33	AS SHOWN
34	AS SHOWN
35	AS SHOWN
36	AS SHOWN
37	AS SHOWN
38	AS SHOWN
39	AS SHOWN
40	AS SHOWN
41	AS SHOWN
42	AS SHOWN
43	AS SHOWN
44	AS SHOWN
45	AS SHOWN
46	AS SHOWN
47	AS SHOWN
48	AS SHOWN
49	AS SHOWN
50	AS SHOWN

1. ALL WORK TO BE ACCORDING TO THE SPECIFICATIONS AND NOTES.
 2. ALL WORK TO BE ACCORDING TO THE SPECIFICATIONS AND NOTES.
 3. ALL WORK TO BE ACCORDING TO THE SPECIFICATIONS AND NOTES.
 4. ALL WORK TO BE ACCORDING TO THE SPECIFICATIONS AND NOTES.
 5. ALL WORK TO BE ACCORDING TO THE SPECIFICATIONS AND NOTES.
 6. ALL WORK TO BE ACCORDING TO THE SPECIFICATIONS AND NOTES.
 7. ALL WORK TO BE ACCORDING TO THE SPECIFICATIONS AND NOTES.
 8. ALL WORK TO BE ACCORDING TO THE SPECIFICATIONS AND NOTES.
 9. ALL WORK TO BE ACCORDING TO THE SPECIFICATIONS AND NOTES.
 10. ALL WORK TO BE ACCORDING TO THE SPECIFICATIONS AND NOTES.
 11. ALL WORK TO BE ACCORDING TO THE SPECIFICATIONS AND NOTES.
 12. ALL WORK TO BE ACCORDING TO THE SPECIFICATIONS AND NOTES.
 13. ALL WORK TO BE ACCORDING TO THE SPECIFICATIONS AND NOTES.
 14. ALL WORK TO BE ACCORDING TO THE SPECIFICATIONS AND NOTES.
 15. ALL WORK TO BE ACCORDING TO THE SPECIFICATIONS AND NOTES.
 16. ALL WORK TO BE ACCORDING TO THE SPECIFICATIONS AND NOTES.
 17. ALL WORK TO BE ACCORDING TO THE SPECIFICATIONS AND NOTES.
 18. ALL WORK TO BE ACCORDING TO THE SPECIFICATIONS AND NOTES.
 19. ALL WORK TO BE ACCORDING TO THE SPECIFICATIONS AND NOTES.
 20. ALL WORK TO BE ACCORDING TO THE SPECIFICATIONS AND NOTES.
 21. ALL WORK TO BE ACCORDING TO THE SPECIFICATIONS AND NOTES.
 22. ALL WORK TO BE ACCORDING TO THE SPECIFICATIONS AND NOTES.
 23. ALL WORK TO BE ACCORDING TO THE SPECIFICATIONS AND NOTES.
 24. ALL WORK TO BE ACCORDING TO THE SPECIFICATIONS AND NOTES.
 25. ALL WORK TO BE ACCORDING TO THE SPECIFICATIONS AND NOTES.
 26. ALL WORK TO BE ACCORDING TO THE SPECIFICATIONS AND NOTES.
 27. ALL WORK TO BE ACCORDING TO THE SPECIFICATIONS AND NOTES.
 28. ALL WORK TO BE ACCORDING TO THE SPECIFICATIONS AND NOTES.
 29. ALL WORK TO BE ACCORDING TO THE SPECIFICATIONS AND NOTES.
 30. ALL WORK TO BE ACCORDING TO THE SPECIFICATIONS AND NOTES.
 31. ALL WORK TO BE ACCORDING TO THE SPECIFICATIONS AND NOTES.
 32. ALL WORK TO BE ACCORDING TO THE SPECIFICATIONS AND NOTES.
 33. ALL WORK TO BE ACCORDING TO THE SPECIFICATIONS AND NOTES.
 34. ALL WORK TO BE ACCORDING TO THE SPECIFICATIONS AND NOTES.
 35. ALL WORK TO BE ACCORDING TO THE SPECIFICATIONS AND NOTES.
 36. ALL WORK TO BE ACCORDING TO THE SPECIFICATIONS AND NOTES.
 37. ALL WORK TO BE ACCORDING TO THE SPECIFICATIONS AND NOTES.
 38. ALL WORK TO BE ACCORDING TO THE SPECIFICATIONS AND NOTES.
 39. ALL WORK TO BE ACCORDING TO THE SPECIFICATIONS AND NOTES.
 40. ALL WORK TO BE ACCORDING TO THE SPECIFICATIONS AND NOTES.
 41. ALL WORK TO BE ACCORDING TO THE SPECIFICATIONS AND NOTES.
 42. ALL WORK TO BE ACCORDING TO THE SPECIFICATIONS AND NOTES.
 43. ALL WORK TO BE ACCORDING TO THE SPECIFICATIONS AND NOTES.
 44. ALL WORK TO BE ACCORDING TO THE SPECIFICATIONS AND NOTES.
 45. ALL WORK TO BE ACCORDING TO THE SPECIFICATIONS AND NOTES.
 46. ALL WORK TO BE ACCORDING TO THE SPECIFICATIONS AND NOTES.
 47. ALL WORK TO BE ACCORDING TO THE SPECIFICATIONS AND NOTES.
 48. ALL WORK TO BE ACCORDING TO THE SPECIFICATIONS AND NOTES.
 49. ALL WORK TO BE ACCORDING TO THE SPECIFICATIONS AND NOTES.
 50. ALL WORK TO BE ACCORDING TO THE SPECIFICATIONS AND NOTES.

FIRST PLAN
 SCALE 1/8" = 1'-0"

LEGEND


---	2" GAS LINE
---	6" AC WATER PIPE
---	4" AC WATER PIPE
---	4" AC WATER PIPE
---	SANITARY SERVICE
---	EQUIPMENT LINE




LeRoy D. Bradford AIA
 Lawrence F. Smith AIA
 C. Stewart Shepherd

BRADFORD, SMITH & SHEPHERD Architects


3900 South Crysler • Independence, Missouri • (405) 241-3100

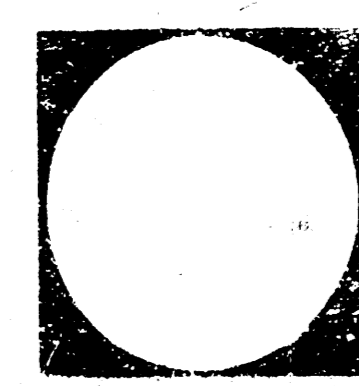



Revisions	Date	Job No.	Job Name	Sheet Title
				FIRST PLAN UTILITY PLAN WATER, SEWER, & GAS

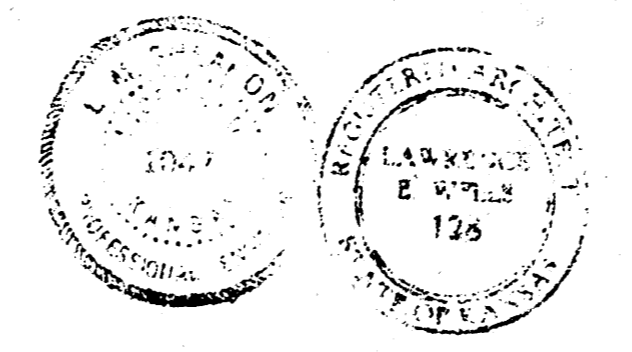

6-29-59

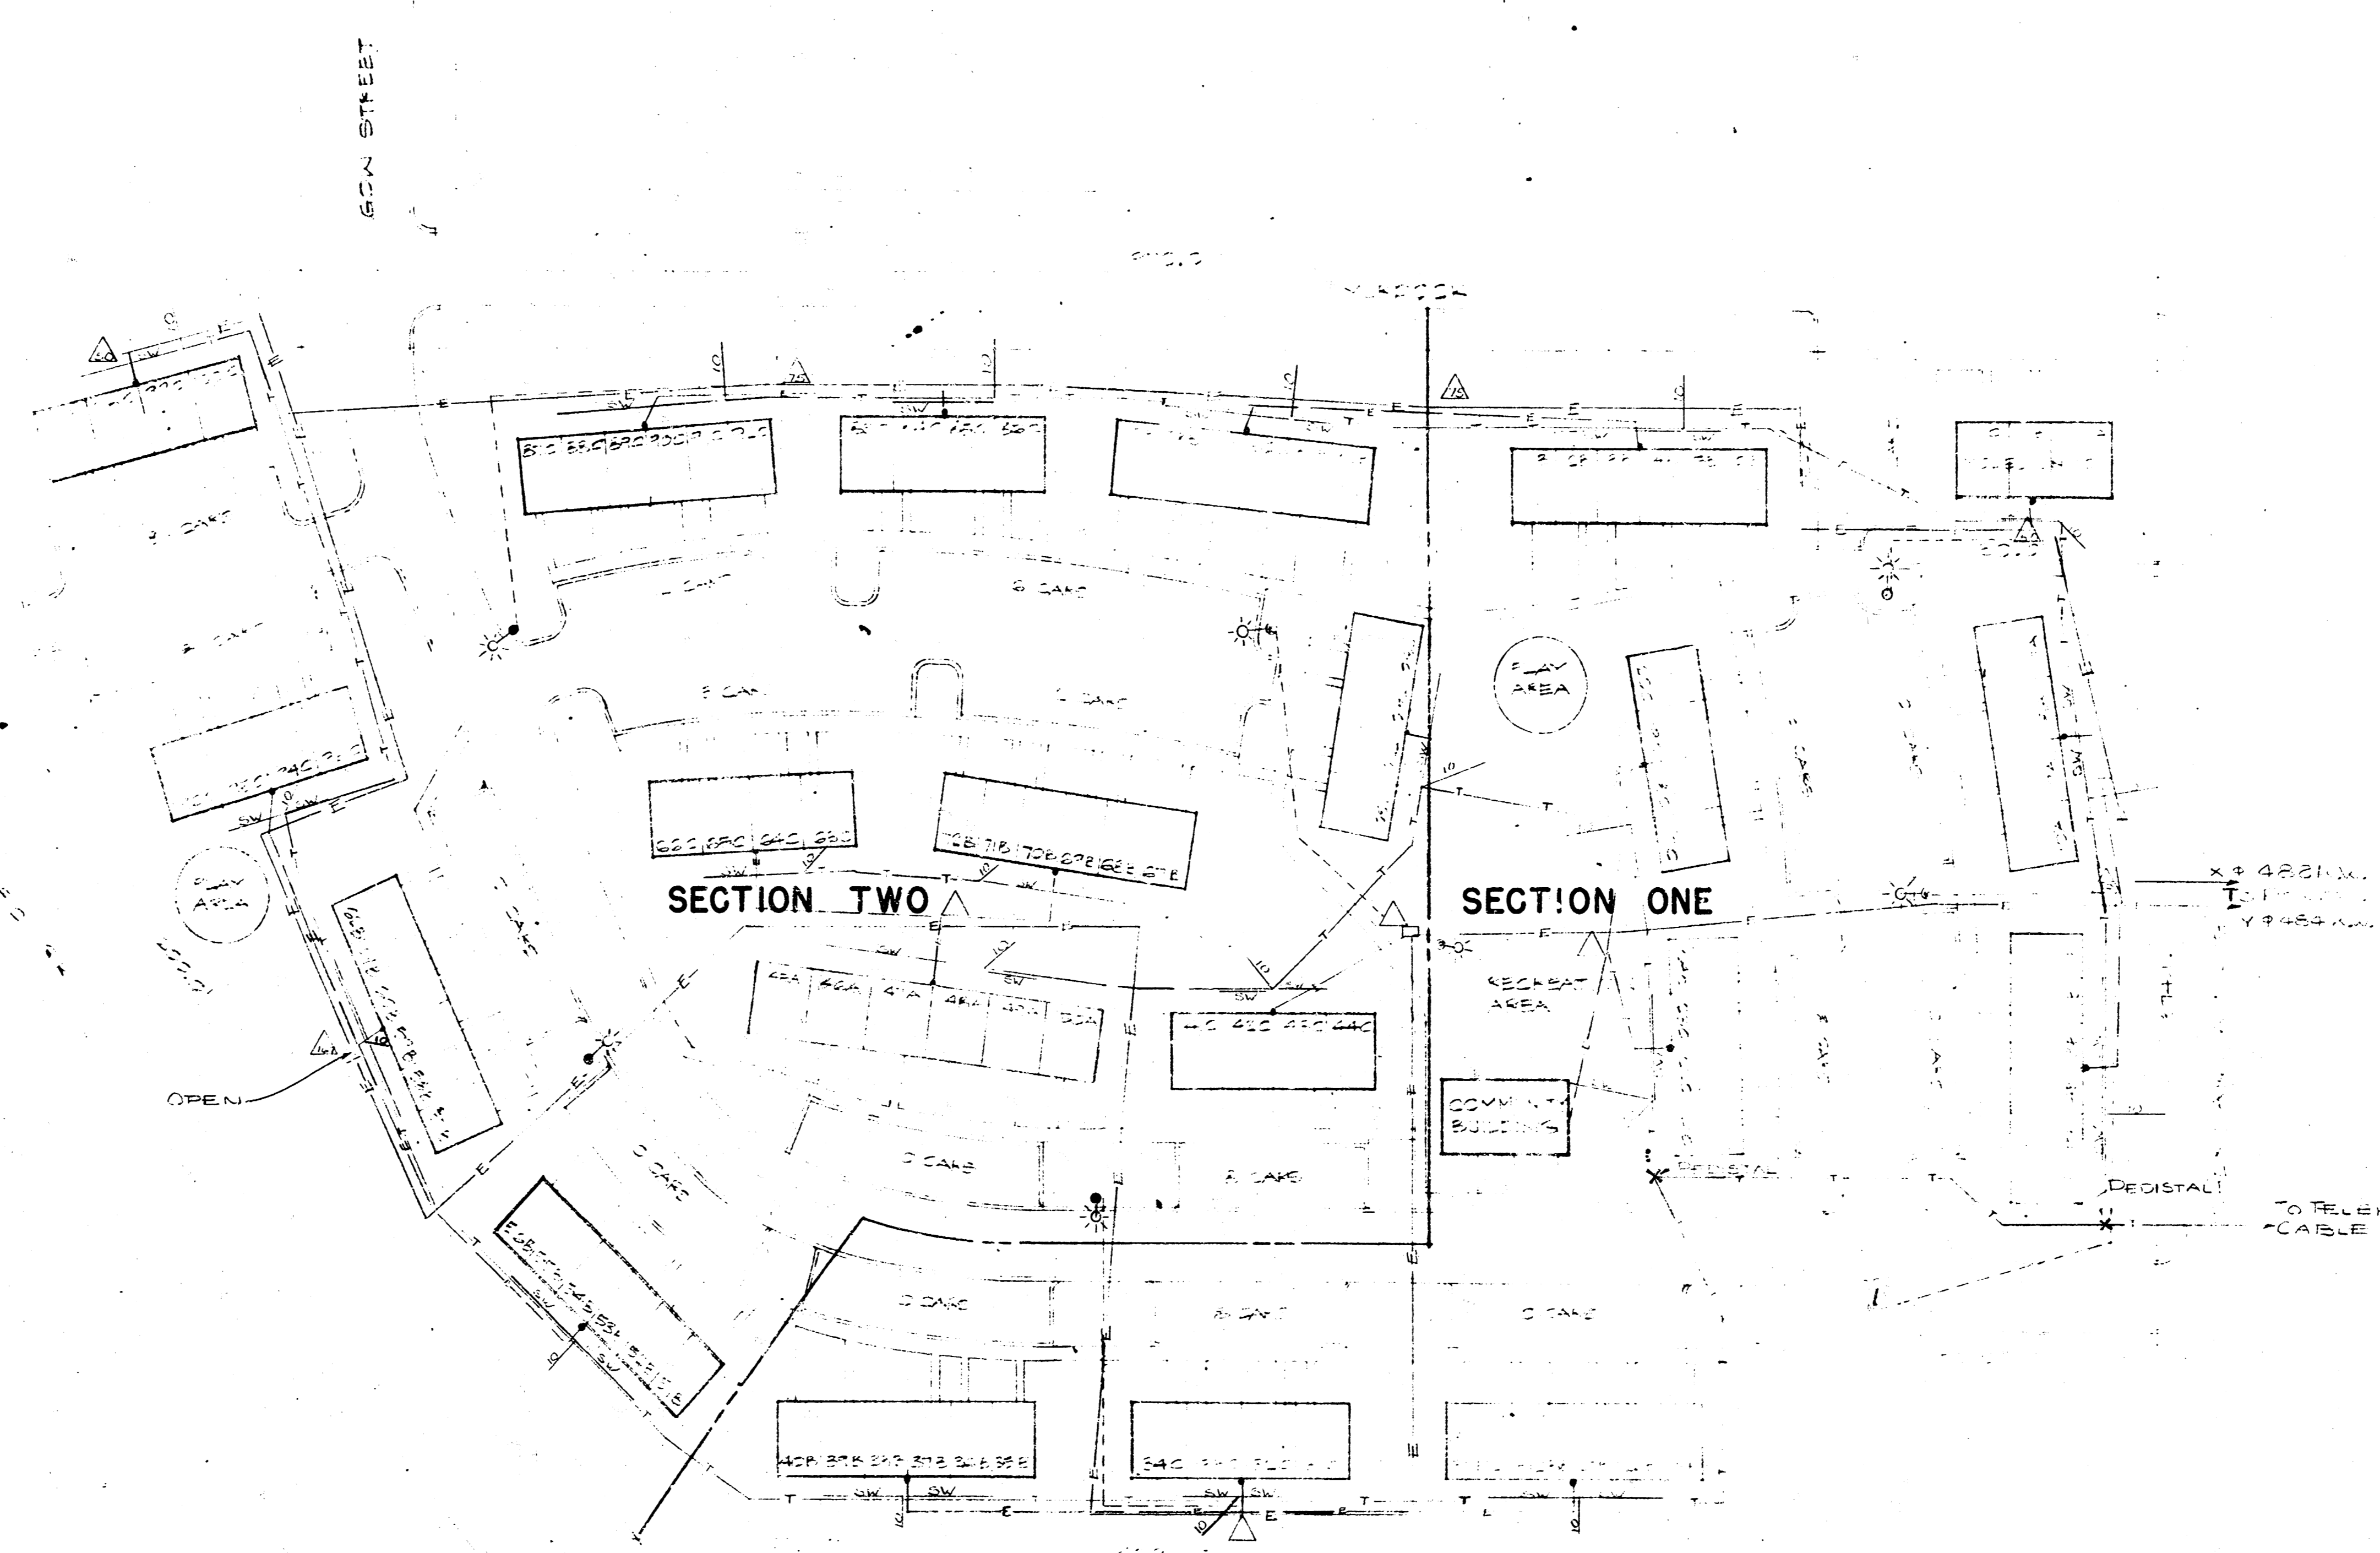


0 - 1/2" = 1' - 0"
 1/4" = 1' - 0"
 1/8" = 1' - 0"
 1/16" = 1' - 0"
 1/32" = 1' - 0"
 1/64" = 1' - 0"
 1/128" = 1' - 0"
 1/256" = 1' - 0"
 1/512" = 1' - 0"
 1/1024" = 1' - 0"
 1/2048" = 1' - 0"
 1/4096" = 1' - 0"
 1/8192" = 1' - 0"
 1/16384" = 1' - 0"
 1/32768" = 1' - 0"
 1/65536" = 1' - 0"
 1/131072" = 1' - 0"
 1/262144" = 1' - 0"
 1/524288" = 1' - 0"
 1/1048576" = 1' - 0"
 1/2097152" = 1' - 0"
 1/4194304" = 1' - 0"
 1/8388608" = 1' - 0"
 1/16777216" = 1' - 0"
 1/33554432" = 1' - 0"
 1/67108864" = 1' - 0"
 1/134217728" = 1' - 0"
 1/268435456" = 1' - 0"
 1/536870912" = 1' - 0"
 1/1073741824" = 1' - 0"
 1/2147483648" = 1' - 0"
 1/4294967296" = 1' - 0"
 1/8589934592" = 1' - 0"
 1/17179869184" = 1' - 0"
 1/34359738368" = 1' - 0"
 1/68719476736" = 1' - 0"
 1/137438953472" = 1' - 0"
 1/274877906944" = 1' - 0"
 1/549755813888" = 1' - 0"
 1/1099511627776" = 1' - 0"
 1/2199023255552" = 1' - 0"
 1/4398046511104" = 1' - 0"
 1/8796093022208" = 1' - 0"
 1/17592186044416" = 1' - 0"
 1/35184372088832" = 1' - 0"
 1/70368744177664" = 1' - 0"
 1/140737488355328" = 1' - 0"
 1/281474976710656" = 1' - 0"
 1/562949953421312" = 1' - 0"
 1/1125899906842624" = 1' - 0"
 1/2251799813685248" = 1' - 0"
 1/4503599627370496" = 1' - 0"
 1/9007199254740992" = 1' - 0"
 1/18014398509481984" = 1' - 0"
 1/36028797018963968" = 1' - 0"
 1/72057594037927936" = 1' - 0"
 1/144115188075855872" = 1' - 0"
 1/288230376151711744" = 1' - 0"
 1/576460752303423488" = 1' - 0"
 1/1152921504606846976" = 1' - 0"
 1/2305843009213693952" = 1' - 0"
 1/4611686018427387904" = 1' - 0"
 1/9223372036854775808" = 1' - 0"
 1/18446744073709551616" = 1' - 0"
 1/36893488147419103232" = 1' - 0"
 1/73786976294838206464" = 1' - 0"
 1/147573952589676412928" = 1' - 0"
 1/295147905179352825856" = 1' - 0"
 1/590295810358705651712" = 1' - 0"
 1/1180591620717411303424" = 1' - 0"
 1/2361183241434822606848" = 1' - 0"
 1/4722366482869645213696" = 1' - 0"
 1/9444732965739290427392" = 1' - 0"
 1/18889465931478580854784" = 1' - 0"
 1/37778931862957161709568" = 1' - 0"
 1/75557863725914323419136" = 1' - 0"
 1/151115727451828646838272" = 1' - 0"
 1/302231454903657293676544" = 1' - 0"
 1/604462909807314587353088" = 1' - 0"
 1/1208925819614629174706176" = 1' - 0"
 1/2417851639229258349412352" = 1' - 0"
 1/4835703278458516698824704" = 1' - 0"
 1/9671406556917033397649408" = 1' - 0"
 1/19342813113834066795298816" = 1' - 0"
 1/38685626227668133590597632" = 1' - 0"
 1/77371252455336267181195264" = 1' - 0"
 1/154742504910672534362390528" = 1' - 0"
 1/309485009821345068724781056" = 1' - 0"
 1/618970019642690137449562112" = 1' - 0"
 1/1237940039285380274899124224" = 1' - 0"
 1/2475880078570760549798248448" = 1' - 0"
 1/4951760157141521099596496896" = 1' - 0"
 1/9903520314283042199192993792" = 1' - 0"
 1/19807040628566084398385987584" = 1' - 0"
 1/39614081257132168796771975168" = 1' - 0"
 1/79228162514264337593543950336" = 1' - 0"
 1/158456325028528675187087900672" = 1' - 0"
 1/316912650057057350374175801344" = 1' - 0"
 1/633825300114114700748351602688" = 1' - 0"
 1/1267650600228229401496703205376" = 1' - 0"
 1/2535301200456458802993406410752" = 1' - 0"
 1/5070602400912917605986812821504" = 1' - 0"
 1/10141204801825835211973625643008" = 1' - 0"
 1/20282409603651670423947251286016" = 1' - 0"
 1/40564819207303340847894502572032" = 1' - 0"
 1/81129638414606681695789005144064" = 1' - 0"
 1/162259276832213363391578010288128" = 1' - 0"
 1/324518553664426726783156020576256" = 1' - 0"
 1/649037107328853453566312041152512" = 1' - 0"
 1/1298074214657706907132624082305024" = 1' - 0"
 1/2596148429315413814265248164610048" = 1' - 0"
 1/5192296858630827628530496329220096" = 1' - 0"
 1/10384593717261655257060992658440192" = 1' - 0"
 1/20769187434523310514121985316880384" = 1' - 0"
 1/41538374869046621028243970633760768" = 1' - 0"
 1/83076749738093242056487941267521536" = 1' - 0"
 1/166153499476186484112975882535042672" = 1' - 0"
 1/332306998952372968225951751070085344" = 1' - 0"
 1/664613997904745936451903502140170688" = 1' - 0"
 1/1329227995809491872903807004283401376" = 1' - 0"
 1/2658455991618983745807614008566802752" = 1' - 0"
 1/5316911983237967491615228017133605504" = 1' - 0"
 1/10633823966475934983230456034267211008" = 1' - 0"
 1/21267647932951869966460912068534422016" = 1' - 0"
 1/42535295865903739932921824137068844032" = 1' - 0"
 1/85070591731807479865843648274137688064" = 1' - 0"
 1/170141183463614959731687296548275372128" = 1' - 0"
 1/340282366927229919463374593096550744256" = 1' - 0"
 1/680564733854459838926749186193101488512" = 1' - 0"
 1/1361129467708919677853498372386202977024" = 1' - 0"
 1/2722258935417839355706996744772405954048" = 1' - 0"
 1/5444517870835678711413993489544811908096" = 1' - 0"
 1/10889035741671357422827986979089623816192" = 1' - 0"
 1/21778071483342714845655973958179247632384" = 1' - 0"
 1/43556142966685429691311947916358495264768" = 1' - 0"
 1/87112285933370859382623895832716990529536" = 1' - 0"
 1/17422457186674171876524779166543984105984" = 1' - 0"
 1/34844914373348343753049558333087968211968" = 1' - 0"
 1/69689828746696687506099116666175936423936" = 1' - 0"
 1/139379657493393375012198233332351872847872" = 1' - 0"
 1/278759314986786750024396466664703755695648" = 1' - 0"
 1/557518629973573500048792933329407511391136" = 1' - 0"
 1/111503725994714700009758586665881502782272" = 1' - 0"
 1/223007451989429400019517173331774005564544" = 1' - 0"
 1/446014903978858800039034346663548011129088" = 1' - 0"
 1/892029807957717600078068693327116022258176" = 1' - 0"
 1/178405961591543520015613738665423204451632" = 1' - 0"
 1/35681192318308704003122747733084640890304" = 1' - 0"
 1/71362384636617408062454895466169281780608" = 1' - 0"
 1/142724769273234816124909790932338563561216" = 1' - 0"
 1/285449538546469632249819581864677127122432" = 1' - 0"
 1/57089907709293926449963916372935425424464" = 1' - 0"
 1/114179815418587852999327832745870850848928" = 1' - 0"
 1/228359630837175705998655665491741701697952" = 1' - 0"
 1/45671926167435141199731133098348340339584" = 1' - 0"
 1/91343852334870282399462266196796680679168" = 1' - 0"
 1/182687704669740564798924532393593361382336" = 1' - 0"
 1/365375409339481129597849064787186722764672" = 1' - 0"
 1/730750818678962259195698129574373445529344" = 1' - 0"
 1/146150163735792451839139625914874689105888" = 1' - 0"
 1/292300327471584903678279251829749378211776" = 1' - 0"
 1/584600654943169807356558503659498756423552" = 1' - 0"
 1/1169201309886339614713117007318997528847104" = 1' - 0"
 1/233840261977267922942623401463799505769408" = 1' - 0"
 1/467680523954535845885246802927599011538816" = 1' - 0"
 1/935361047909071691770493605855198023077728" = 1' - 0"
 1/1870722095818143383540987211710396046155456" = 1' - 0"
 1/3741444191636286767081974423420792092310912" = 1' - 0"
 1/7482888383272573534163948846841584184621824" = 1' - 0"
 1/1496577676654514706832789769368316836924352" = 1' - 0"
 1/299315535330902941366557953873663367384864" = 1' - 0"
 1/598631070661805882733115907747326734769728" = 1' - 0"
 1/119726214132361176546623181549465347553952" = 1' - 0"
 1/239452428264722353093246363098930695107904" = 1' - 0"
 1/478904856529444706186492726197861392215808" = 1' - 0"
 1/957809713058889412372985452395722784431616" = 1' - 0"
 1/19156194261177788247459709049144555688632" = 1' - 0"
 1/38312388522355576494919418098289111377264" = 1' - 0"
 1/76624777044711152989838836196578222754528" = 1' - 0"
 1/153249554089422305979677672393156445509152" = 1' - 0"
 1/30649910817884461195935534478631289101824" = 1' - 0"
 1/61299821635768922391870868957262578203648" = 1' - 0"
 1/122599643271537844783741737914525156407296" = 1' - 0"
 1/245199286543075689567483475829050312814592" = 1' - 0"
 1/490398573086151379134966951658100625629184" = 1' - 0"
 1/98079714617230275826993390331620125258368" = 1' - 0"
 1/196159429234460551653986780663240250516736" = 1' - 0"
 1/392318858468921103307973561326480501033472" = 1' - 0"
 1/784637716937842206615947222652961002066944" = 1' - 0"
 1/1569275433875684413231914445305922004133888" = 1' - 0"
 1/3138550867751368826463828890611844008267776" = 1' - 0"
 1/6277101735502737652927657781223688016535552" = 1' - 0"
 1/1255420347100547530585531556244737603307104" = 1' - 0"
 1/2510840694201095061171063112489475206601408" = 1' - 0"
 1/5021681388402190122342126249798944133202816" = 1' - 0"
 1/1004336277680438024468425249959788826605536" = 1' - 0"
 1/2008672555360876048936850499919577753211104" = 1' - 0"
 1/4017345110721752097873700999839155462422208" = 1' - 0"
 1/8034690221443504195747401999678310924844416" = 1' - 0"
 1/16069380442887008391494803999356621849688832" = 1' - 0"
 1/32138760885774016782989607998713243699377664" = 1' - 0"
 1/64277521771548033565979215997426487398755296" = 1' - 0"
 1/128555043543096067131958431994852974797510592" = 1' - 0"
 1/257110087086192134263916863989705949595021184" = 1' - 0"
 1/514220174172384268527833727979411899100043776" = 1' - 0"
 1/1028440348344768537055667455958823798200087552" = 1' - 0"
 1/2056880696689537074111334911917675976400175104" = 1' - 0"
 1/4113761393379074148222669823835351952800350208" = 1' - 0"
 1/8227522786758148296445339647670703905600700416" = 1' - 0"
 1/16455045573516296592890679295341407811201400832" = 1' - 0"
 1/32910091147032593185781358590682815622402801664" = 1' - 0"
 1/65820182294065186371562717181365631244805603328" = 1' - 0"
 1/131640364588130372743125434362731264889611206656" = 1' - 0"
 1/263280729176260745486250868725462529779222413312" = 1' - 0"
 1/526561458352521490972501737450925059558444826624" = 1' - 0"
 1/1053122916705042981945003474901801191116889653248" = 1' - 0"
 1/2106245833410085963890006949803602382233779206496" = 1' - 0"
 1/4212491666820171927780013899607204764467558412992" = 1' - 0"
 1/8424983333640343855560027799214409528935116825984" = 1' - 0"
 1/16849966667280687711120055998428819057870233715968" = 1' - 0"
 1/33699933334561375422240111996857638115740467431936" = 1' - 0"
 1/67399866669122750844480223993715276231480934863872" = 1' - 0"
 1/134799733338245501688960447987425552462961869727744" = 1' - 0"
 1/269599466676491003377920895974851104925923374455488" = 1' - 0"
 1/539198933352982006755841791949702209851866889110976" = 1' - 0"
 1/1078397866705964013511683783899404419703733778221952" = 1' - 0"
 1/215679573341192802702336756779880883940746755644384" = 1' - 0"
 1/431359146682385605404673513559761778801495111288768" = 1' - 0"
 1/862718293364771210809347027119523557602990222577536" = 1' - 0"
 1/172543658672954242161869405423904711520580445115104" = 1' - 0"
 1/345087317345908484323738810847808230401160882222208" = 1' - 0"
 1/690174634691816968647477621695616460802321644444416" = 1' - 0"
 1/138034926938363393729495524339123292160464288888832" = 1' - 0"
 1/276069853876726787458991048678246584320928577777664" = 1' - 0"
 1/552139707753453574917982097356493168641857555555296" = 1' - 0"
 1/11042794155069071498359641947129863372837151111111552" = 1' - 0"
 1/22085588310138142996719283894259726745674222222222208" = 1' - 0"
 1/44171176620276285993438567788519453491214444444444416" = 1' - 0"
 1/88342353240552571986877135577038906982428888888888832" = 1' - 0"
 1/1766847064811051439737542711540778139648577777777777664" = 1' - 0"
 1/3533694129622102879475085423081556279297155555555555128" = 1' - 0"
 1/7067388259244205758950170846163112585943111111111111256" = 1' - 0"
 1/14134776518488411517900341692326225171086222222222222512" = 1' - 0"
 1/28269553036976823035800683384652450342172444444444445024" = 1' - 0"
 1/565391060739536460716013677693049006843448888888888810048" = 1' - 0"
 1/1130782121479072921432027355386098013686889777777777720096" = 1' - 0"
 1/226156424295814584286405471077216607377777777777777740192" = 1' - 0"
 1/452312848591629168572810942154433214755555555555555580384" = 1' - 0"
 1/904625697183258337145621884308866435111111111111111160768" = 1' - 0"
 1/1809251394366516674291243768617732702222222222222222241536" = 1' - 0"

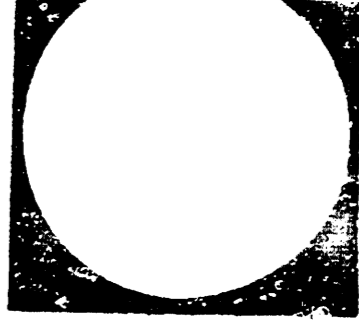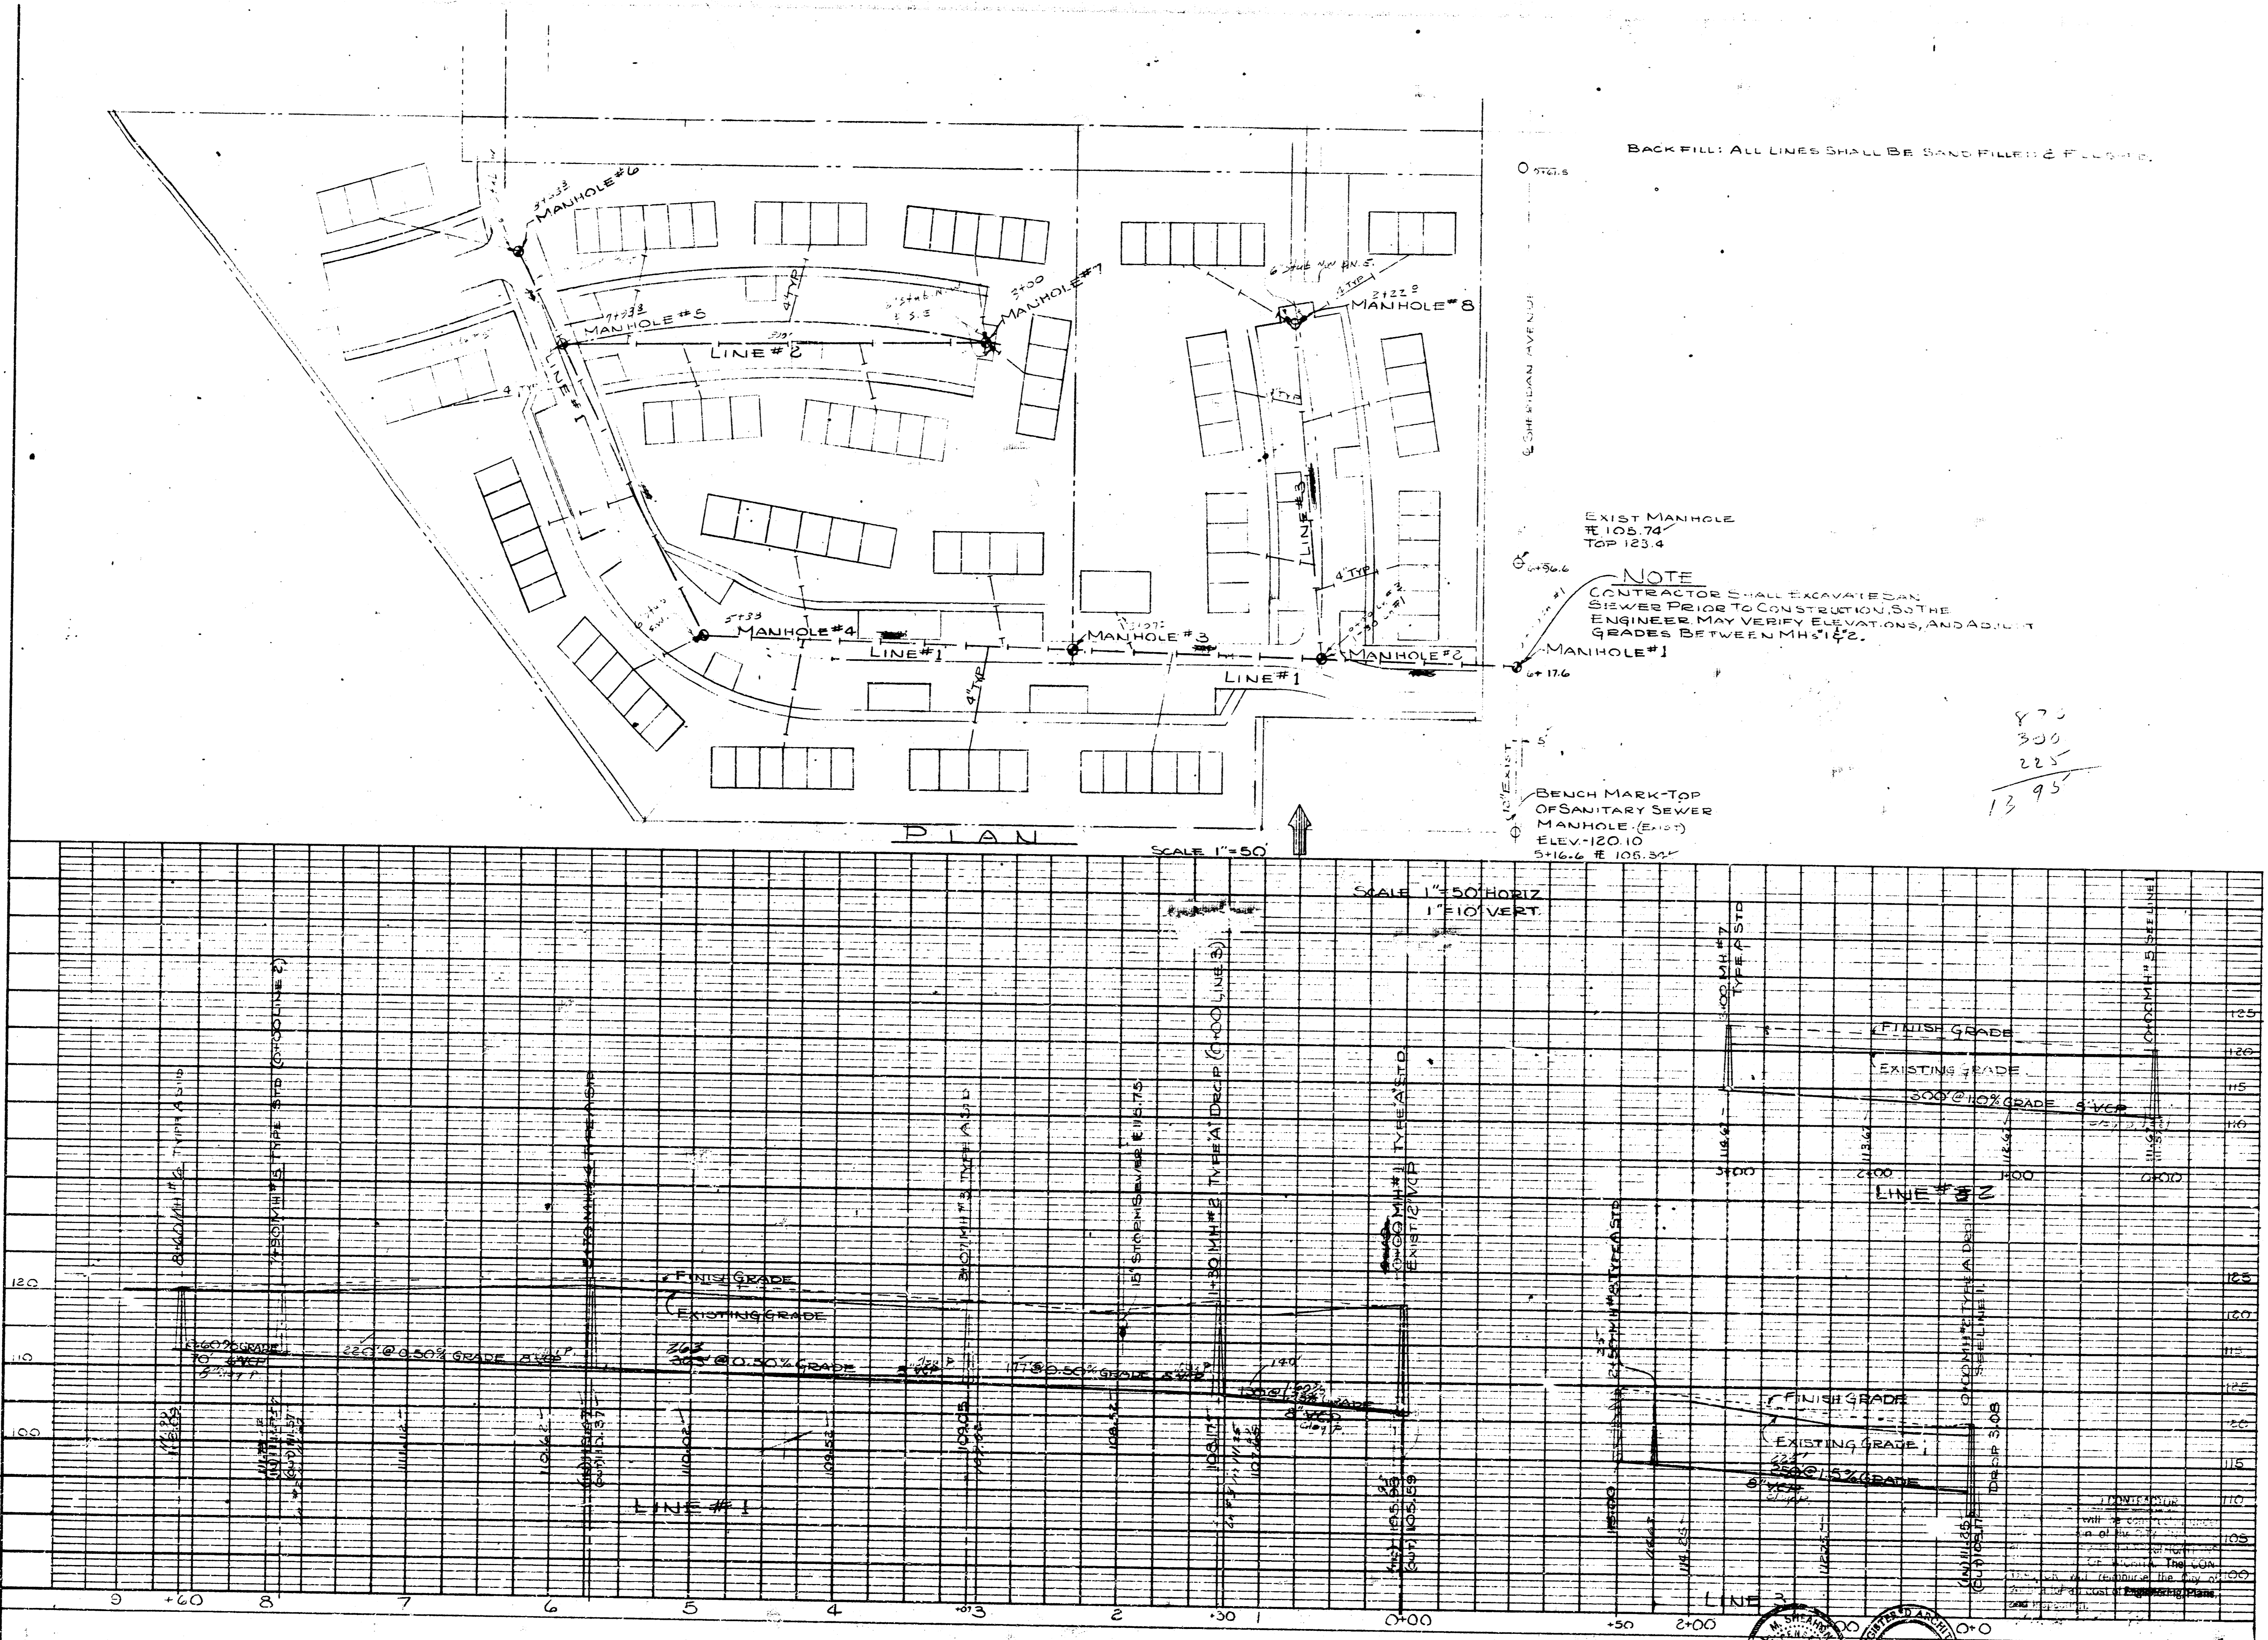





LeRoy D. Bradford A.I.A.
Lawrence F. Smith A.I.A.
C. Stewart Shepherd

BRADFORD, SMITH & SHEPHERD Architects
BLUE RIDGE TOWER, SUITE 720, 4240 BLUE RIDGE BLVD., KANSAS CITY, MO. 64133

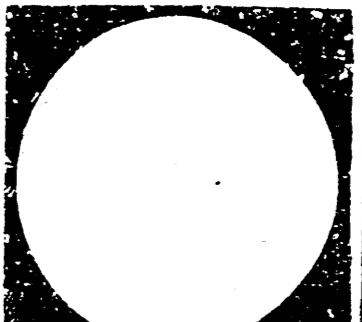


Revisions	Date	Job No.	Job Name	Sheet Title
				SANITARY PLAN & PROFILE



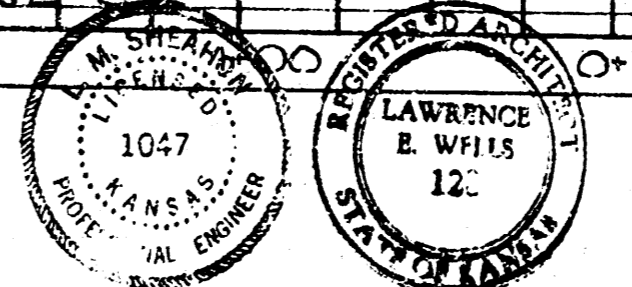


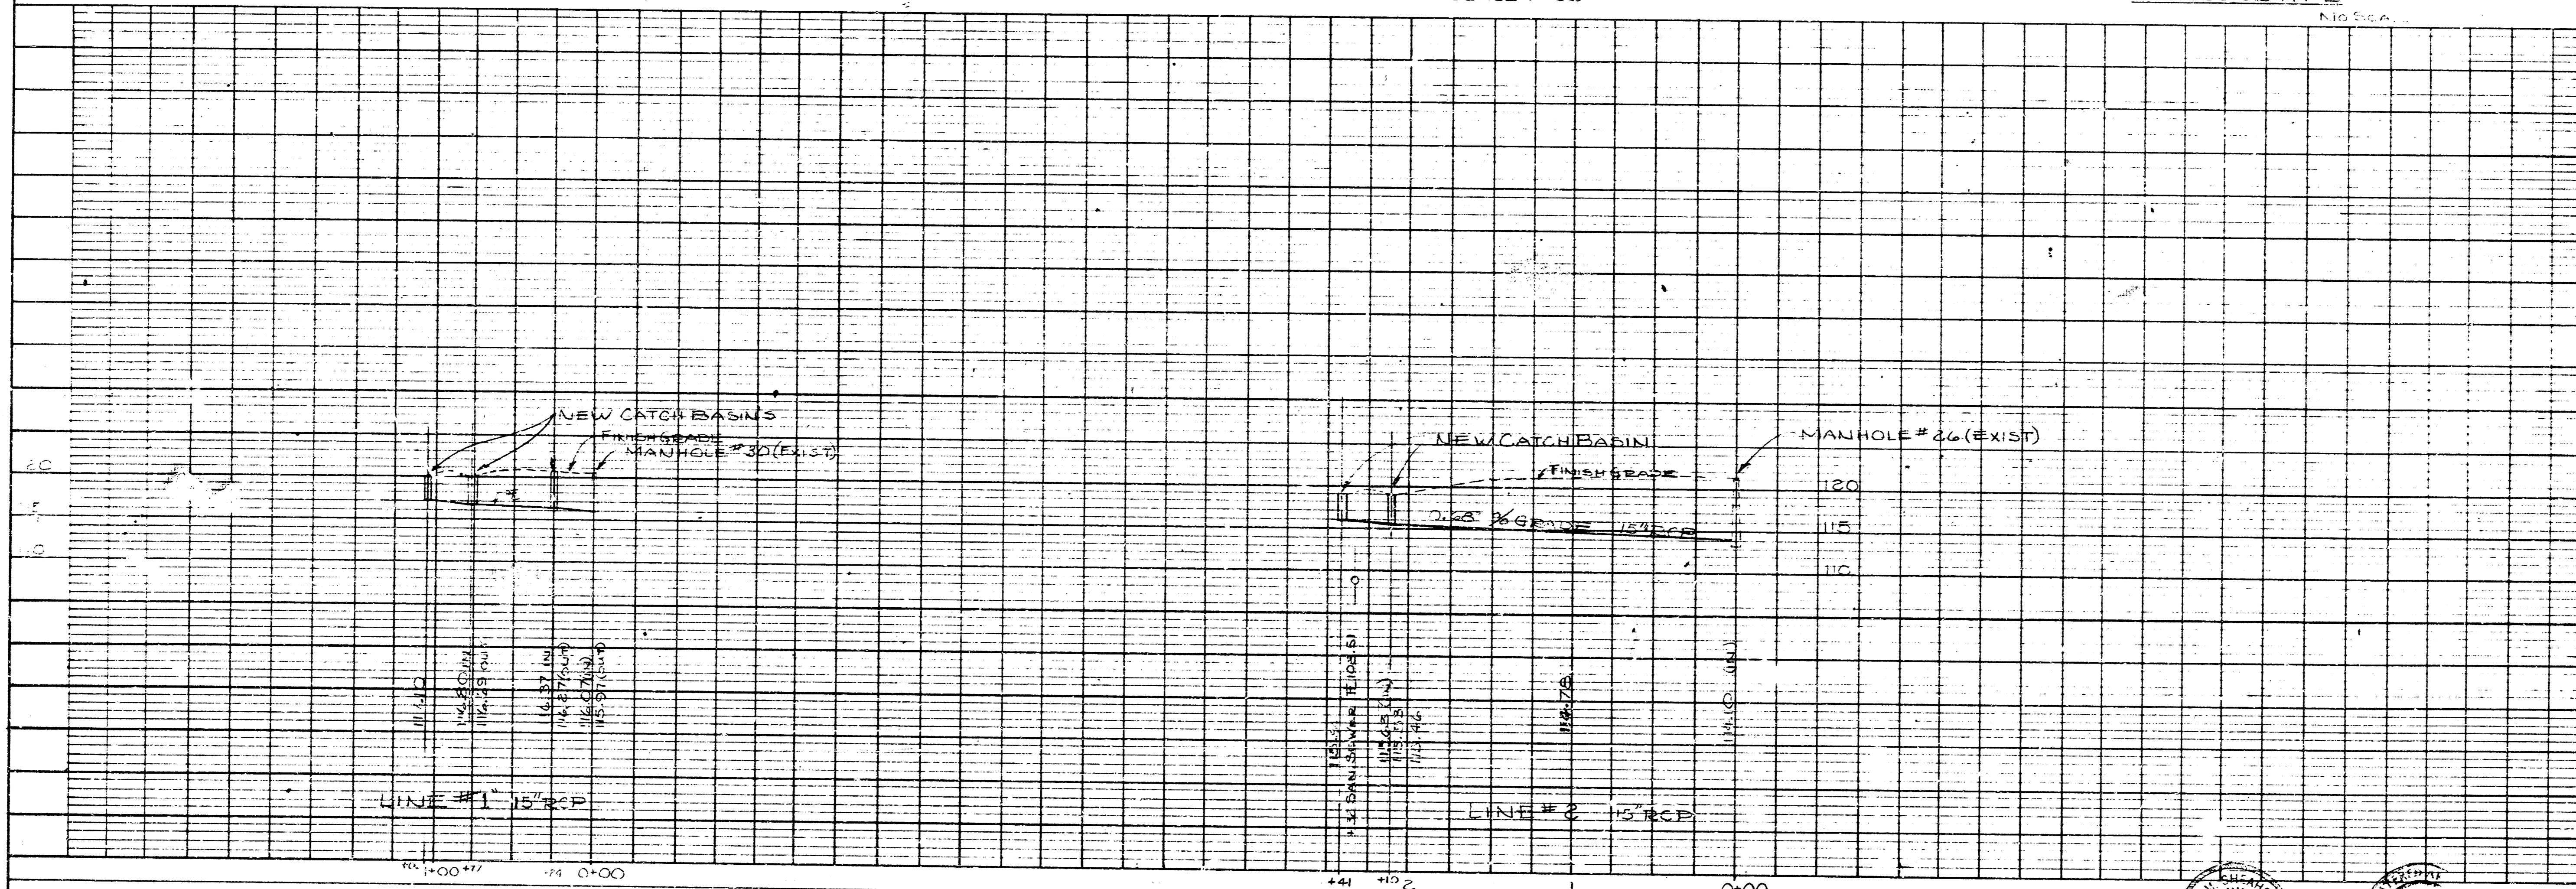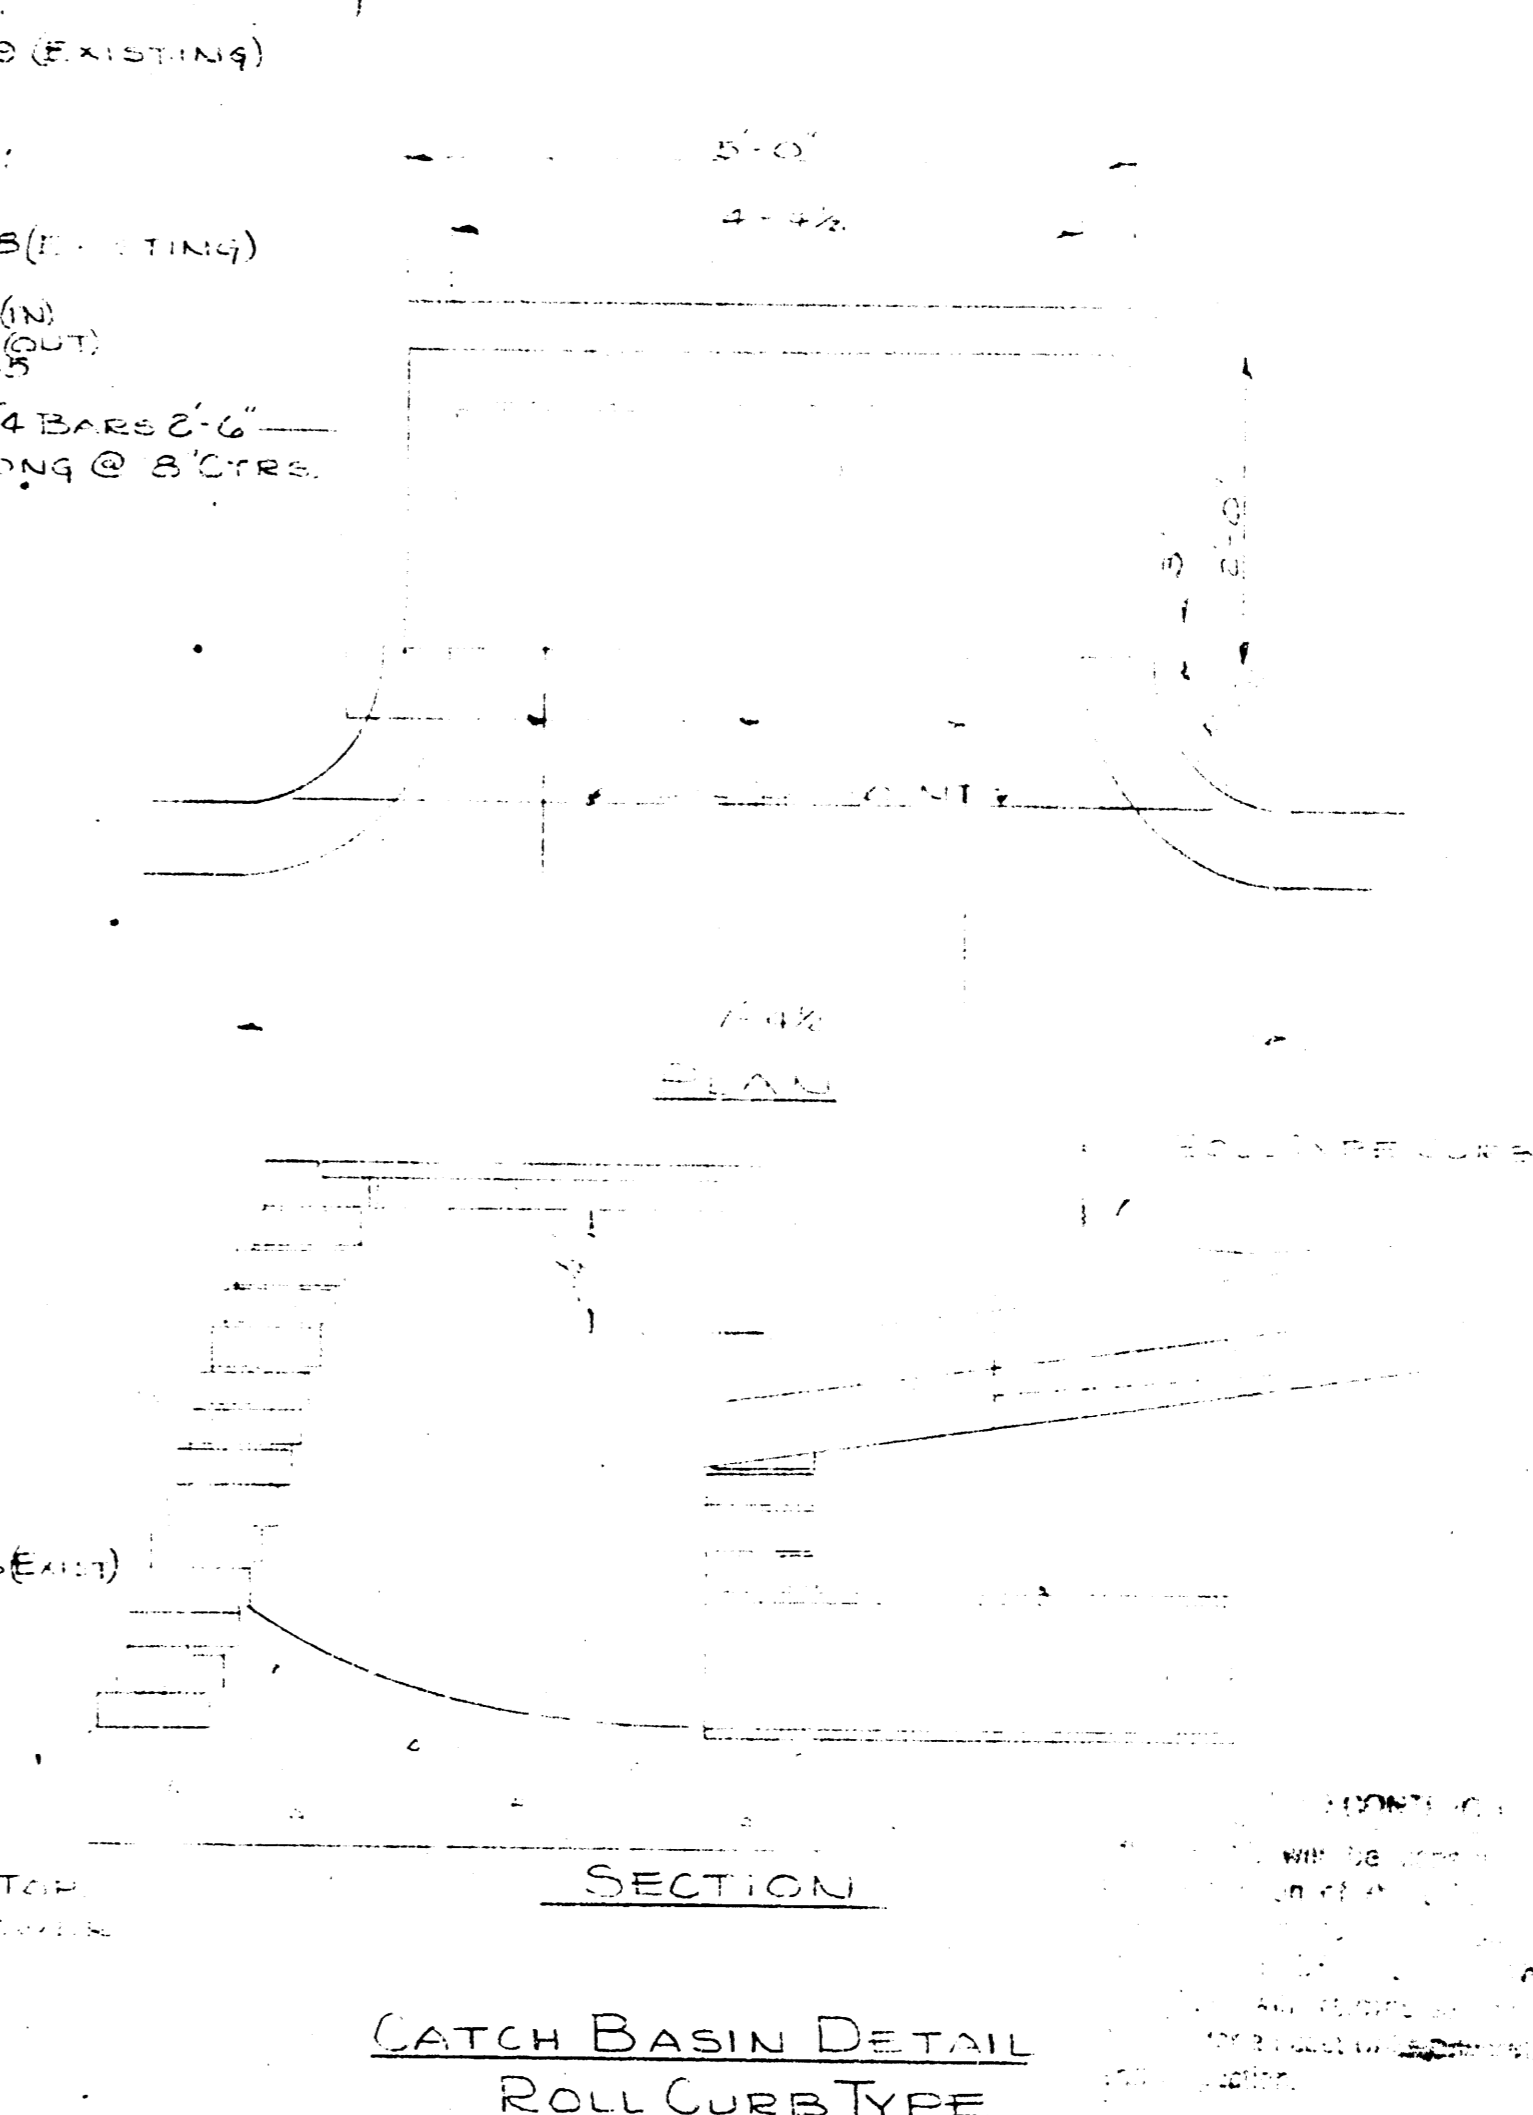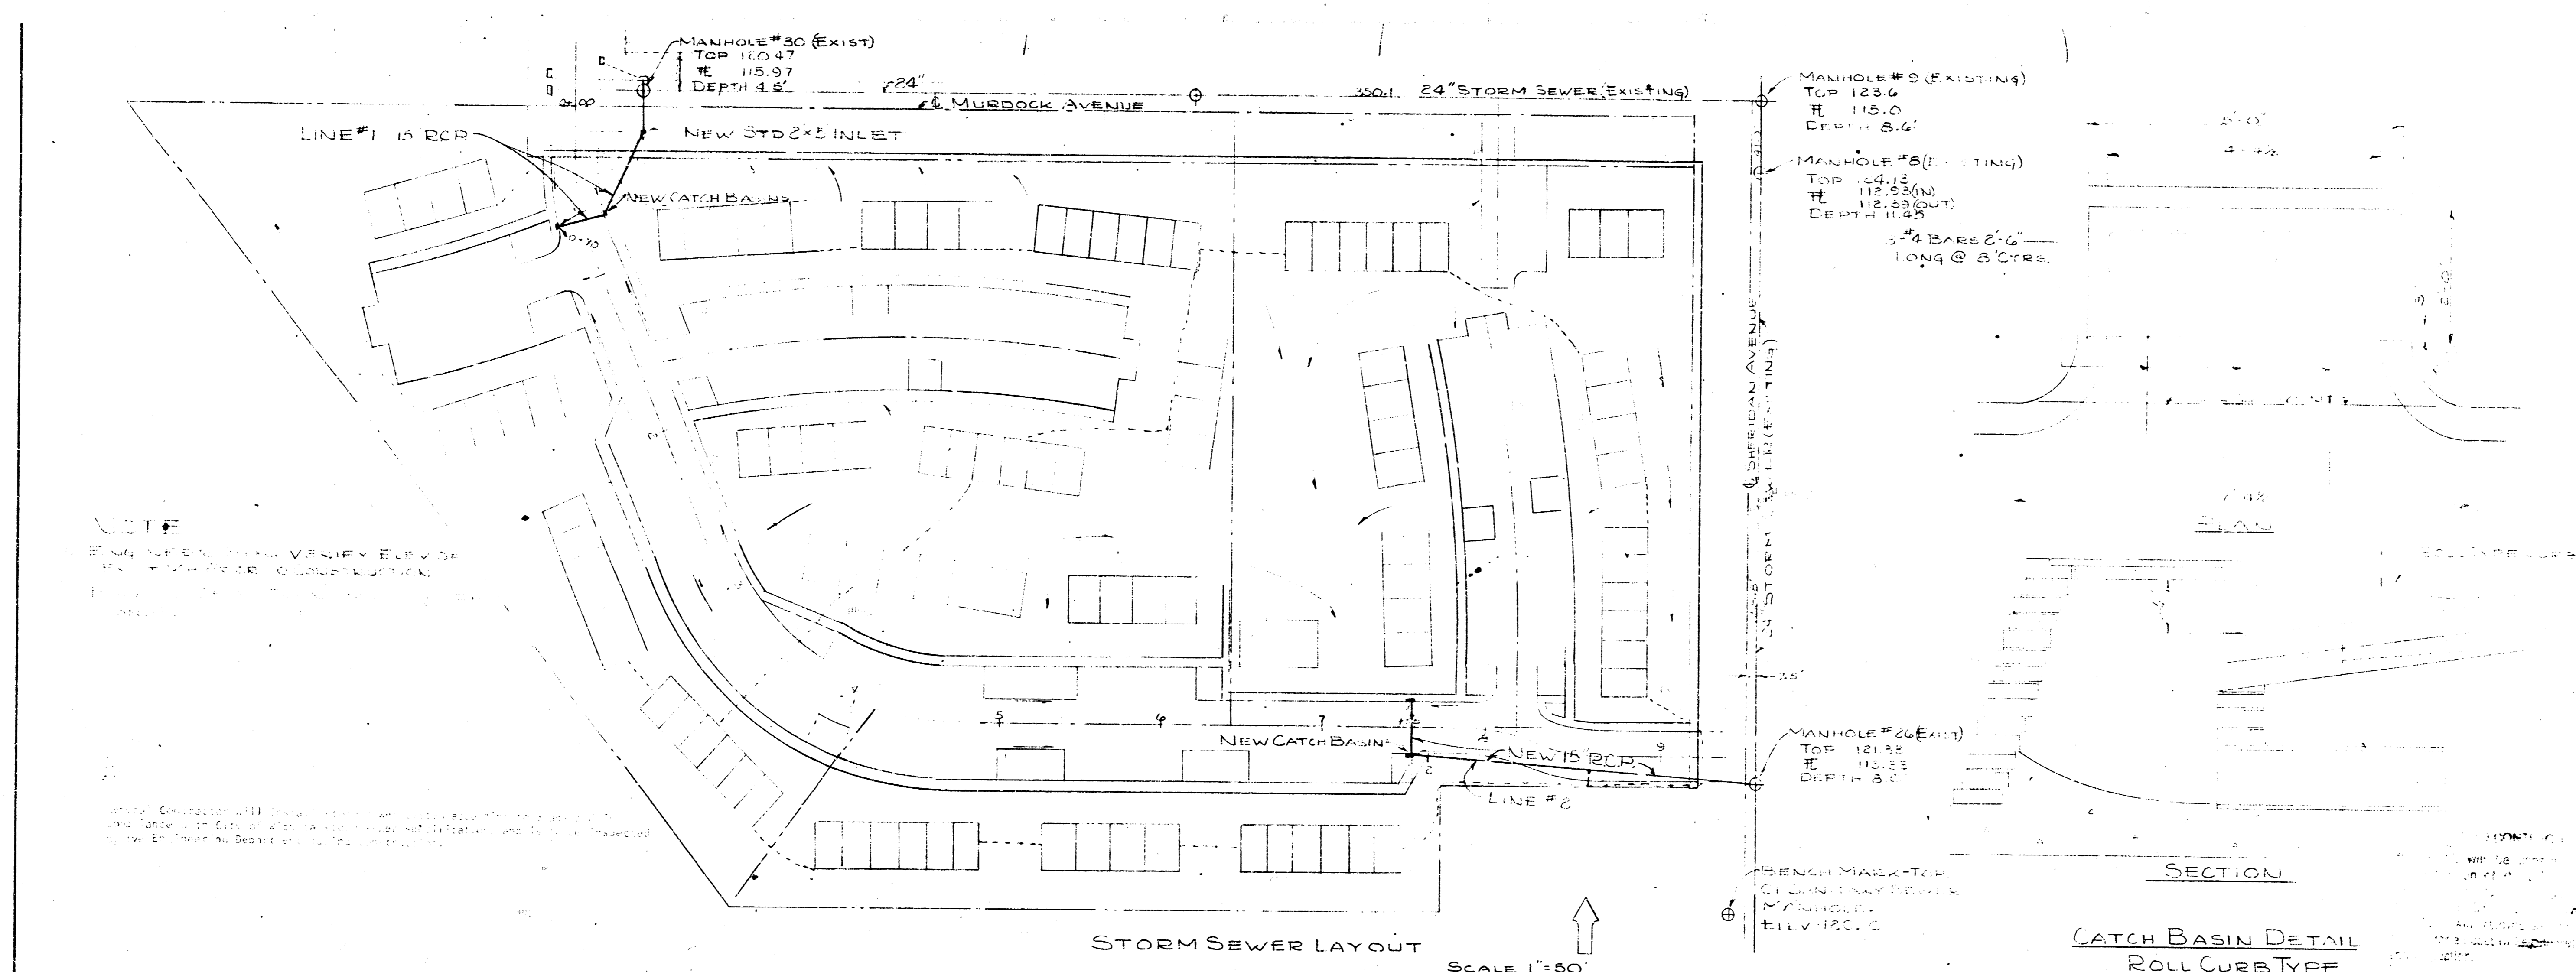



Revisions	Date	Job No.	Job Name	Sheet Title
				STORM SEWER PLAN & PROFILE

BRADFORD, SMITH & SHEPHERD Architects
 BLUE RIDGE TOWER, SUITE 720, 4240 BLUE RIDGE BLVD., KANSAS CITY, MO. 64133
 LeRoy D. Bradford A.I.A.
 Lawrence F. Smith A.I.A.
 C. Stewart Shepherd



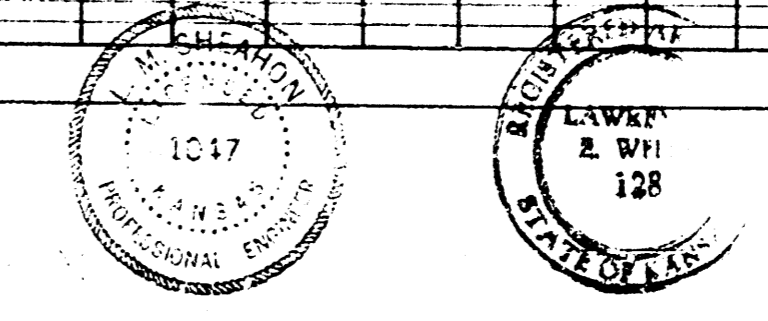


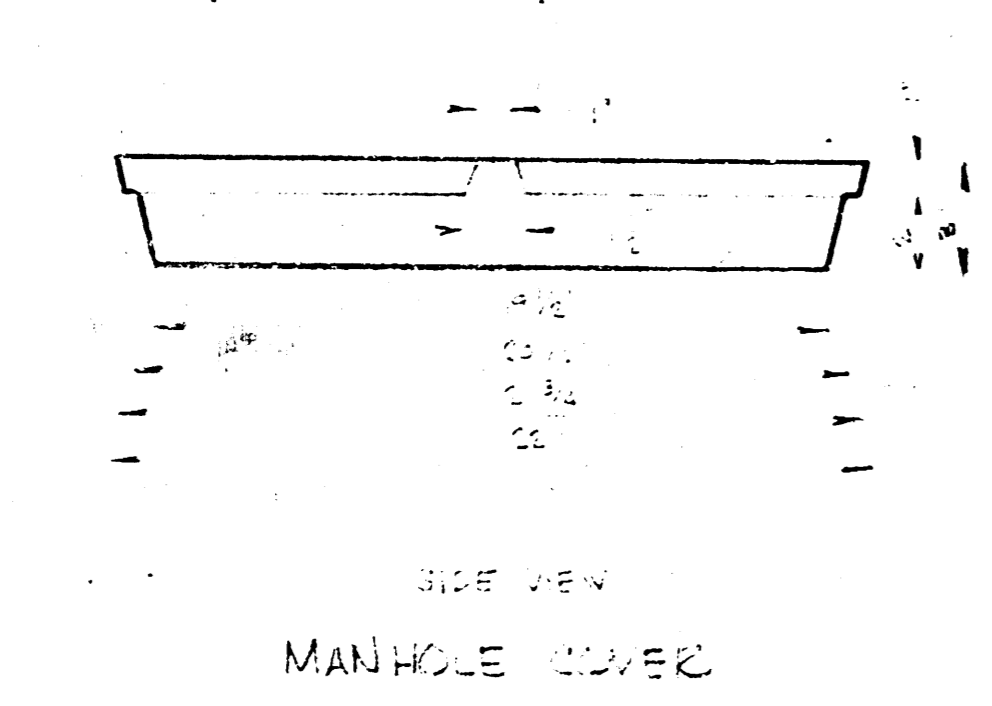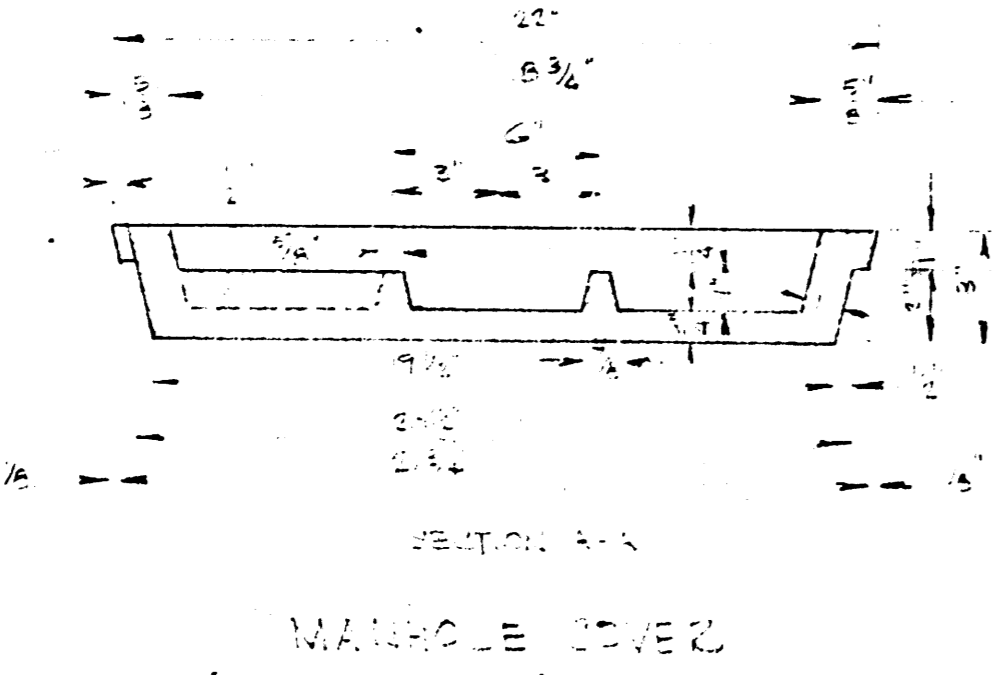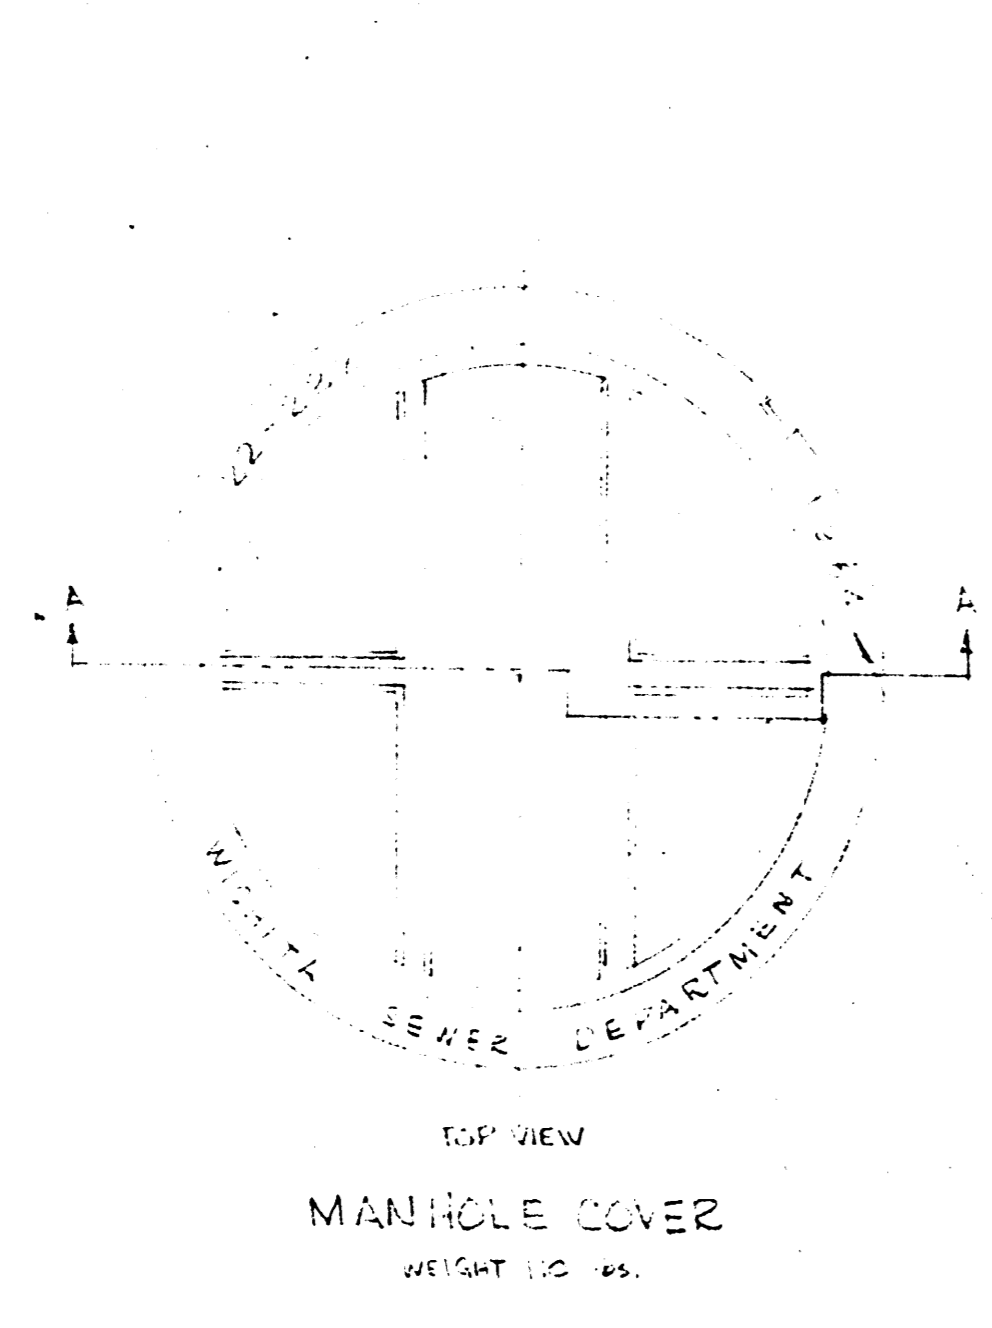


YEAR CASTING IS MADE

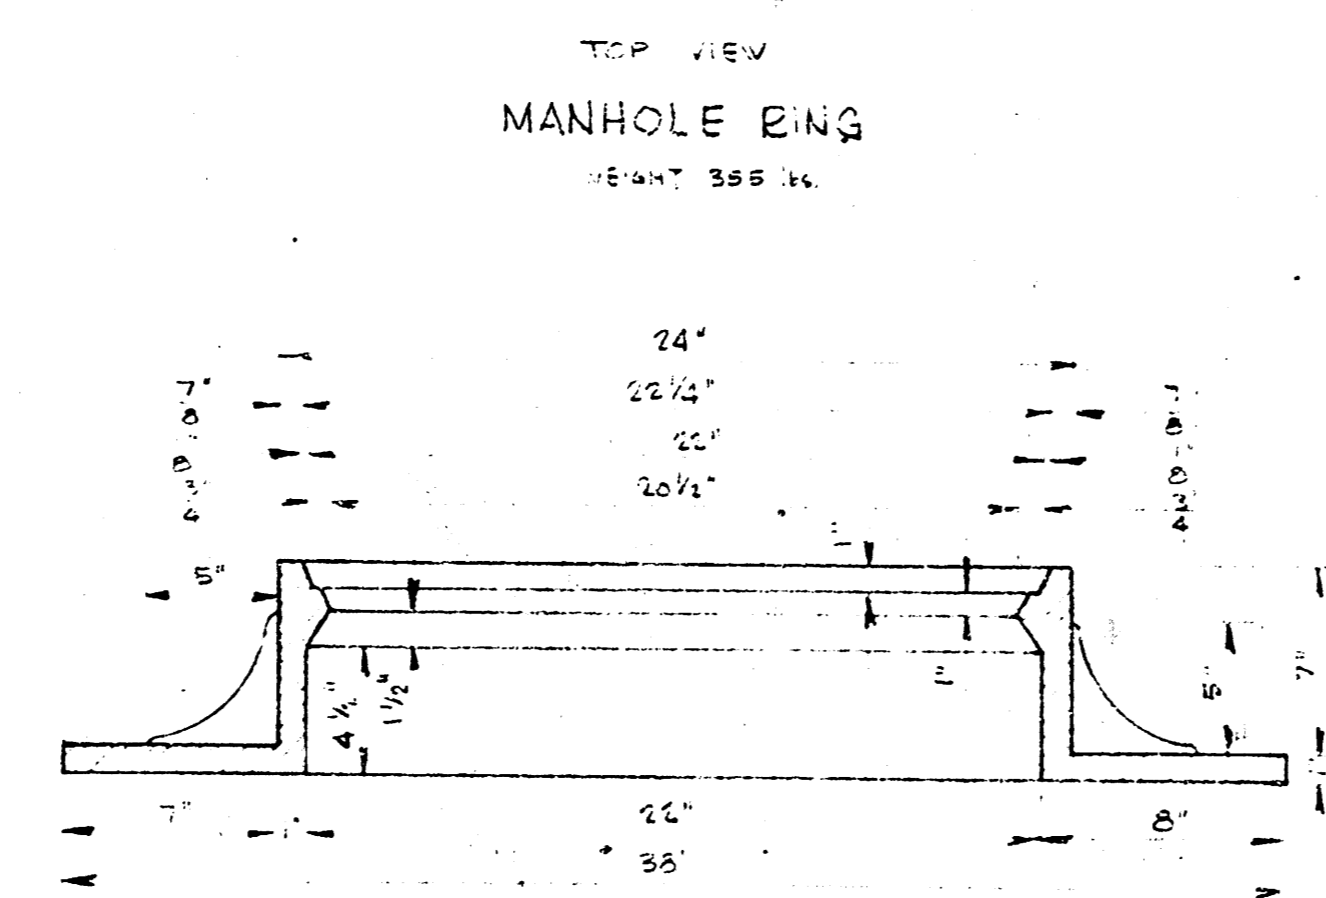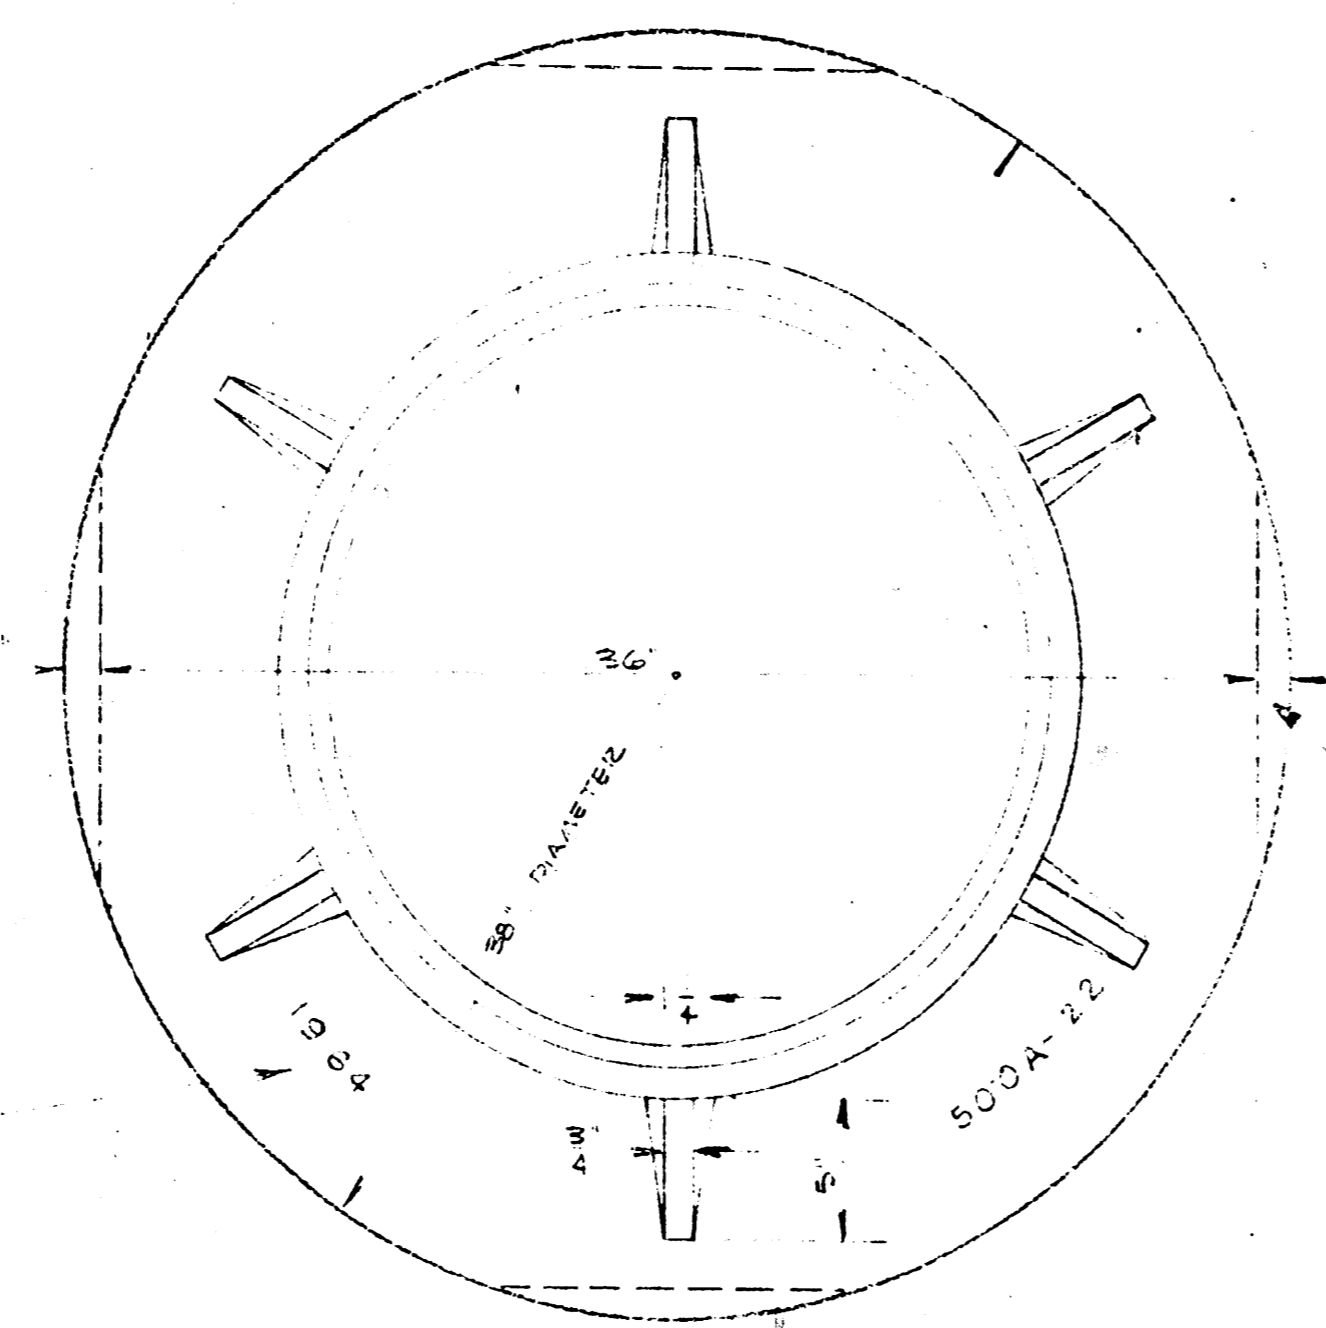

OUTSIDE CIRCUMFERENCE OF COVER AND THE INNER FACE AND HEAT OF RING TO BE MACHINE FIT.

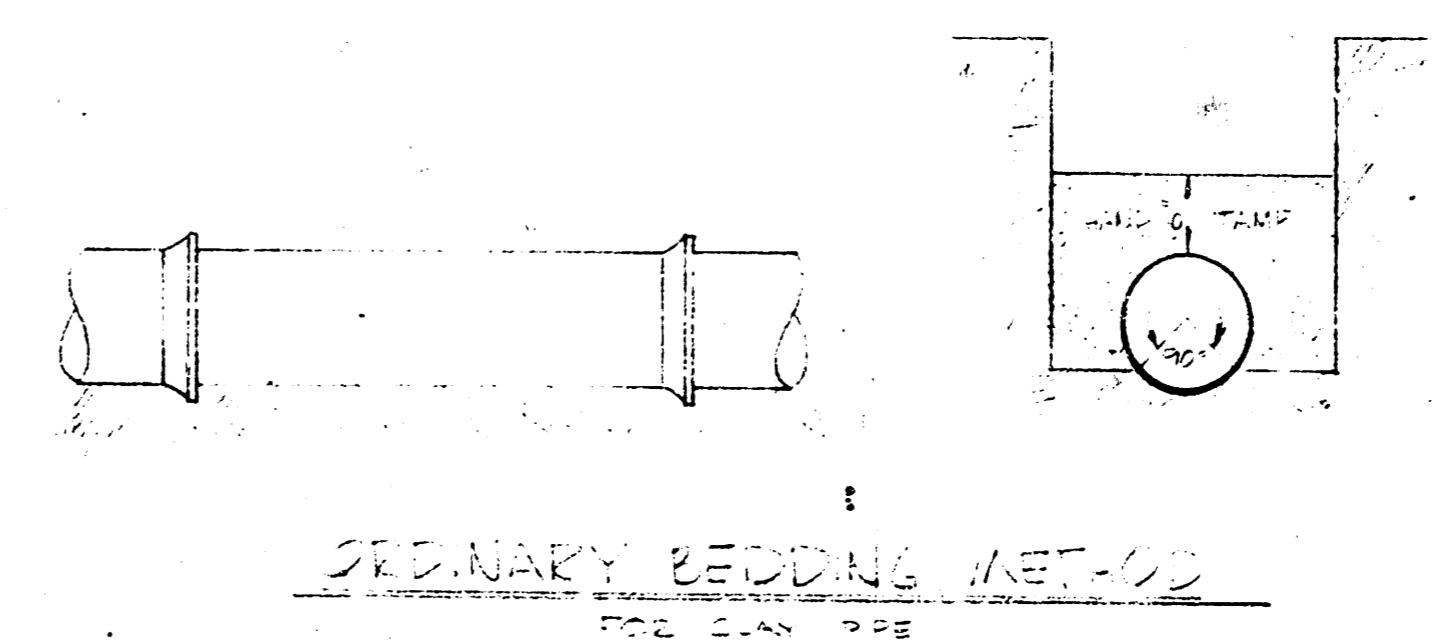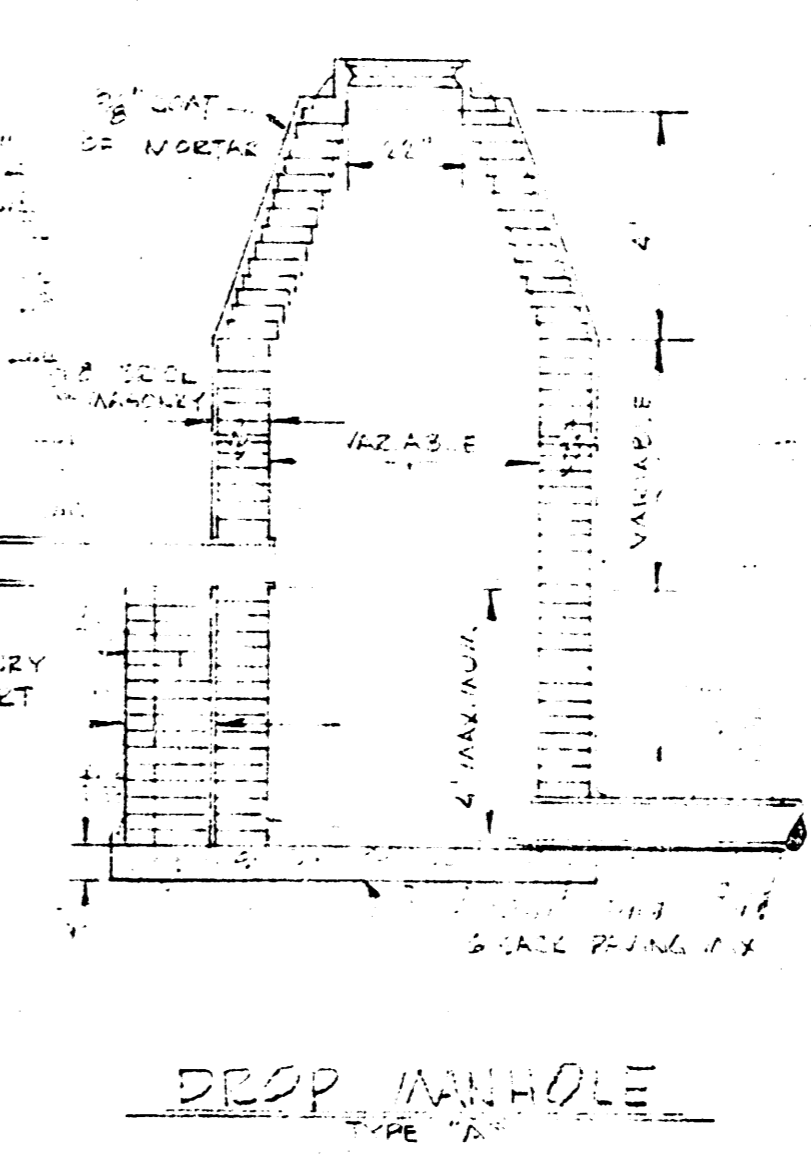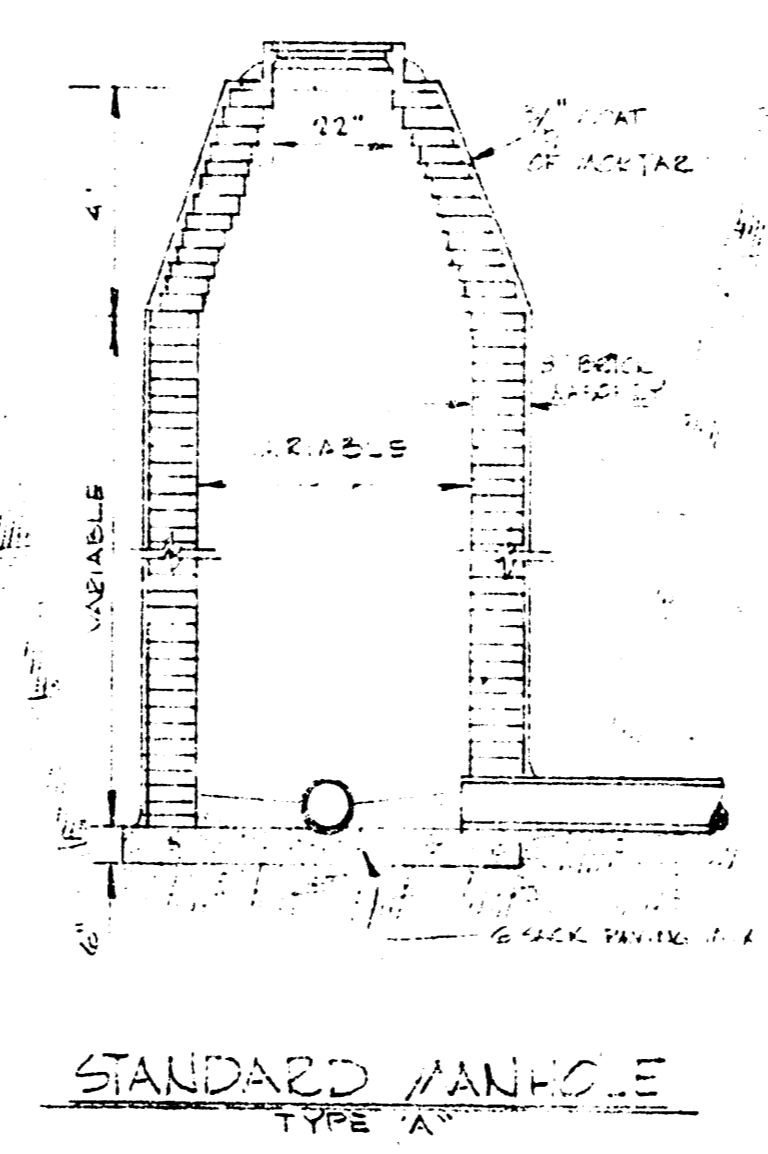


Note: THE CONCRETE USED FOR MORTAR IN MANHOLES SHALL CONTAIN 8 BAGS OF CEMENT PER CUBIC YARD. STANDARD MANHOLES AND DEEP MANHOLES, SPANDED BACK OF DIAMETER SHALL BE 8\"/>

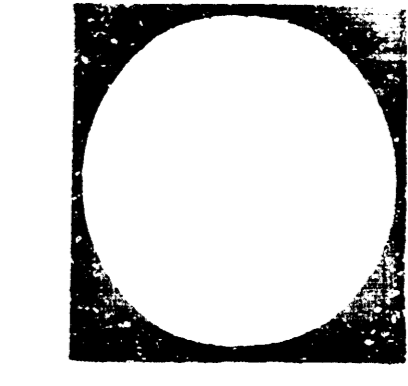


LeRoy D. Bradford A.I.A.
Lawrence F. Smith A.I.A.
C. Stewart Shepherd


BRADFORD, SMITH & SHEPHERD Architects
BLUE RIDGE TOWER, SUITE 720, 4240 BLUE RIDGE BLVD., KANSAS CITY, MO. 64133

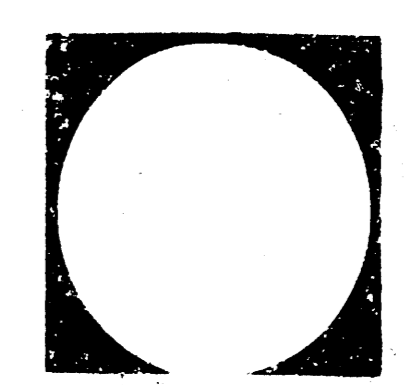

Revisions	Date	Job No.	Job Name	Sheet Title
				SANITARY SEWER DETAILS

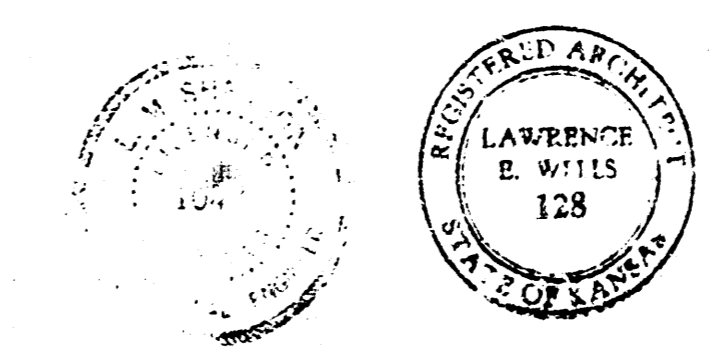


Approved: *Lawrence F. Smith*
2/2/29

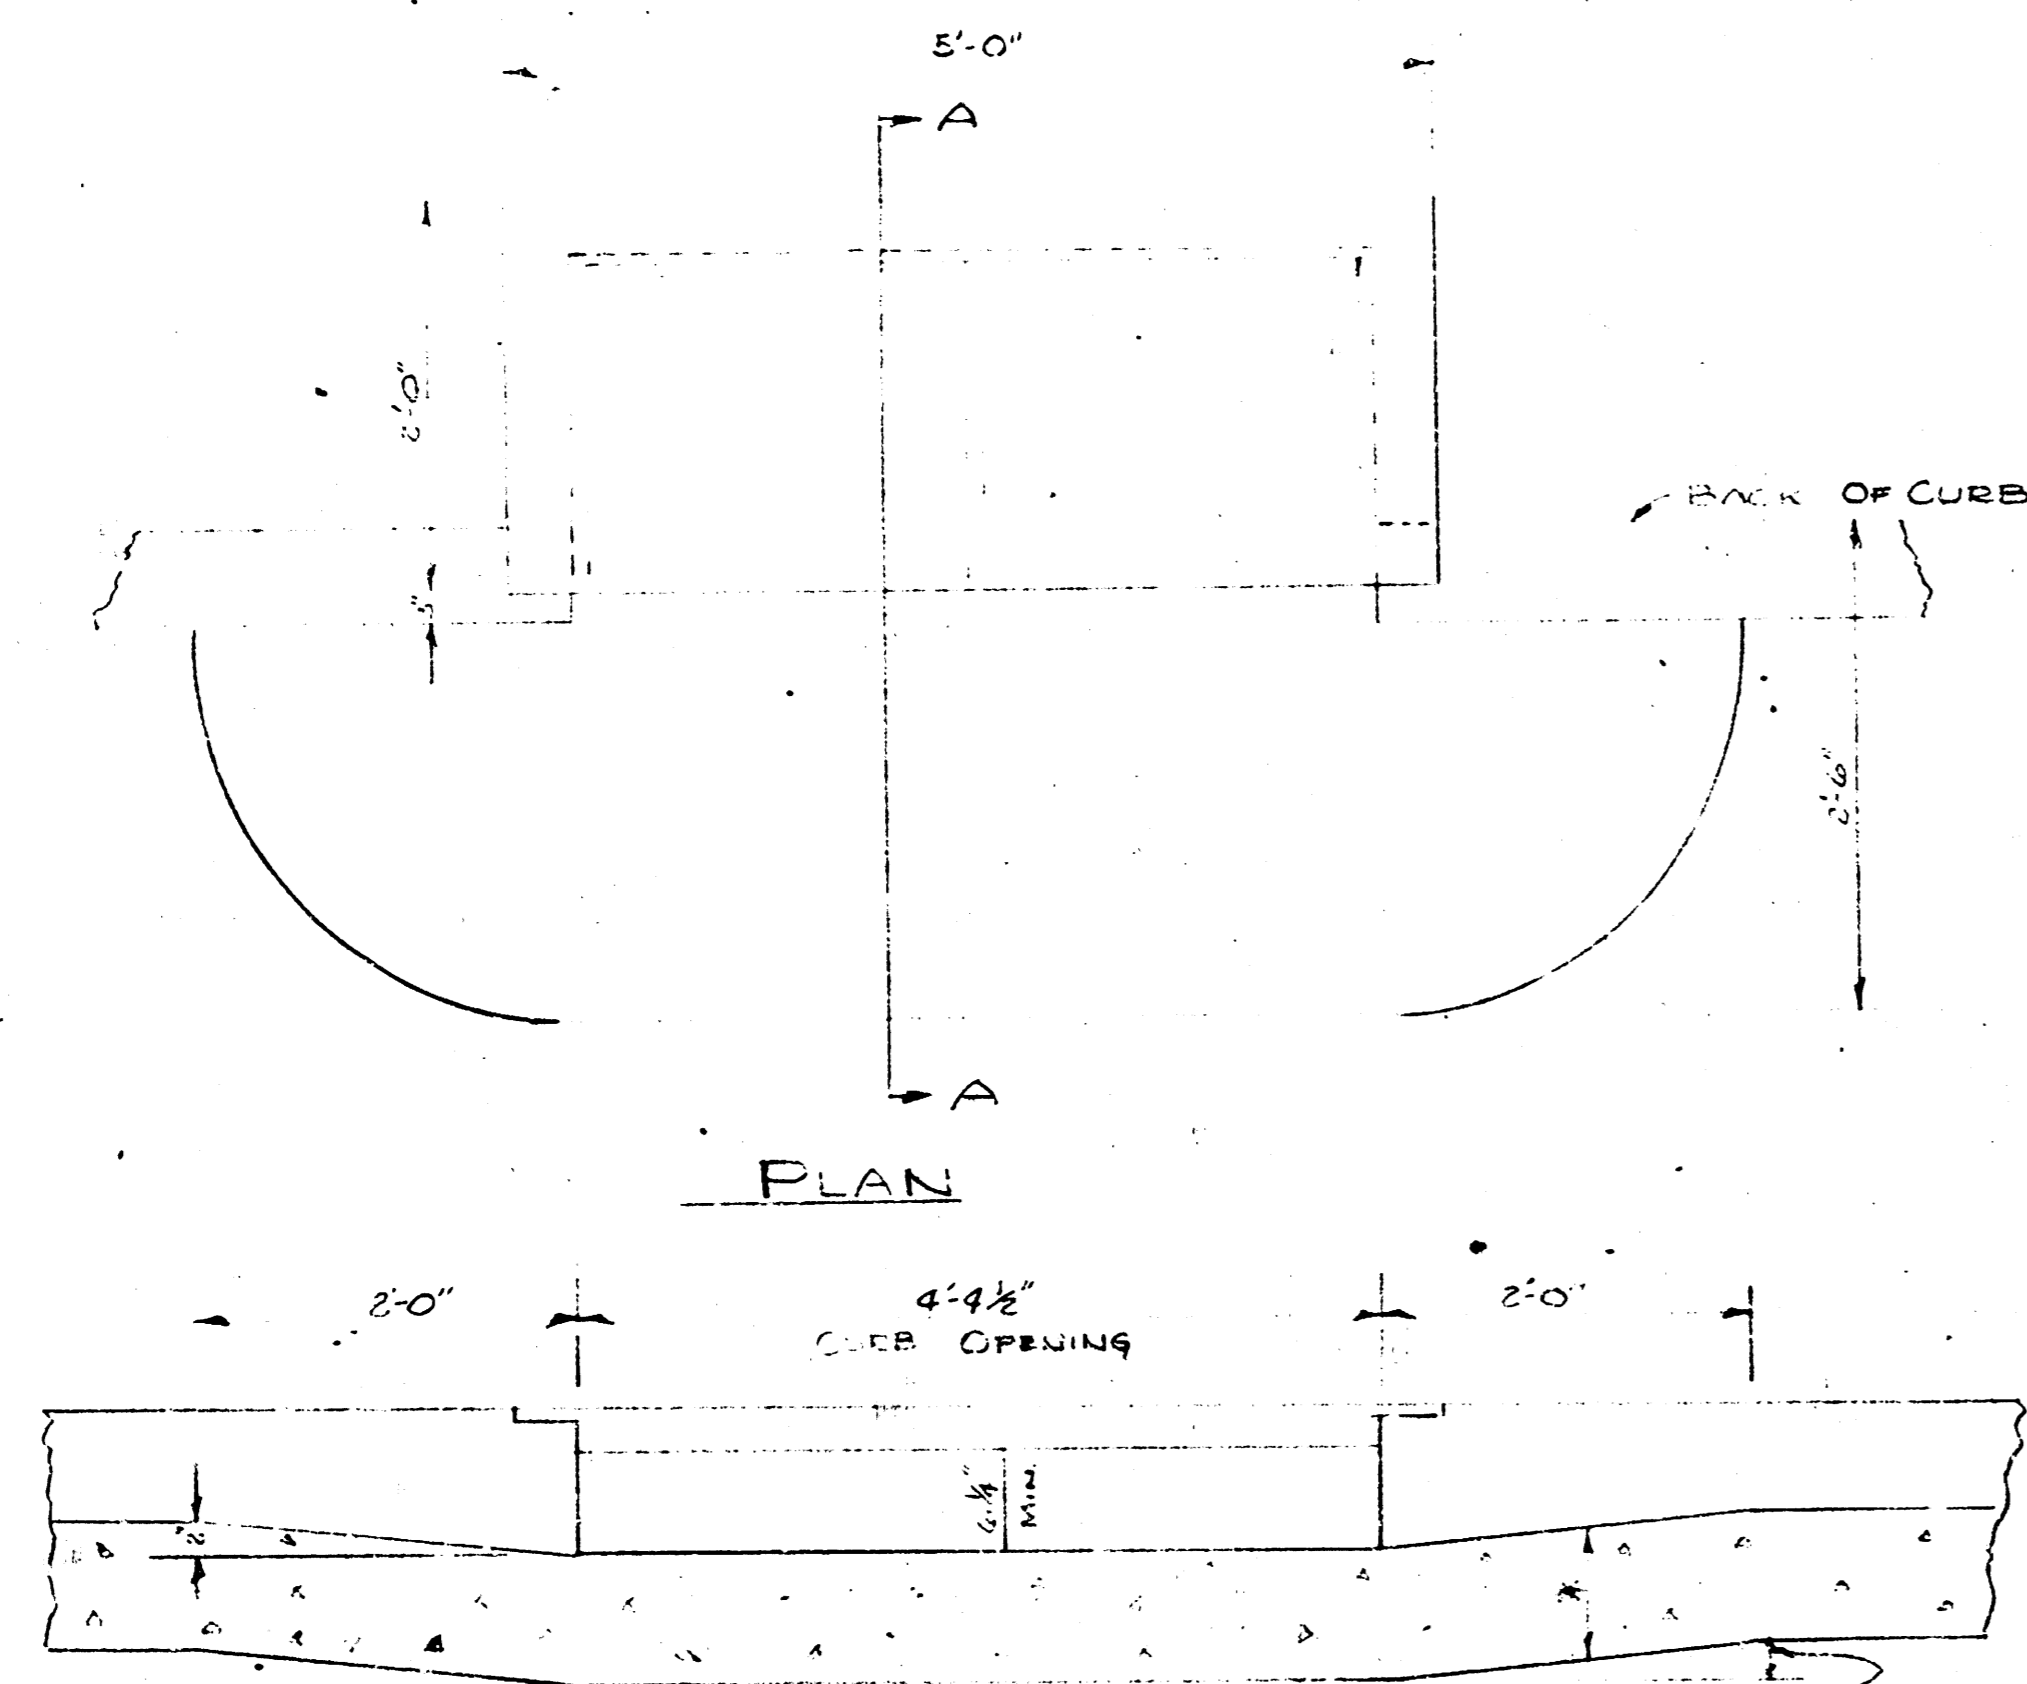


PLAN

ELEVATION

SUBGRADE TO BE SHAPED TO ALLOW FOR DEPRESSION IN PAVEMENT.

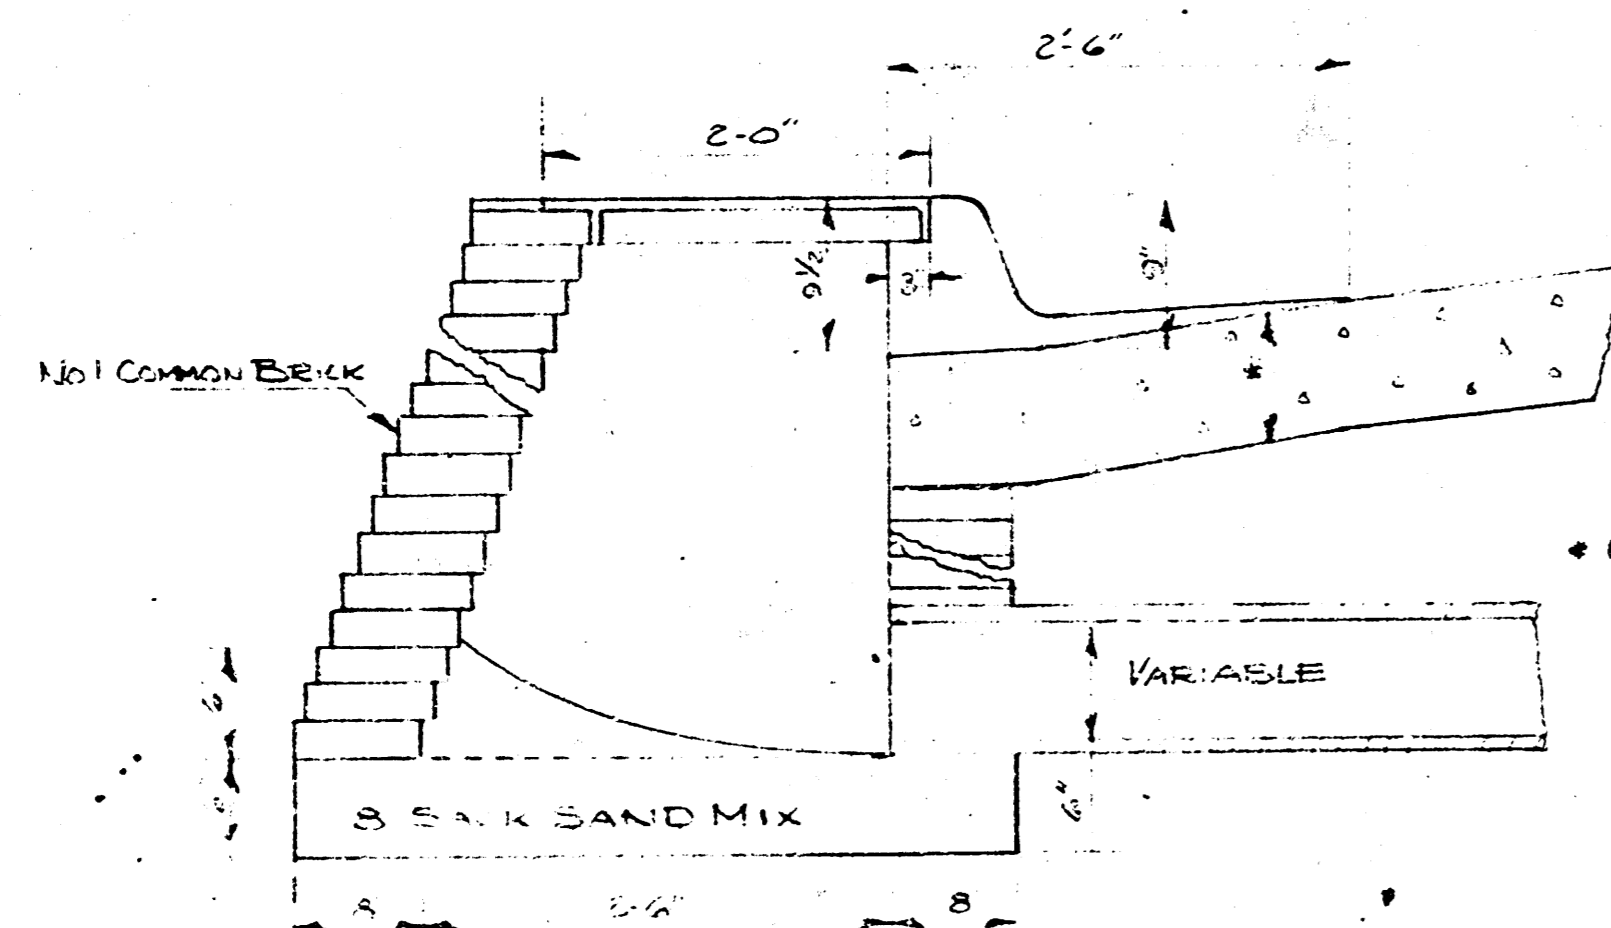


SECTION A-A

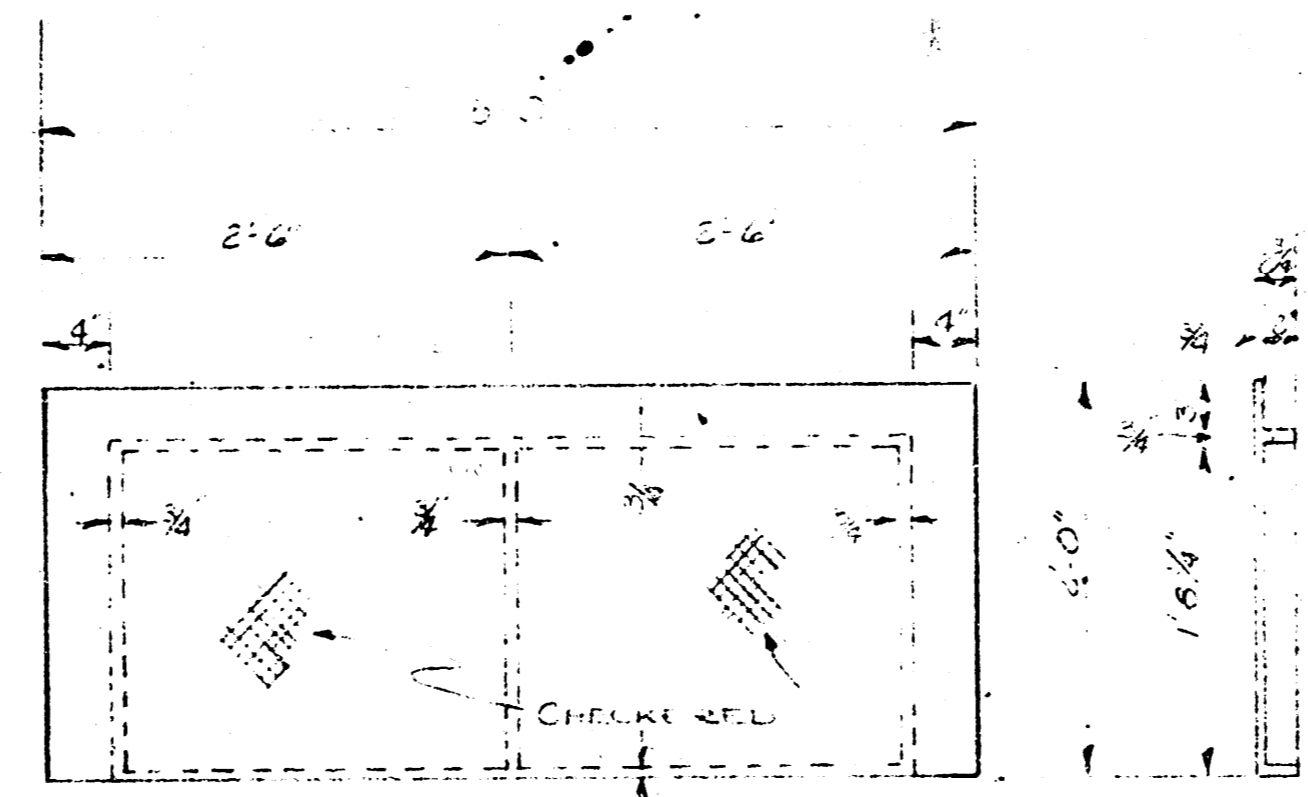


PLAN

SECTION

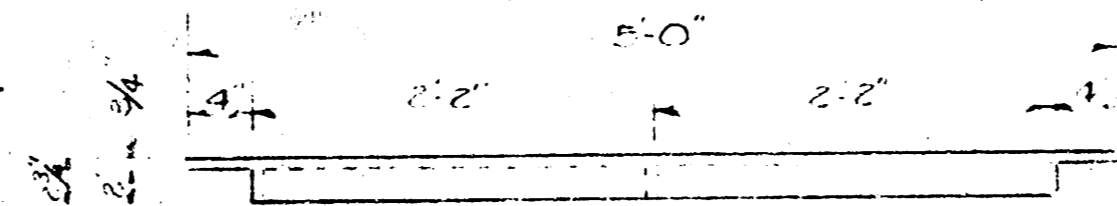


ELEVATION

CAST IRON INLET COVER
WEIGHT 1325#

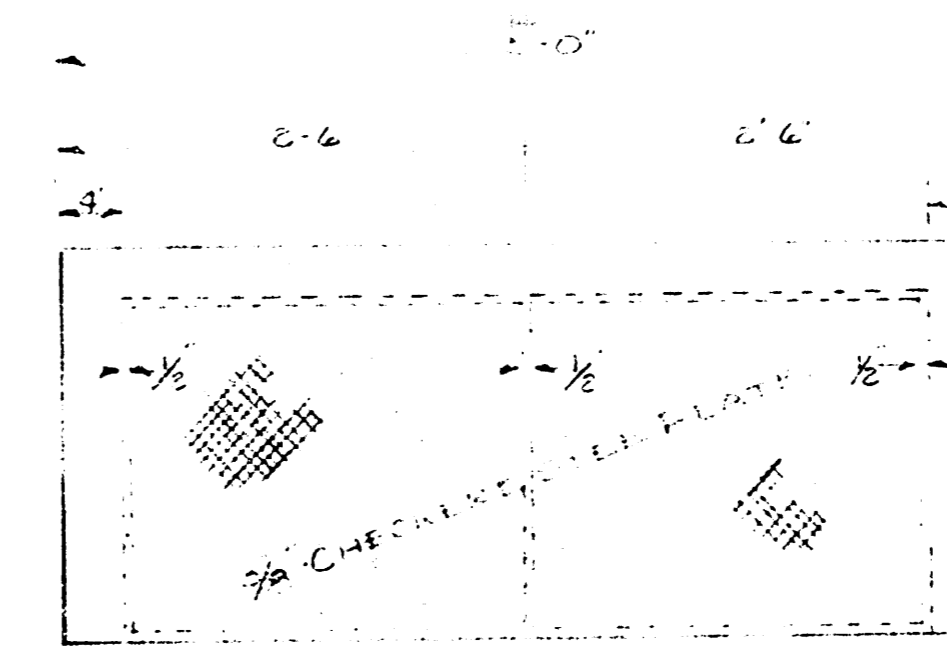

PLAN

 
SECTION



ELEVATION


SITE INLET COVER
WEIGHT 6200#
SPECIAL ORDER 450# EACH

STANDARD 2' x 5' INLET
SCALE 1/4" = 1'-0"

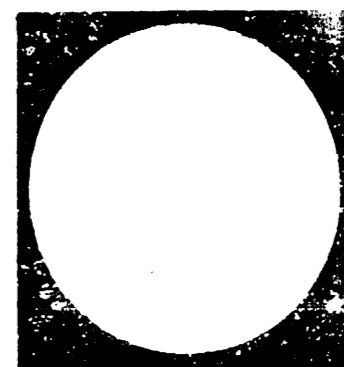

LeRoy D. Bradford A.I.A.
Lawrence E. Smith A.I.A.
C. Stewart Shepherd



BRADFORD, SMITH & SHEPHERD Architects
BLUE RIDGE TOWER, SUITE 720, 4240 BLUE RIDGE BLVD., KANSAS CITY, MO. 64133

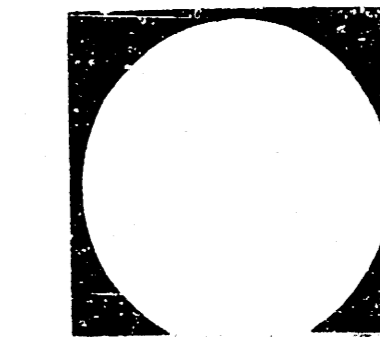


THIS CONTRACT
will be construed
in accordance with
the specifications
of the CITY ENGINEER
of the CITY OF WICHITA. THE CON-
TRACTOR will reimburse the City of
Wichita for all cost of
inspection.

Approved
8/2/07

Revisions	Date	Job No.	Job Name	Sheet Title
				STORM SEWER- DETAILS STANDARD 2' x 5' INLET

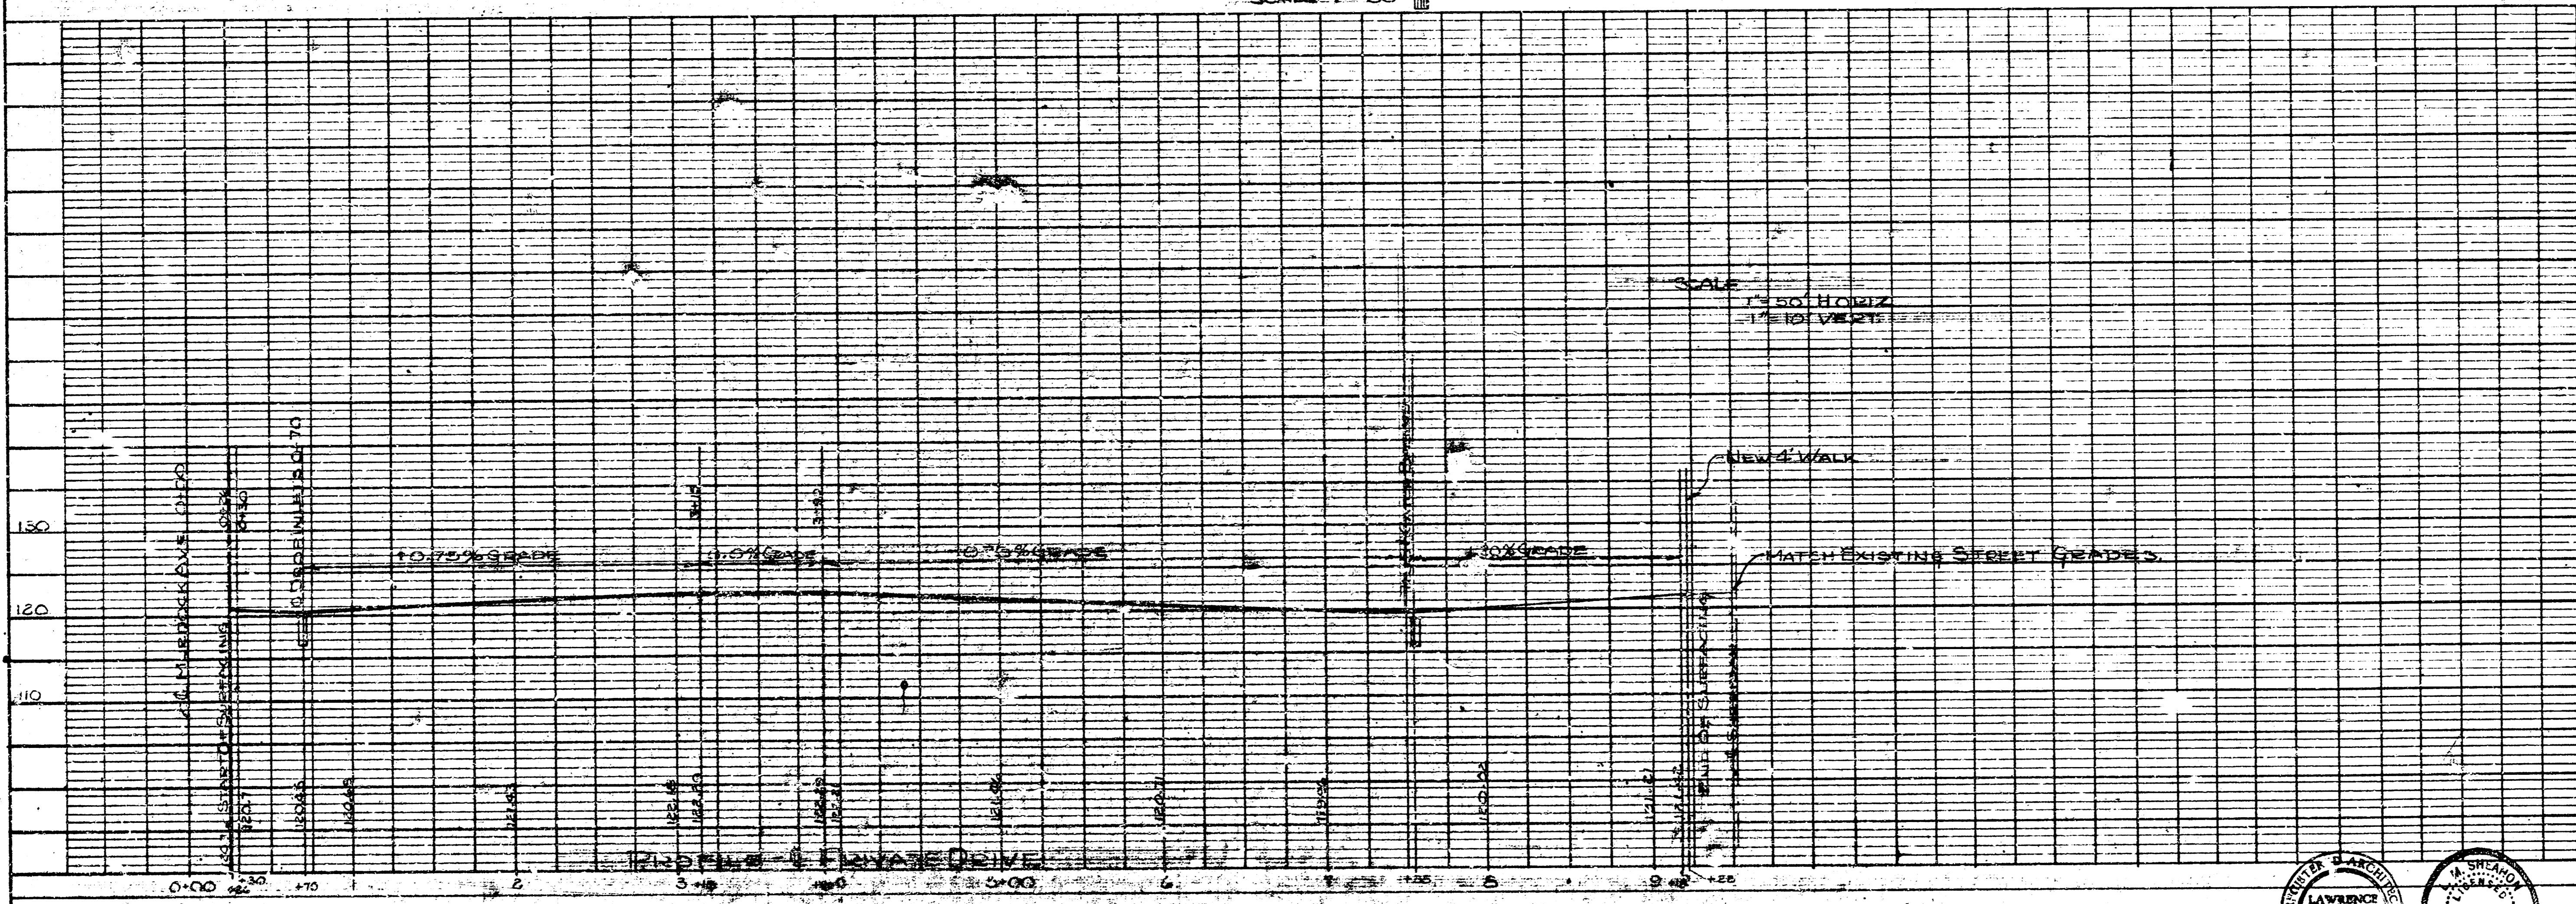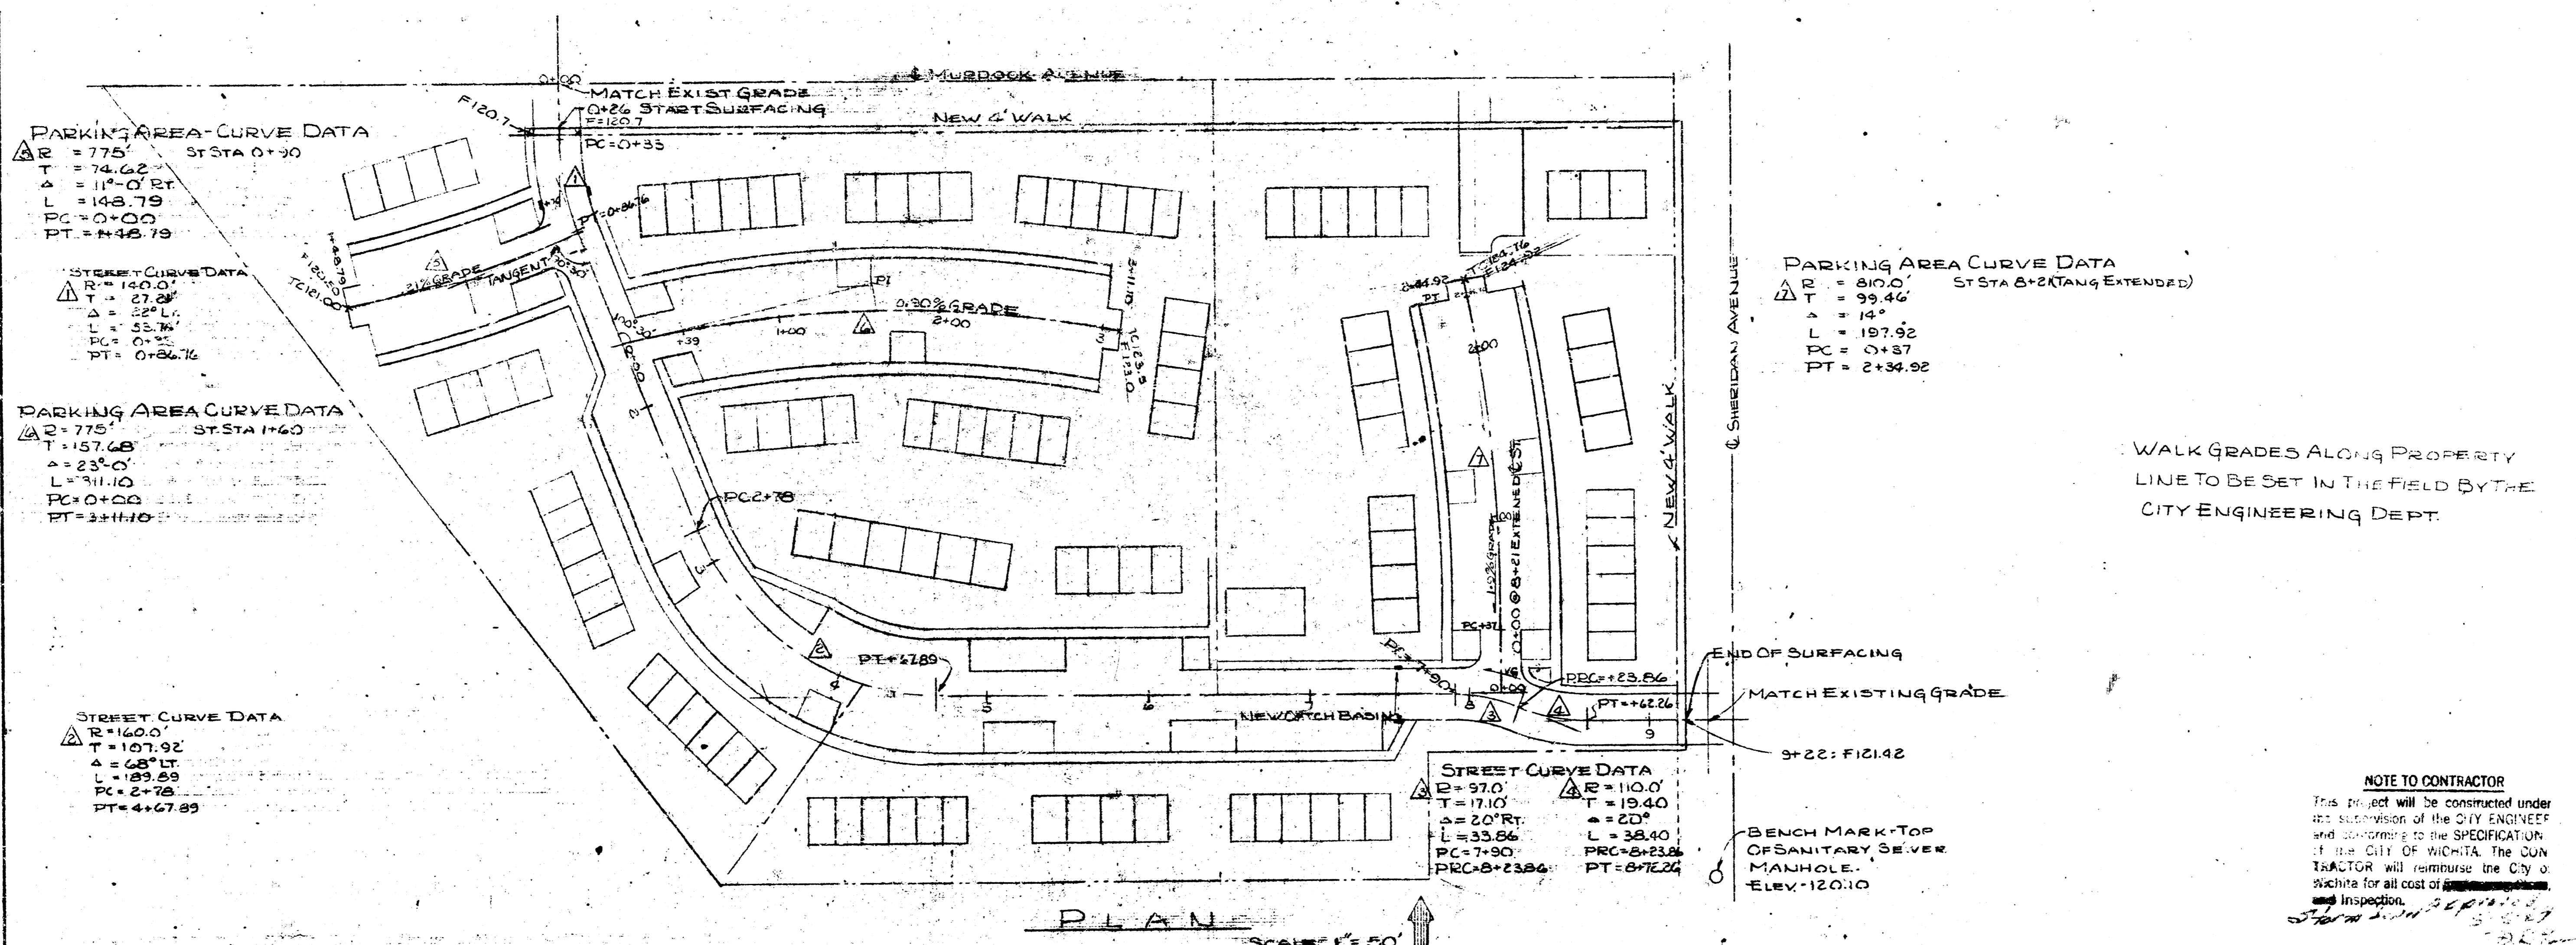


Revisions	Date	Job No.	Job Name	Sheet Title


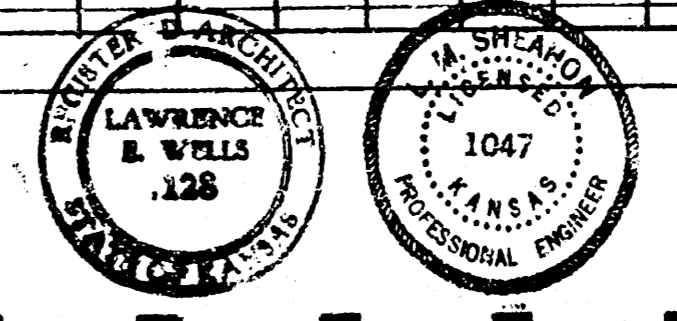


LeRoy D. Bradford A.I.A.
 Lawrence F. Smith A.I.A.
 C. Stewart Shepherd
BRADFORD, SMITH & SHEPHERD Architects
 BLUE RIDGE TOWER, SUITE 720, 4240 BLUE RIDGE BLVD., KANSAS CITY, MO. 64133


DRIVE - PLAN & PROFILE

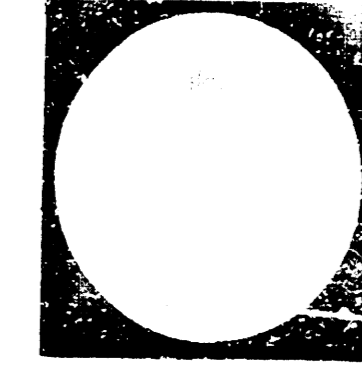



LeRoy D. Bradford A.I.A.
 Lawrence F. Smith A.I.A.
 C. Stewart Shepherd

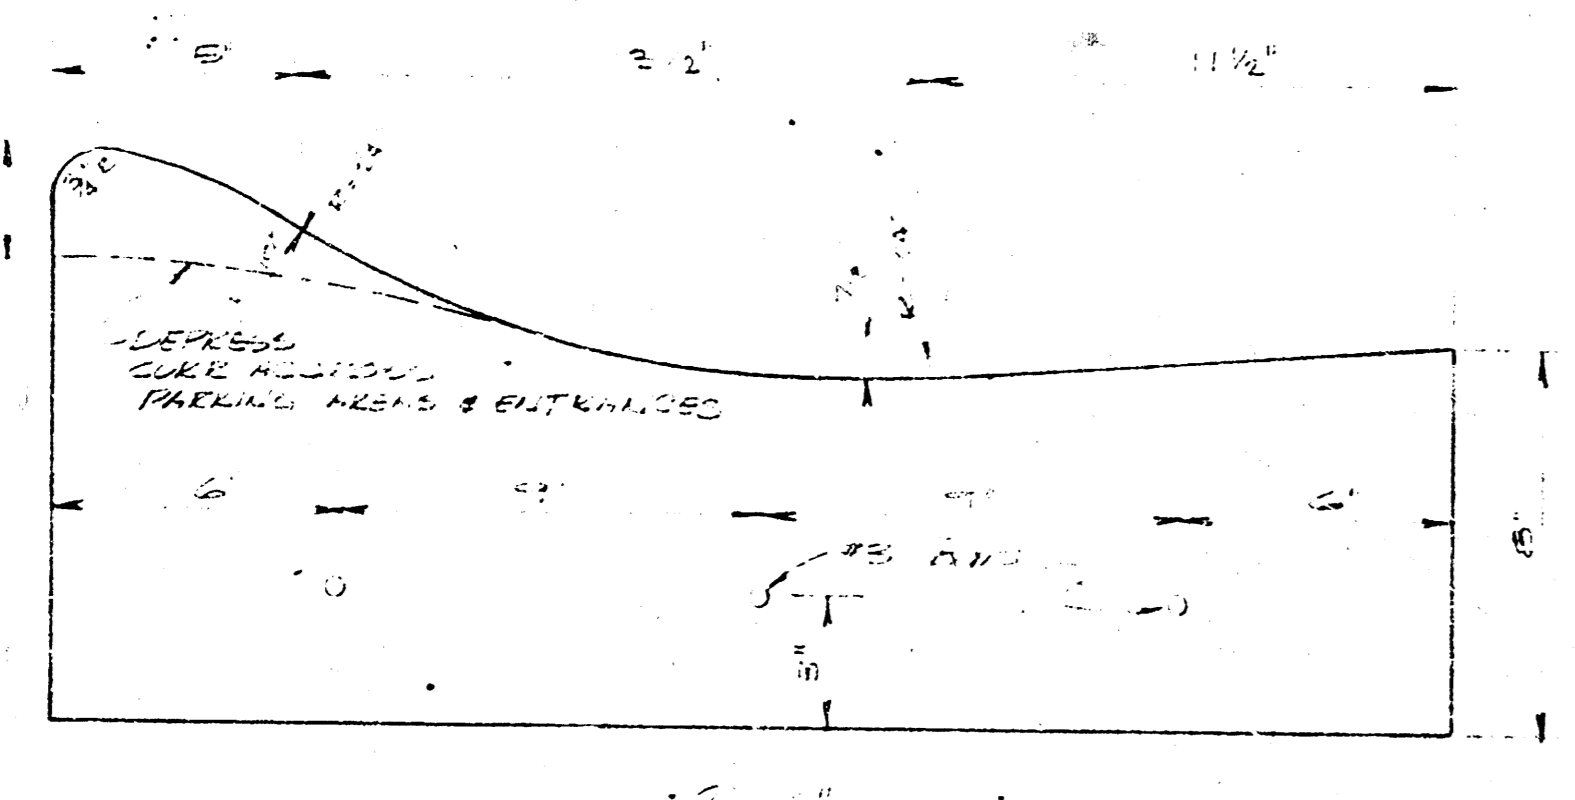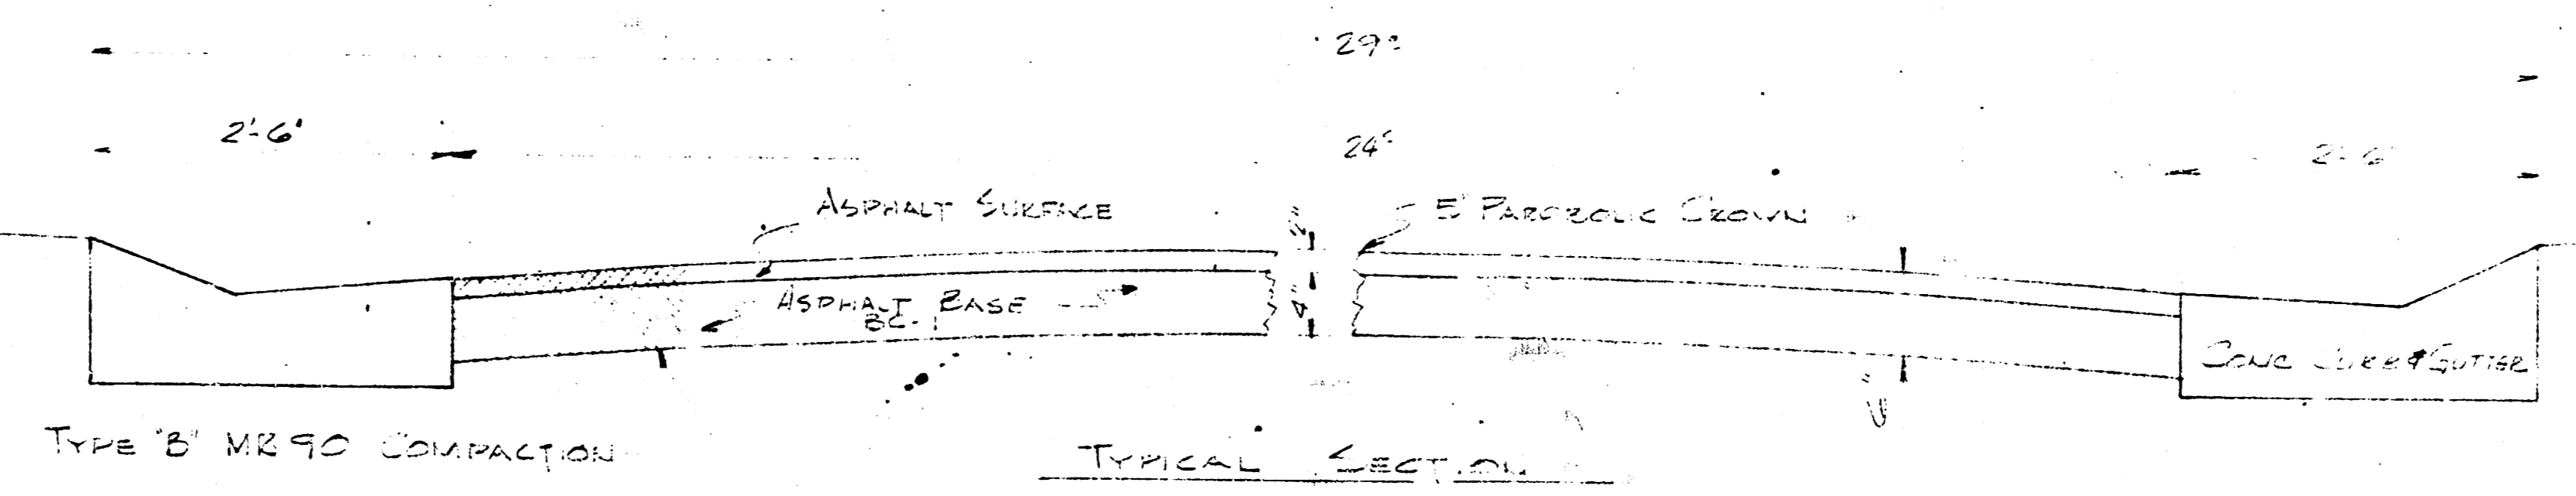


THIS CURB TO BE INSTALLED ALONG ALL EXTERIOR DRIVEWAYS AND DRIVE ENTRANCES SHALL CONFORM TO ALL PARKING CURBS.

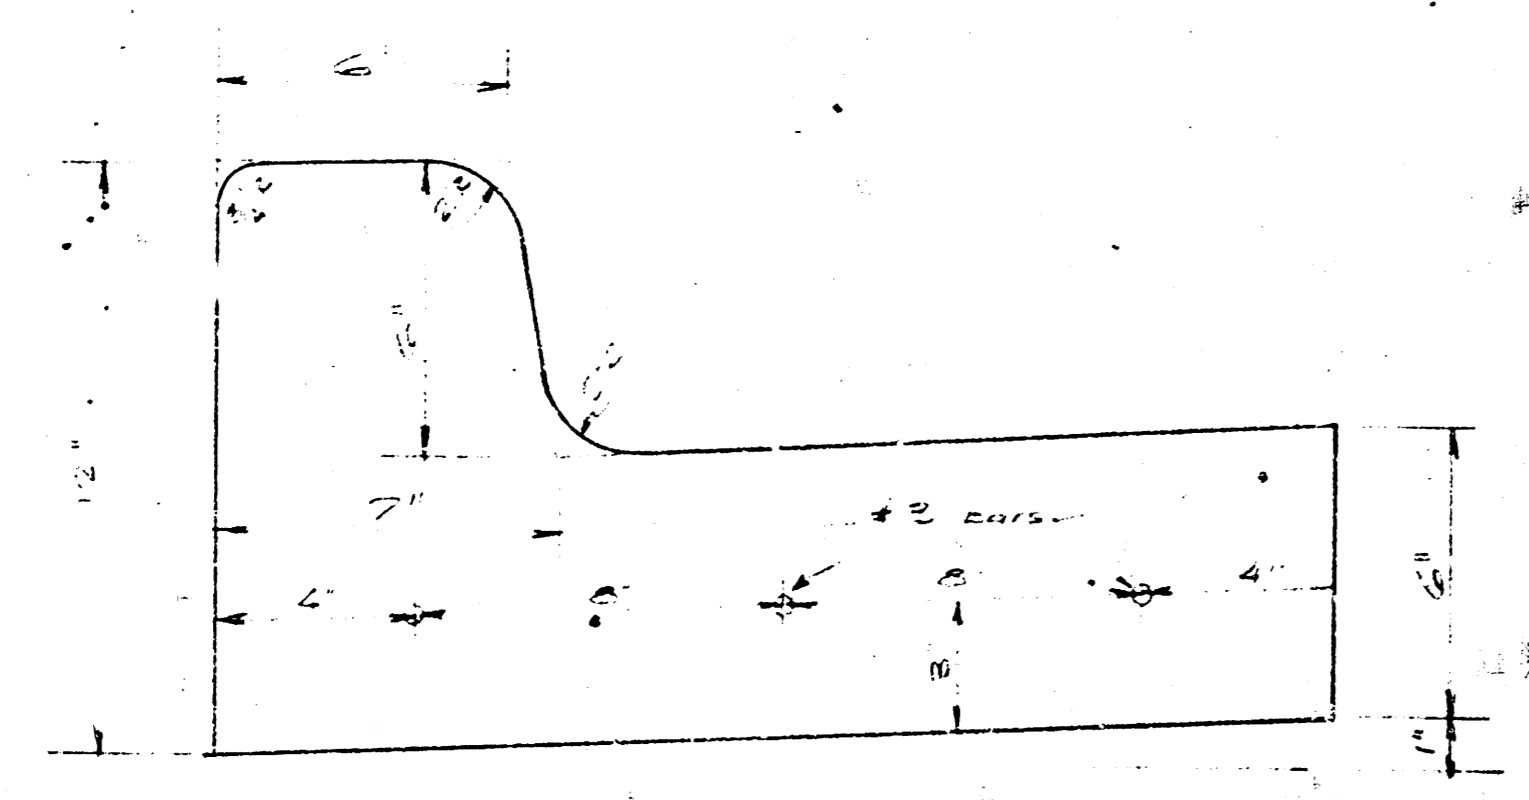

To be used along all parking areas

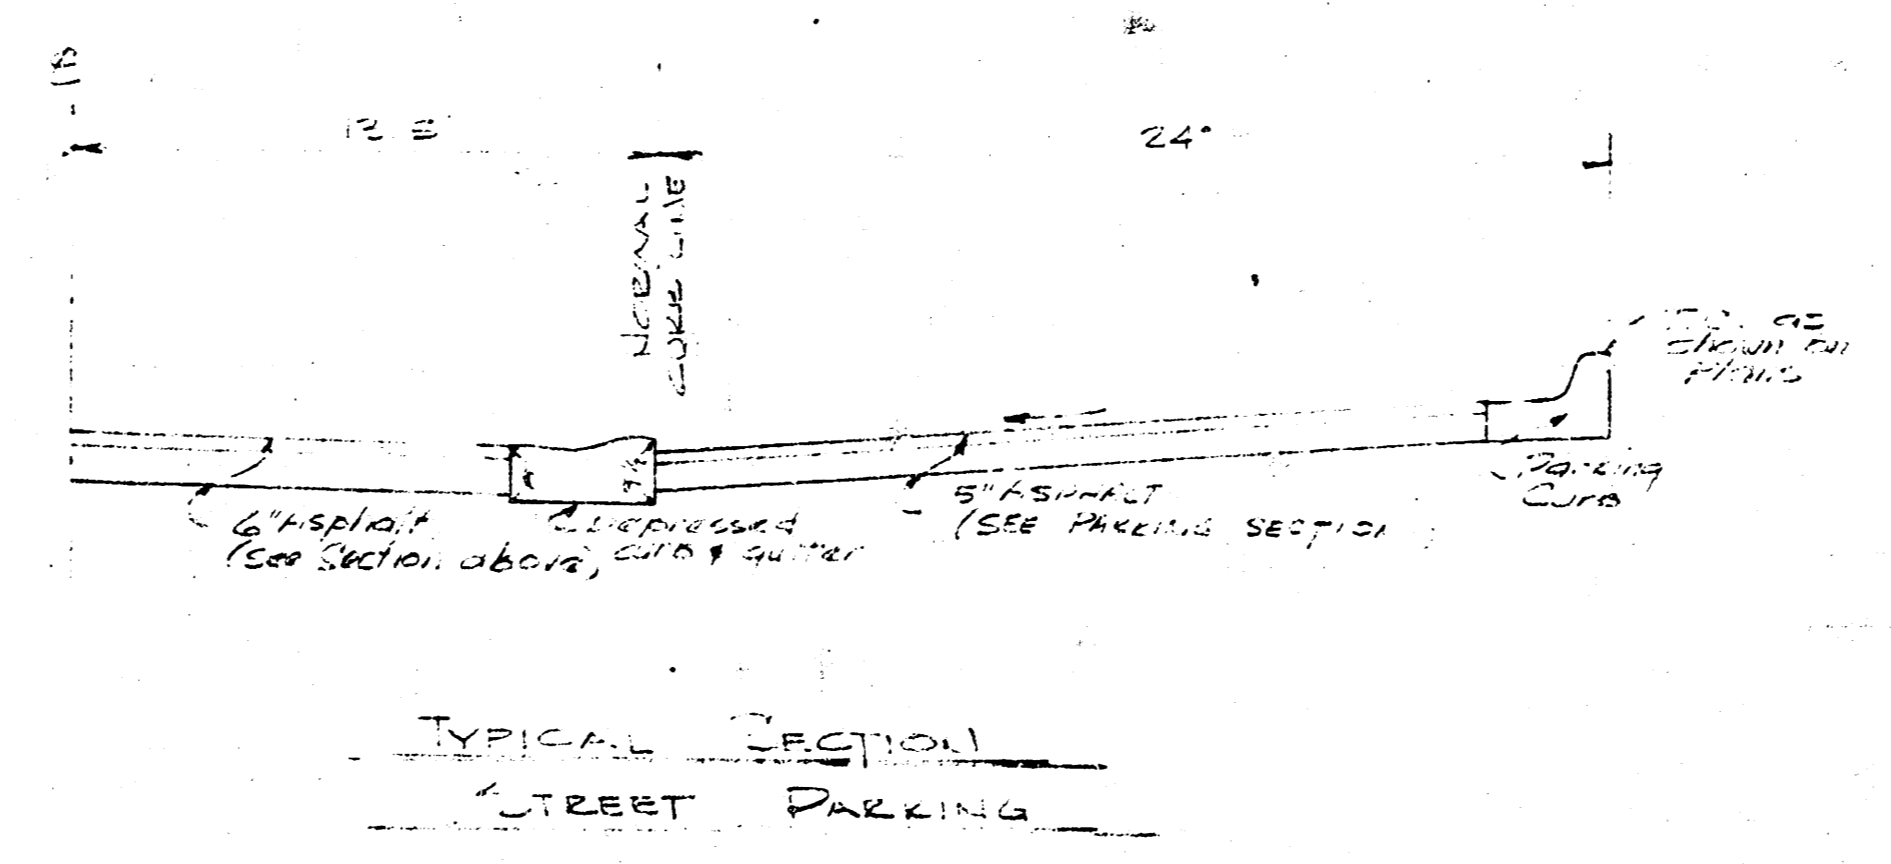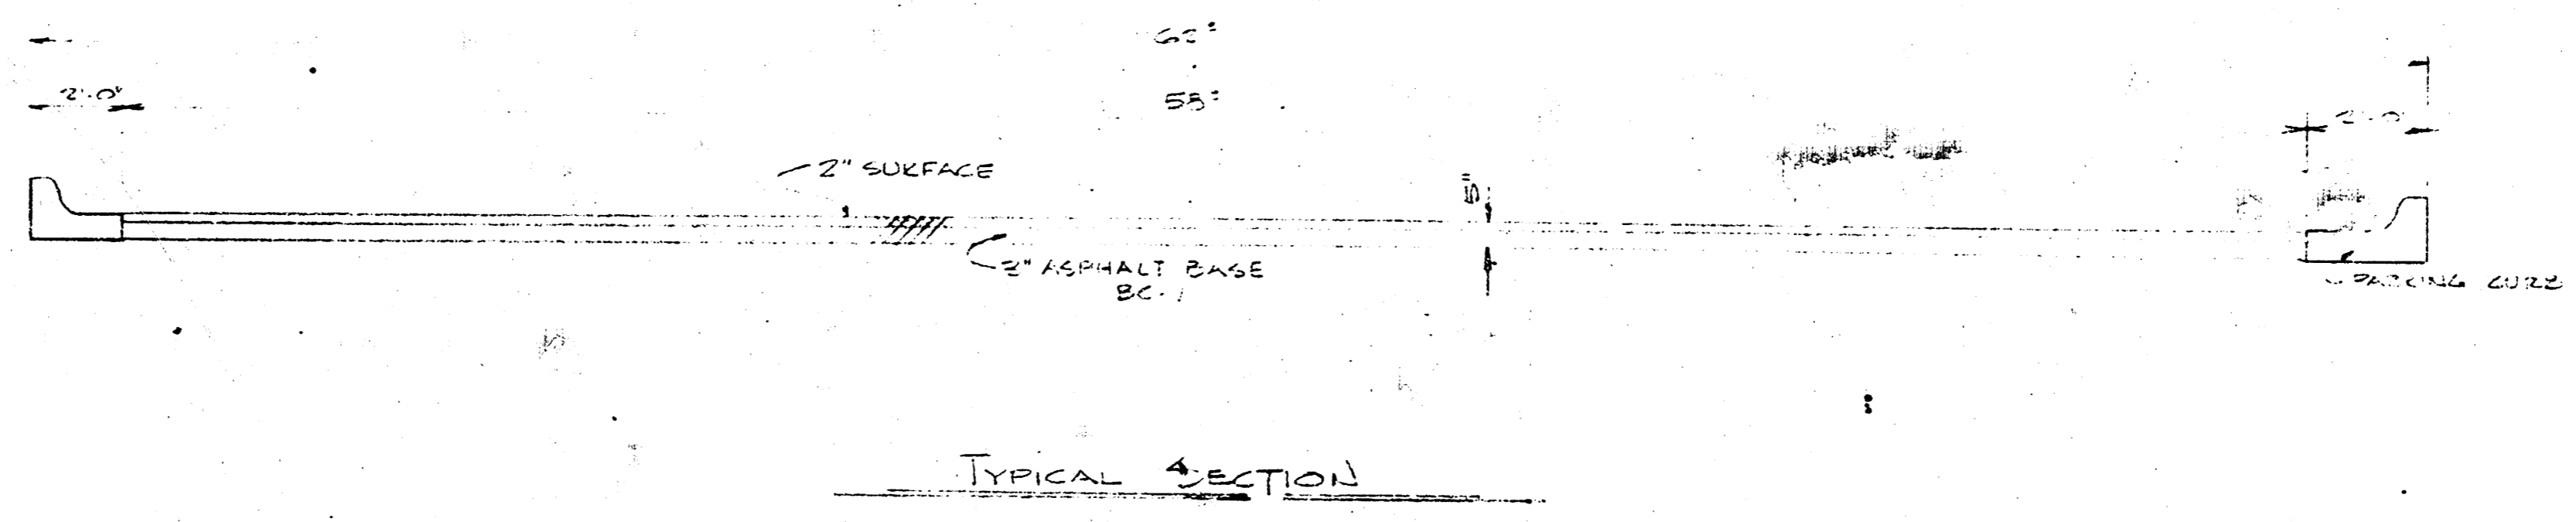

BRADFORD, SMITH & SHEPHERD Architects
 BLUE RIDGE TOWER, SUITE 720, 4240 BLUE RIDGE BLVD., KANSAS CITY, MO. 64133

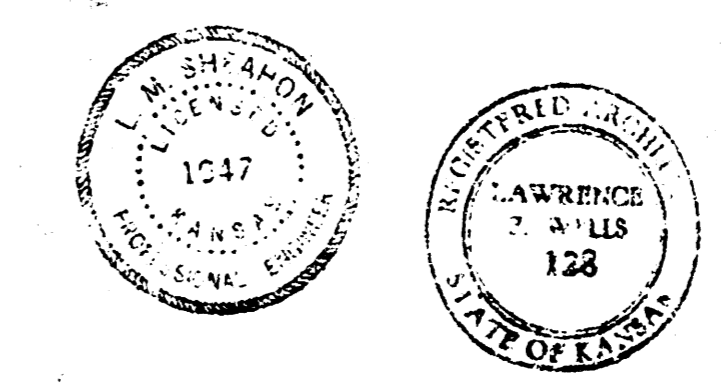

Revisions	Date	Job No.	Job Name	Sheet Title

DRIVE, PARKING & CURB DETAILS

