
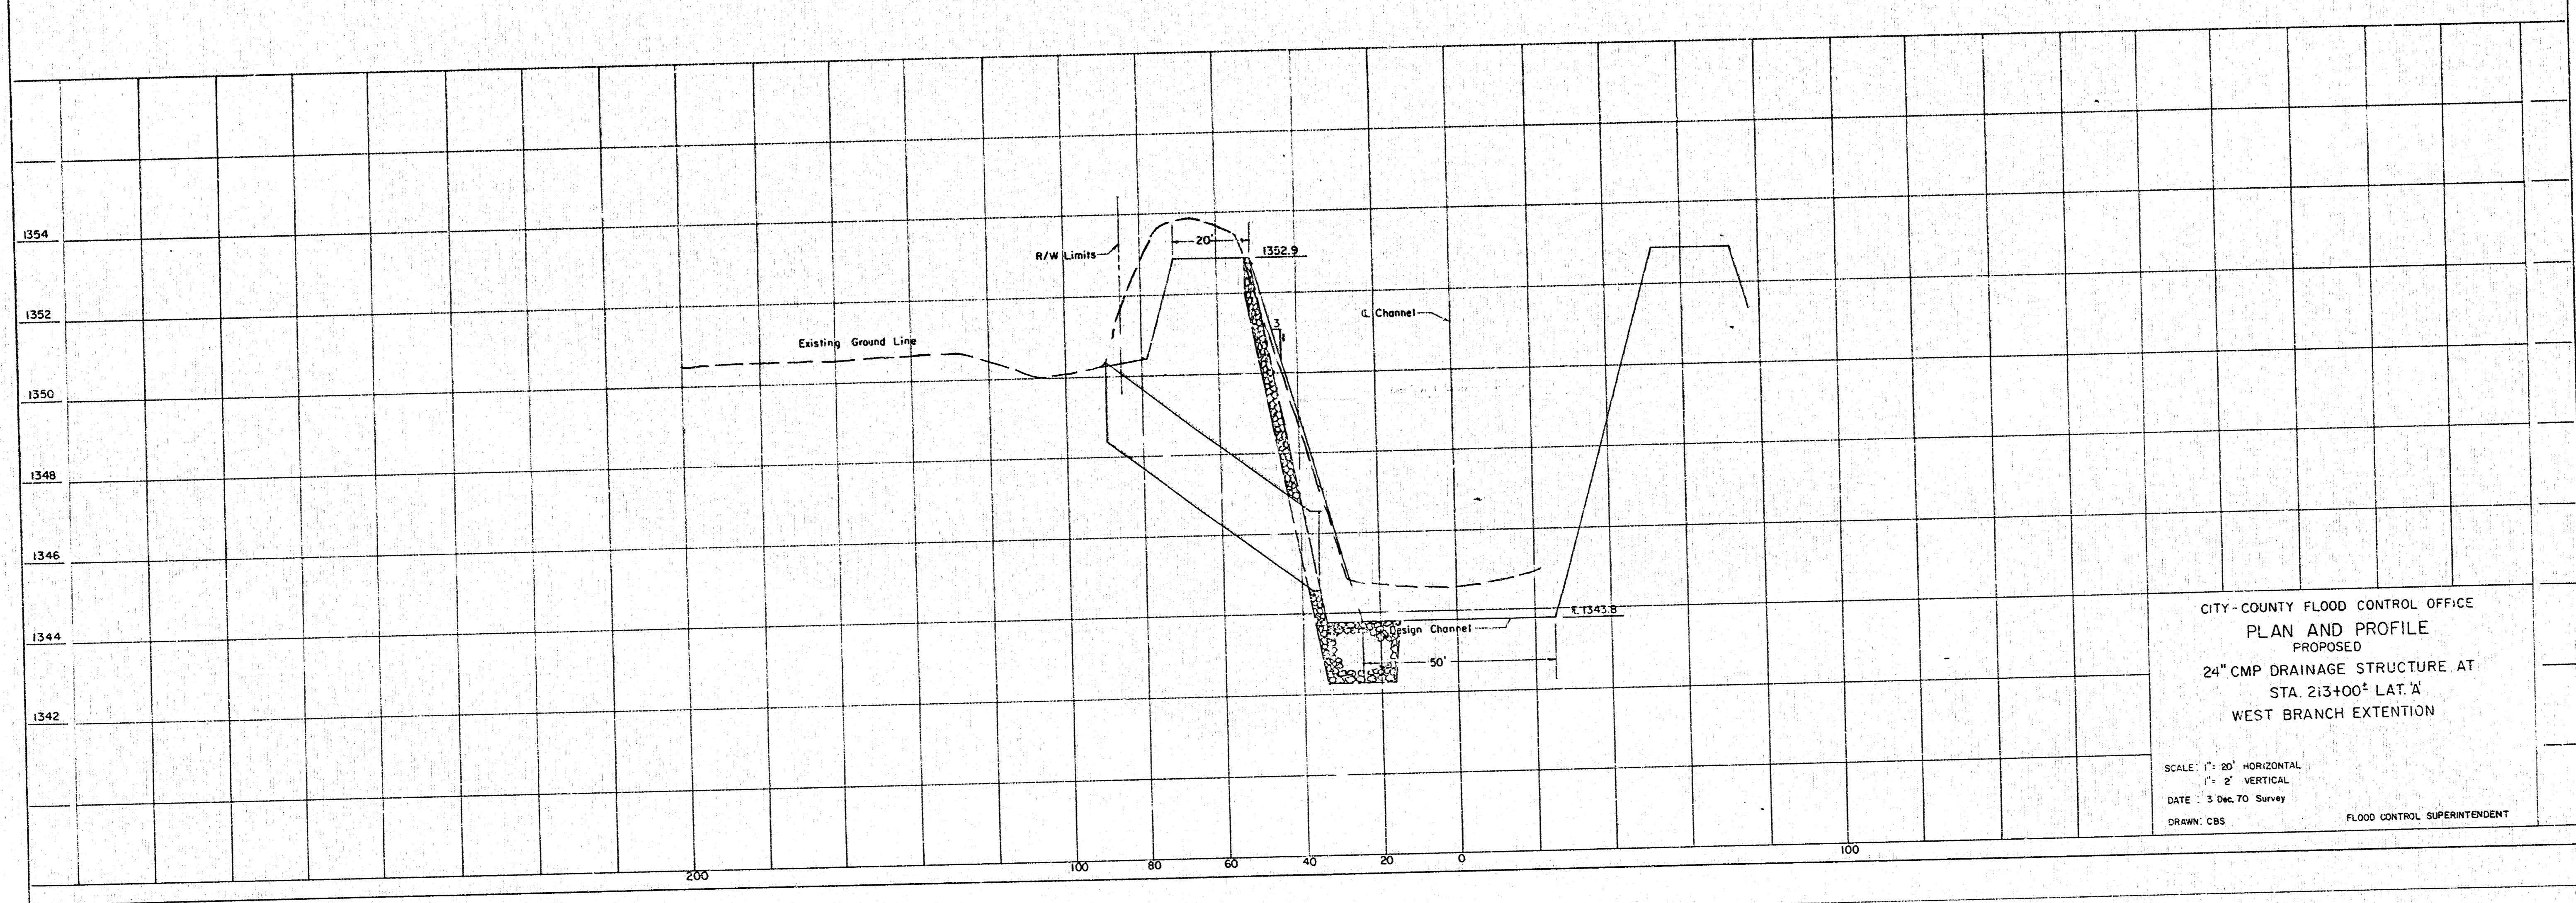


CITY-COUNTY FLOOD CONTROL OFFICE
 PLAN AND PROFILE
 PROPOSED
 48" DRAINAGE STRUCTURE
 STA. 1031+30 LEVEE 'K'

SCALE: 1" = 10' HORIZONTAL
 1" = 5' VERTICAL
 DATE: JUNE 1971
 DRAWN: WDI
 FLOOD CONTROL SUPERINTENDENT

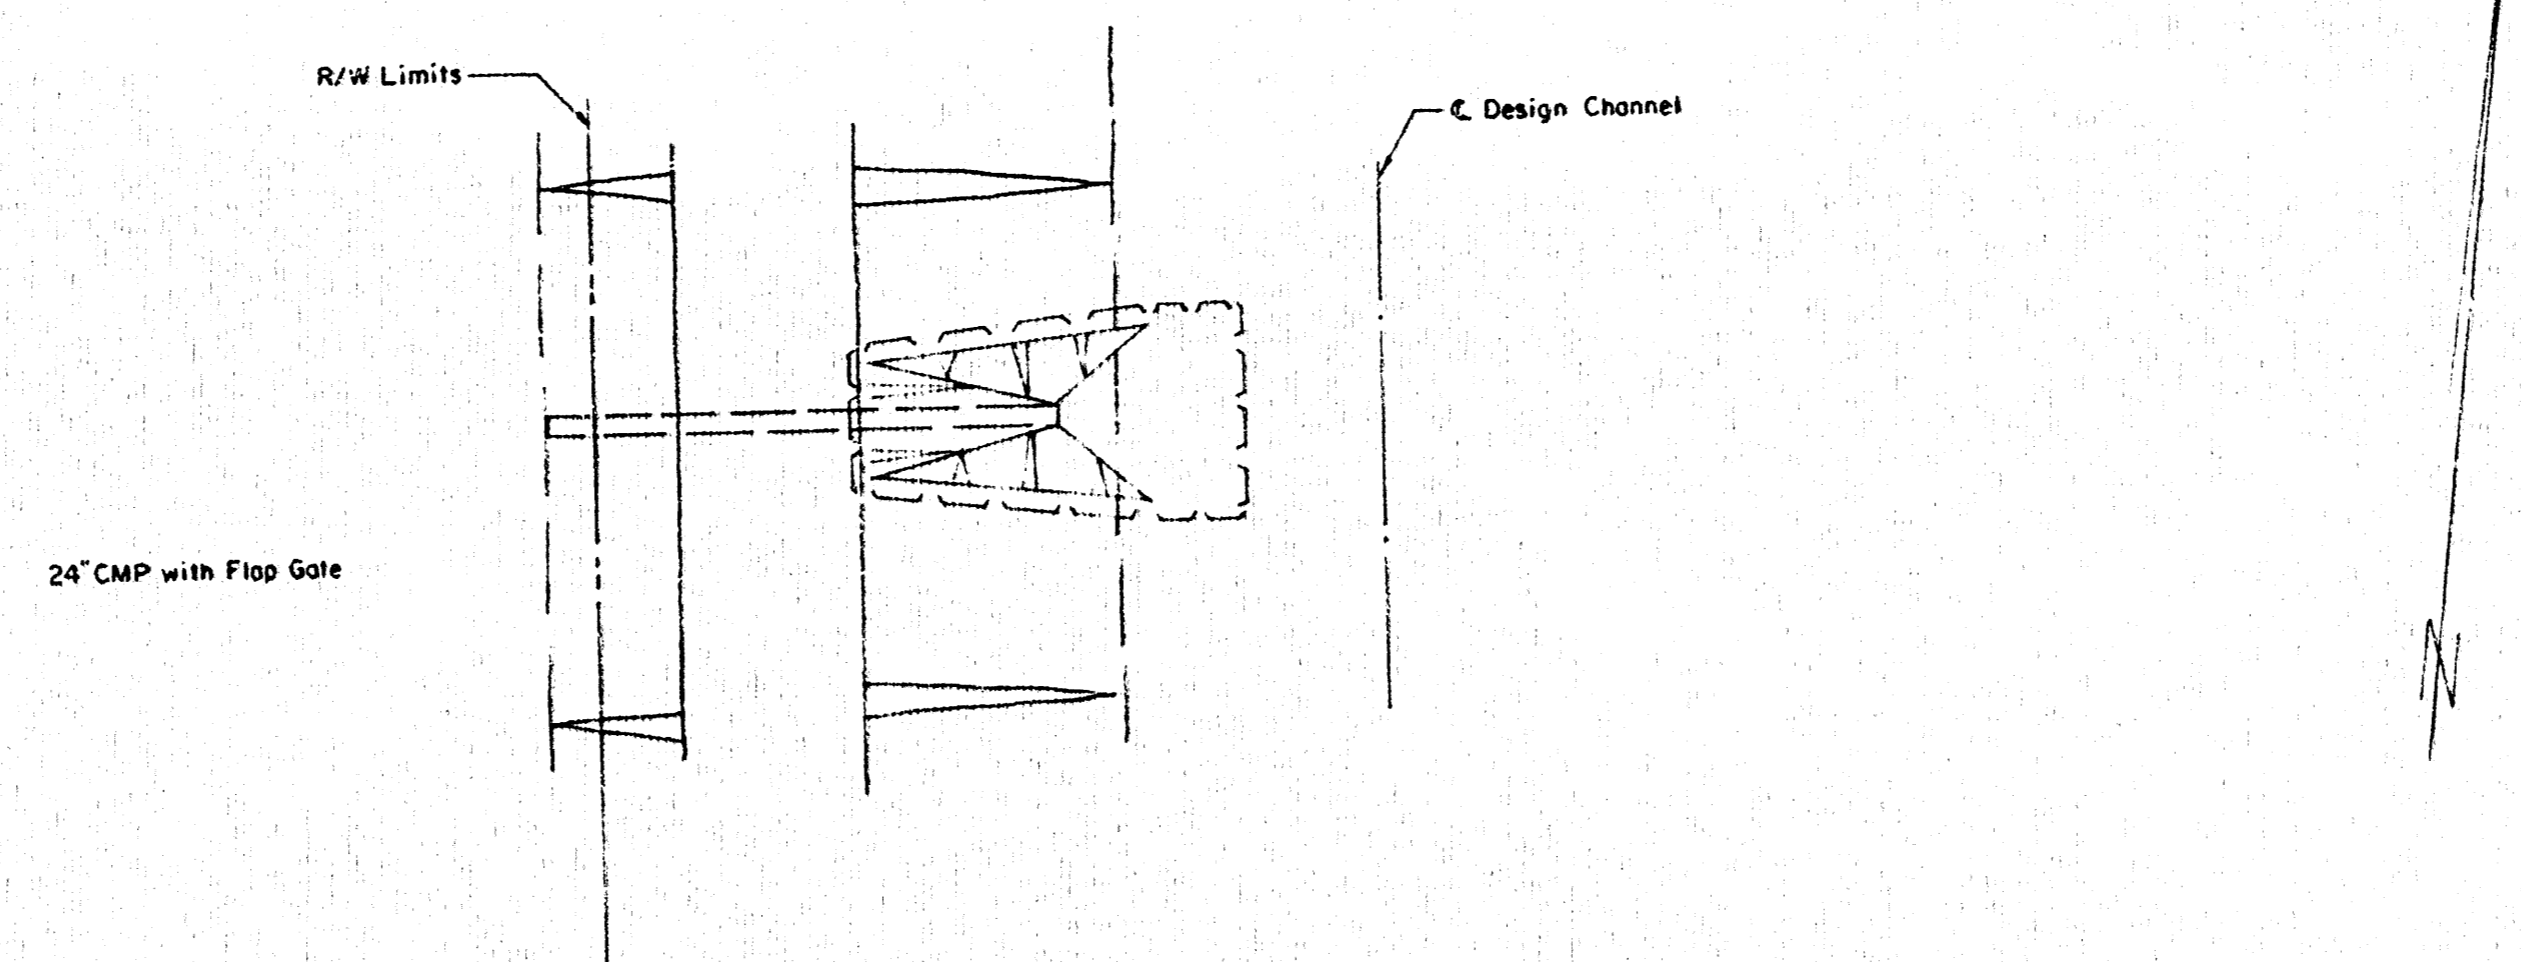

CITY-COUNTY FLOOD CONTROL OFFICE
 PLAN AND PROFILE
 PROPOSED
 24" CMP DRAINAGE STRUCTURE AT
 STA. 213+00.0 LAT. 'A'
 WEST BRANCH EXTENTION
 SCALE: 1" = 20' HORIZONTAL
 1" = 2' VERTICAL
 DATE: 3 Dec. 70 Survey
 DRAWN: CBS FLOOD CONTROL SUPERINTENDENT