


FCBM 12.25.1944  
 City of Huey P. Long, Louisiana  
 12.25.1944

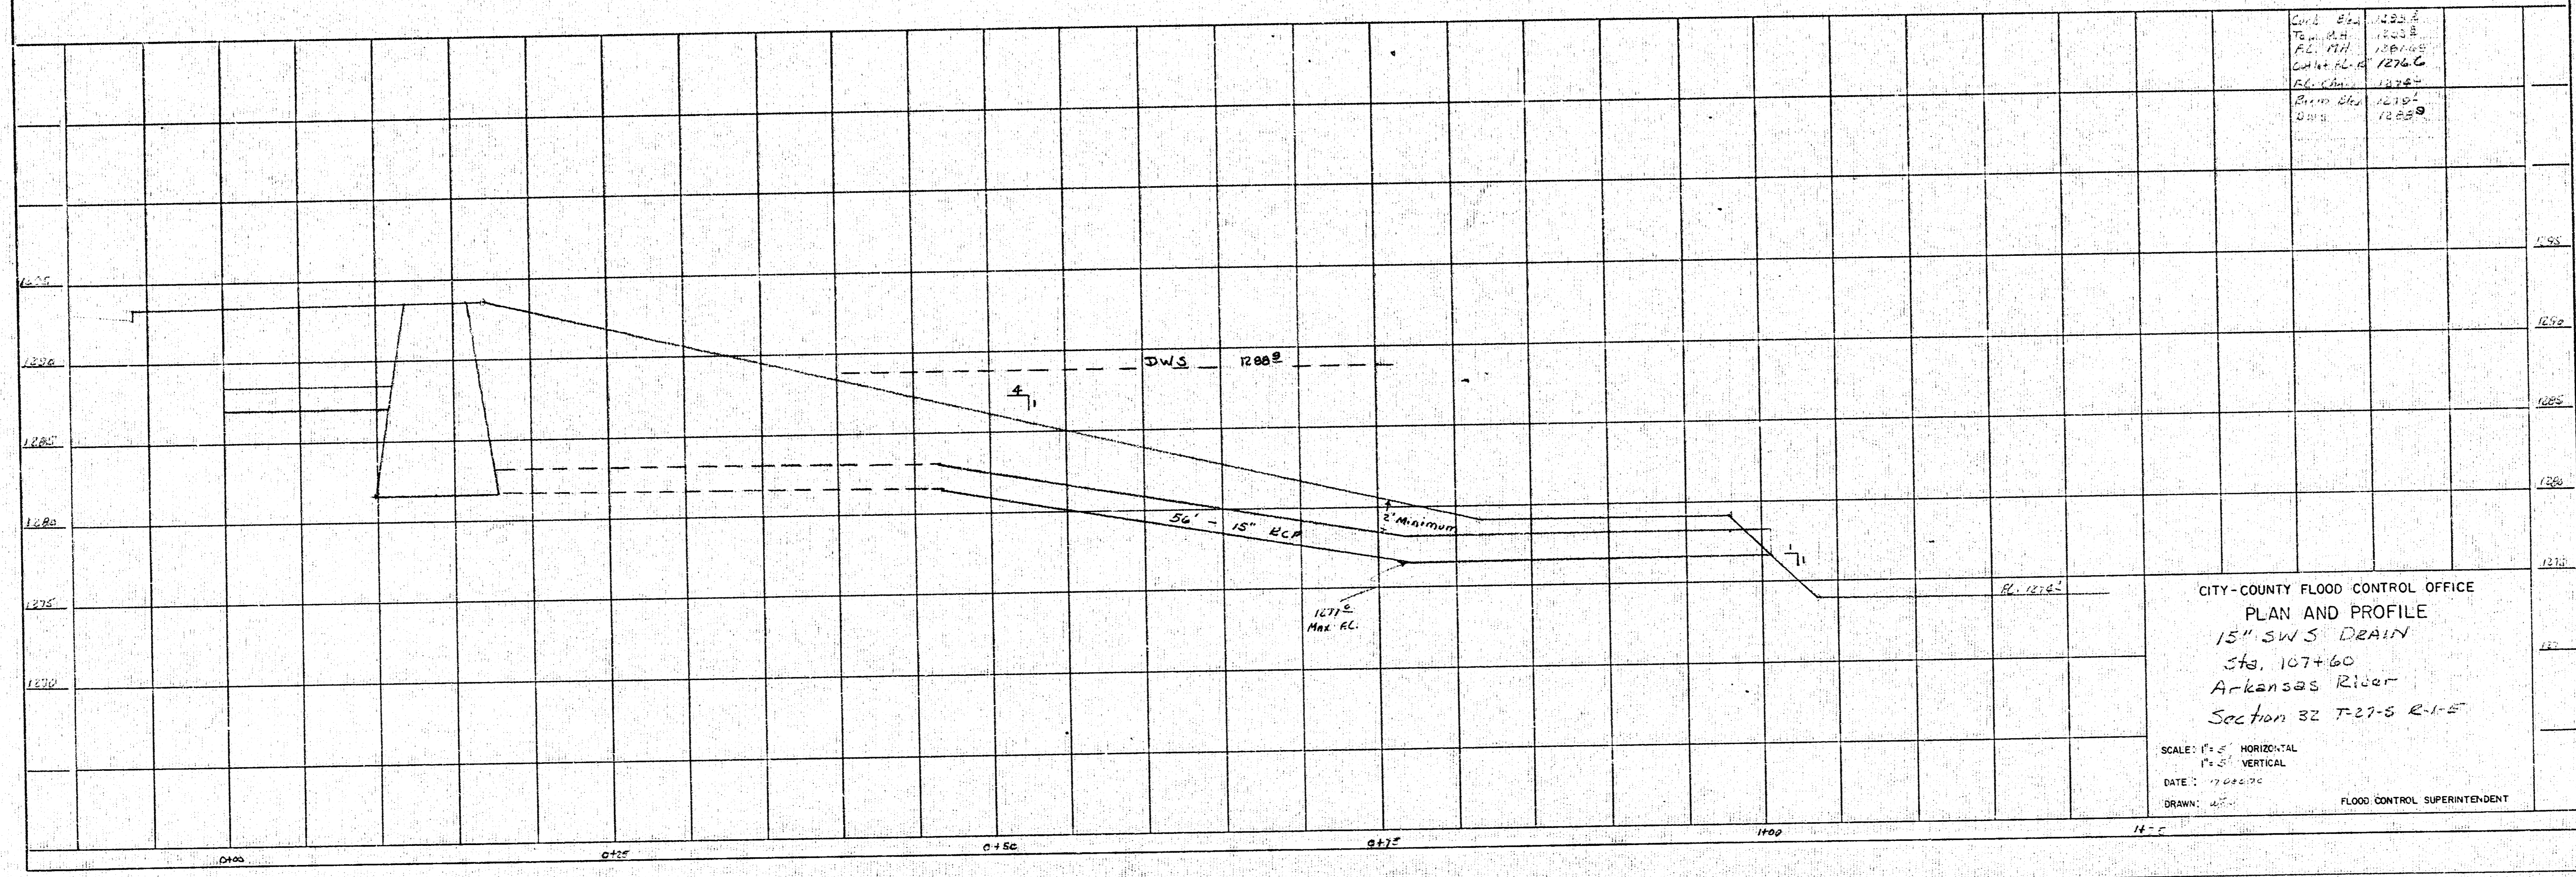

End Sta.	1200
Temp. Sta.	1200
FC. Sta.	1200
Water Sta.	1200
Bottom Sta.	1200
Bottom Sta.	1200
Bottom Sta.	1200

CITY-COUNTY FLOOD CONTROL OFFICE  
 PLAN AND PROFILE  
 15" SW S DRAIN  
 Sta. 107+60  
 Arkansas River  
 Section 32 T-27-S R-1-E

SCALE: 1" = 40' HORIZONTAL  
 1" = 5' VERTICAL  
 DATE: 12-25-44  
 DRAWN: [Signature]  
 FLOOD CONTROL SUPERINTENDENT

