

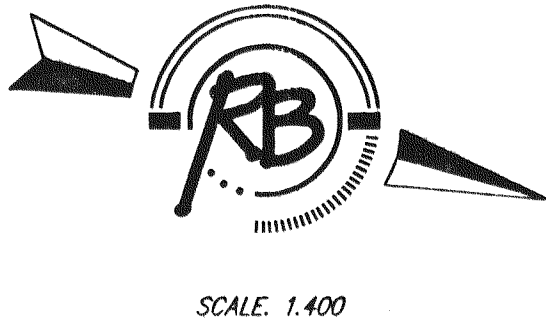


REFERENCES NOTED	DATE
REFERENCES CHECKED	

FHWA REGION NO.	STATE	PROJECT NUMBER	FISCAL YEAR	SHEET NUMBER	TOTAL SHEETS
7	KANSAS				

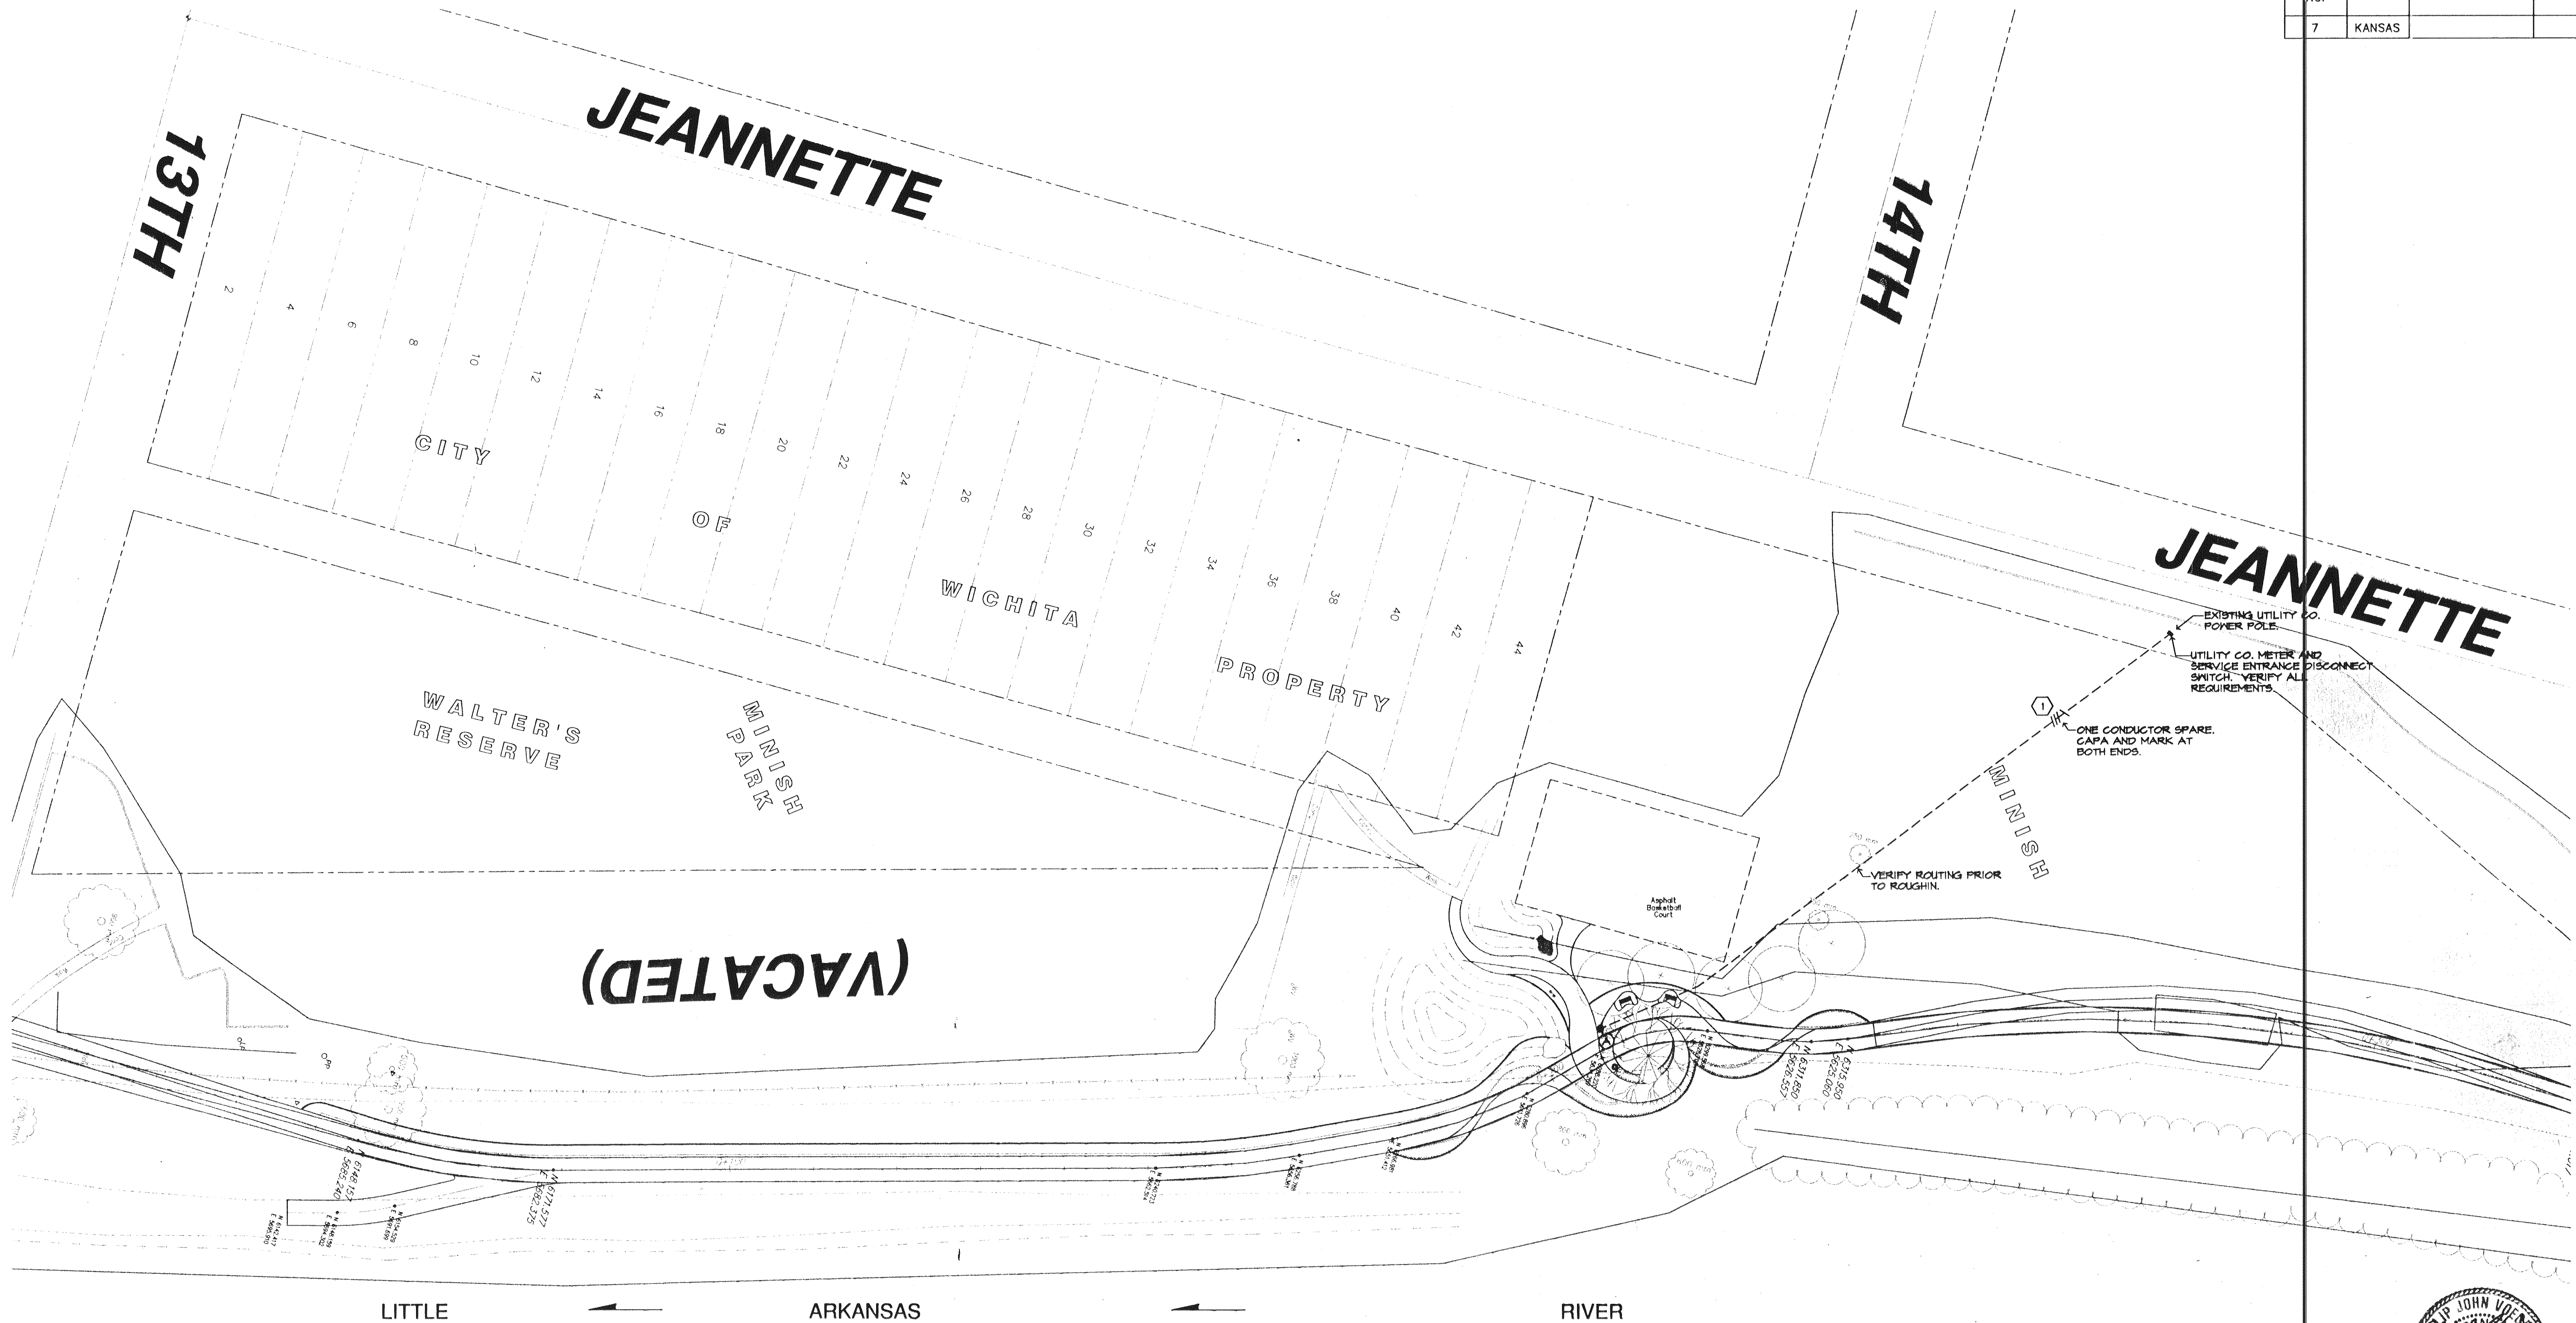

Electrical Engineering
and Design
349 S. Hydraulic
Wichita, KS 67211-1804
(316) 264-3051
FAX (316) 264-3542

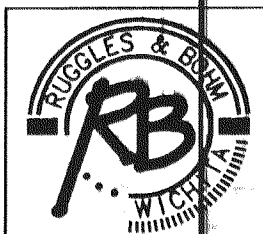

Ruggles & Bohm, P.A.
Engineering, Surveying, Land Planning
924 North Main
Wichita, Kansas 67203
www.rbkansas.com
(316) 264-8008
(316) 264-4821 fax
E-mail: info@rbkansas.com

PROJECT NUMBER	DESIGN	DRAWN	REVIEW
472-83436 (7/08/03)	S/A	S/A	S/A
2140602.DWG	UTILITY	DATE	REVISED
		JUN. 20, 2003	

ELECTRICAL PLAN
LITTLE ARKANSAS RIVER
BICYCLE / PEDESTRIAN PATH

RB JOB
20887
SHEET
62
63

02140-041