


S.V.A. DWG NAME: 2140e03.dwg; DATE: 01/20/03; TIME: 12:03

REFERENCES NOTED	BY	DATE
REFERENCES CHECKED		


CVB 3-1

FHWA REGION NO.	STATE	PROJECT NUMBER	FISCAL YEAR	SHEET NUMBER	TOTAL SHEETS
7	KANSAS				

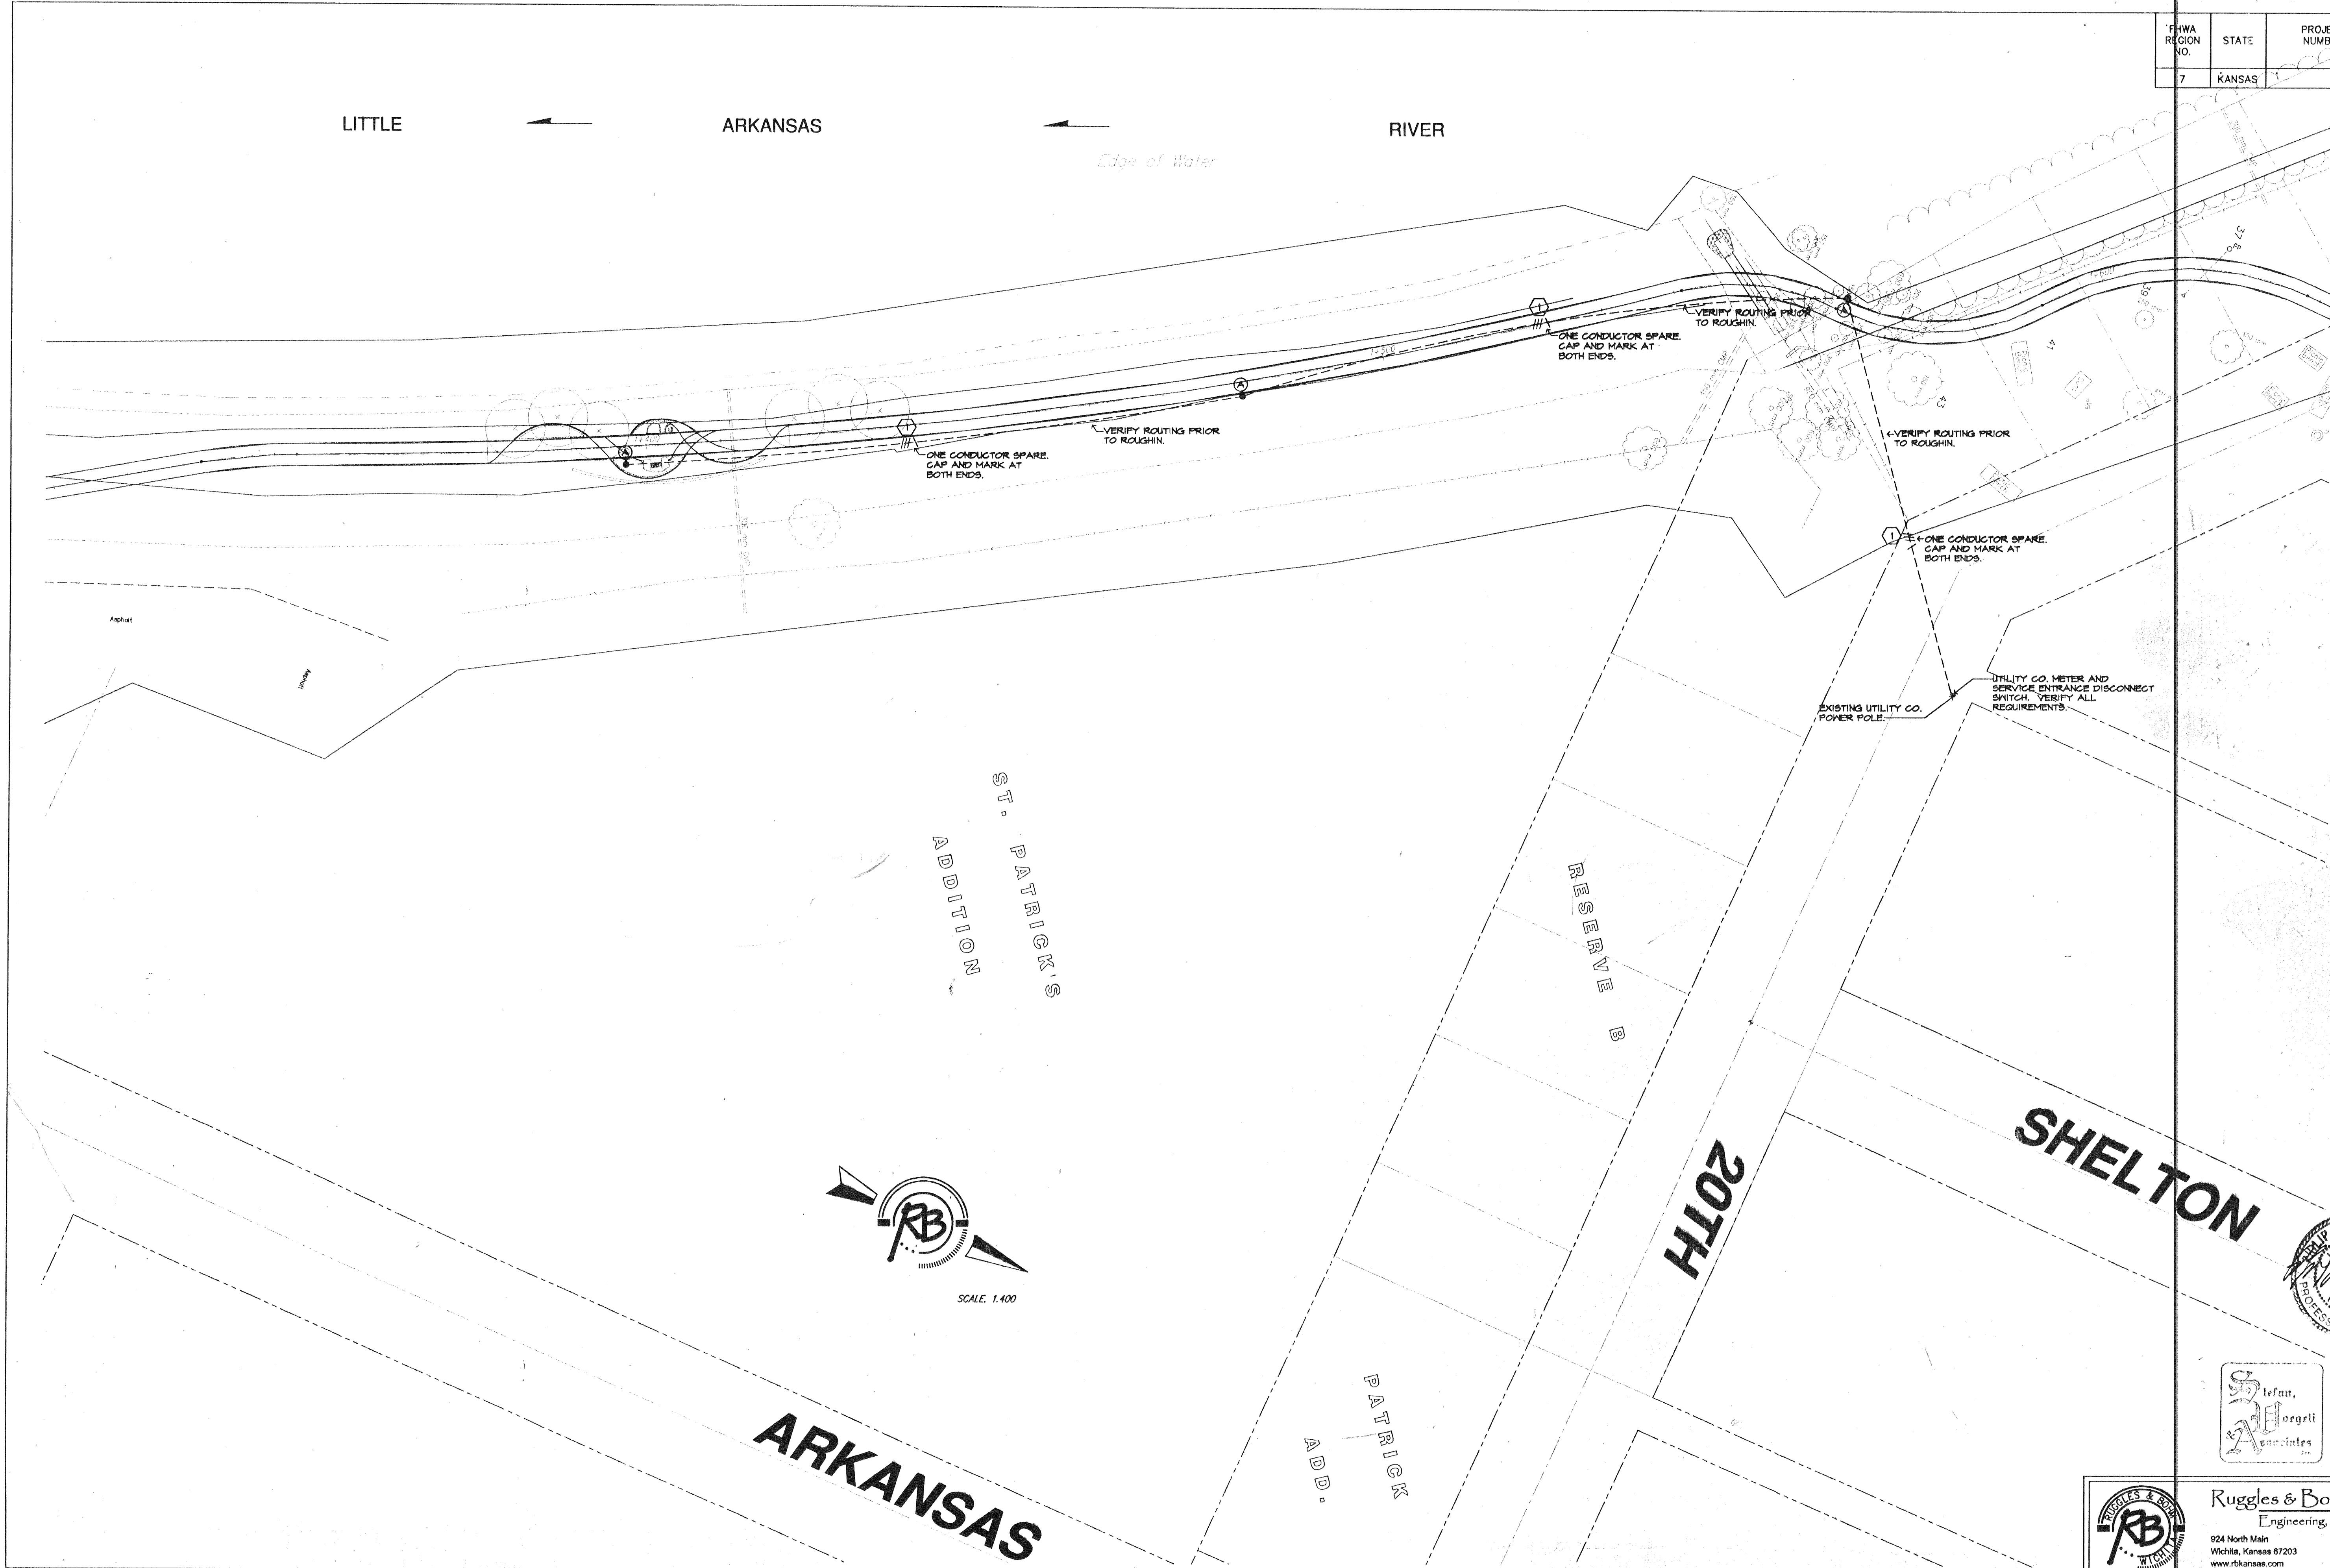

ELECTRICAL PLAN LITTLE ARKANSAS RIVER BICYCLE / PEDESTRIAN PATH	PROJECT NUMBER	DESIGN	DRAWN	REVIEW
	472-83436 (706531)	SVA	SVA	
	DRAWING FILE	UTILITY	DATE	REVISED
	2140E03.DWG		JAN. 20, 2003	

ELECTRICAL PLAN
LITTLE ARKANSAS RIVER
BICYCLE / PEDESTRIAN PATH

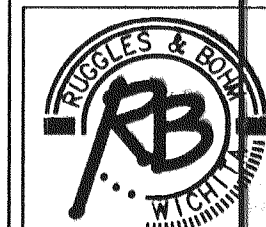

Ruggles & Bohm, P.A.
Engineering, Surveying, Land Planning
924 North Main
Wichita, Kansas 67203
www.rbkansas.com
(316) 264-8008
(316) 264-4621 fax
E-mail: info@rbkansas.com

RB JOB
2088T
SHEET
3
OF
3
02140-041