
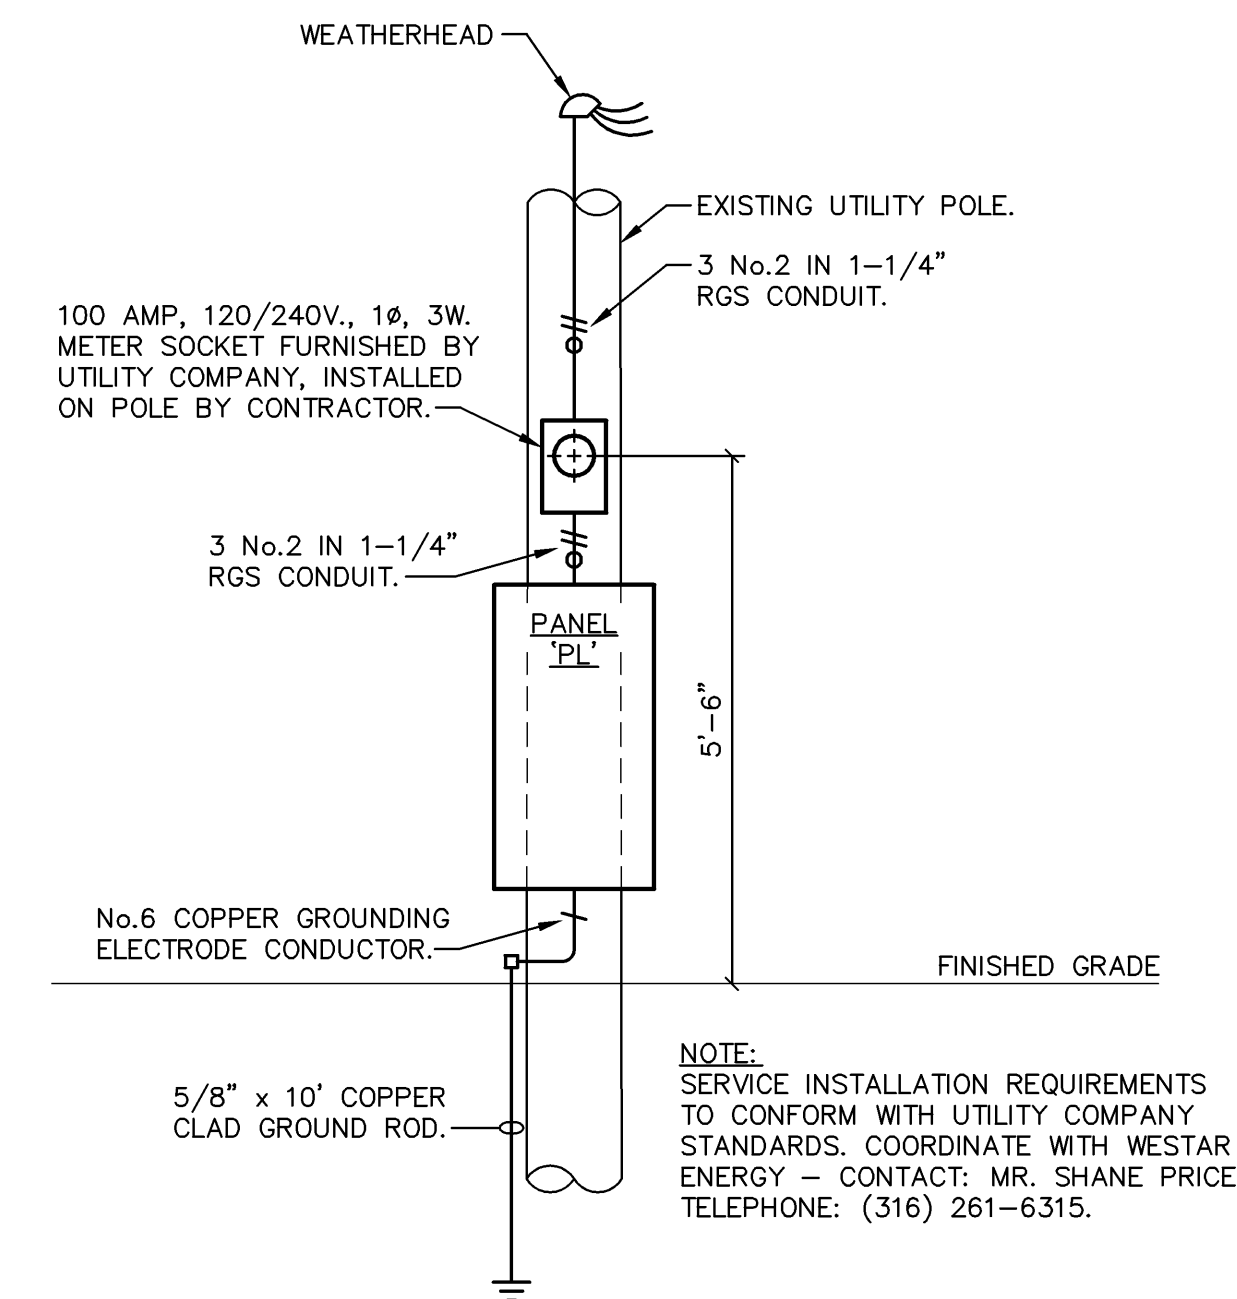


STATE	PROJECT NO.	YEAR	SHEET NO.	TOTAL SHEETS
KANSAS	472-84295	2010	133	194


SERVICE ENTRANCE RATED W/GROUND BUS AND NEMA-3R ENCLOSURE.		PANEL PL		S.C. RATING 65,000 AIC.					
TYPE NQ		120/240 V 1 Ø 3 W, SN		SURFACE MOUNTED					
				100 AMP. MAIN BRKR.					
CKT No.	DESCRIPTION	KVA	AMP	Ø A	Ø B	AMP	KVA	DESCRIPTION	CKT No.
1	LIGHTS POLE S21 AND S22	.9	20					SPACE ONLY	2
3								SPACE ONLY	4
5	SPACE ONLY							SPACE ONLY	6
7	SPACE ONLY							SPACE ONLY	8
9	SPACE ONLY							SPACE ONLY	10
11	SPACE ONLY							SPACE ONLY	12
13	SPACE ONLY							SPACE ONLY	14
15	SPACE ONLY							SPACE ONLY	16
17	SPACE ONLY							SPACE ONLY	18

① CIRCUIT TO BE CONTROLLED BY PHOTOCELL - SEE PLAN 'A' THIS SHEET FOR REQUIREMENTS.


DATE	
BY	
REFERENCES NOTED	
REFERENCES CHECKED	

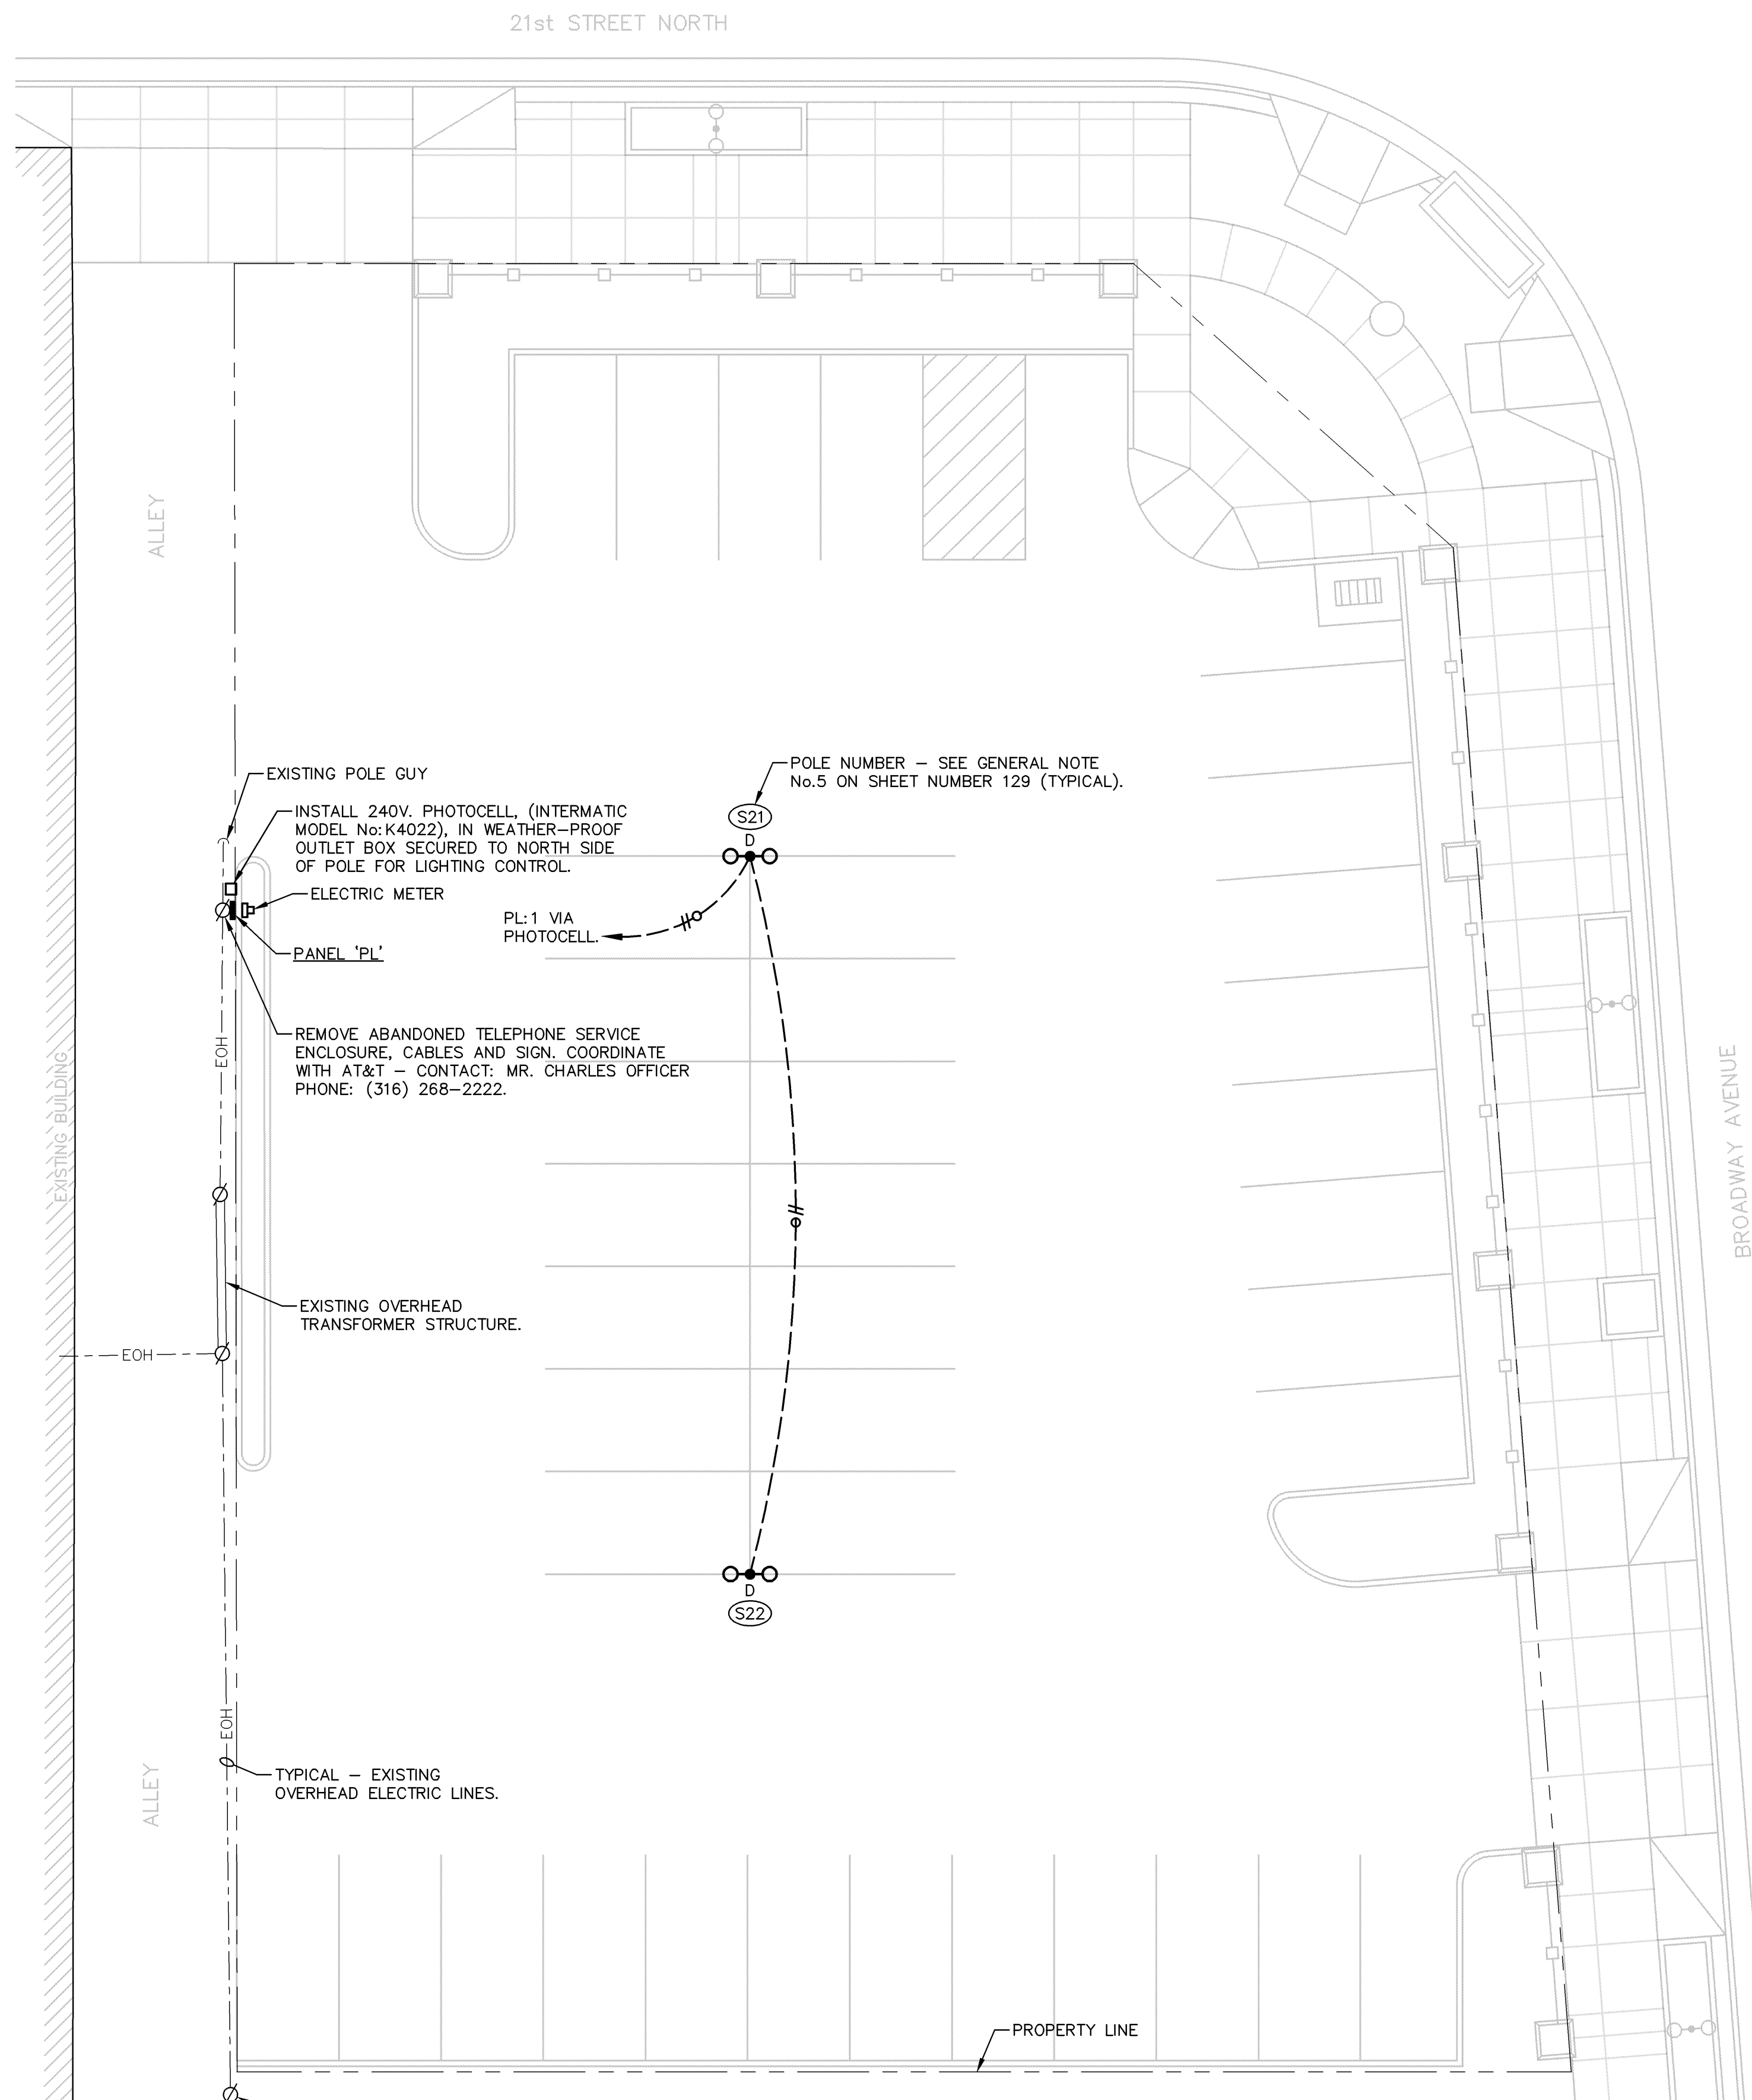

B PARKING LOT SERVICE BRISER DIAGRAM
1/2" = 1'-0"

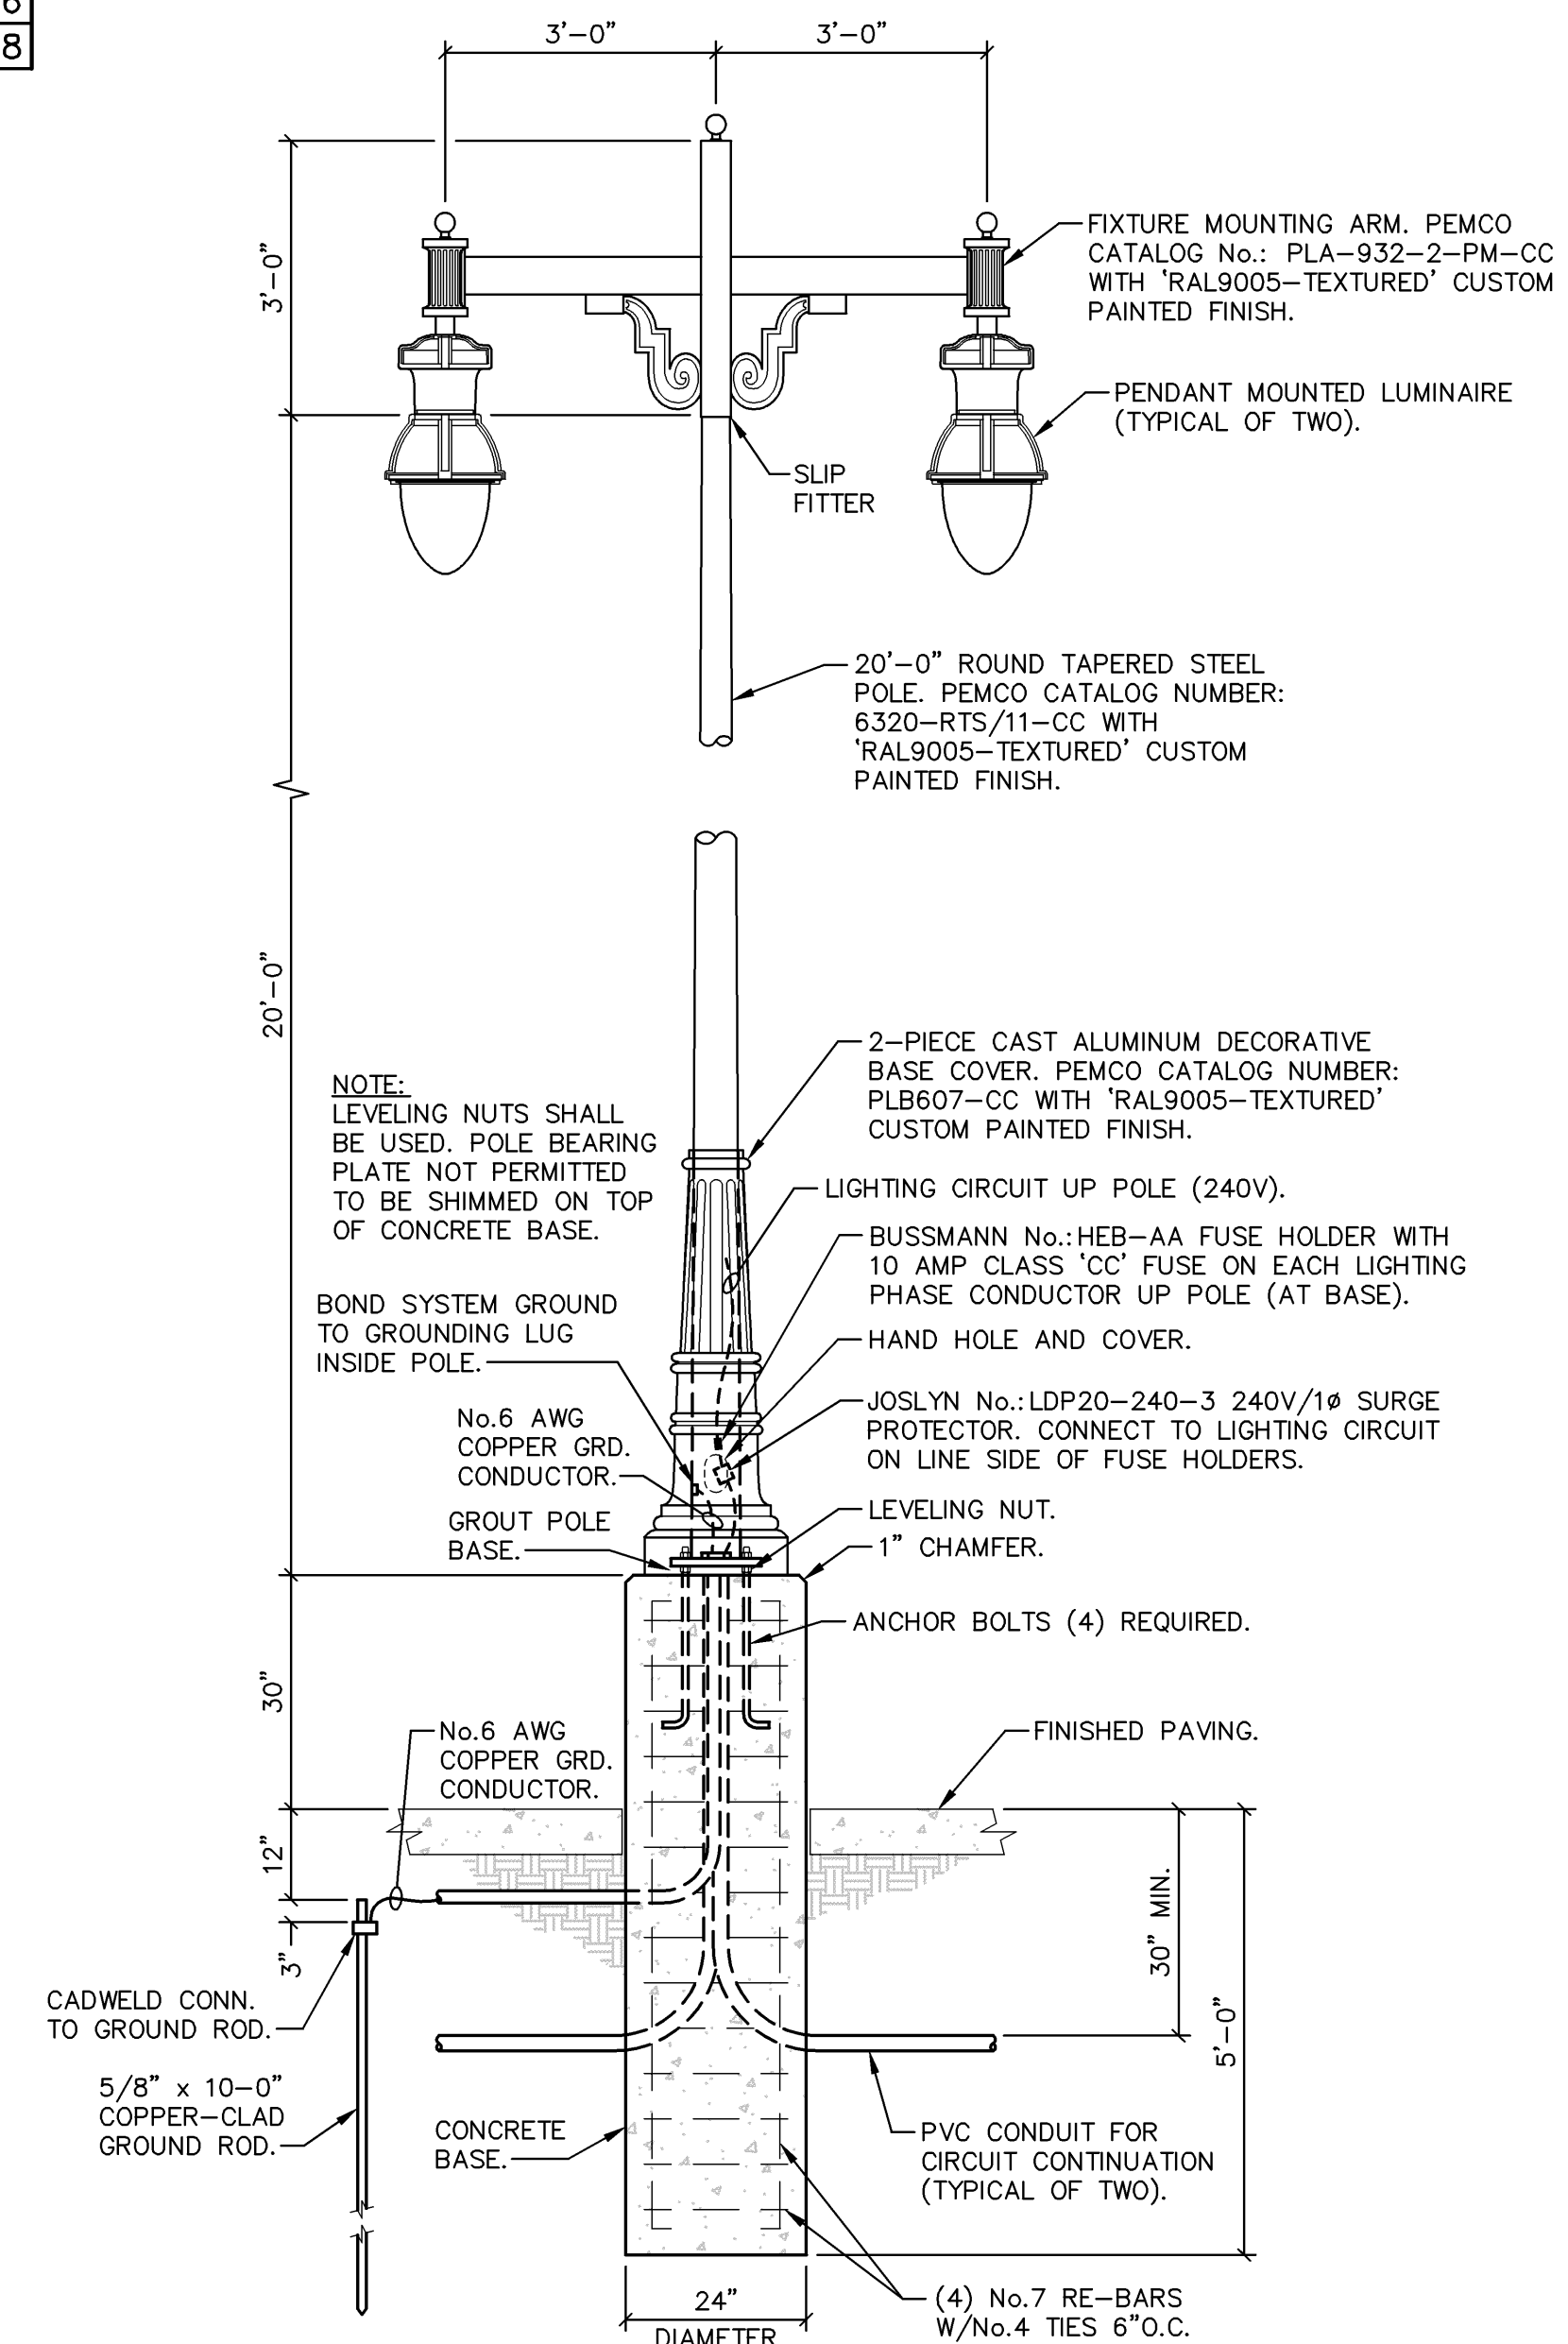

C LIGHTING POLE TYPE 'D'
1/2" = 1'-0"

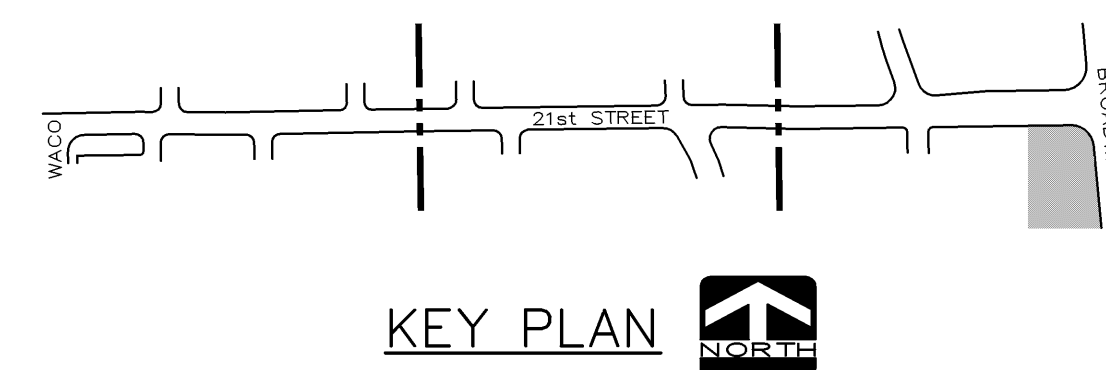

KEY PLAN

A PARKING LOT LIGHTING PLAN
1" = 10'-0"

LAW/KINGDON, INC.
ARCHITECTS, ENGINEERS, PLANNERS & LANDSCAPE ARCHITECTS

CITY OF WICHITA
21ST STREET NORTH & BROADWAY AVENUE INTERSECTION
LIGHTING PLAN, PANEL SCHEDULE AND DIAGRAM - PARKING LOT
WICHITA, KANSAS

DESIGNED: ST
CHECKED: JC
DATE: 01-11-2010

TranSystems

L/K DWG. NAME: 07290-133.dwg; Jan 8 2010 - 11:25am; LAST EDITED BY: stucker