



J:\2008Proj\08527\DWG\Structural\DWG\SZ-3 FD Plan 11/10/2009 - 1:47pm lpham

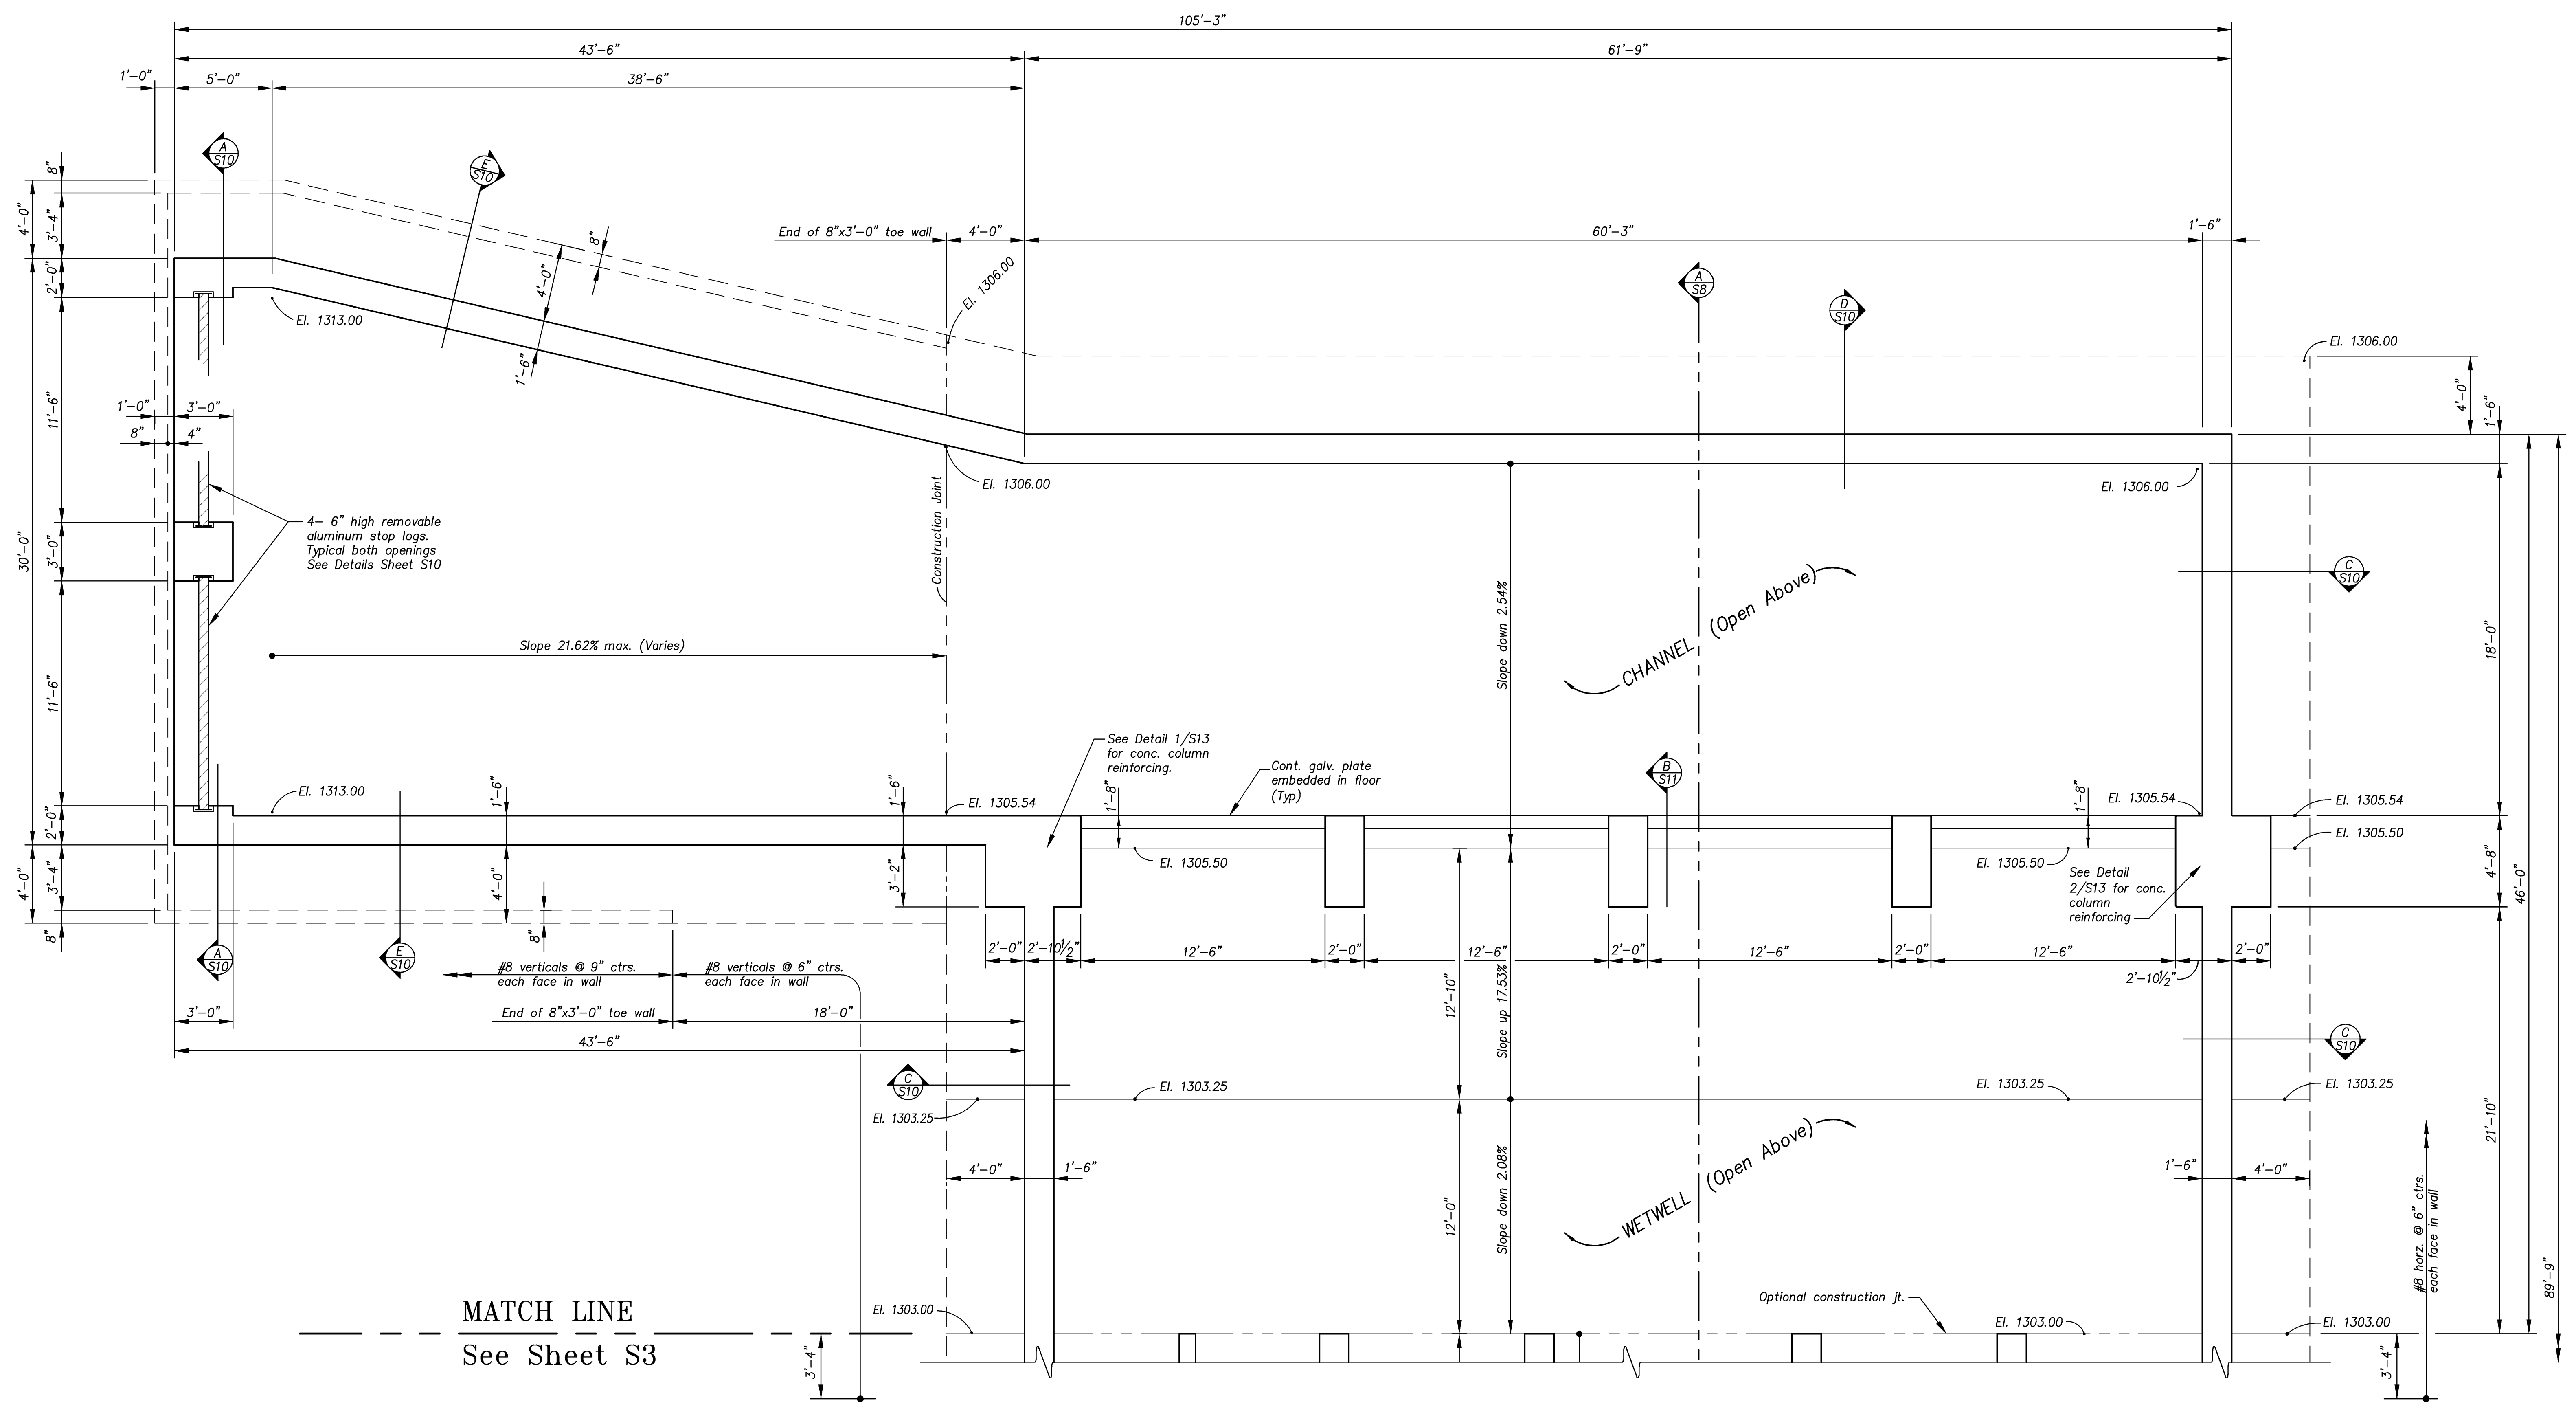

MATCH LINE
See Sheet S3

FOUNDATION PLAN - CHANNEL & WETWELL AREA
Scale: 1/4" = 1'-0"

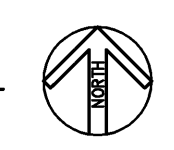

CITY OF WICHITA, KANSAS	
PUMP STATION NO. 11	
STRUCTURAL	
PUMP STATION FOUNDATION PLAN CHANNEL & WETWELL AREA	

CFS
Cook, Flatt & Strobel
ENGINEERS, P. A.

DESIGNED KMB	SCALE As Shown
DATE 10-30-09	DATE 10-30-09
CHECKED	SHEET S2 OF S17