


J:\2008Proj\08527\DWG\Structural\DWG\SS FLR Reinf 11/10/2009 - 1:51pm npham

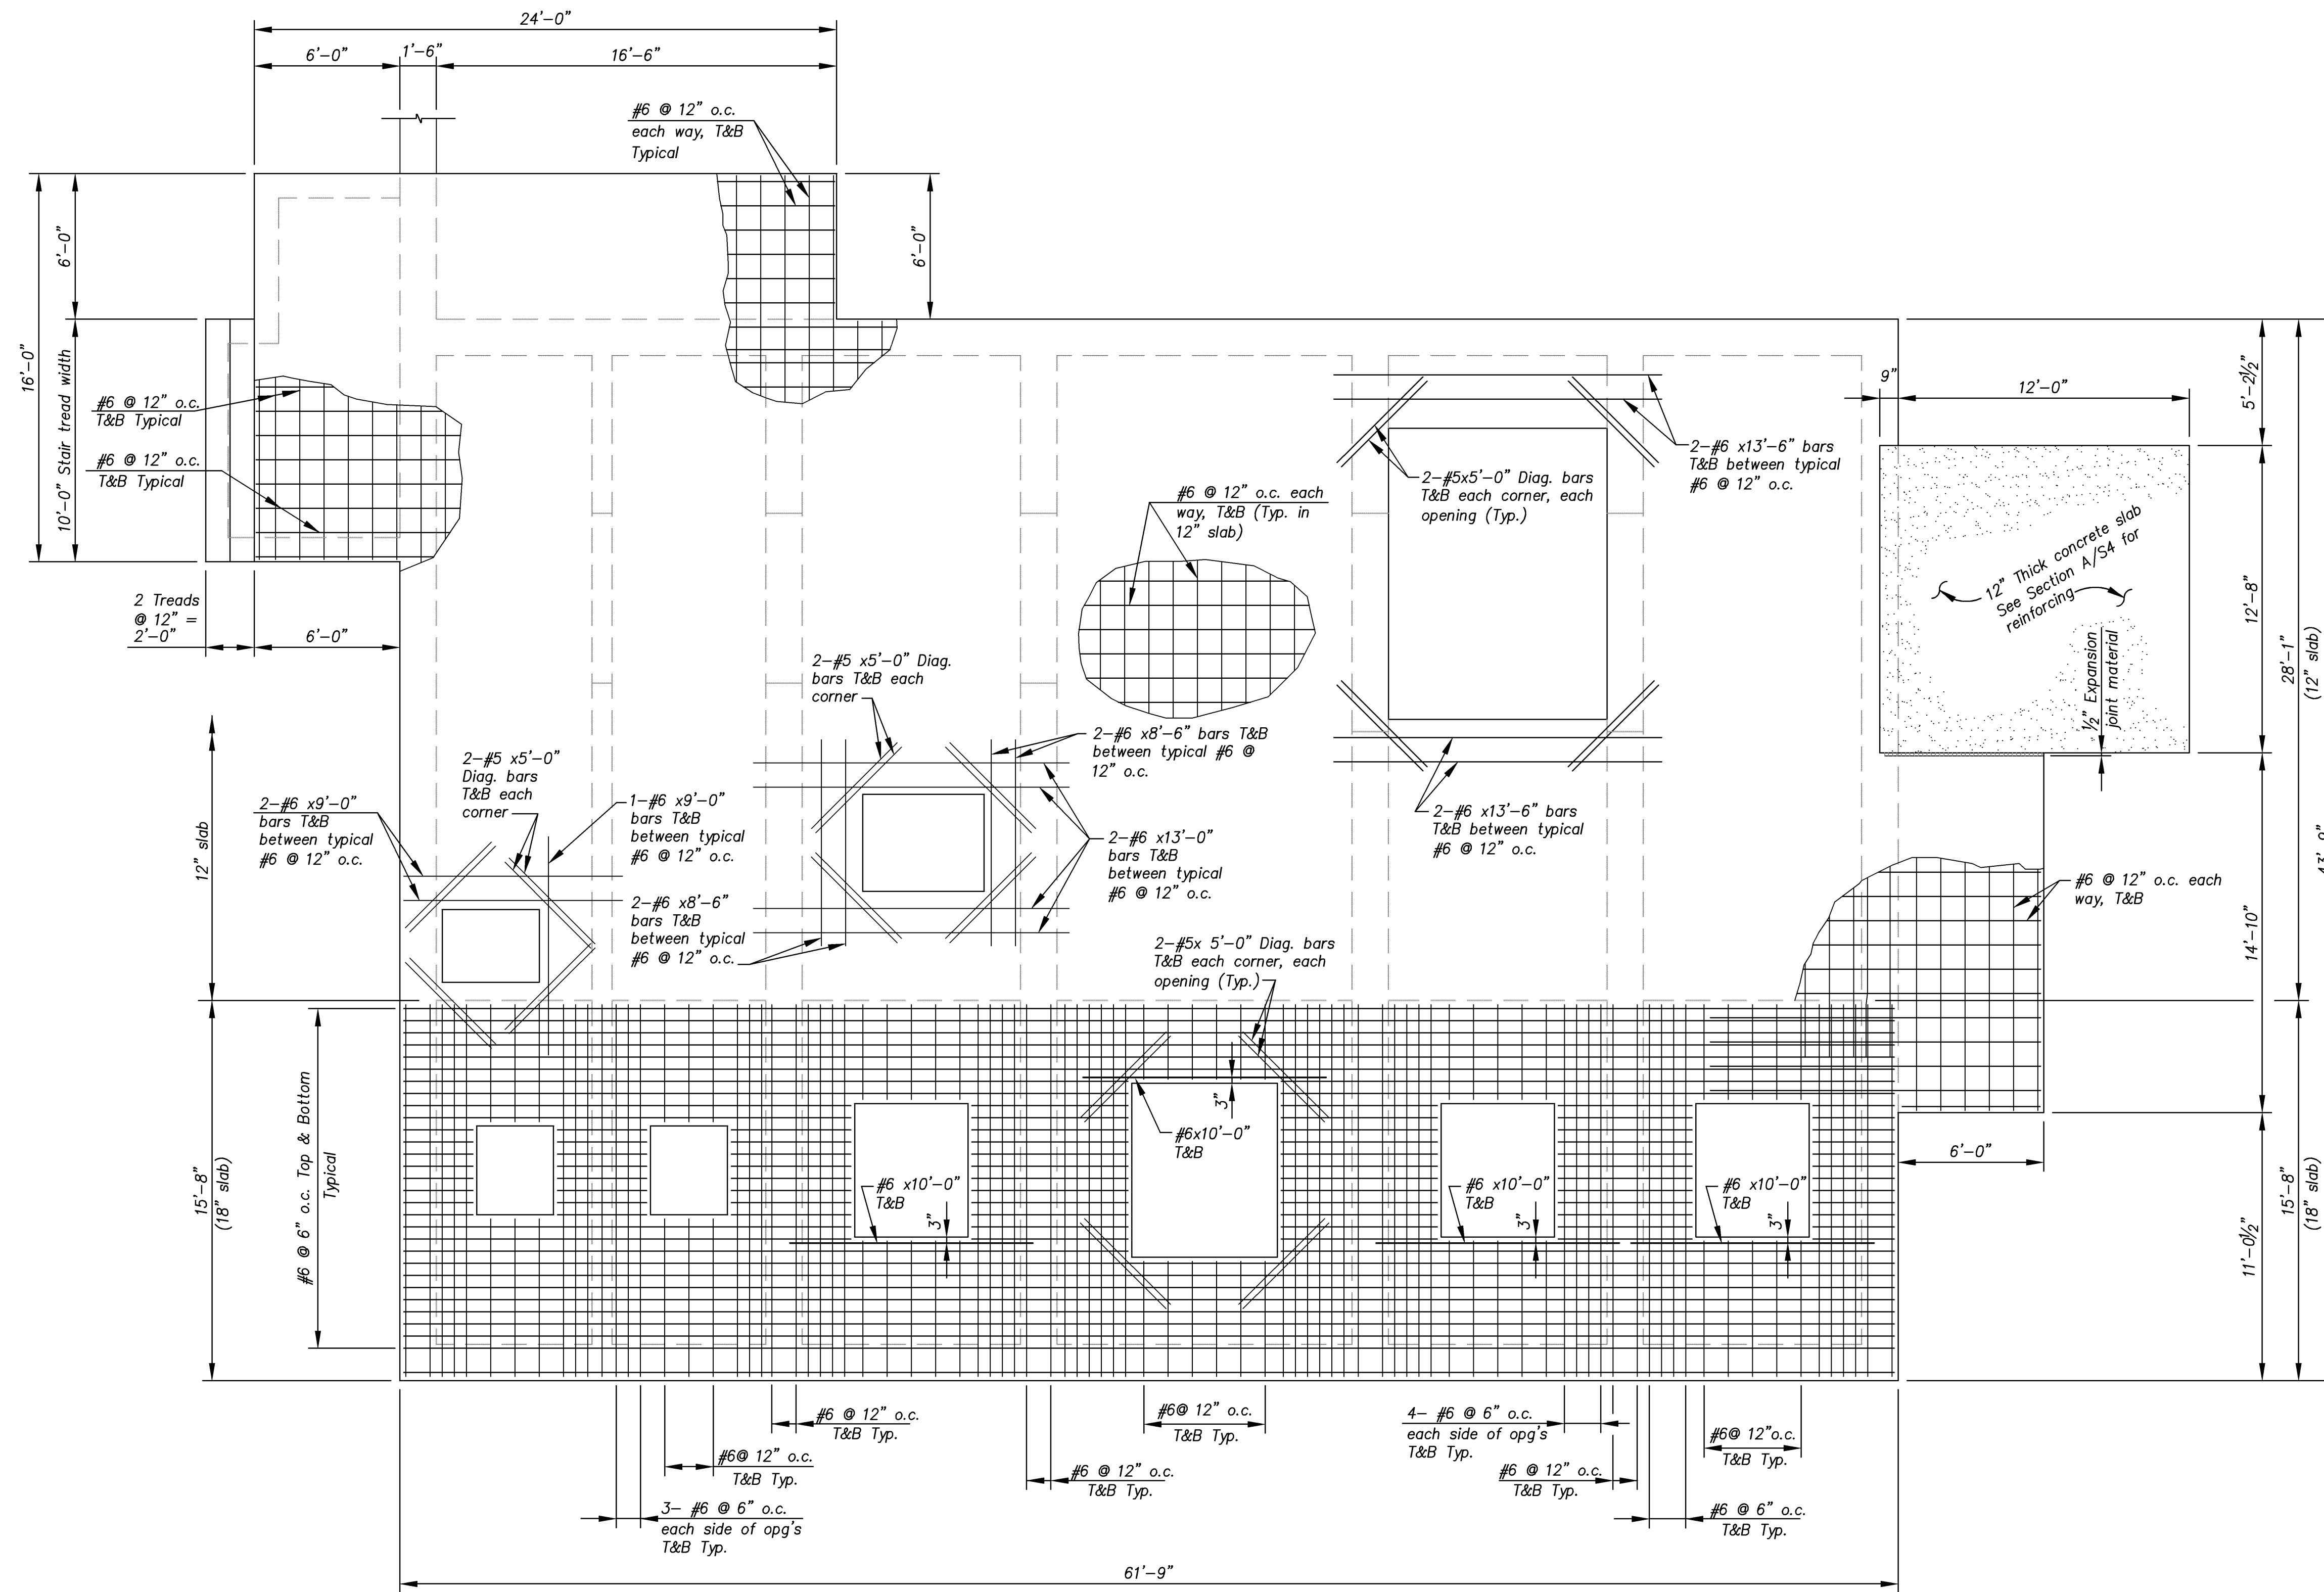

PUMP FLOOR PLAN - REINFORCING

Scale: 1/4" = 1'-0"



CITY OF WICHITA, KANSAS		CFS Cook, Flatt & Strobel ENGINEERS, P.A.	
PUMP STATION NO. 11			
STRUCTURAL		DESIGNED KMB	SCALE As Shown
PUMP STATION		DETAILED HAP	DATE 10-30-09
PUMP FLOOR REINFORCING PLAN		CHECKED	SHEET S9 OF S17