

STATE	PROJECT NO.	YEAR	SHEET NO.	TOTAL SHEETS
KANSAS	472 84614	.	138	534

MH 3-2
N
E
Sta. 11+00.27 Line 3=
Sta. 1729+98.66 63.24' Rt.
@ South Frontage Road
Const. Manhole (San.) 5' Dia. Type P (Std.)
Install 21" x 229.40' San. Sewer (N).
See Sheet Nos.

MH 3-1
N
E
Sta. 9+78.14 Line 3=
Sta. 1731+04.94 123.42' Rt.
@ South Frontage Road
Const. Manhole (San.) 5' Dia. Type P (Std.)
Over Exist. 21" San. Sewer
Install 21" x 122.13' San. Sewer (NW)
Abandon Exist. 21" San. Sewer (N)
See Sheet Nos.

MH 3-3
N
E
Sta. 13+29.67 Line 3=
Sta. 10+00, Line 3A
Sta. 2726+87.03 29.04' Rt.
@ North Frontage Road
Const. Manhole (San.) 5' Dia. Type P (Std.)
Install 21" x 47.05' San. Sewer (N).
Install 8" x 299.18' San. Sewer (E).
See Sheet Nos.

MH 3-4
N
E
Sta. 13+76.72 Line 3=
Sta. 2726+87.03 18.00' Lt.
@ North Frontage Road
Const. Manhole (San.) 5' Dia. Type P (Std.) Over
Exist. 21" San. Sewer
Install 10" x 83.32' San. Sewer (NE).
Abandon Exist. 21" San. Sewer (E).
See Sheet Nos.

MH 3-5
N
E
Sta. 14+60.04 Line 3=
Sta. 2727+44.60 78.23' Lt.
@ North Frontage Road
Const. Manhole (San.) 5' Dia. Type P (Std.)
Over Exist. 10" San. Sewer.
Abandon Exist. 10" San. Sewer (SE).
See Sheet Nos.


MH 3A-1
N
E
Sta. 12+99.18 Line 3A=
Sta. 2929+86.22 29.20' Rt.
@ North Frontage Road
Const. Manhole (San.) 4' Dia. Type P (Std.)
Install 8" x 82.17' San. Sewer (N).
See Sheet Nos.

MH 3A-2
N
E
Sta. 13+81.35 Line 3A=
Sta. 2729+86.22 52.96' Lt.
@ North Frontage Road
Const. Manhole (San.) 4' Dia. Type P (Std.)
Over Exist. 8" San. Sewer
Abandon Exist. 8" San. Sewer (S).
See Sheet Nos.

Notes:
Existing lines not remaining in service shall be abandoned in place or removed. All open ends of abandoned pipe shall be plugged. See Sh. No.

Existing manholes over abandoned sanitary sewer shall be removed. See Sh. No.

See Sh. No's. 102-130 for SWS Plans.
See Sh. No's. 140-162 for Water Plans.

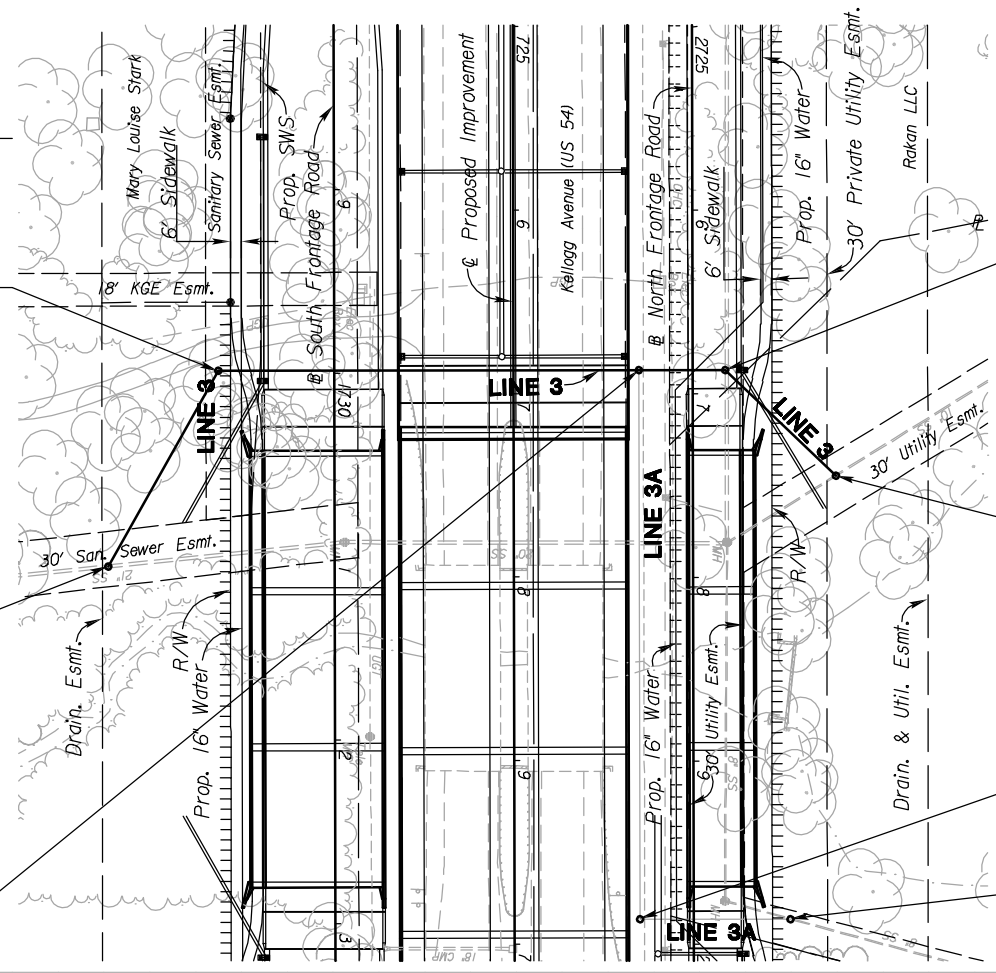


PLAN - LINE 3
SCALE: 1" = 50'

PLAN - LINE 3A
SCALE: 1" = 50'

PROFILE - LINE 3
HORIZ: 1" = 50'
VERTICAL: 1" = 5'

PROFILE - LINE 3A
HORIZ: 1" = 50'
VERTICAL: 1" = 5'

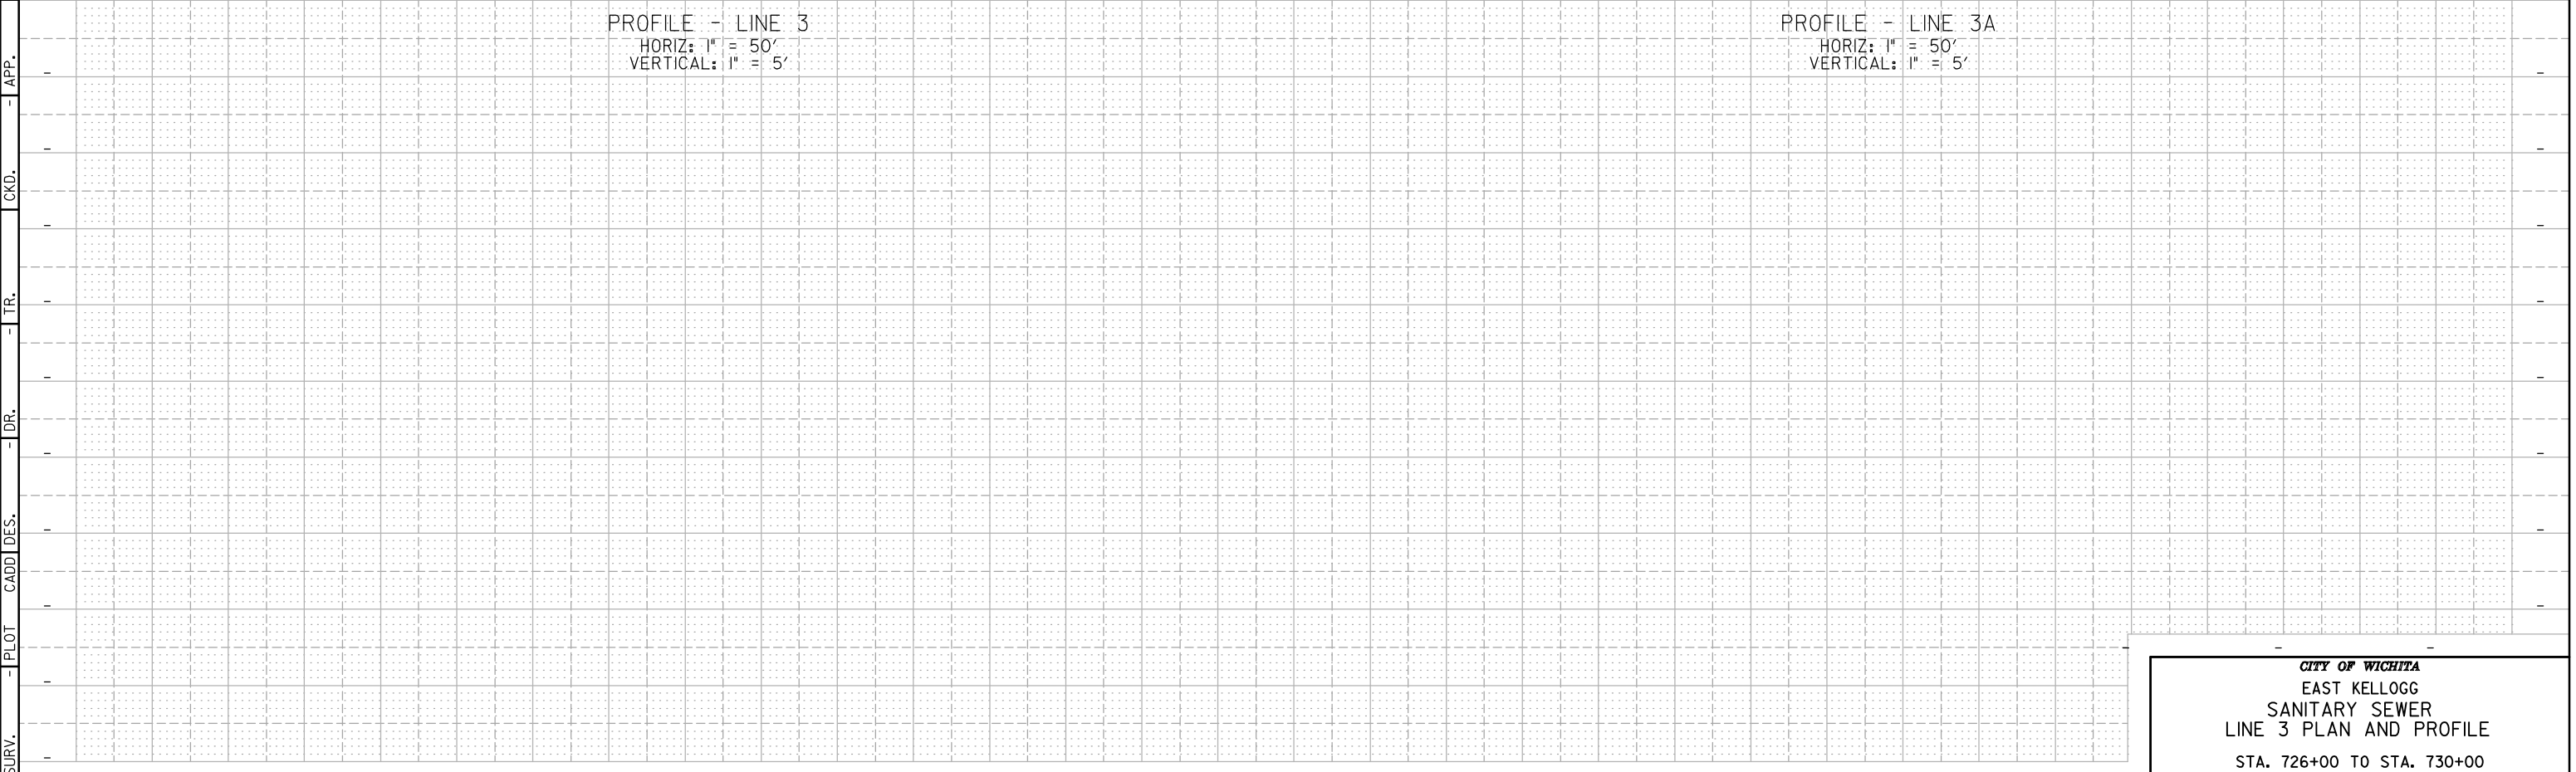

CITY OF WICHITA
EAST KELLOGG
SANITARY SEWER
LINE 3 PLAN AND PROFILE
STA. 726+00 TO STA. 730+00

3:05 PM
2/18/2011
J:\CIVIL\07432\DWG\SAN\K2\SAN PLAN\K2M\SNP03.DWG
SURV. - PLOT CADD DES. - DR. - TR. - CKD. - APP.