

# SEDGWICK COUNTY RURAL WATER DISTRICT #3


SEDGWICK COUNTY, KANSAS

CONSTRUCTION PLANS FOR

# 55TH STREET SOUTH WATERLINE IMPROVEMENTS K15 TO ROCK ROAD

**PUBLIC OFFICIALS**

CHAIRMAN MARK HARDISON  
 VICE-CHAIRMAN MIKE CAMPBELL  
 TREASURER FRANK L. CARSON, III  
 ASST. SECRETARY CRAIG LINOT  
 MEMBERS K. VERDOU PARISH  
 CHARLIE BAUMGARTNER  
 GARY DONALDSON  
 RONALD MACKAY  
 LARRY DEINES  
 OPERATIONS MANAGER LARRY SMITH

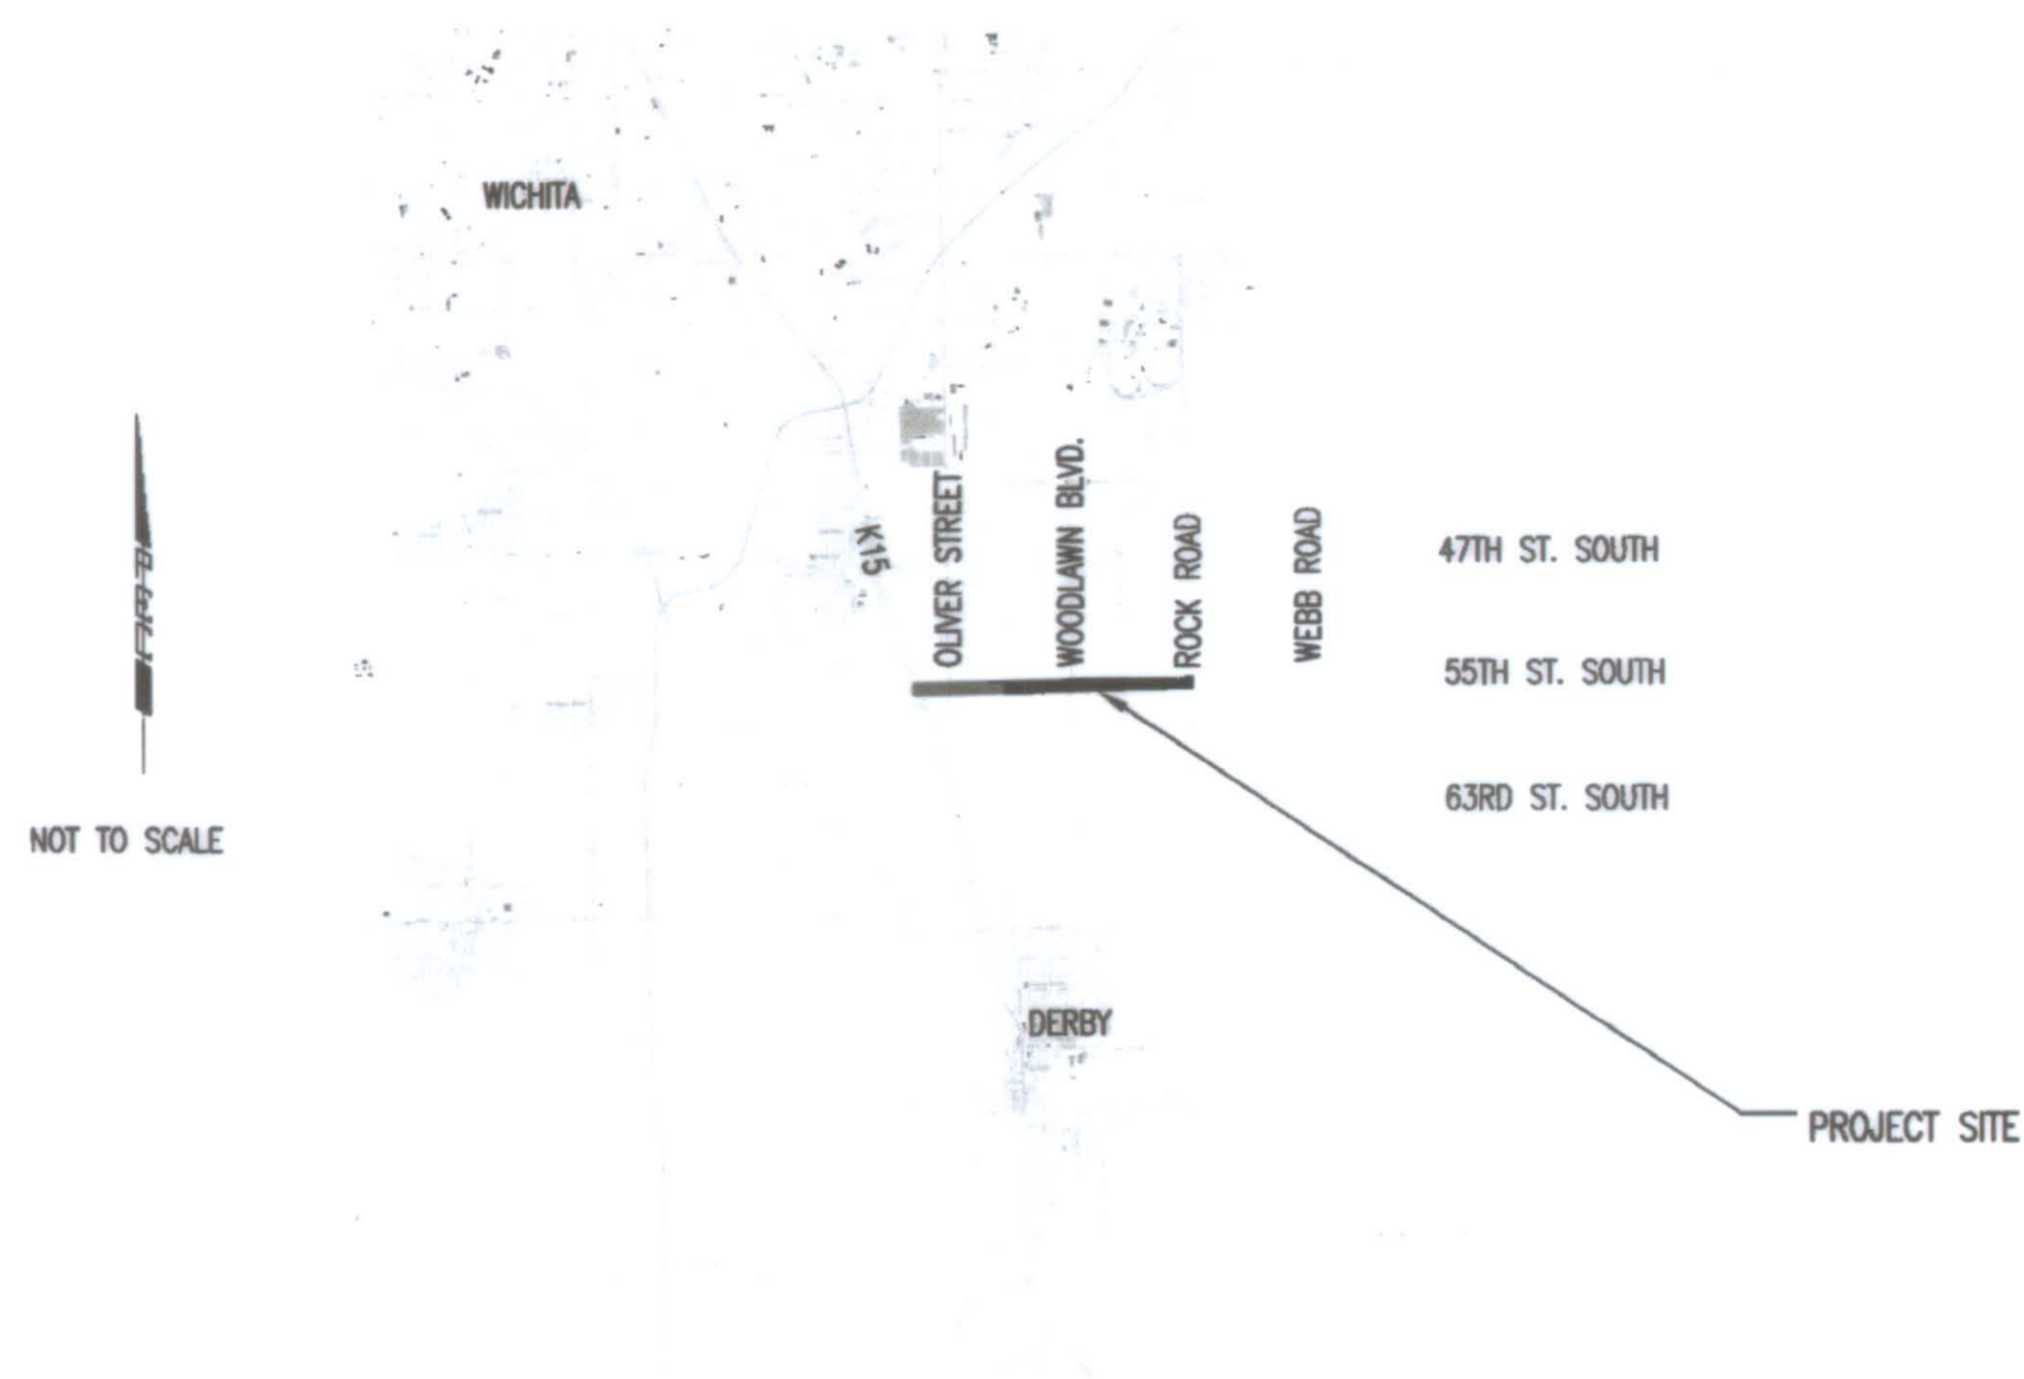

LOCATION MAP

P.E.C. PROJECT NO. 35-10335-4597

**JUNE 2011**

PLANS PREPARED BY

**PROFESSIONAL ENGINEERING CONSULTANTS, P.A.**  
**ENGINEERS**  
**WICHITA, KANSAS**

**INDEX OF SHEETS**

SHEET NO.	SHEET NAME
SHEET NO. 1	TITLE SHEET
SHEET NO. 2	KEY MAP AND GENERAL NOTES
SHEET NO. 3	HORIZONTAL/VERTICAL CONTROL
SHEET NO. 4	WATERLINE DETAILS
SHEET NO. 5	WATER METER VAULT DETAIL
SHEET NO. 6-19	WATERLINE PLAN/PROFILE
SHEET NO. 20	EROSION CONTROL AND SEDIMENT BARRIER DETAILS
SHEET NO. 21	BEDDING AND BACKFILL DETAILS

CITY OF WICHITA PRIVATE PROJECT NO. 1596 PPW (607853)

APPROVED AS NOTED  
 BY CITY ENGINEER OF WICHITA  
 & BY WICHITA WATER UTILITIES

Water Mains (Public Works) *[Signature]* 6/2/11

Water Mains (Water Utilities) *[Signature]* 6/2/11

**NOTE TO CONTRACTORS**

**PUBLIC PROPERTY:**  
 Inspection and testing for the waterline is to be provided by a Licensed Consulting Engineering Firm under contract with the Owner/Developer. Said inspection to be in accordance with the City of Wichita standard construction engineering practices and certified by a Licensed Professional Engineer licensed in the State of Kansas. No work shall be performed in dedicated easements or public right-of-way by the Contractor without such inspection nor shall any work be commenced without written authorization by the City Engineer. All Construction and Materials shall comply with the City of Wichita Specifications and Standards (on file and available in the City Engineer's Office).

**RECORD DRAWINGS**

CONTRACTOR: Nowak Construction Company Inc.  
 INSPECTOR: Charles Daniels, Professional Engineering Consultants, P.A.

.pdf by: *CD* 6/15/11  
 Inspectors Initials Date

