
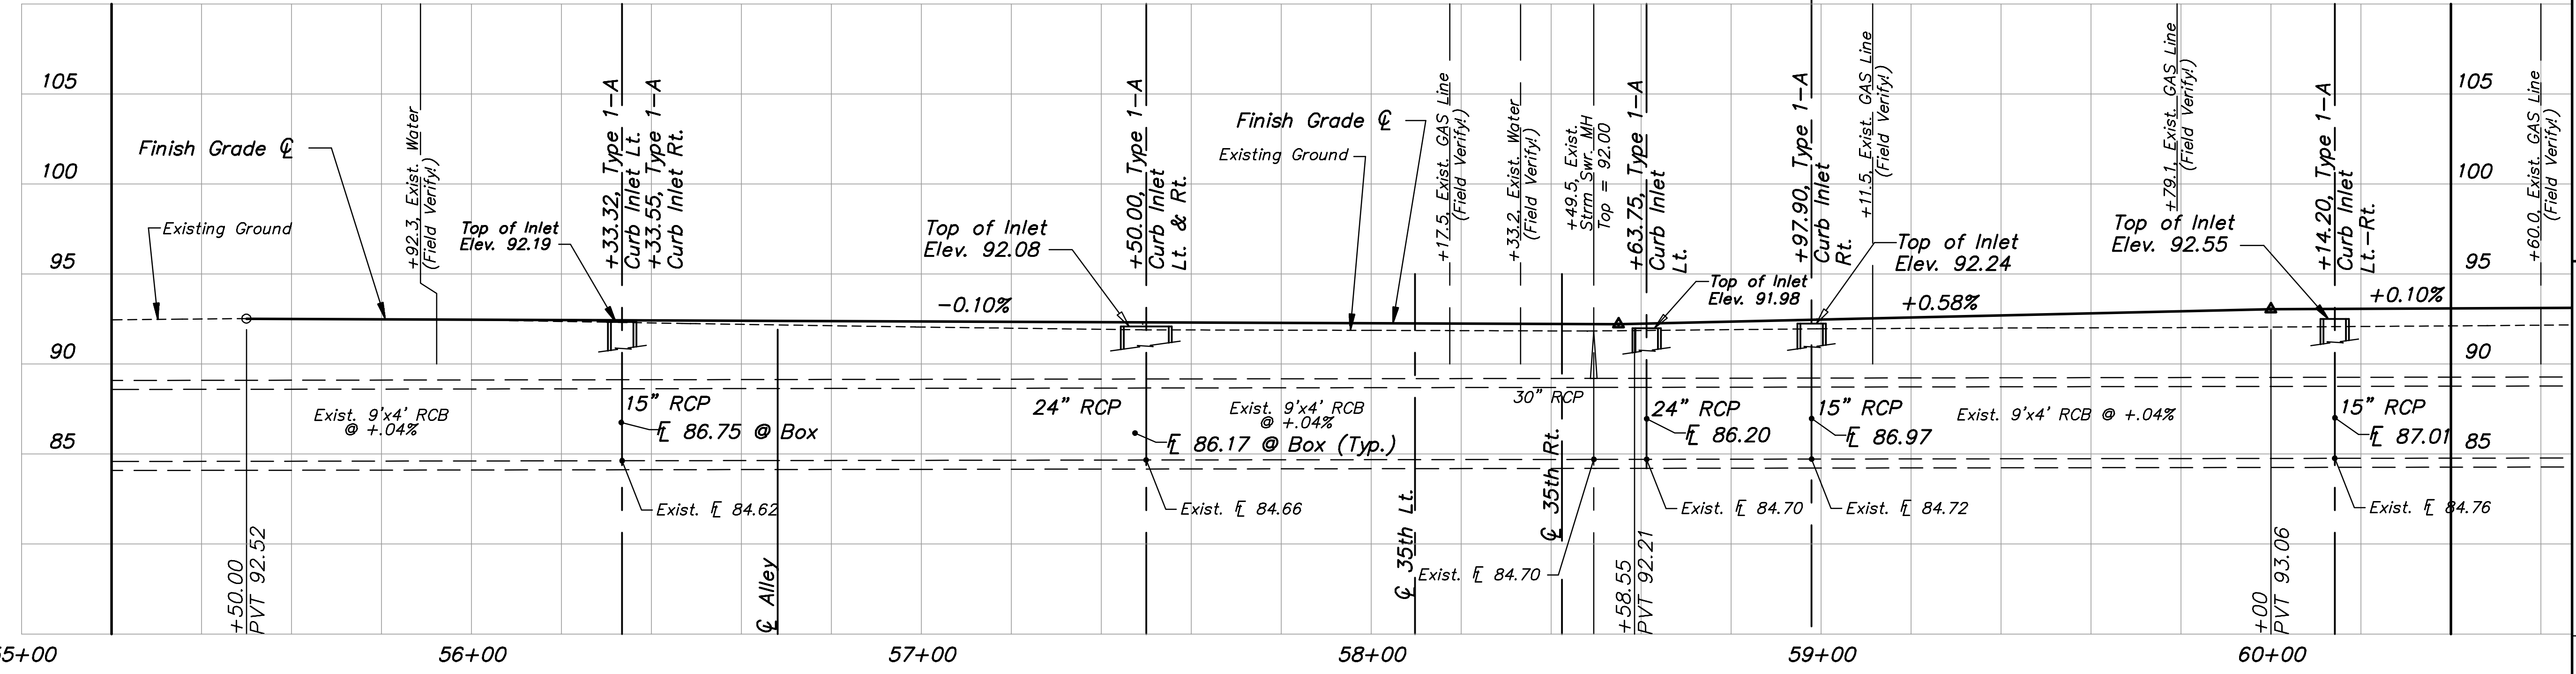
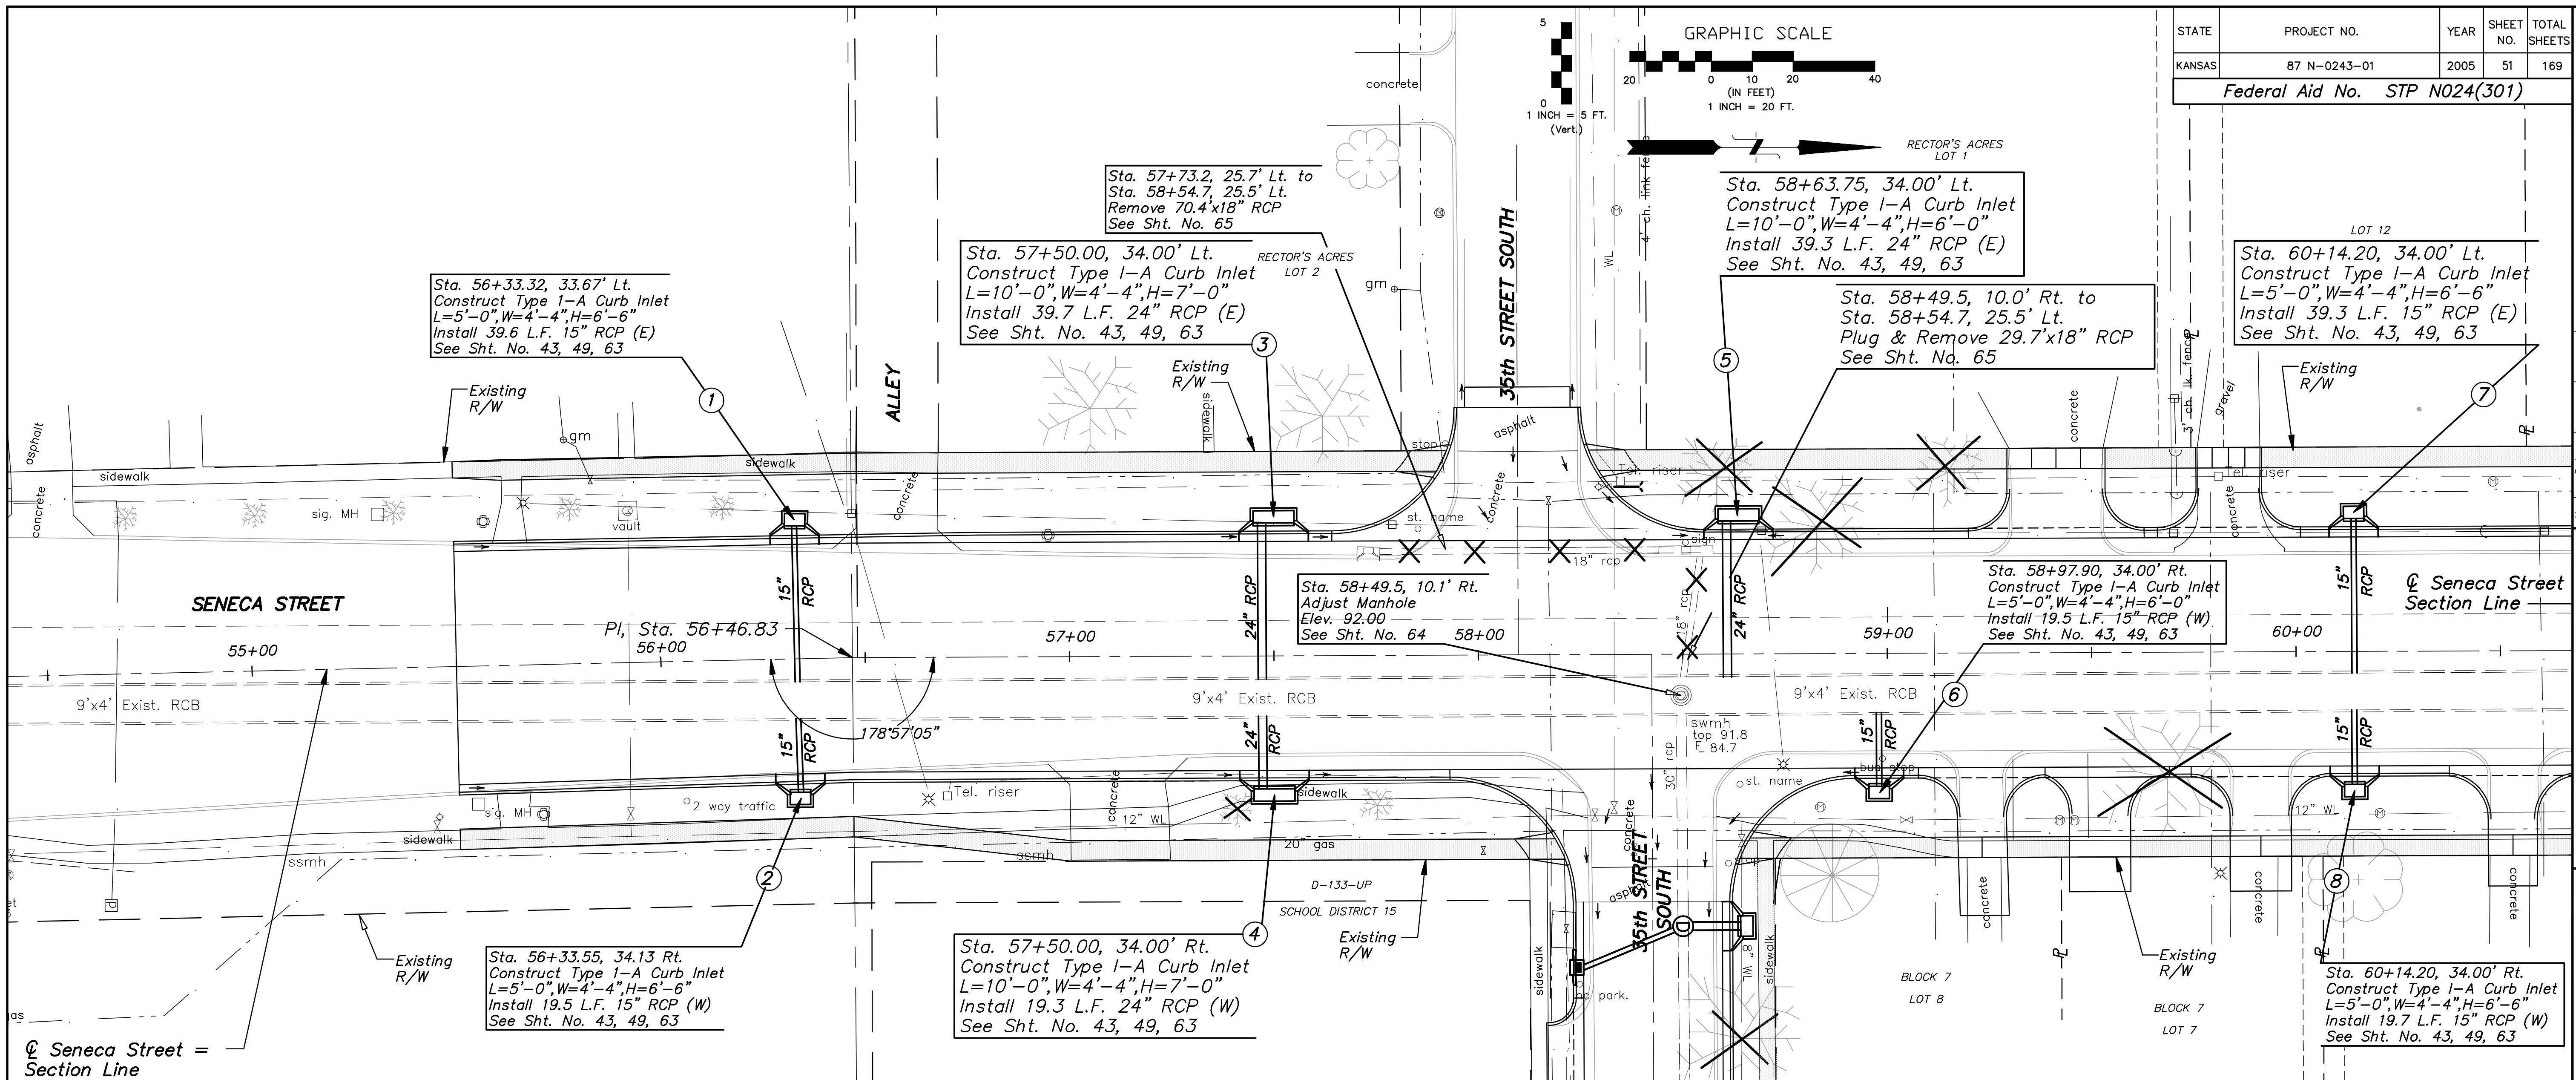


STATE	PROJECT NO.	YEAR	SHEET NO.	TOTAL SHEETS
KANSAS	87 N-0243-01	2005	51	169
Federal Aid No. STP N024(301)				

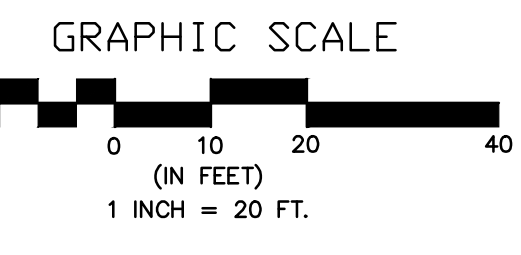

SENECA STREET
1-235 TO 31ST STREET
CITY OF WICHITA, KANSAS
STORM SEWER PLAN AND PROFILE
STA. 56+00 TO 60+50 (SENECA STREET)

POE & ASSOCIATES, INC.
CONSULTING ENGINEERS
5940 E. Central, Suite 200 □ Wichita, KS
67208-4242
Phone: 316/685-4114 □ FAX: 316/685-4444

Engineer: P. FERGUSON
Designer: J. UNRUH
KDOT Job No.: 87 N-0243-01 Poe Job No.: 1794
Date: JANUARY 2010

Sheet 51 of 169