


STATE	PROJECT NO.	YEAR	SHEET NO.	TOTAL SHEETS
KANSAS	87 N-0243-01	2005	53	169

Federal Aid No. STP N024(301)

GRAPHIC SCALE
1 INCH = 5 FT. (Vert.)
1 INCH = 20 FT. (Horiz.)

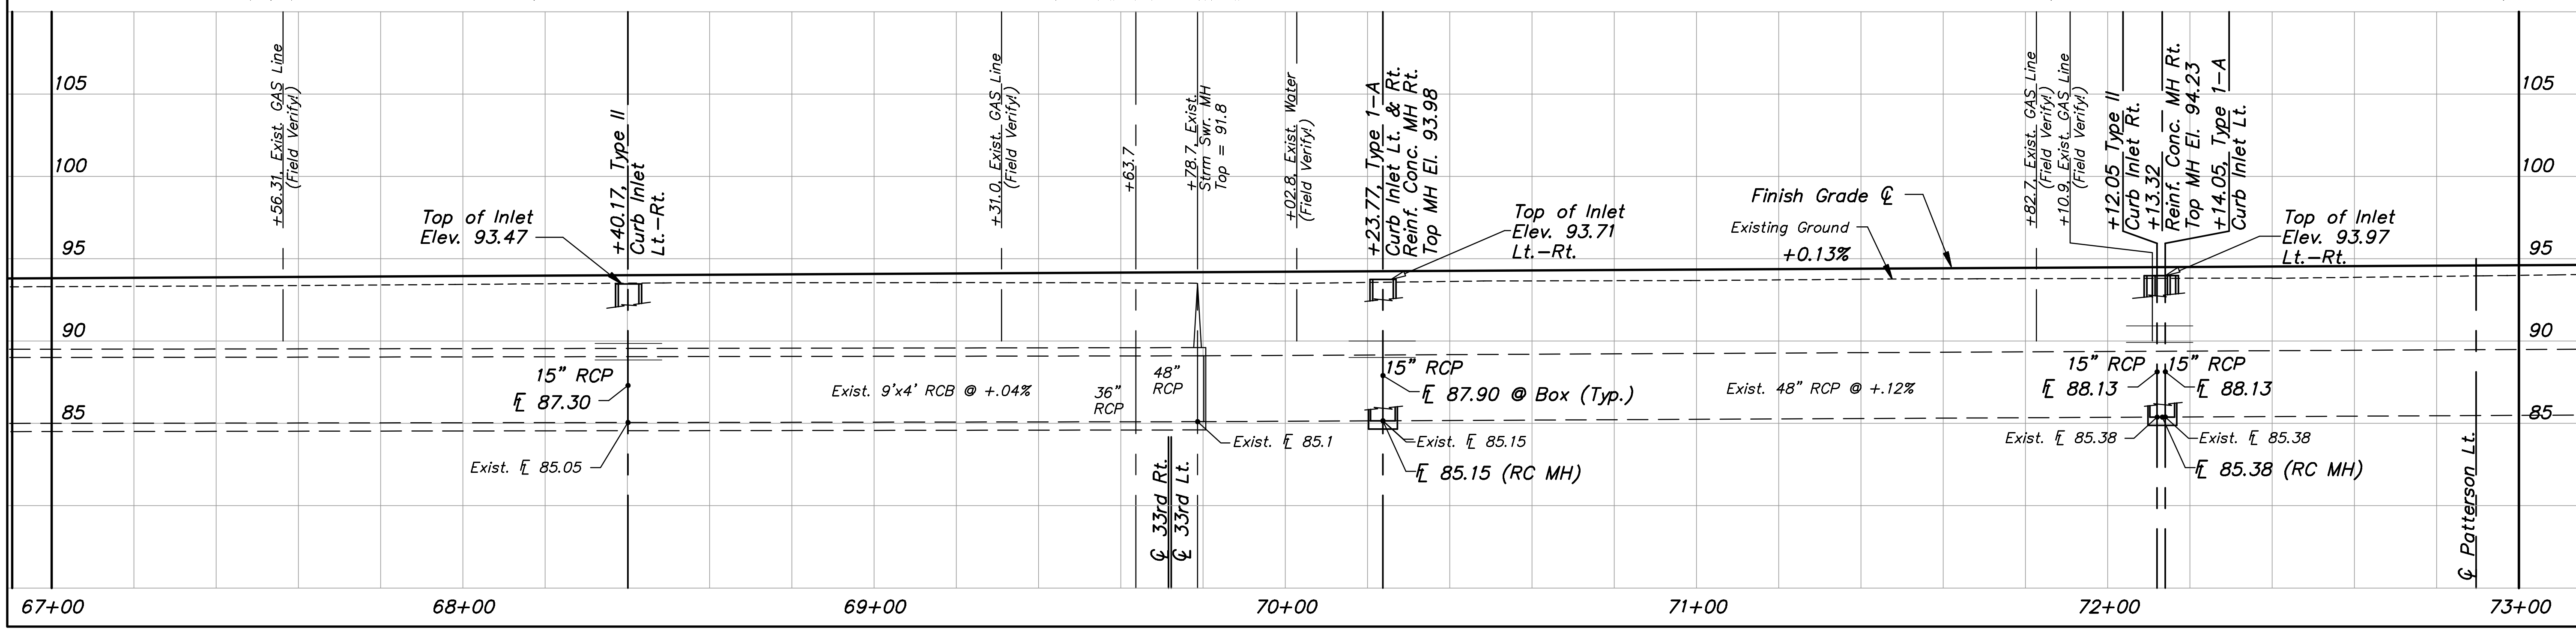

SENECA STREET
1-235 TO 31ST STREET

CITY OF WICHITA, KANSAS
STORM SEWER PLAN AND PROFILE
STA. 66+75 TO 73+00 (SENECA STREET)

POE & ASSOCIATES, INC.
CONSULTING ENGINEERS
5940 E. Central, Suite 200 | Wichita, KS
67208-4242
Phone: 316/685-4114 | FAX: 316/685-4444

ENGINEER: P. FERGUSON
DESIGNER: J. UNRUH

KDOT Job No.: 87 N-0243-01
Poe Job No.: 1794
Date: JANUARY 2010

Sheet 53 of 169