
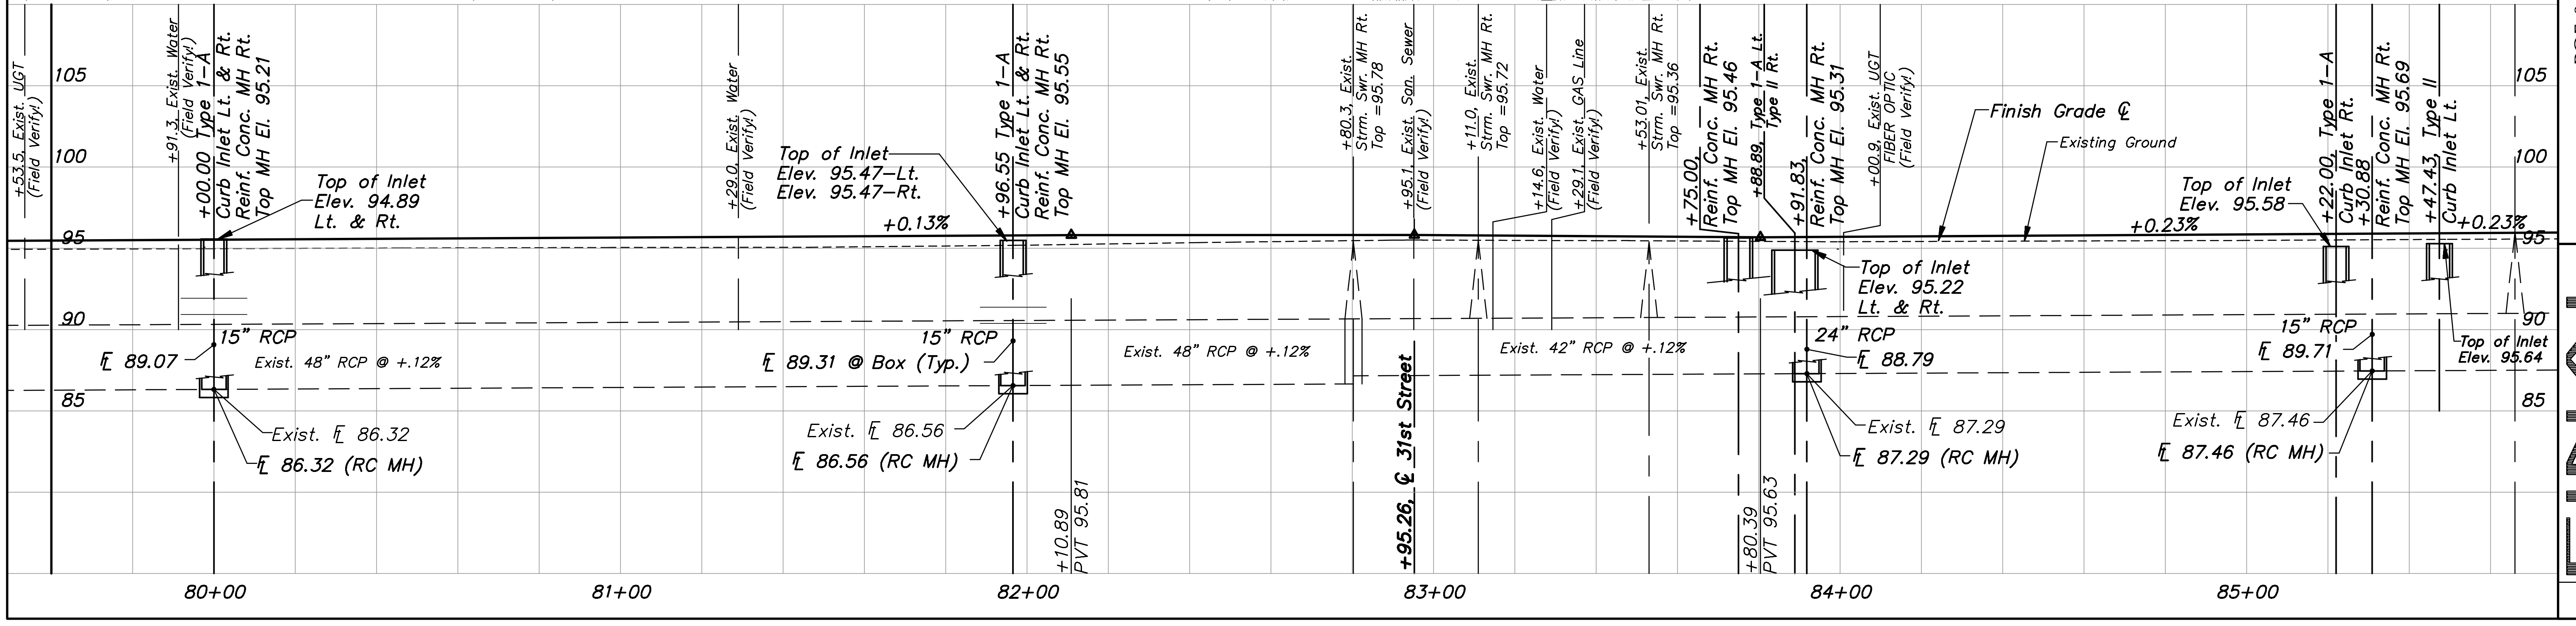
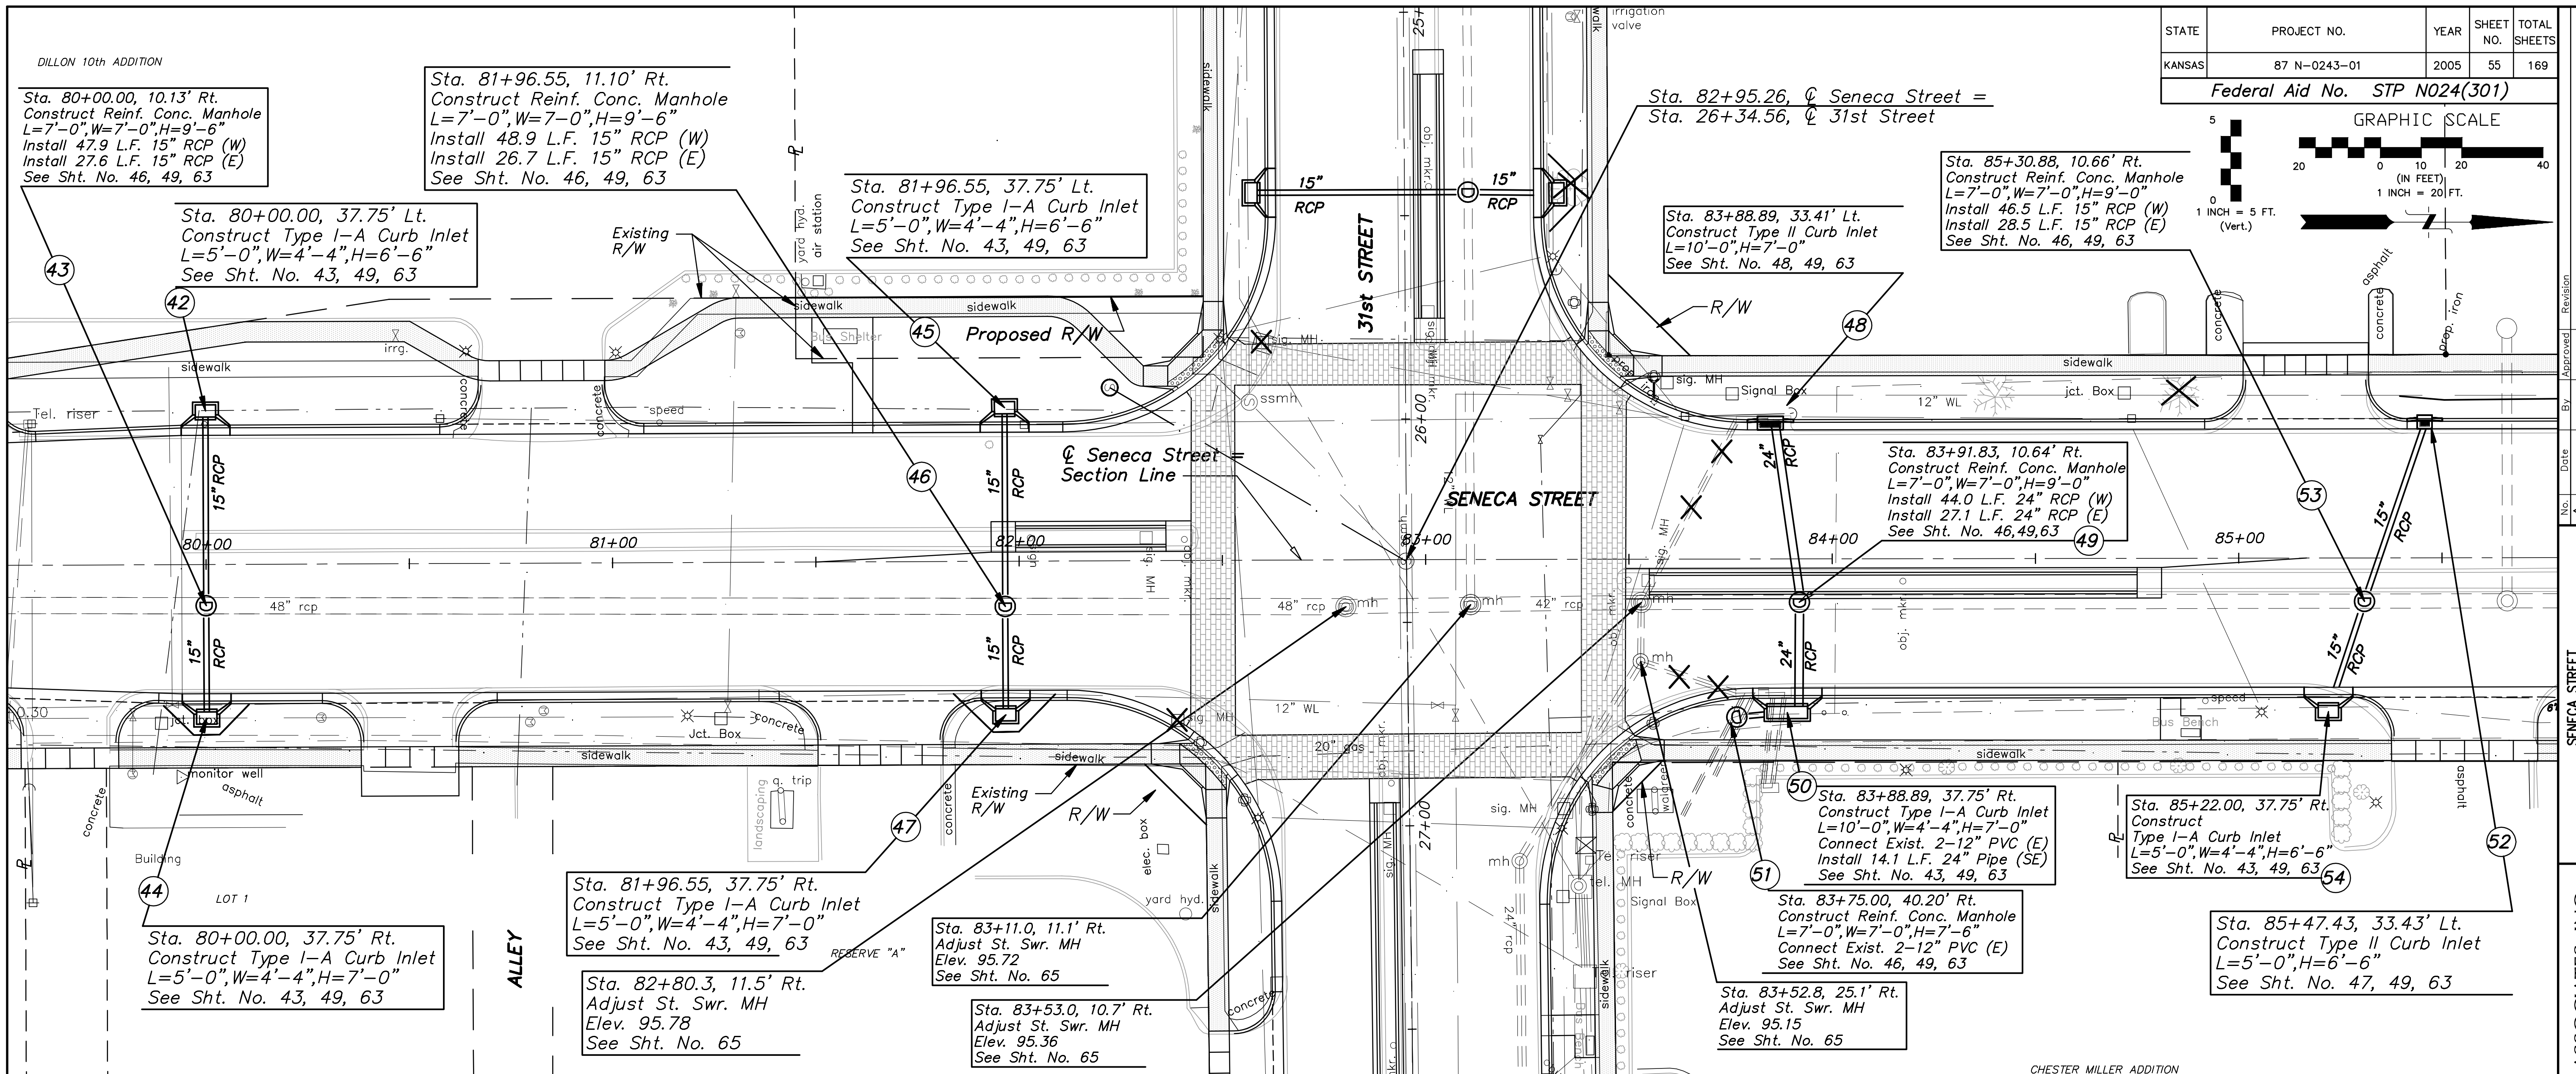


STATE	PROJECT NO.	YEAR	SHEET NO.	TOTAL SHEETS
KANSAS	87 N-0243-01	2005	55	169

Federal Aid No. STP N024(301)

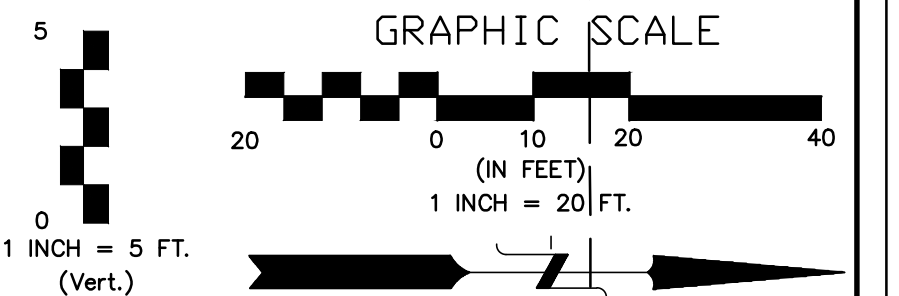

No. _____ Date _____ By _____ Approved _____
 Revision _____
 No. _____ Date _____ By _____ Approved _____
 Revision _____

SENECA STREET
 1-235 TO 31ST STREET
 CITY OF WICHITA, KANSAS
 STORM SEWER PLAN AND PROFILE
 STA. 79+00 TO 85+50 (SENECA STREET)

POE & ASSOCIATES, INC.
 CONSULTING ENGINEERS
 5940 E. Central, Suite 200 | Wichita, KS
 67208-4242
 Phone 316/685-4114 | FAX 316/685-4444

Engineer: P. FERGUSON
 Designer: J. UNRUH
 KDOT Job No.: 87 N-0243-01
 Job No.: 87 N-0243-01
 Date: JANUARY 2010
 Sheet 55 of 169