
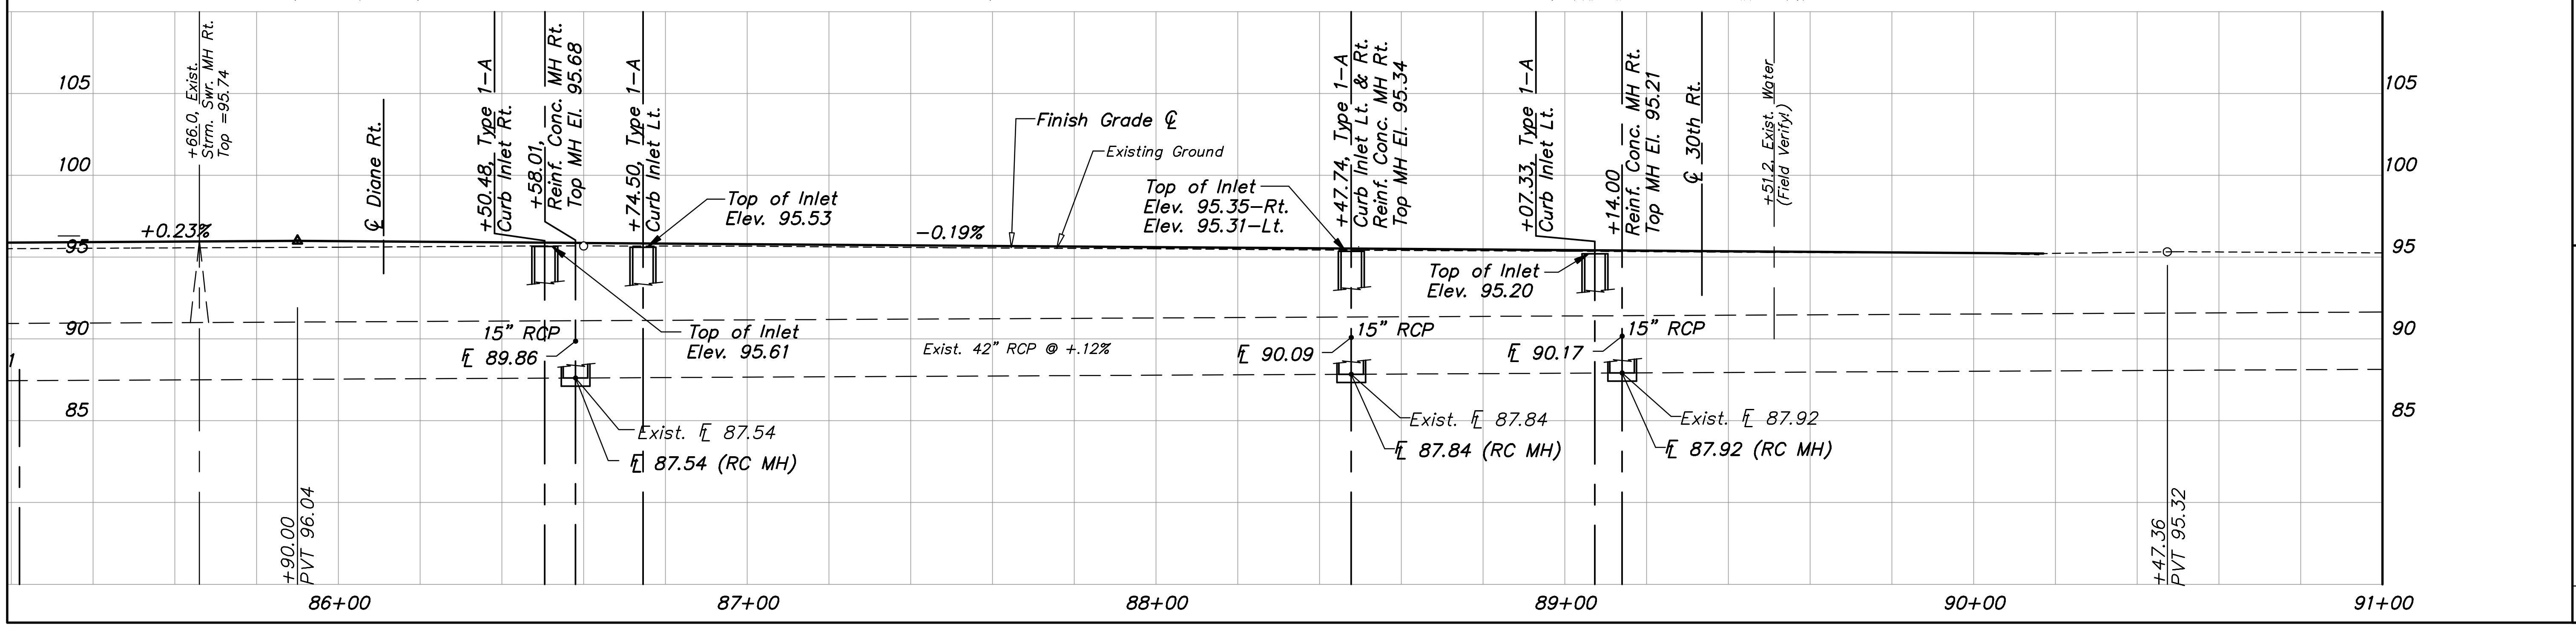
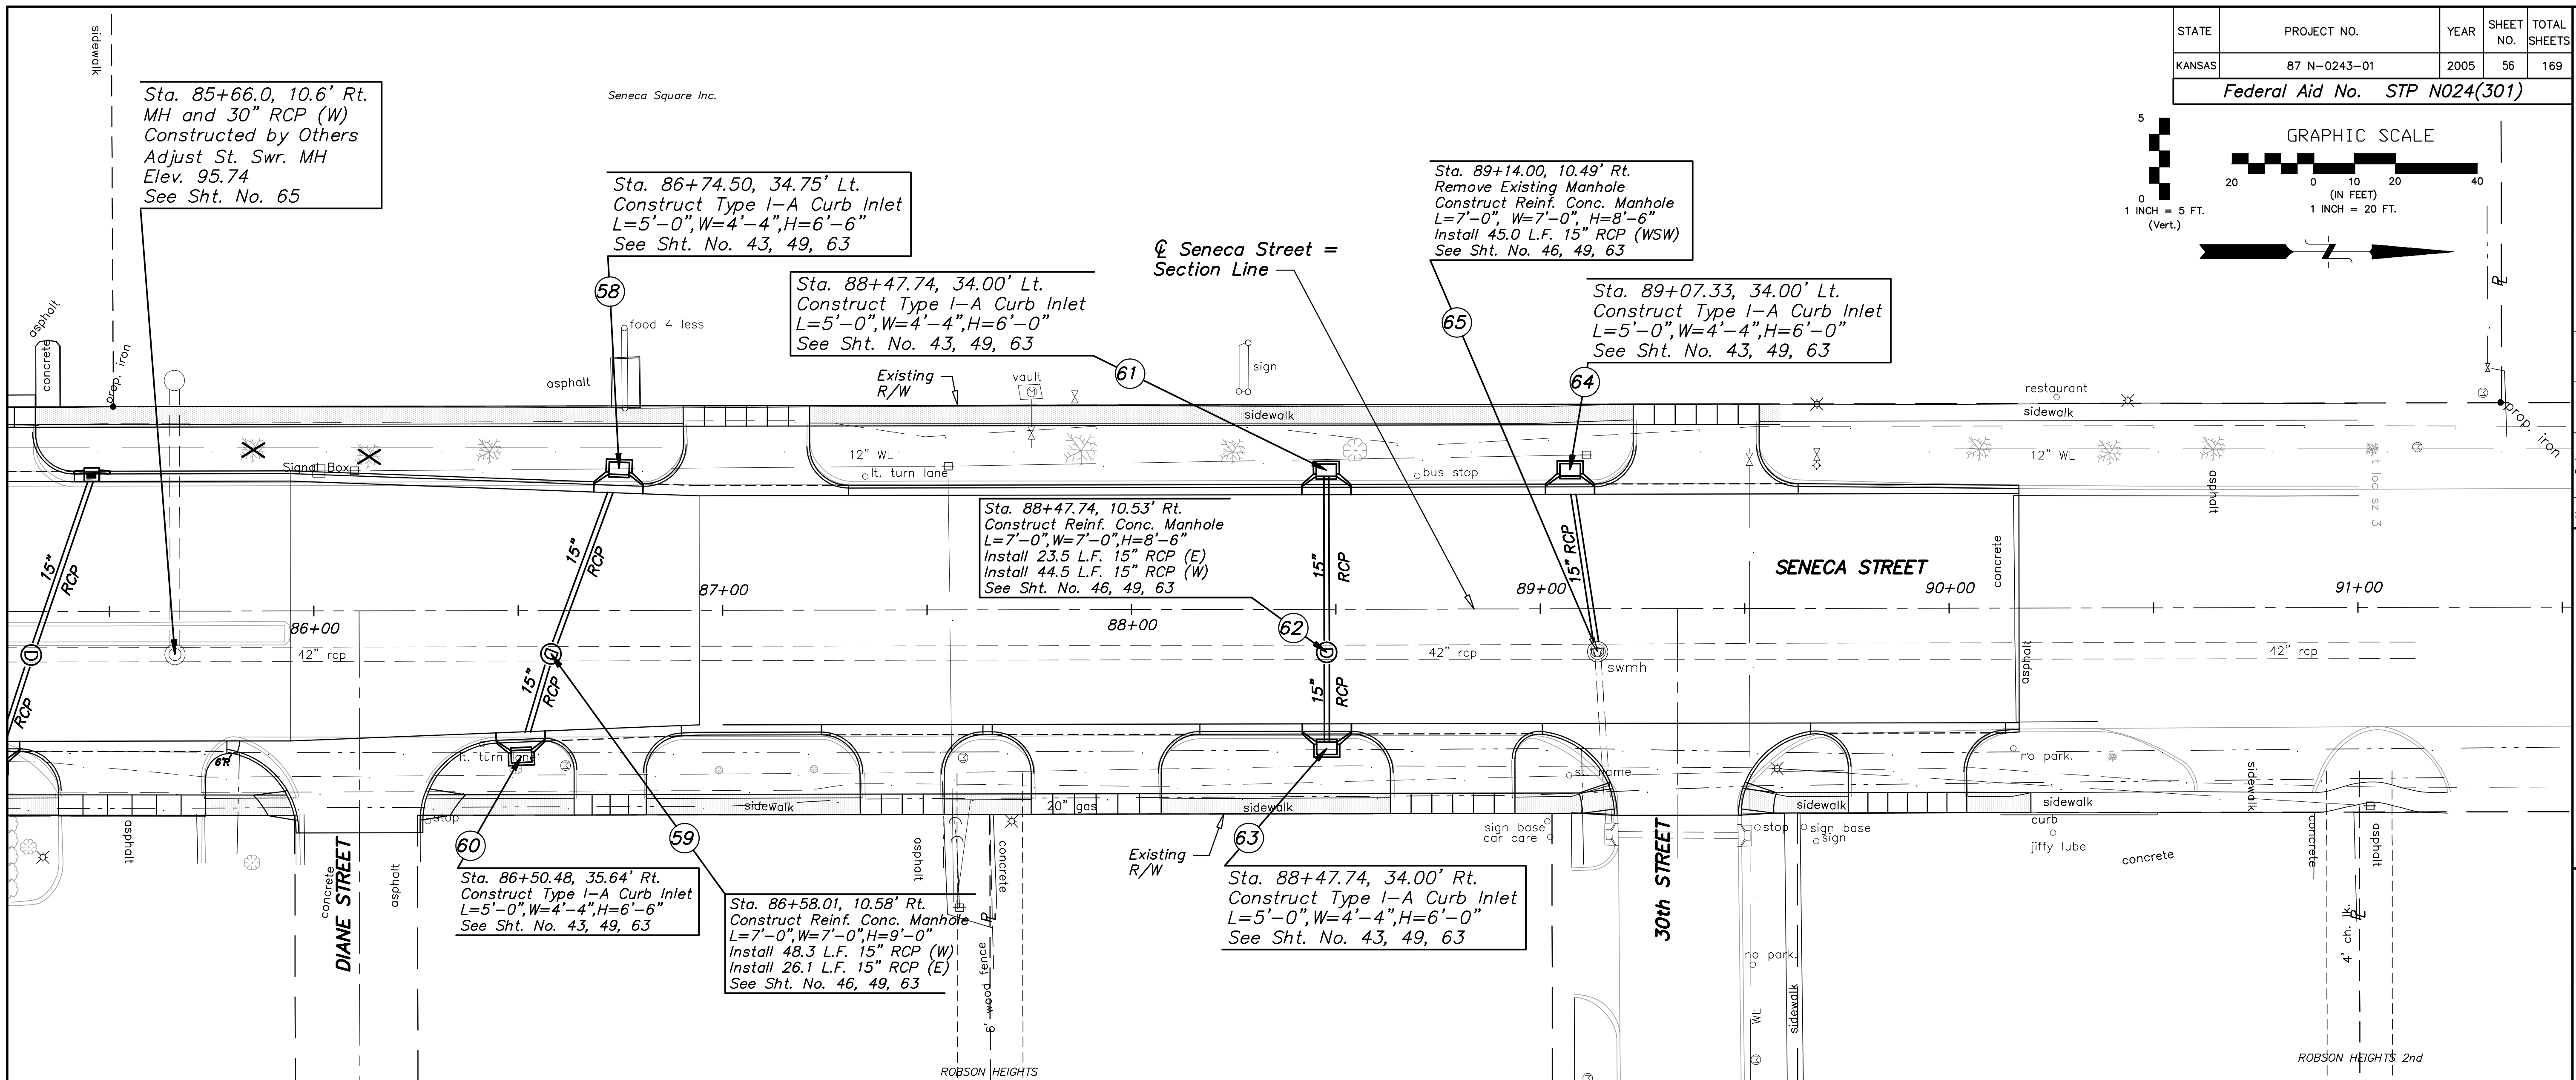


STATE	PROJECT NO.	YEAR	SHEET NO.	TOTAL SHEETS
KANSAS	87 N-0243-01	2005	56	169
Federal Aid No. STP N024(301)				

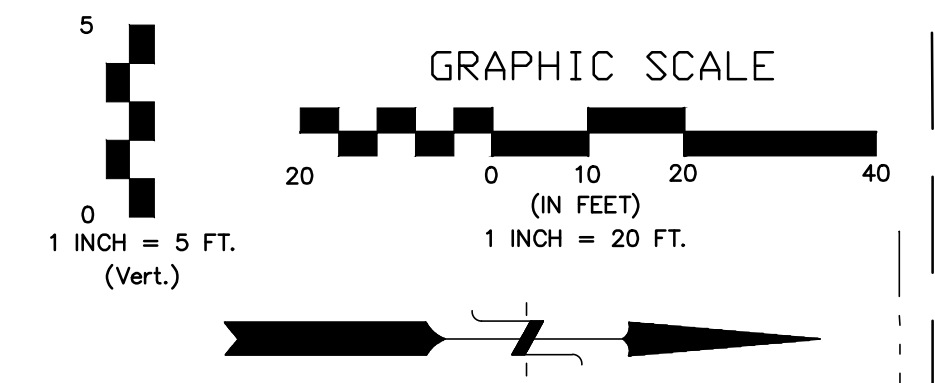

Engineer:	P. FERGUSON
Designer:	J. UNRUH
KDOT Job No.:	87 N-0243-01
Date:	JANUARY 2010

Sheet 56 of 169

POE & ASSOCIATES, INC.
CONSULTING ENGINEERS
5940 E. Central, Suite 200 Wichita, KS
67208-4242
Phone: 316/685-4114 FAX: 316/685-4444

SENeca STREET
1-235 TO 31ST STREET
CITY OF WICHITA, KANSAS
STORM SEWER PLAN AND PROFILE
STA. 85+50 TO 90+00 (SENeca STREET)