
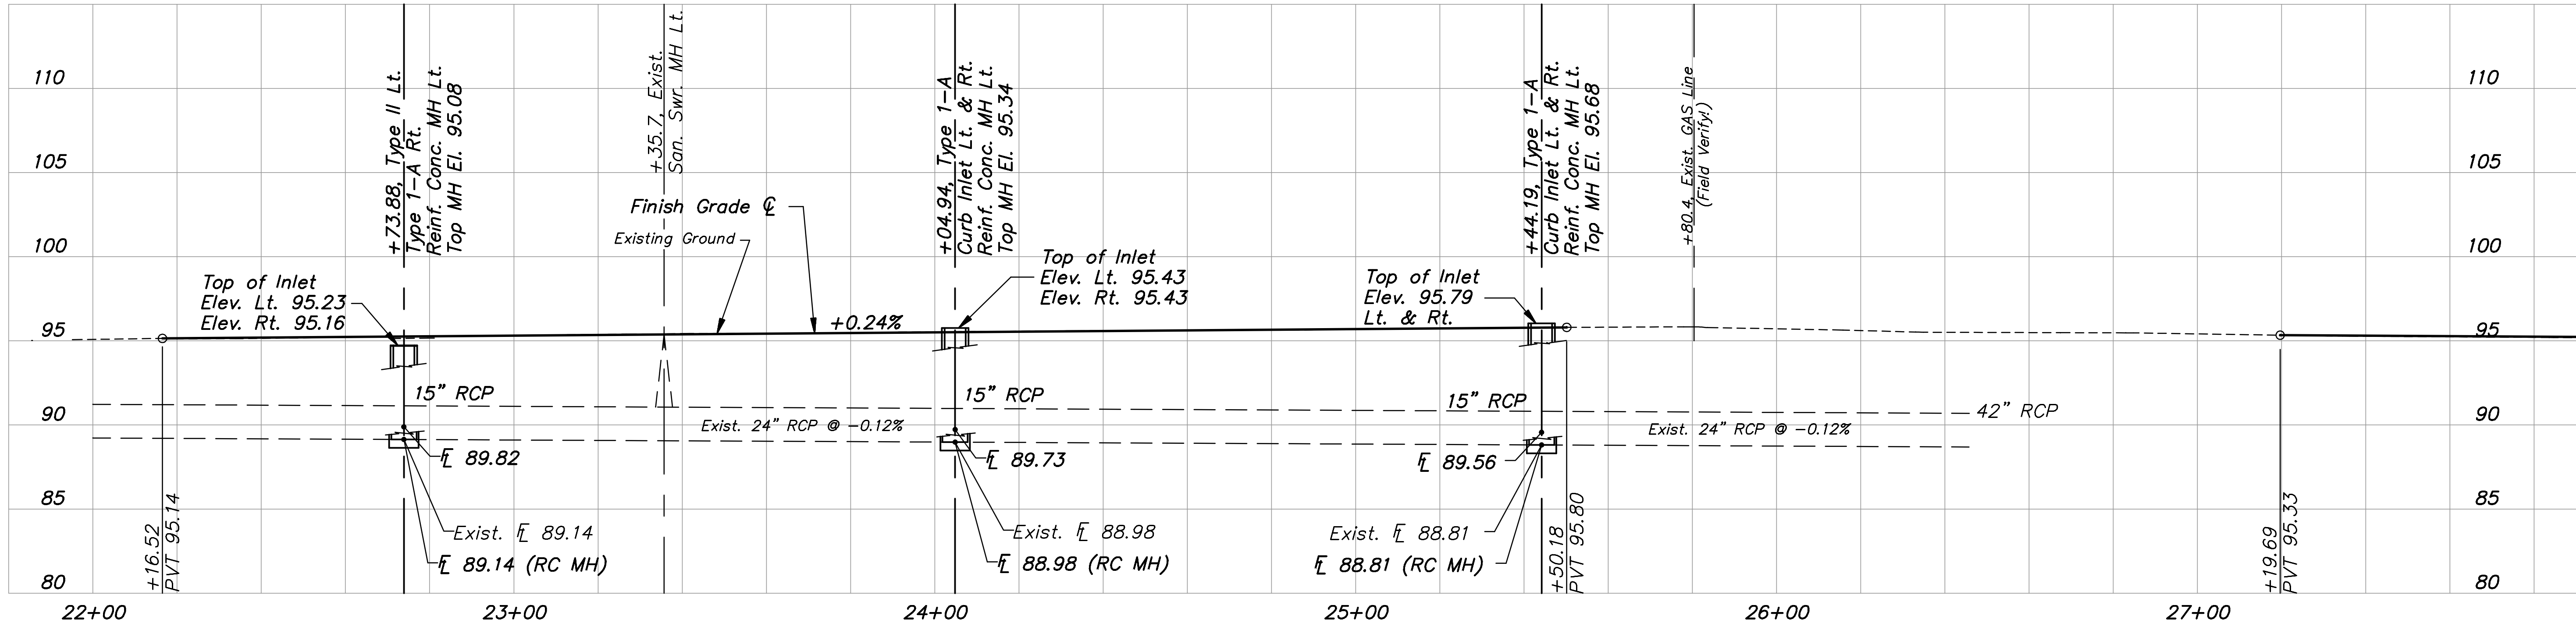
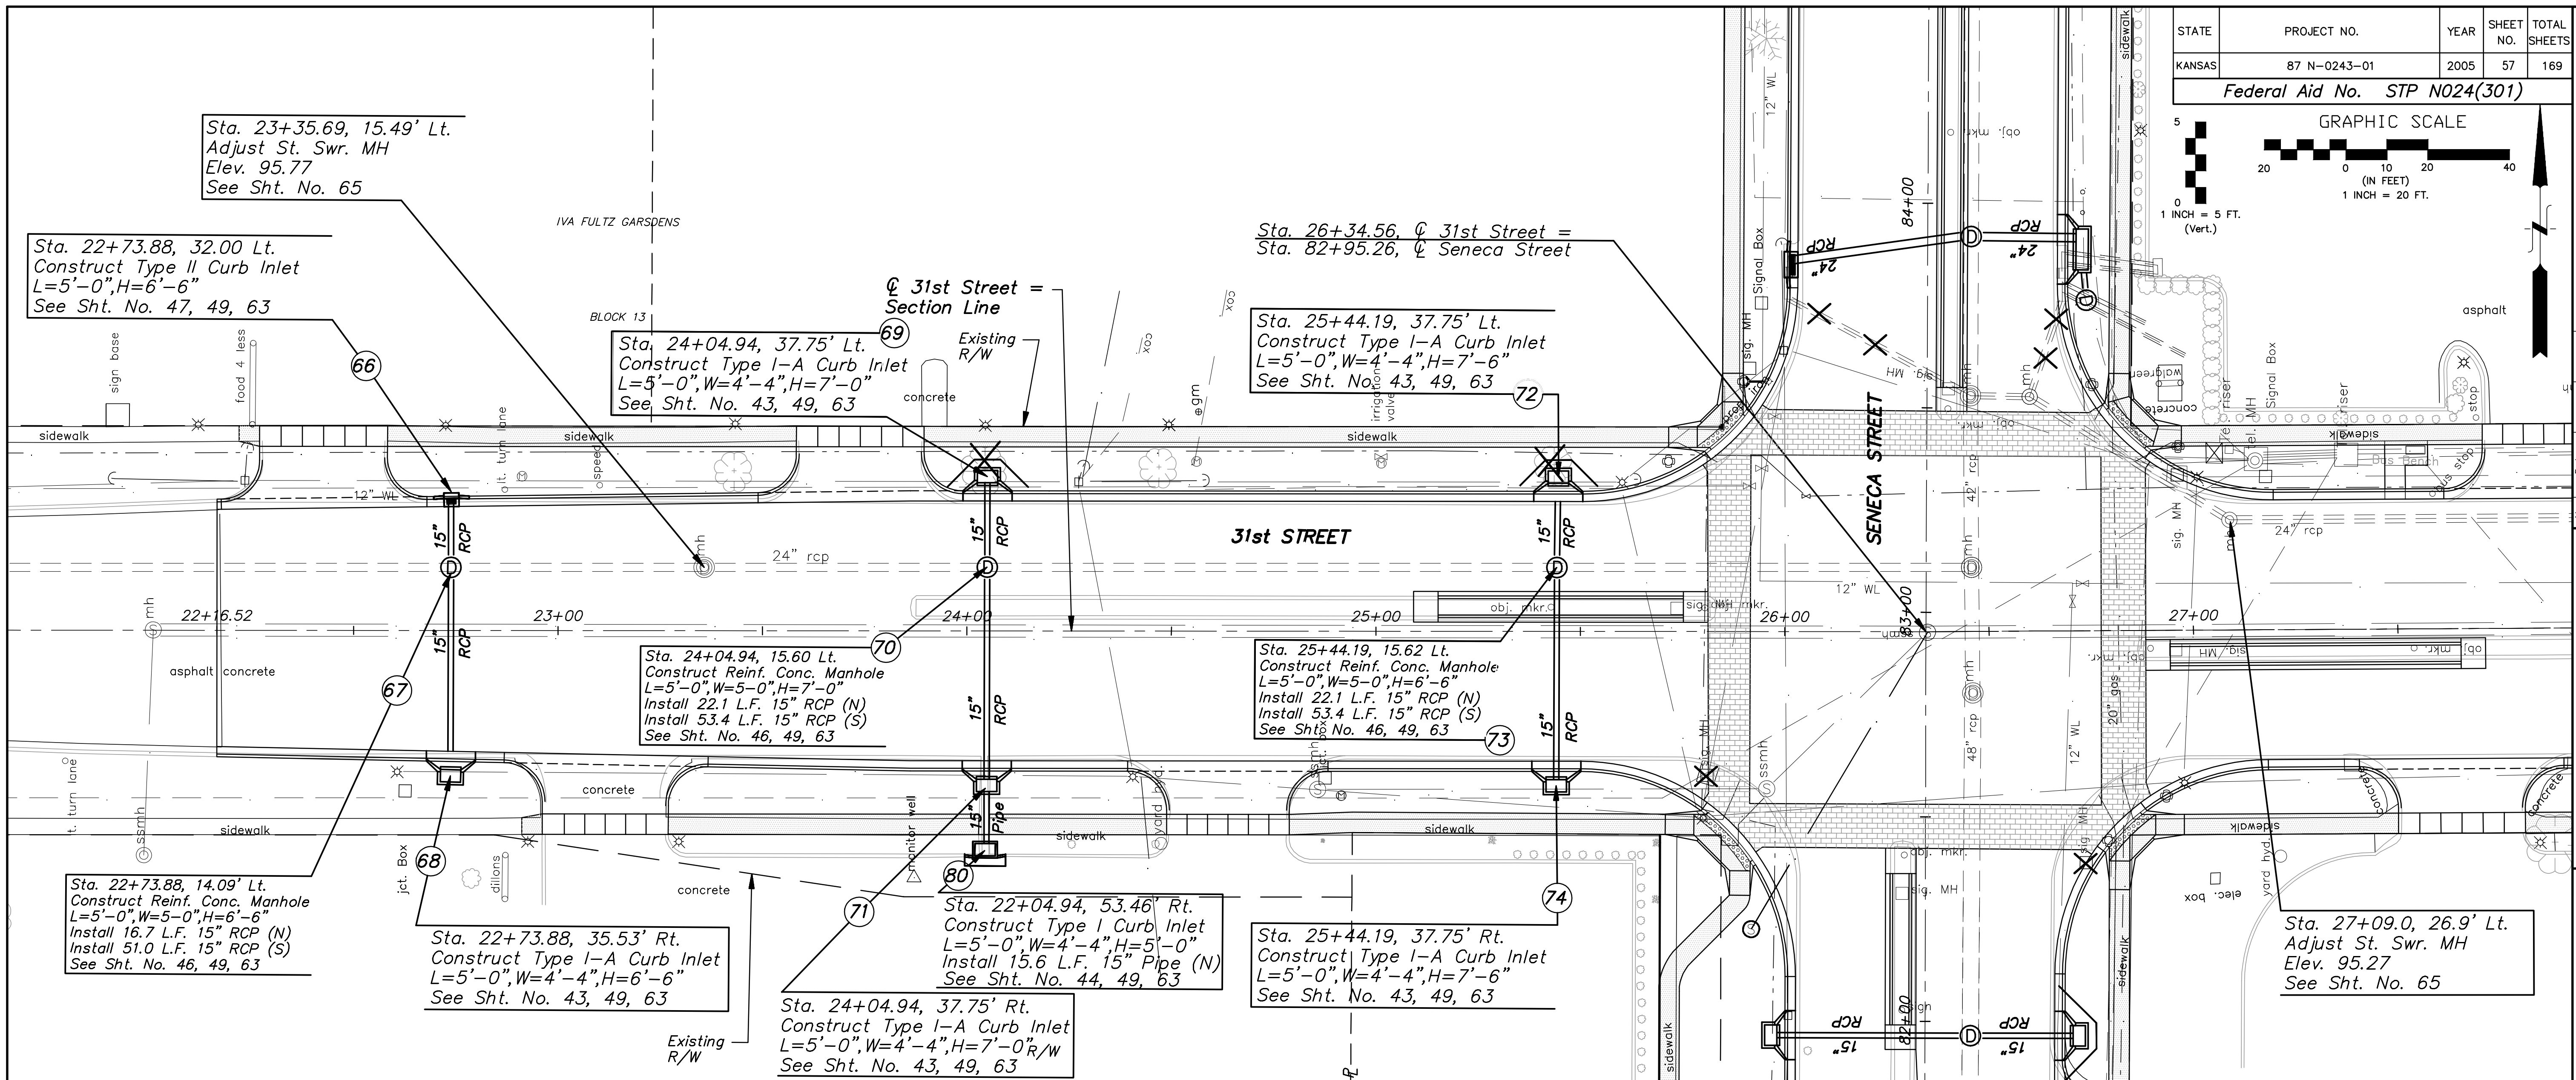


STATE	PROJECT NO.	YEAR	SHEET NO.	TOTAL SHEETS
KANSAS	87 N-0243-01	2005	57	169

Federal Aid No. STP N024(301)

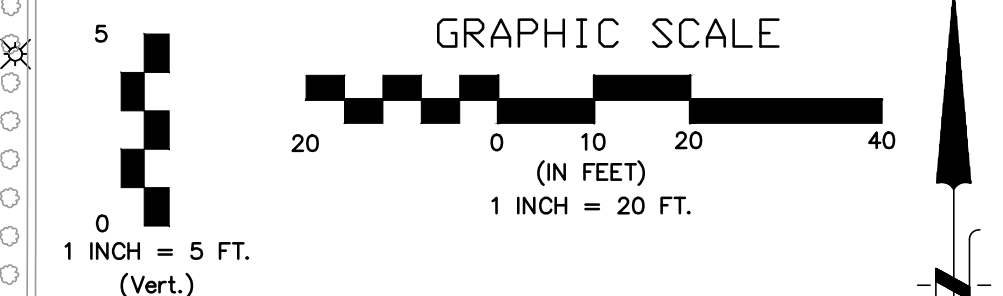

SENECA STREET
 1-235 TO 31ST STREET
 CITY OF WICHITA, KANSAS
 STORM SEWER PLAN AND PROFILE
 STA. 22+00 TO 26+00 (31ST STREET SOUTH)

POE & ASSOCIATES, INC.
 CONSULTING ENGINEERS
 5940 E. Central, Suite 200 Wichita, KS
 67208-4242
 Phone 316/685-4114 FAX 316/685-4444

WICHITA
 Engineer: P. FERGUSON
 Designer: J. UNRUH
 KDOT Job No.: 87 N-0243-01 Poe Job No.: 1794
 Date: JANUARY 2010

Sheet
 57 of 169