
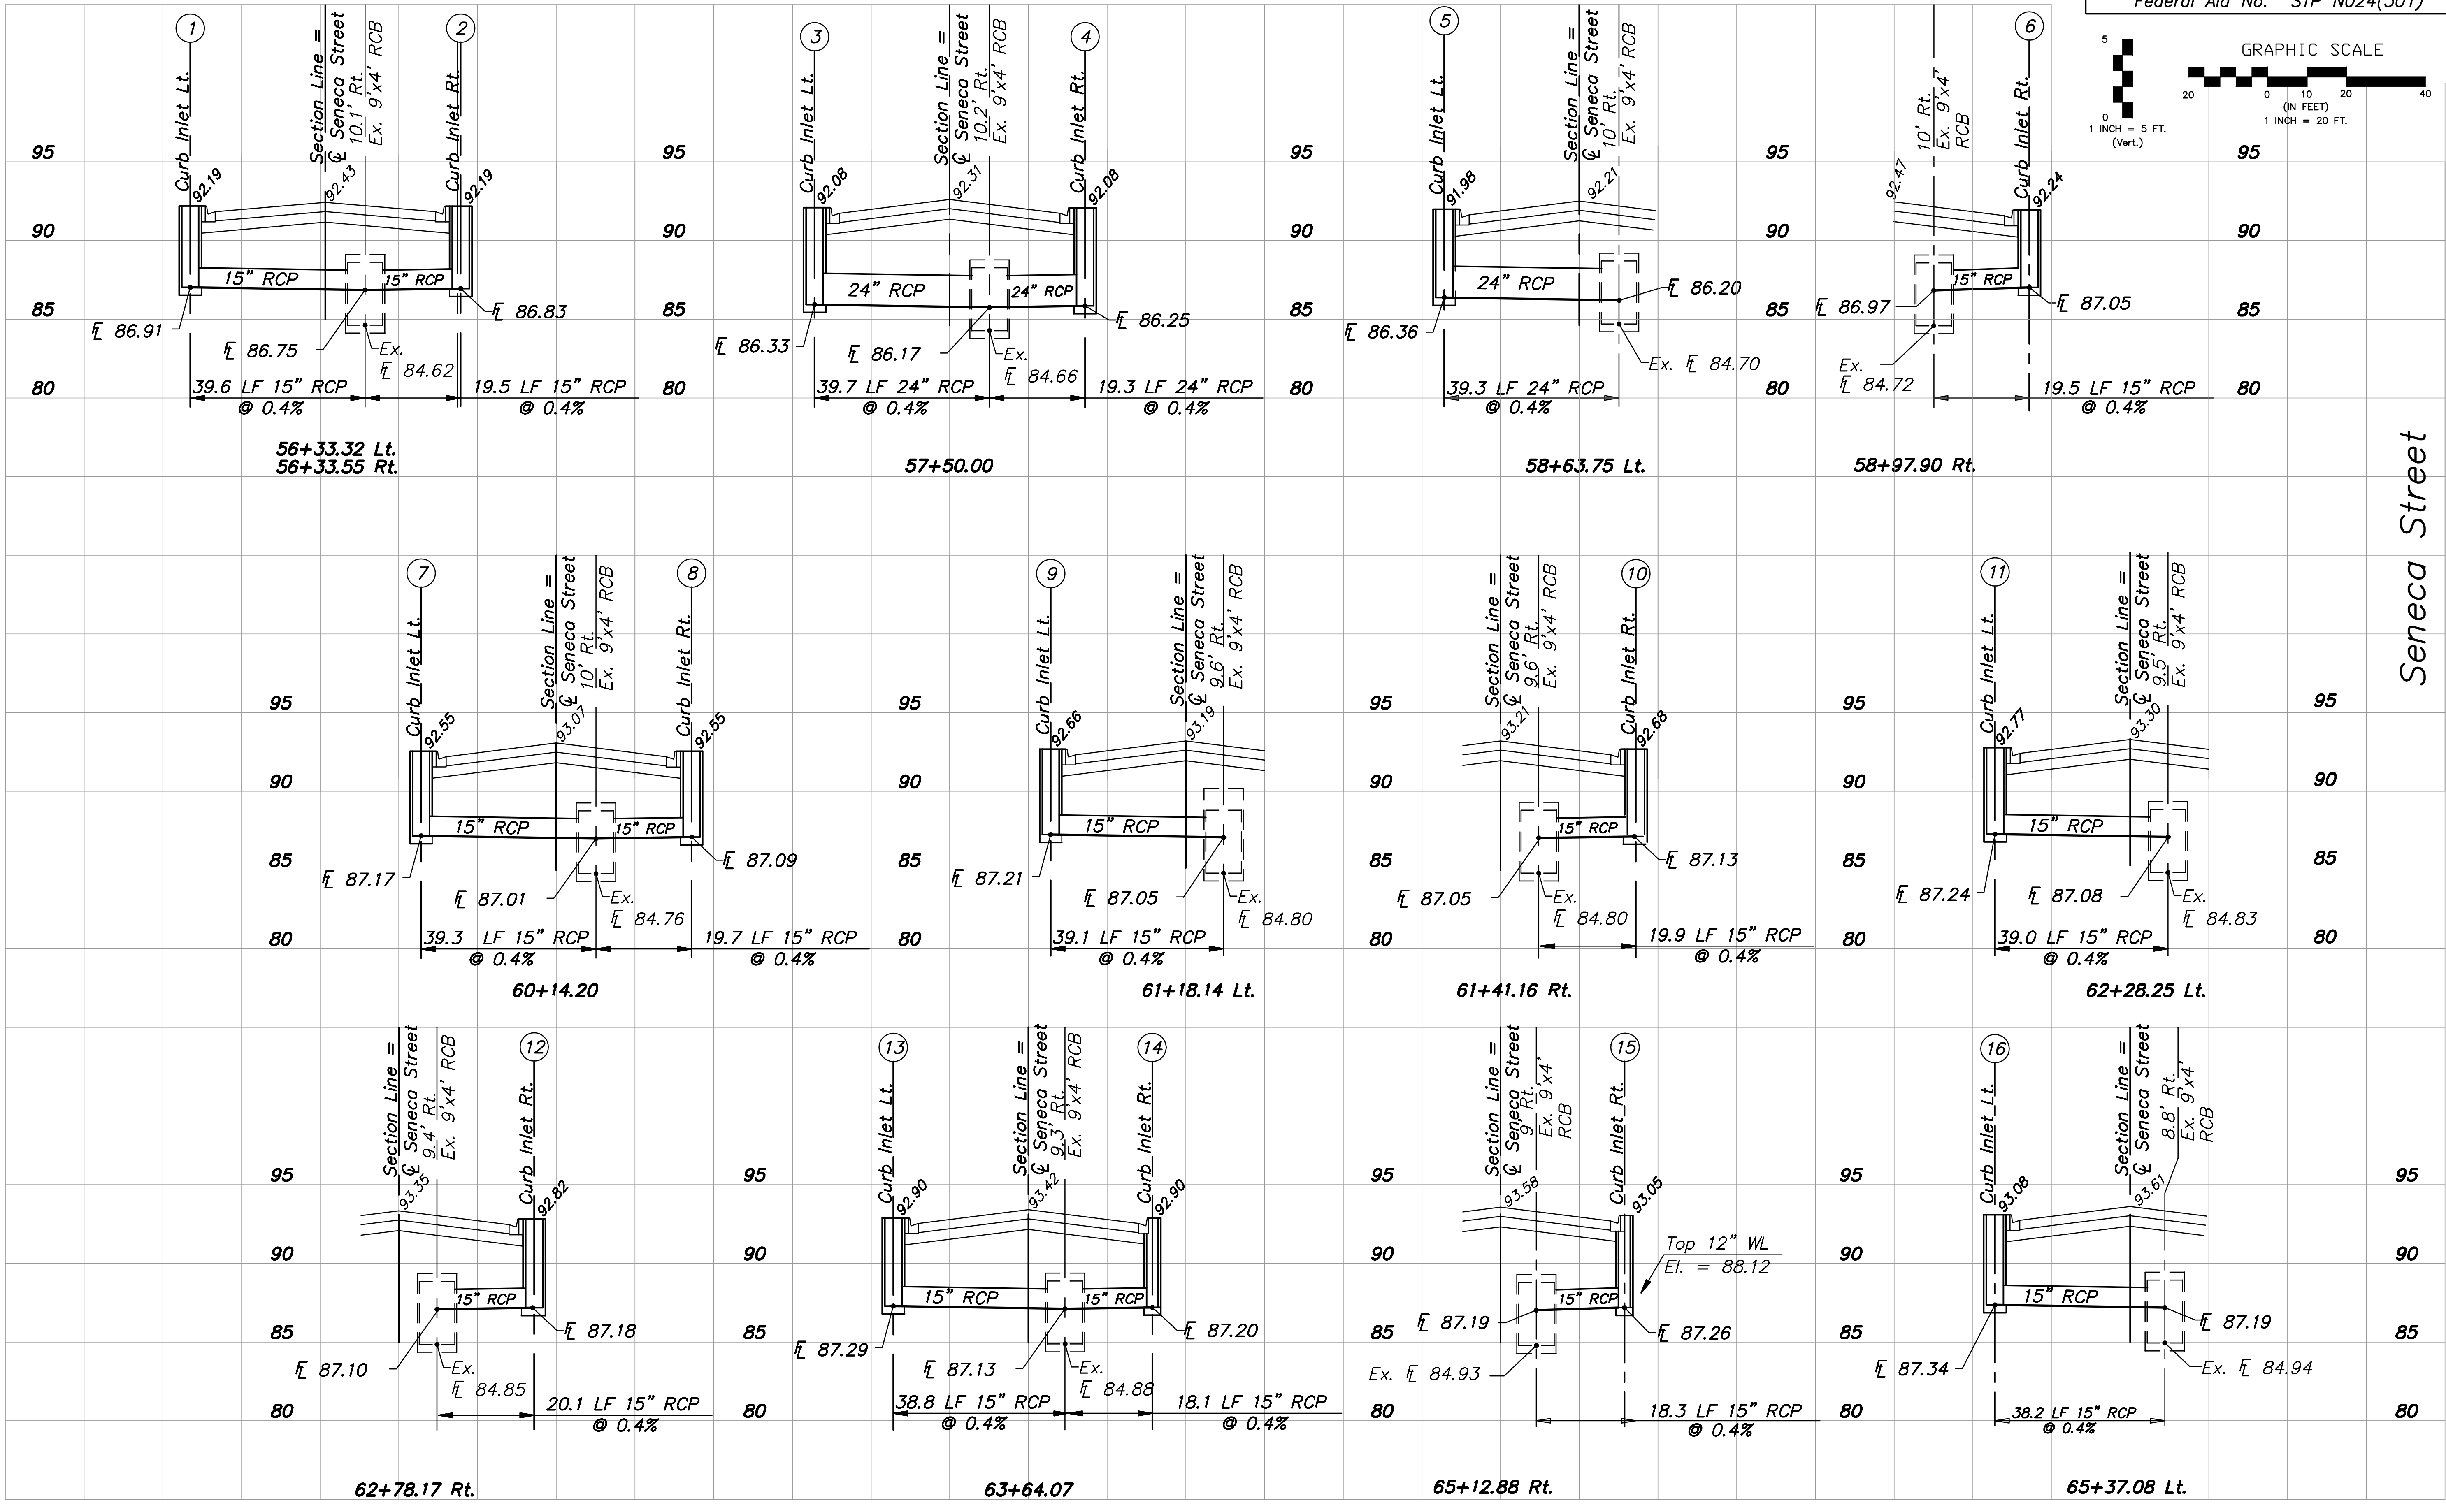


STATE	PROJECT NO.	YEAR	SHEET NO.	TOTAL SHEETS
KANSAS	87 N-0243-01	2005	59	169
Federal Aid No. STP N024(301)				

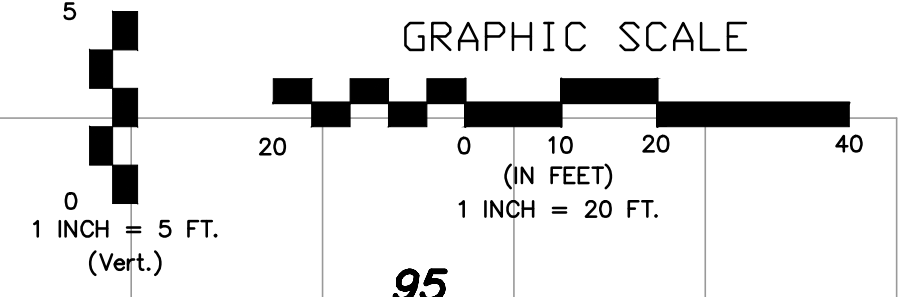

Seneca Street

SENeca STREET 1-235 TO 31ST STREET CITY OF WICHITA, KANSAS STORM SEWER PLAN AND PROFILE CROSS ROAD PROFILES	POE & ASSOCIATES, INC. CONSULTING ENGINEERS 5940 E. Central, Suite 200 □ Wichita, KS 67208-4242 Phone: 316/685-4114 □ FAX: 316/685-4444		WICHITA P. FERGUSON Designer: J. UNRUH KDOT Job No.: 87 N-0243-01 Poe Job No.: 1794 Date: JANUARY 2010 Sheet 59 of 169
--	--	--	---